


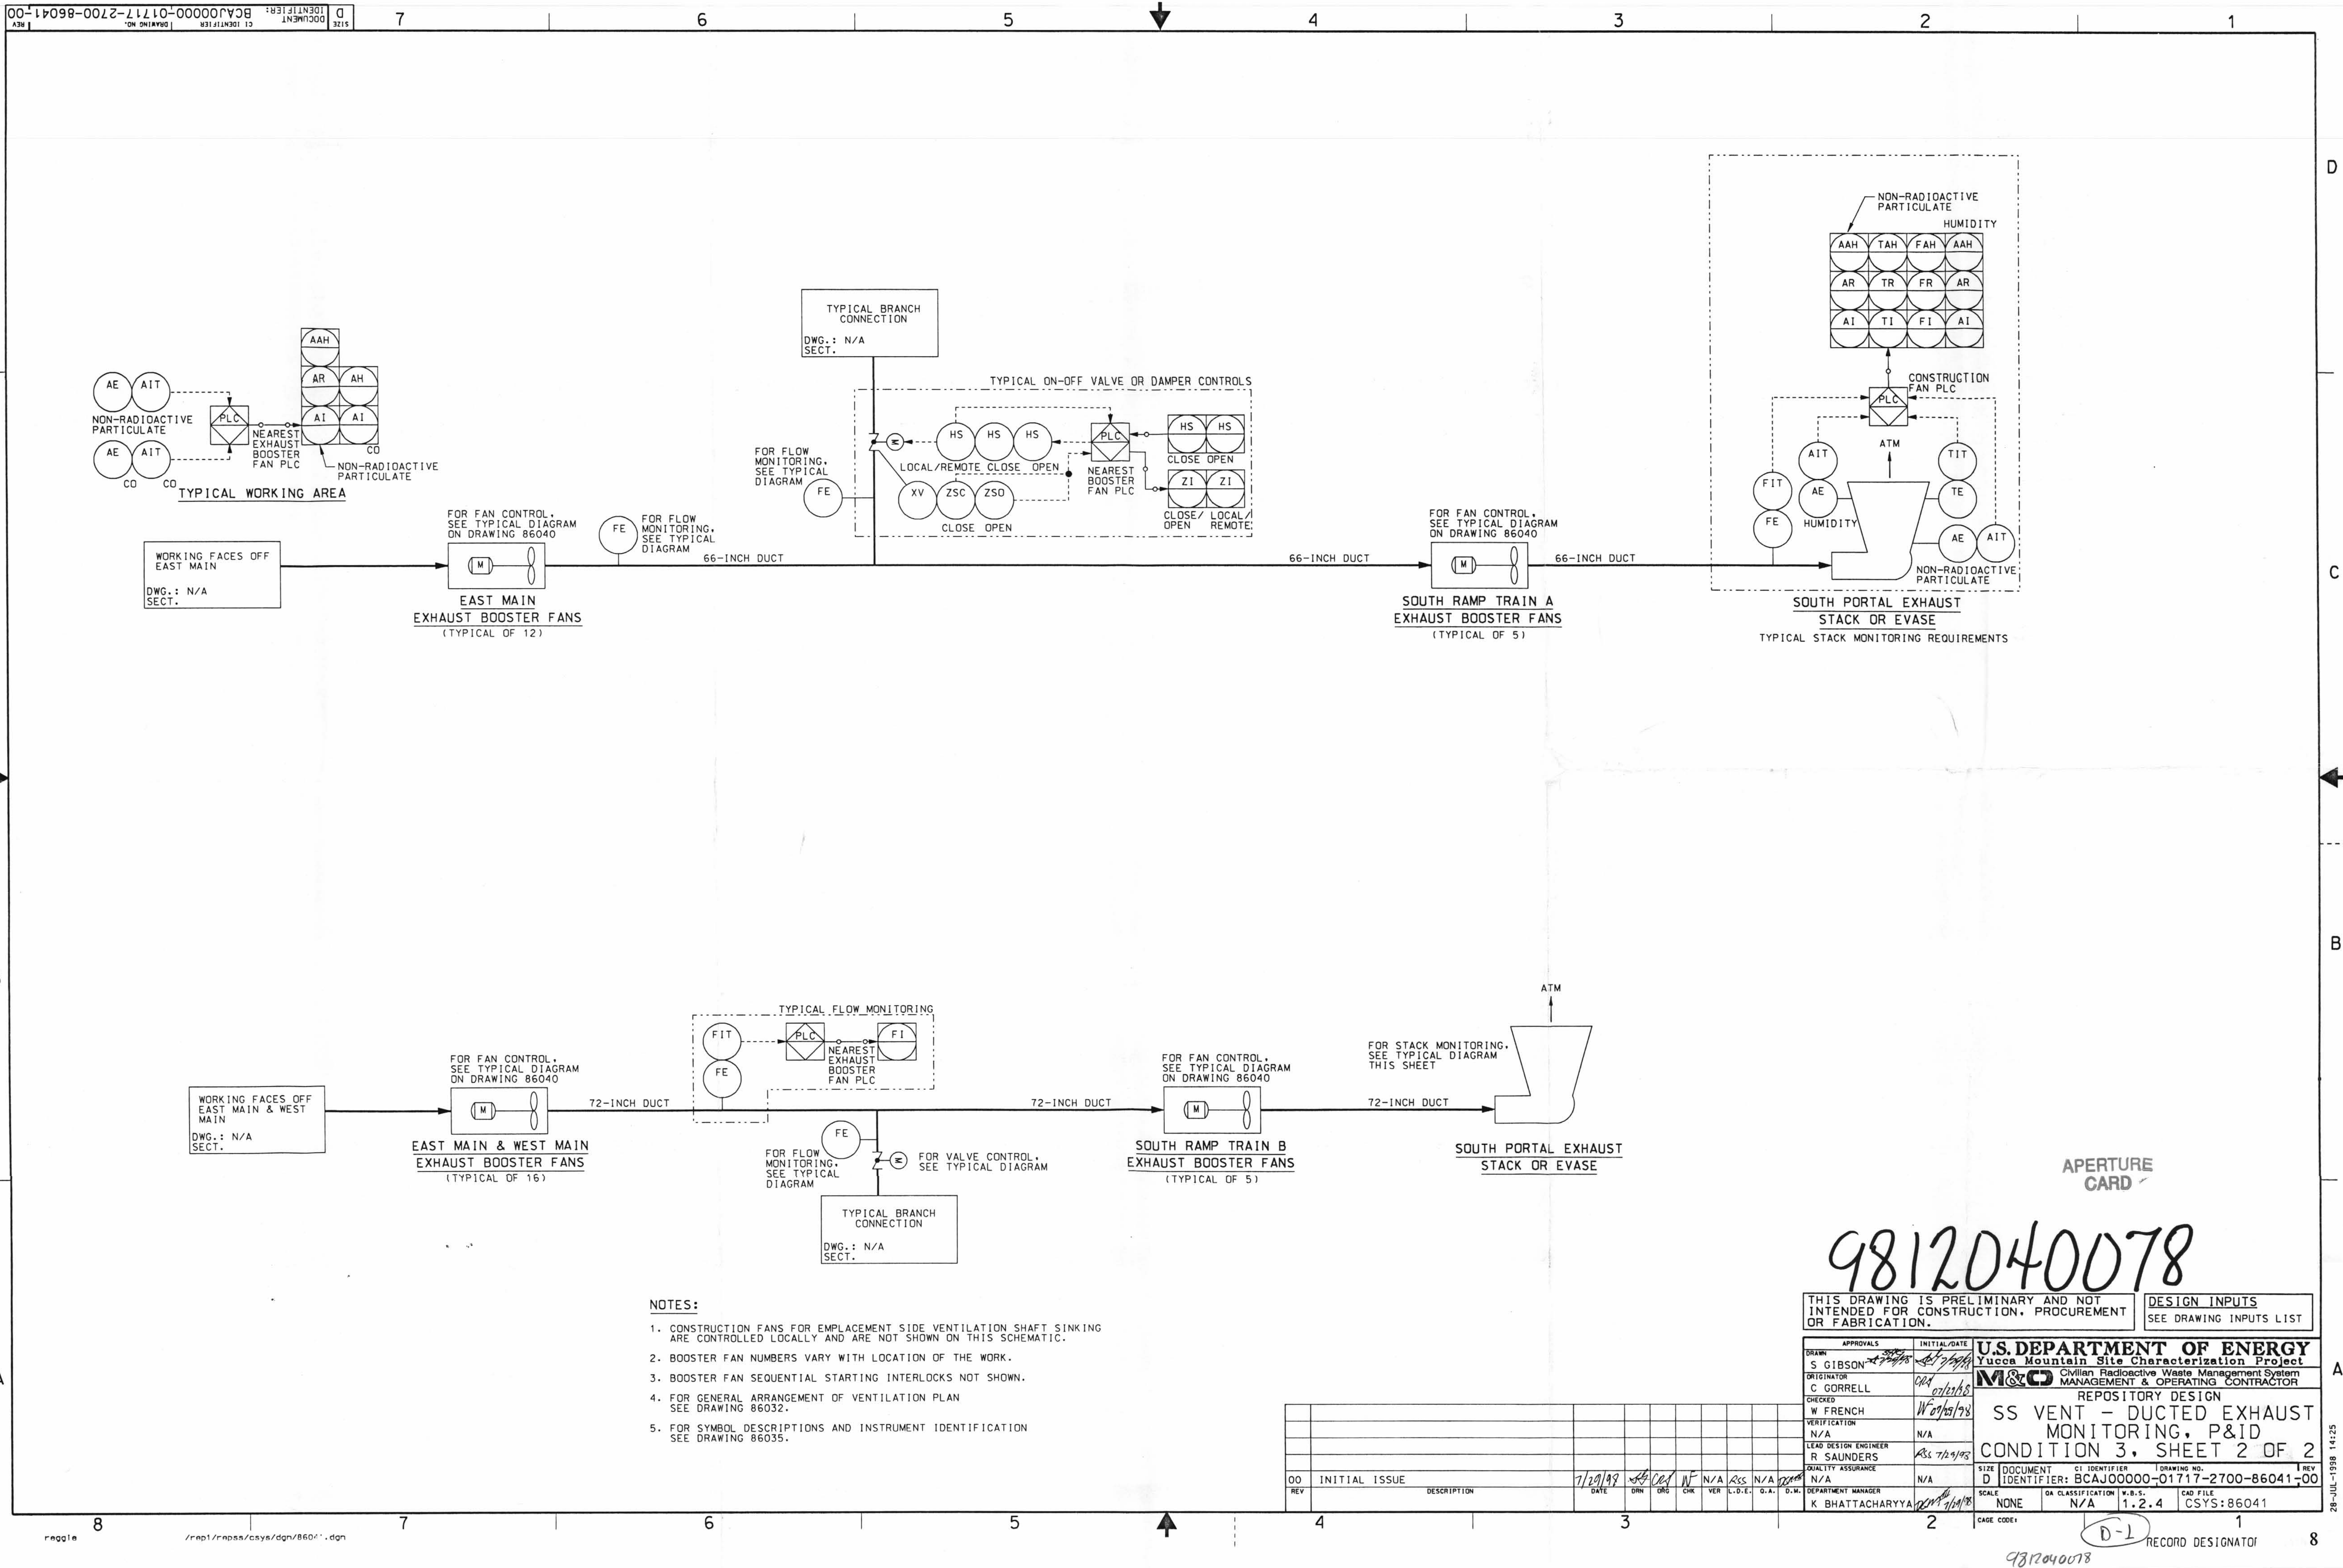

NOTES:

1. CONSTRUCTION FANS FOR EMPLACEMENT SIDE VENTILATION SHAFT SINKING ARE CONTROLLED LOCALLY AND ARE NOT SHOWN ON THIS SCHEMATIC.
2. BOOSTER FAN NUMBERS VARY WITH LOCATION OF THE WORK.
3. BOOSTER FAN SEQUENTIAL STARTING INTERLOCKS NOT SHOWN.
4. FOR GENERAL ARRANGEMENT OF VENTILATION PLAN SEE DRAWING 86032.
5. FOR SYMBOL DESCRIPTIONS AND INSTRUMENT IDENTIFICATION SEE DRAWING 86035.

THIS DRAWING IS PRELIMINARY AND NOT INTENDED FOR CONSTRUCTION, PROCUREMENT OR FABRICATION.

DESIGN INPUTS
SEE DRAWING INPUTS LIST

APPROVALS		INITIAL/DATE
DRUM	S GIBSON	7/19/99
ORIGINATOR	C CORRELL	6/11/98
CHECKED	W FRENCH	7/29/98
VERIFICATION	N/A	
LEAD DESIGN ENGINEER	R SAUNDERS	7/29/98
QUALITY ASSURANCE	N/A	
DEPARTMENT MANAGER	K BHATTACHARYA	7/29/98

U.S. DEPARTMENT OF ENERGY				
Yucca Mountain Site Characterization Project				
M&O Civilian Radioactive Waste Management System				
MANAGEMENT & OPERATING CONTRACTOR				
REPOSITORY DESIGN				
SS VENT - DUCTED EXHAUST				
MONITORING, P&ID				
CONDITION 3, SHEET 2 OF 2				
SIZE	DOCUMENT	CI IDENTIFIER	DRAWING NO.	REV
D	IDENTIFIER: BCAJ00000-01717-2700-86041-00			
SCALE	NONE	DA CLASSIFICATION	W-B-12	CAD FILE
				CSYS:86041
CASE CODE	D-1	RECORD DESIGNATOR		