


INFO. NOTE:
(REMOVE AT NEXT UPDATE)
REVISION CHANGE IN THE CLOUDED
AREA WAS FOR COLORIZING THE
LINE CLASS CODES

LEGEND

- ASME SECTION XI CLASS 1 PIPING (RED)
- ASME SECTION XI CLASS 2 PIPING (BLUE)
- ASME SECTION XI CLASS 3 PIPING (GREEN)
- - - REFERENCE & CONTINUITY
- D - D - HVAC DUCT

- ISIM2- REFERENCE TO THE PIPING ISOMETRIC DRAWING FOR DETAILS ON THE PIPING CONFIGURATION, AND THE LOCATION AND IDENTIFICATION OF WELDS AND SUPPORTS.
- RESERVED FOR SPECIAL ISI REQUIREMENTS. (MAY BE) ACCOMPANIED BY SPECIFIC NOTES.
- REFERENCE TO THE ISI ITEM NUMBER DESIGNATION USED IN THE FIRST 10 YEAR INSERVICE INSPECTION INTERVAL.
- ASME SECTION XI CLASS CHANGE
- ISI PROGRAM BOUNDARY

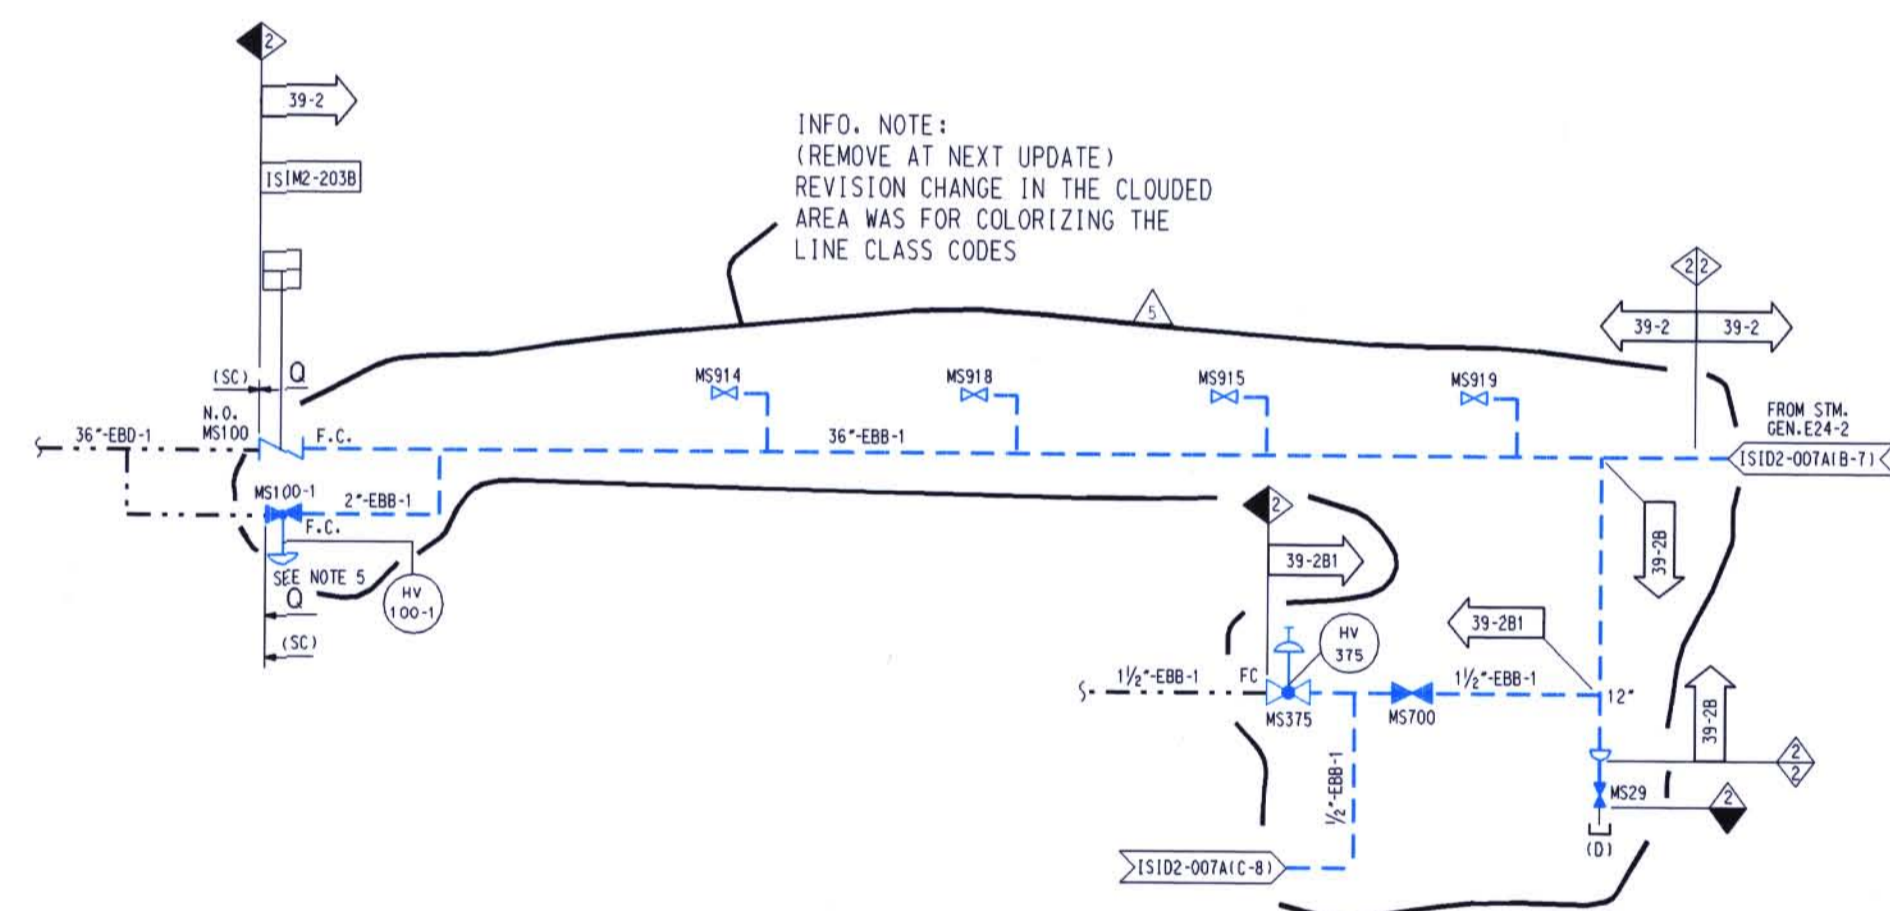

INFO. NOTE:
(REMOVE AT NEXT UPDATE)
REVISION CHANGE IN THE CLOUDED
AREA WAS FOR COLORIZING THE
LINE CLASS CODES

- NOTES:**
1. DELETED
 2. FOR ISI BOUNDARY DIAGRAM INDEX SHEET AND GENERAL NOTES, SEE ISID2-001.
 3. FOR PIPING SYMBOLS AND P & ID INDEX, SEE DRAWING M-001.
 4. UNLESS OTHERWISE NOTED, ALL VENT CONNECTIONS ARE 3/4\"/>

D-002

5	1	INC. DCN ISID2-003A-6 PER DCR 00-1766	SBW		
4	1	INC. DCN'S ISID2-003A-4 AND 5 PER MDD 92-0008 SUP. 00		INITIALS ON FILE	
3	1	INC. DCN ISID2-003A-3 FOR DCR 94-0030		INITIALS ON FILE	
2	1	INC. DCN ISID2-003A-2 FOR DCR 93-0068		INITIALS ON FILE	
1	1	INC. DCN ISID2-003A-1 FOR DCR 91-0011		INITIALS ON FILE	
0	1	ISSUED FOR SECOND 10 YEAR ISI PROGRAM	CB	MTF JBG	JDE MGP ECC
NO.	DATE	REVISIONS	BY	CHK'D	ENGR. SUPV. INSP. MGR.
SCALE N. T. S.			DESIGNED	DRWEN	CB
DAVIS-BESSE NUCLEAR POWER STATION UNIT NO. 1					
THE TOLEDO EDISON COMPANY					
INSERVICE INSPECTION DIAGRAM MAIN STEAM AND REHEAT SYSTEM SHEET 1					
DRAWING NO.			REV.		
ISID2-003A			5		