


LEGEND

- ASME SECTION XI CLASS 1 PIPING (RED)
- - - ASME SECTION XI CLASS 2 PIPING (BLUE)
- · · ASME SECTION XI CLASS 3 PIPING (GREEN)
- - - REFERENCE & CONTINUITY
- D - D - HVAC DUCT

- [SIM2] REFERENCE TO THE PIPING ISOMETRIC DRAWING FOR DETAILS ON THE PIPING CONFIGURATION, AND THE LOCATION AND IDENTIFICATION OF WELDS AND SUPPORTS.
- [] RESERVED FOR SPECIAL ISI REQUIREMENTS. (MAY BE ACCOMPANIED BY SPECIFIC NOTES.)
- [] REFERENCE TO THE ISI ITEM NUMBER DESIGNATION USED IN THE FIRST 10 YEAR INSERVICE INSPECTION INTERVAL.
- [] ASME SECTION XI CLASS CHANGE
- [] ISI PROGRAM BOUNDARY

NOTES:

1. DELETED
2. FOR ISI BOUNDARY DIAGRAM INDEX SHEET AND GENERAL NOTES. SEE IS102-001.
3. FOR PIPING SYMBOLS AND P & ID INDEX. SEE DRAWING M-001.
4. UNLESS OTHERWISE NOTED, ALL VENT CONNECTIONS ARE 1/4" AND DRAIN CONNECTIONS ARE 1/2". LINE IDENTIFICATION IS THE SAME AS THE HEADER.
5. WHERE NOTED THE TANK CAPACITY IS NOMINAL, WHERE APPLICABLE. SEE DB-PF-06705 (TANK LEVEL CALIBRATION CURVES) FOR INDICATED LEVEL VS. VOLUME RELATIONSHIP. (REF. PCADR 96-0976).

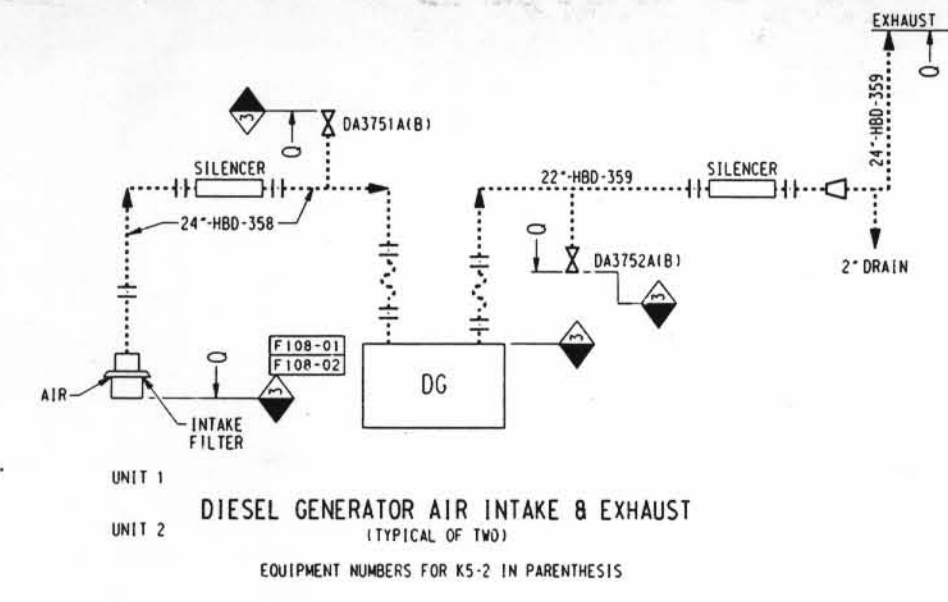

1	INC. DCN IS102-017B-17 PER DCR 99-0001, IS102-017B-20 PER ERR 60-0003-046, DCN IS102-017B-21 PER ERR 60-0003-047 AND DCN IS102-017B-22 PER DCR 00-1766	INITIALS ON FILE
2	INC. DCN IS102-017B-12 & 15 PER FFR 87-128-901 & IS102-017B-16 PER RFA 94-0108	INITIALS ON FILE
3	INC. DCN IS102-017B-13 & 14 FOR FFR 93-1228-901	INITIALS ON FILE
4	INC. DCN'S IS102-017B-10 FOR RFA 93-0472 AND IS102-017B-11 FOR RFA 93-0452	INITIALS ON FILE
5	INC. DCN'S IS102-017B-3 THRU 6 FOR MFD 92-0013 SUPP. 0	INITIALS ON FILE
6	INC. DCN IS102-017B-2 FOR DCR 90-0208	INITIALS ON FILE
7	INC. DCN IS102-017B-23 PER ERR 60-0003-116 & DCN IS102-017B-24 PER ERR 60-0003-115	SBW
8	ISSUED FOR SECOND 10 YEAR ISI PROGRAM	DJR TRN BJC TMB MGP ECC

NO.	DATE	REVISIONS	BY	CHK'D	ENGR.	DRWG. MGR.	APP'D.
SCALE N.T.S.							
DESIGNED BY: CB							
DATE: _____							
DAVIS-BESSE NUCLEAR POWER STATION UNIT NO. 1 THE TEBBEN COMPANY							
INSERVICE INSPECTION DIAGRAM DIESEL GENERATORS AIR START							
DRAWING NO. IS102-017B							
REV. 8							

D-11