



INFO. NOTE:
(REMOVE AT NEXT UPDATE)
REVISION CHANGE IN THE CLOUDED
AREA WAS FOR COLORIZING THE
LINE CLASS CODES

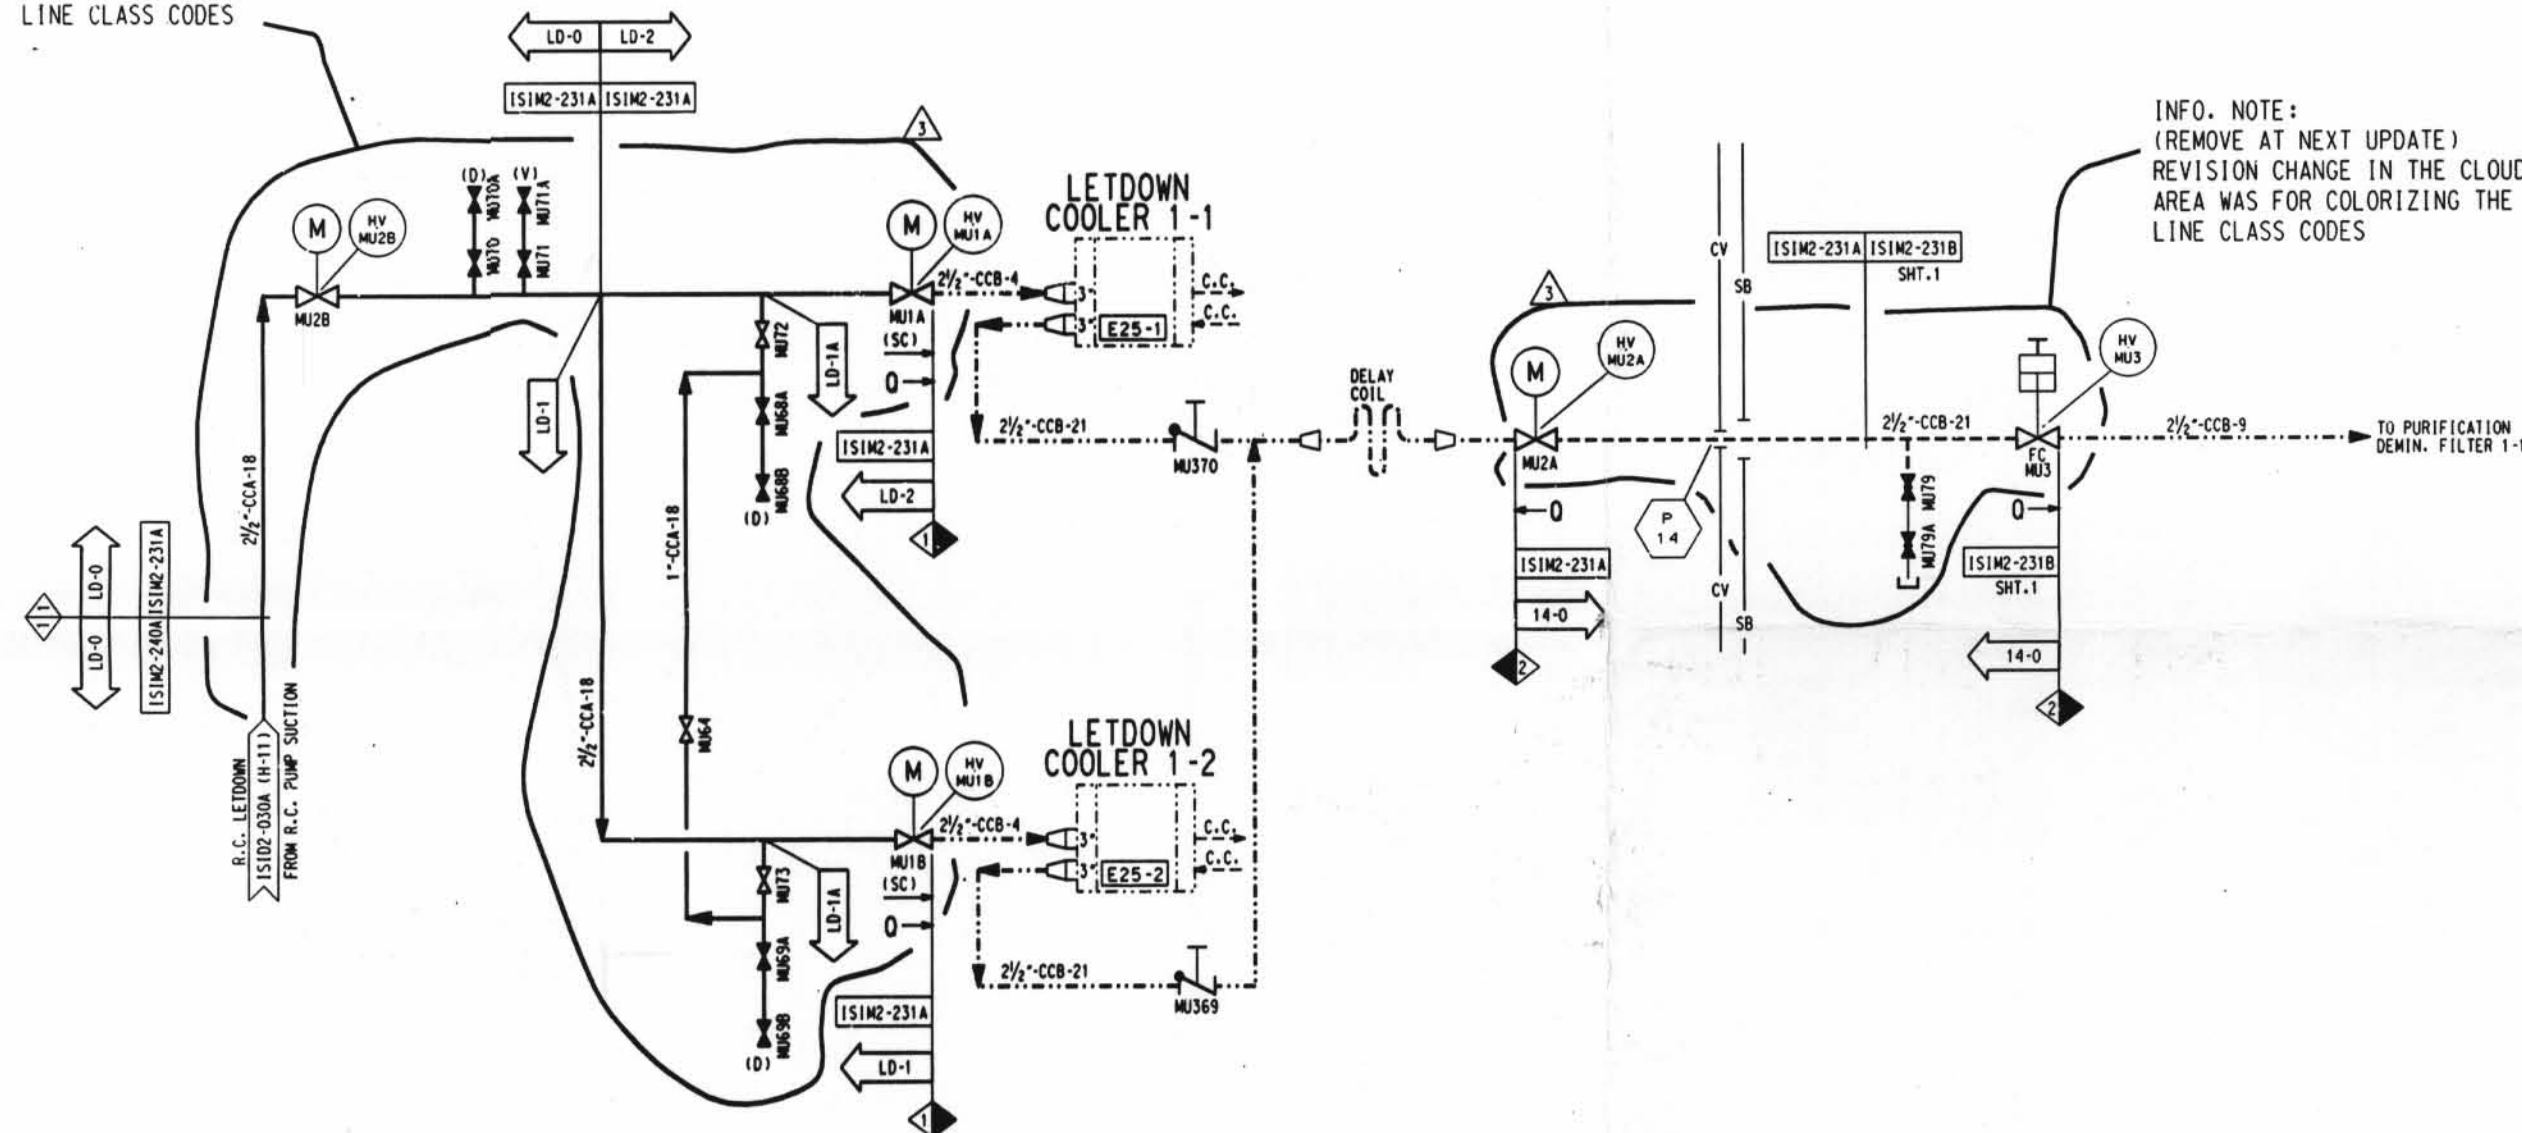

INFO. NOTE:
(REMOVE AT NEXT UPDATE)
REVISION CHANGE IN THE CLOUDED
AREA WAS FOR COLORIZING THE
LINE CLASS CODES

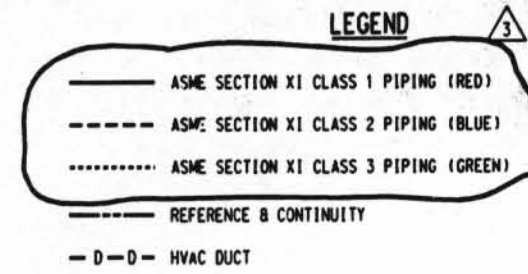

- ISIM2- REFERENCE TO THE PIPING ISOMETRIC DRAWING FOR DETAILS ON THE PIPING CONFIGURATION, AND THE LOCATION AND IDENTIFICATION OF WELDS AND SUPPORTS.
- RESERVED FOR SPECIAL ISI REQUIREMENTS. (MAY BE ACCOMPANIED BY SPECIFIC NOTES.)
- REFERENCE TO THE ISI ITEM NUMBER DESIGNATION USED IN THE FIRST 10 YEAR INSERVICE INSPECTION INTERVAL.
- ASME SECTION XI CLASS CHANGE
- ISI PROGRAM BOUNDARY

NOTES:

- DELETED
- FOR ISI BOUNDARY DIAGRAM INDEX SHEET AND GENERAL NOTES, SEE IS102-001.
- FOR PIPING SYMBOLS AND P & ID INDEX, SEE DRAWING M-001.
- UNLESS OTHERWISE NOTED, ALL VENT CONNECTIONS ARE 3/4" AND DRAIN CONNECTIONS ARE 1". LINE IDENTIFICATION IS THE SAME AS THE HEADER.

D.19

1	INC. DCN IS102-031A-3 PER DCR 00-1766	SBW	
2	INC. DCN IS102-031A-2 PER DCR 97-0187		INITIALS ON FILE
3	INC. DCN IS102-031A-1 FOR DCR 91-001		INITIALS ON FILE
4	ISSUED FOR SECOND 10 YEAR ISI PROGRAM	JJK TRN RJC	FWD MDP ECC
NO.	DATE	REVISIONS	BY
SCALE N.T.S. DESIGNED DRAWN DATE			
DAVIS-BESSE NUCLEAR POWER STATION UNIT NO. 1			
INSERVICE INSPECTION DIAGRAM			
MAKE-UP & PURIFICATION SYSTEM			
DRAWING NO.		REV.	
IS102-031A		3	