

INFO. NOTE:  
(REMOVE AT NEXT UPDATE)  
REVISION CHANGE IN THE CLOUDED  
AREA WAS FOR COLORIZING THE  
LINE CLASS CODES


LEGEND

- ASME SECTION XI CLASS 1 PIPING (RED)
- ASME SECTION XI CLASS 2 PIPING (BLUE)
- ASME SECTION XI CLASS 3 PIPING (GREEN)
- REFERENCE & CONTINUITY
- D - D - HVAC DUCT

- ISIN2- REFERENCE TO THE PIPING ISOMETRIC DRAWING FOR DETAILS ON THE PIPING CONFIGURATION, AND THE LOCATION AND IDENTIFICATION OF WELDS AND SUPPORTS.
- RESERVED FOR SPECIAL ISI REQUIREMENTS. (MAY BE ACCOMPANIED BY SPECIFIC NOTES.)
- REFERENCE TO THE ISI ITEM NUMBER DESIGNATION USED IN THE FIRST 10 YEAR INSERVICE INSPECTION INTERVAL.
- ASME SECTION XI CLASS CHANGE
- ISI PROGRAM BOUNDARY

NOTES:

- DELETED
- FOR ISI BOUNDARY DIAGRAM INDEX SHEET AND GENERAL NOTES, SEE ISID2-001.
- FOR PIPING SYMBOLS AND P & ID INDEX, SEE DRAWING M-001.
- UNLESS OTHERWISE NOTED, ALL VENT CONNECTIONS ARE 3/4" AND DRAIN CONNECTIONS ARE 1". LINE IDENTIFICATION IS THE SAME AS THE HEADER.

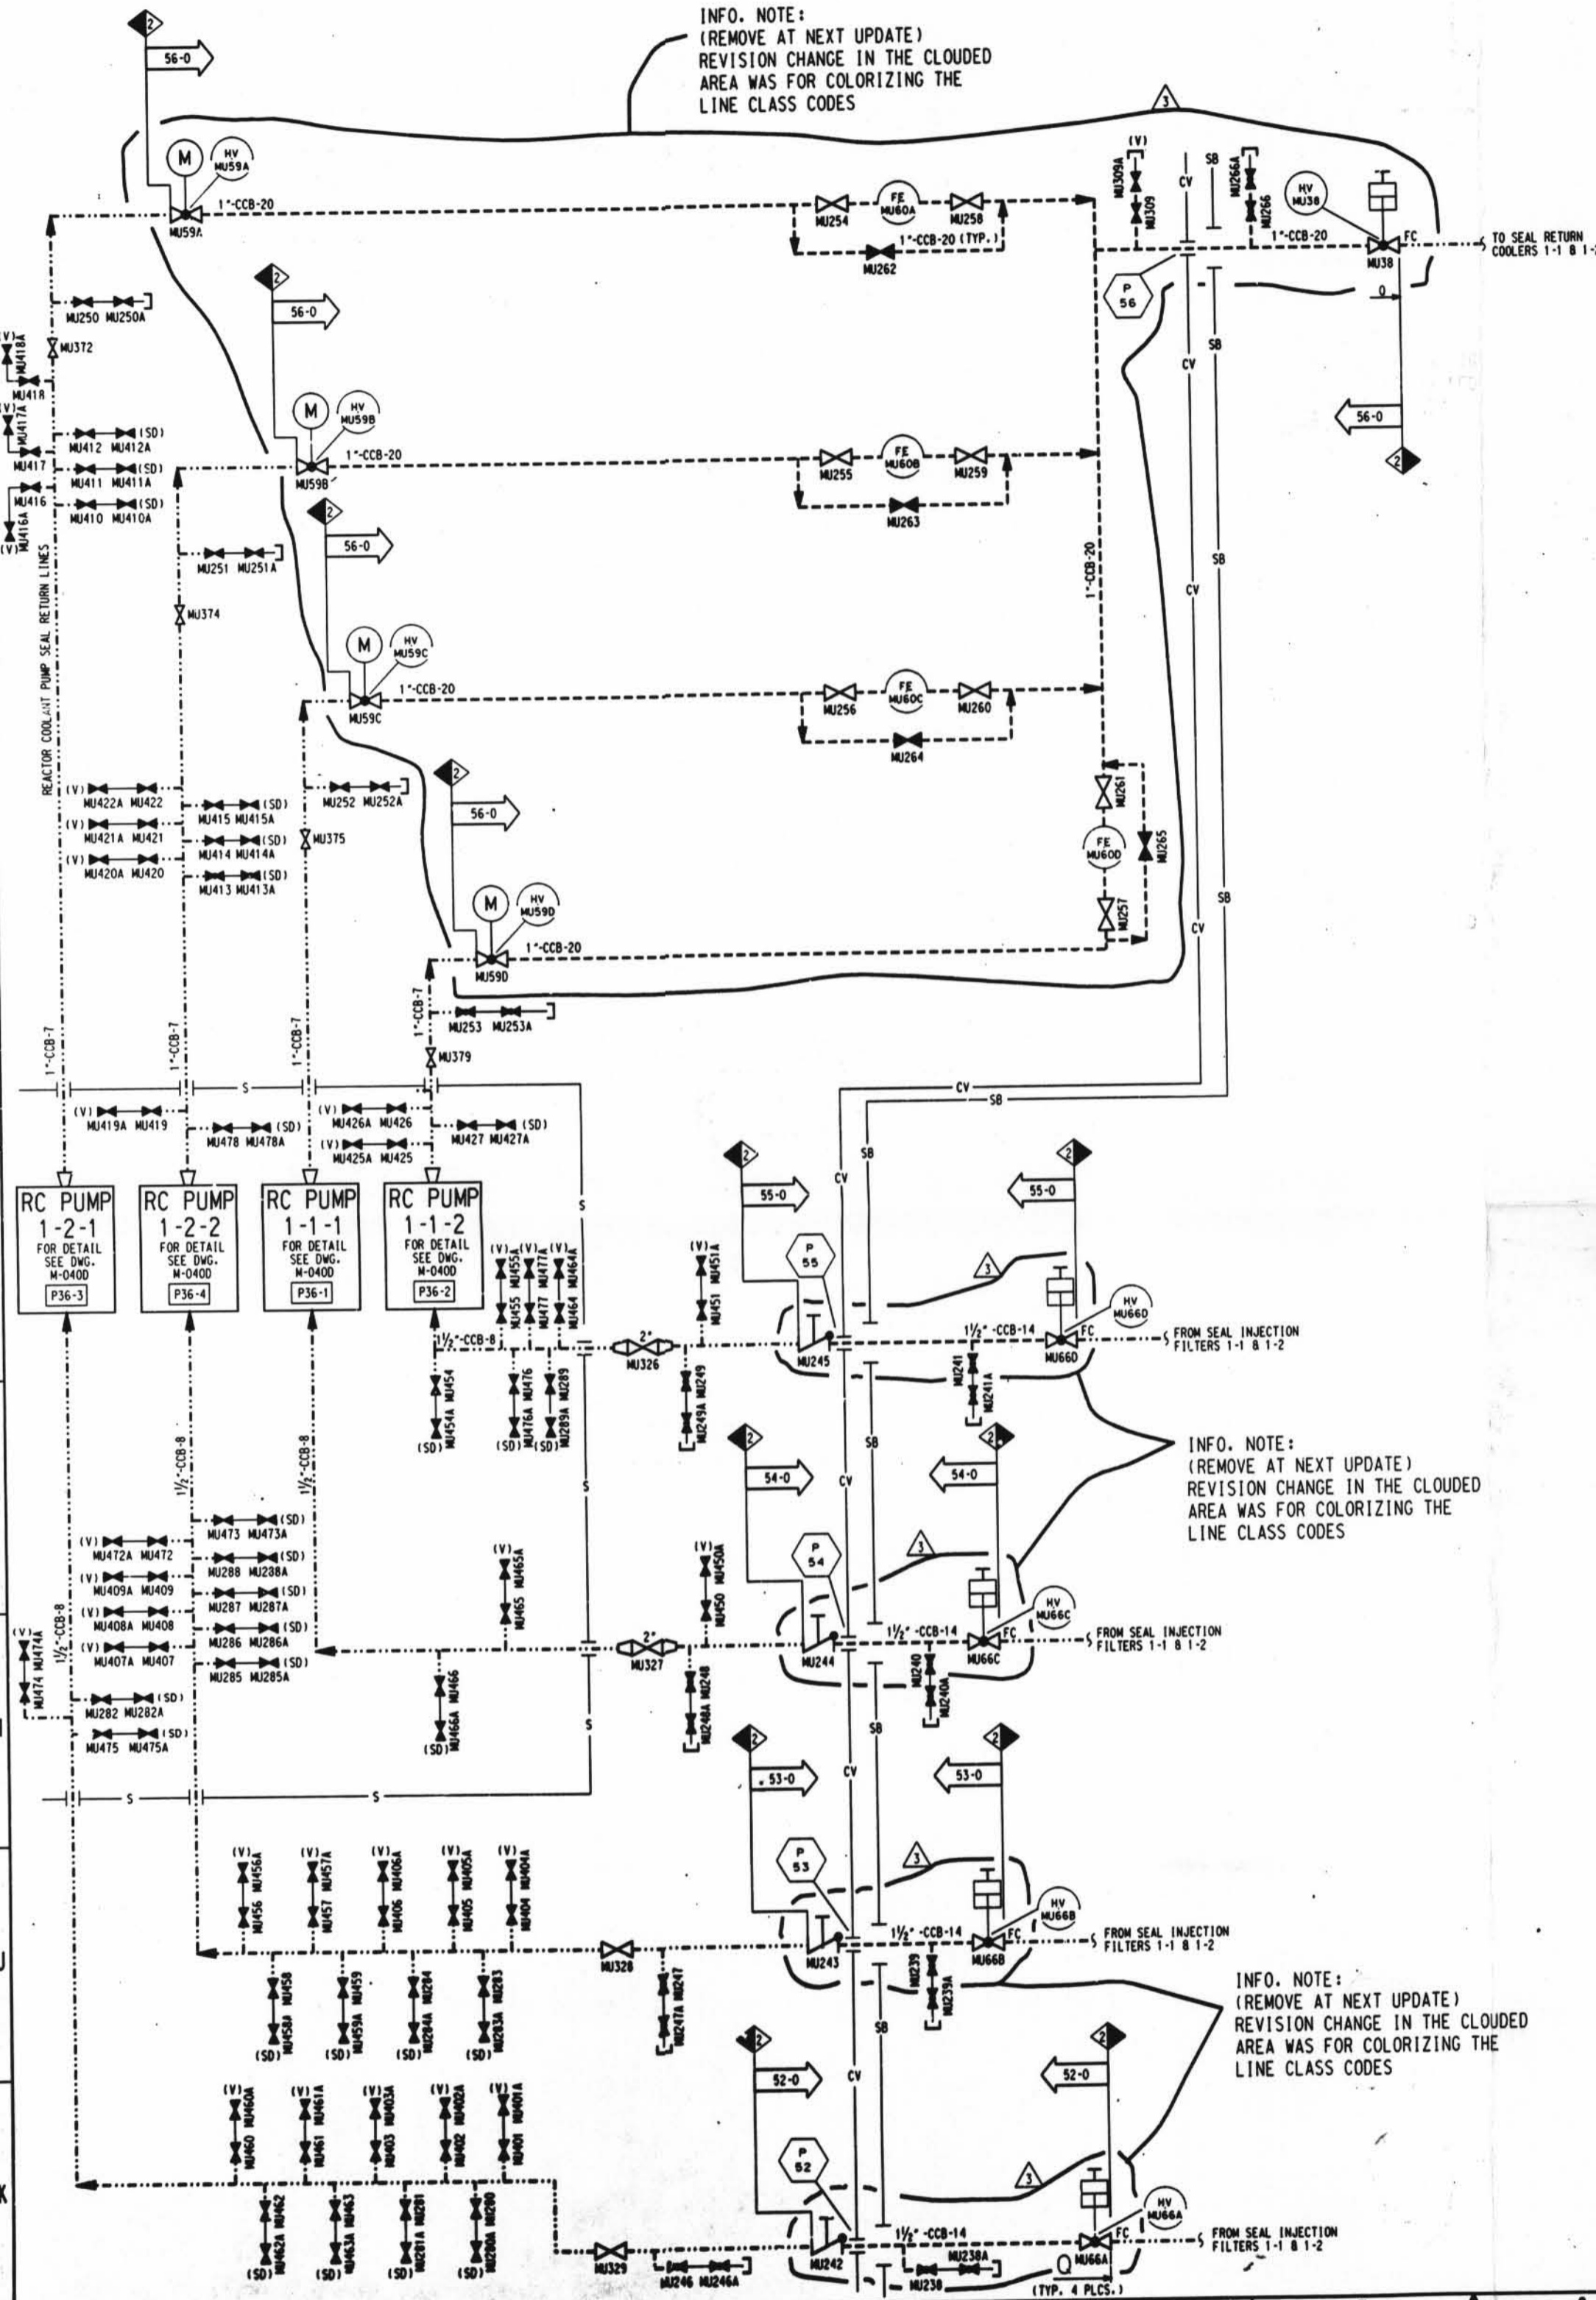

INFO. NOTE:  
(REMOVE AT NEXT UPDATE)  
REVISION CHANGE IN THE CLOUDED  
AREA WAS FOR COLORIZING THE  
LINE CLASS CODES

INFO. NOTE:  
(REMOVE AT NEXT UPDATE)  
REVISION CHANGE IN THE CLOUDED  
AREA WAS FOR COLORIZING THE  
LINE CLASS CODES

D-20

INC DCN IS102-031B-5 PER DCR 00-1766	SBW	10/1/00	14
INC DCN IS102-031B-1 PER MOD P3-0039 SUP-0			
INC DCN'S IS102-031B-2,3 & 4 FOR DCR 91-001			
ISSUED FOR SECOND 10 YEAR ISI PROGRAM			
NO. DATE	REVISIONS	BY	CHK'D
1			
2			
3			
DAVIS-BESSE NUCLEAR POWER STATION UNIT NO. 1			
INSERVICE INSPECTION DIAGRAM			
MAKE-UP & PURIFICATION SYSTEM			
DRAWING NO.		REV.	
IS102-031B		3	