


ZVI PILOT TEST AS-BUILT FOR THE NEW RIFLE SITE RIFLE, COLORADO




INDEX OF DRAWINGS

SHEET	TITLE	DRAWING NO.
1	TITLE SHEET - SITE PLAN	U01433-R00-T01-D+
2	FACILITIES SITE PLAN	U01434-R00-C01-D+
3	SHEDS PIPING PLAN	U01435-R00-M01-D+
4	DETAILS	U01436-R00-M02-D+
5	ELECTRICAL PLAN	U01437-R00-E01-D+
6	TREATMENT SHED PIPING PLAN	U01438-R00-M03-D+
7	STEEL COLUMN	U01439-R00-M04-D+

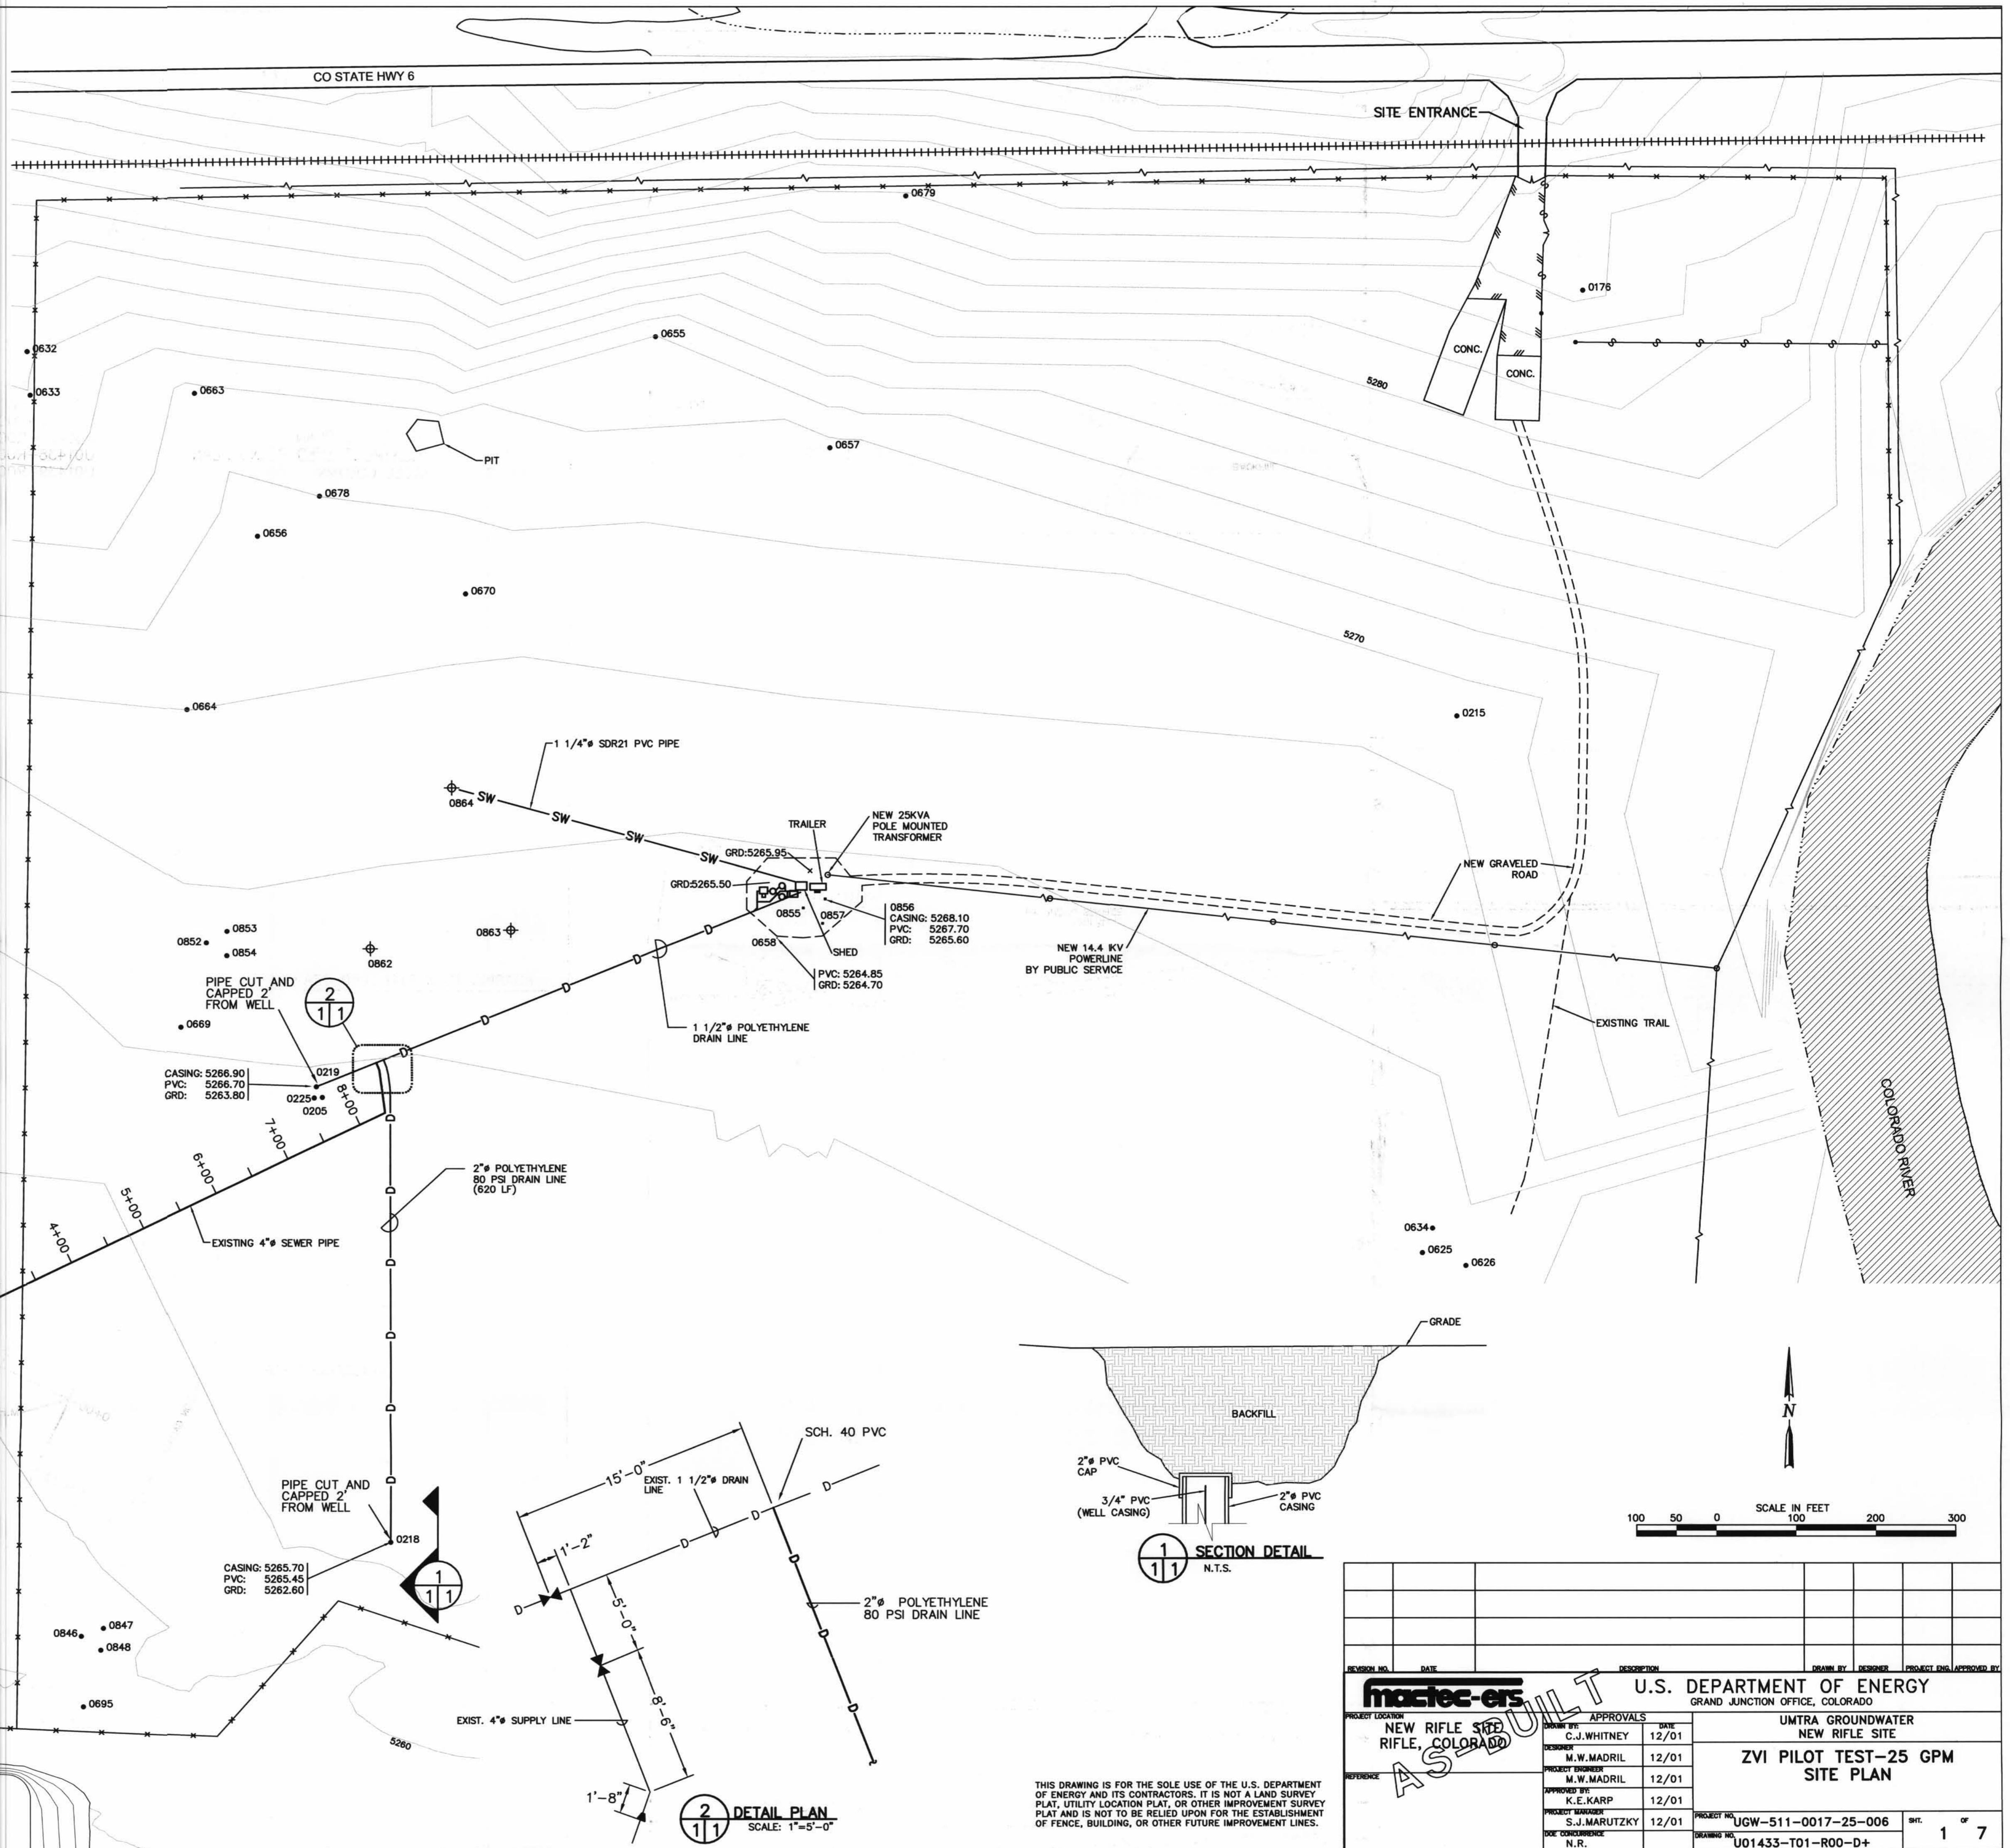

ROARING FORK STANDARD GRAVEL

~McCAULEY PIT~

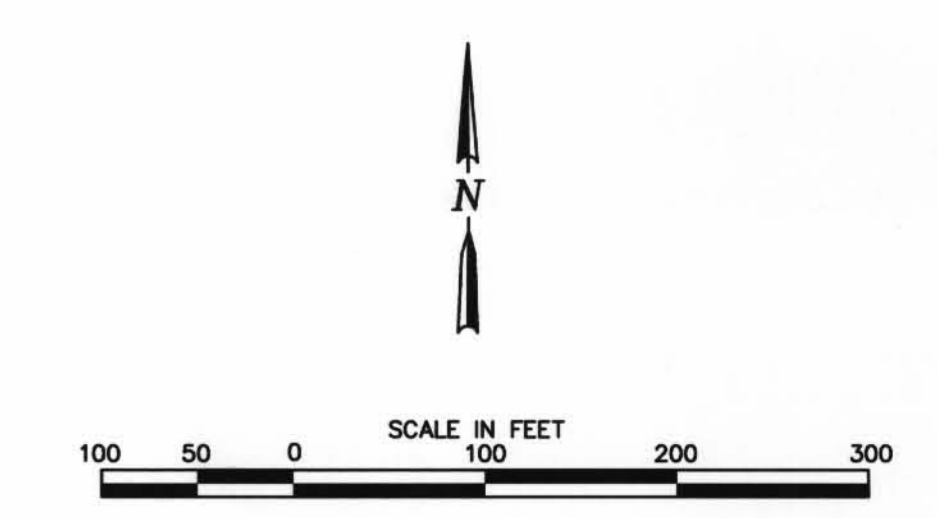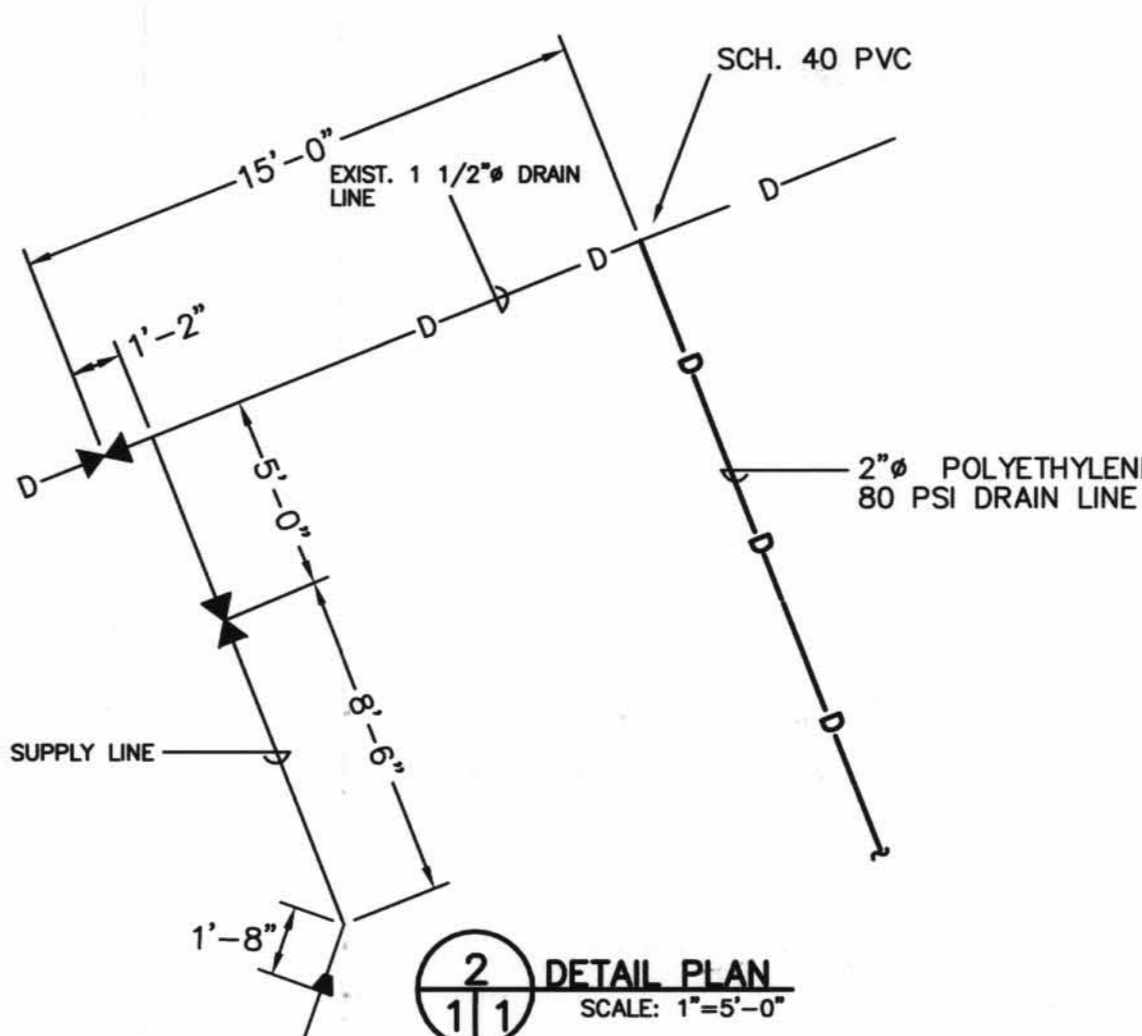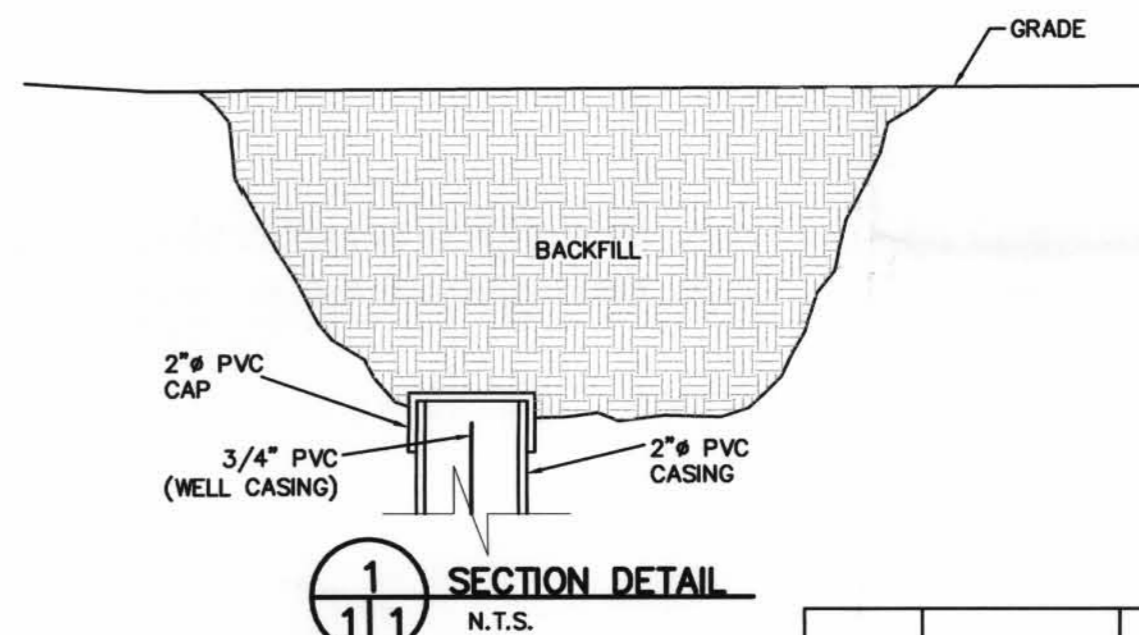

REVISION NO.	DATE	DESCRIPTION	DRAWN BY	DESIGNER	PROJECT ENG. APPROVED BY

		U.S. DEPARTMENT OF ENERGY GRAND JUNCTION OFFICE, COLORADO	
PROJECT LOCATION: NEW RIFLE SITE RIFLE, COLORADO		PROJECT NO.: UGW-511-0017-25-006	
APPROVED BY: C.J. WHITNEY	DATE: 12/01	UMITRA GROUNDWATER NEW RIFLE SITE	
DESIGNER: M.W. MADRIL	DATE: 12/01	ZVI PILOT TEST-25 GPM SITE PLAN	
PROJECT ENGINEER: M.W. MADRIL	DATE: 12/01	DRAWING NO.: U01433-T01-R00-D+	
APPROVED BY: K.E. KARP	DATE: 12/01	SHEET: 1 OF 7	
PROJECT SUPERVISOR: S.J. MARUTZKY	DATE: 12/01	SCALE: 1"=5'-0"	
DATE CONSTRUCTION: N.R.	N.T.S.	0-1	

THIS DRAWING IS FOR THE SOLE USE OF THE U.S. DEPARTMENT OF ENERGY AND ITS CONTRACTORS. IT IS NOT A LAND SURVEY PLAT, UTILITY LOCATION PLAT, OR OTHER IMPROVEMENT SURVEY PLAT AND IS NOT TO BE RELIED UPON FOR THE ESTABLISHMENT OF FENCE, BUILDING, OR OTHER FUTURE IMPROVEMENT LINES.