


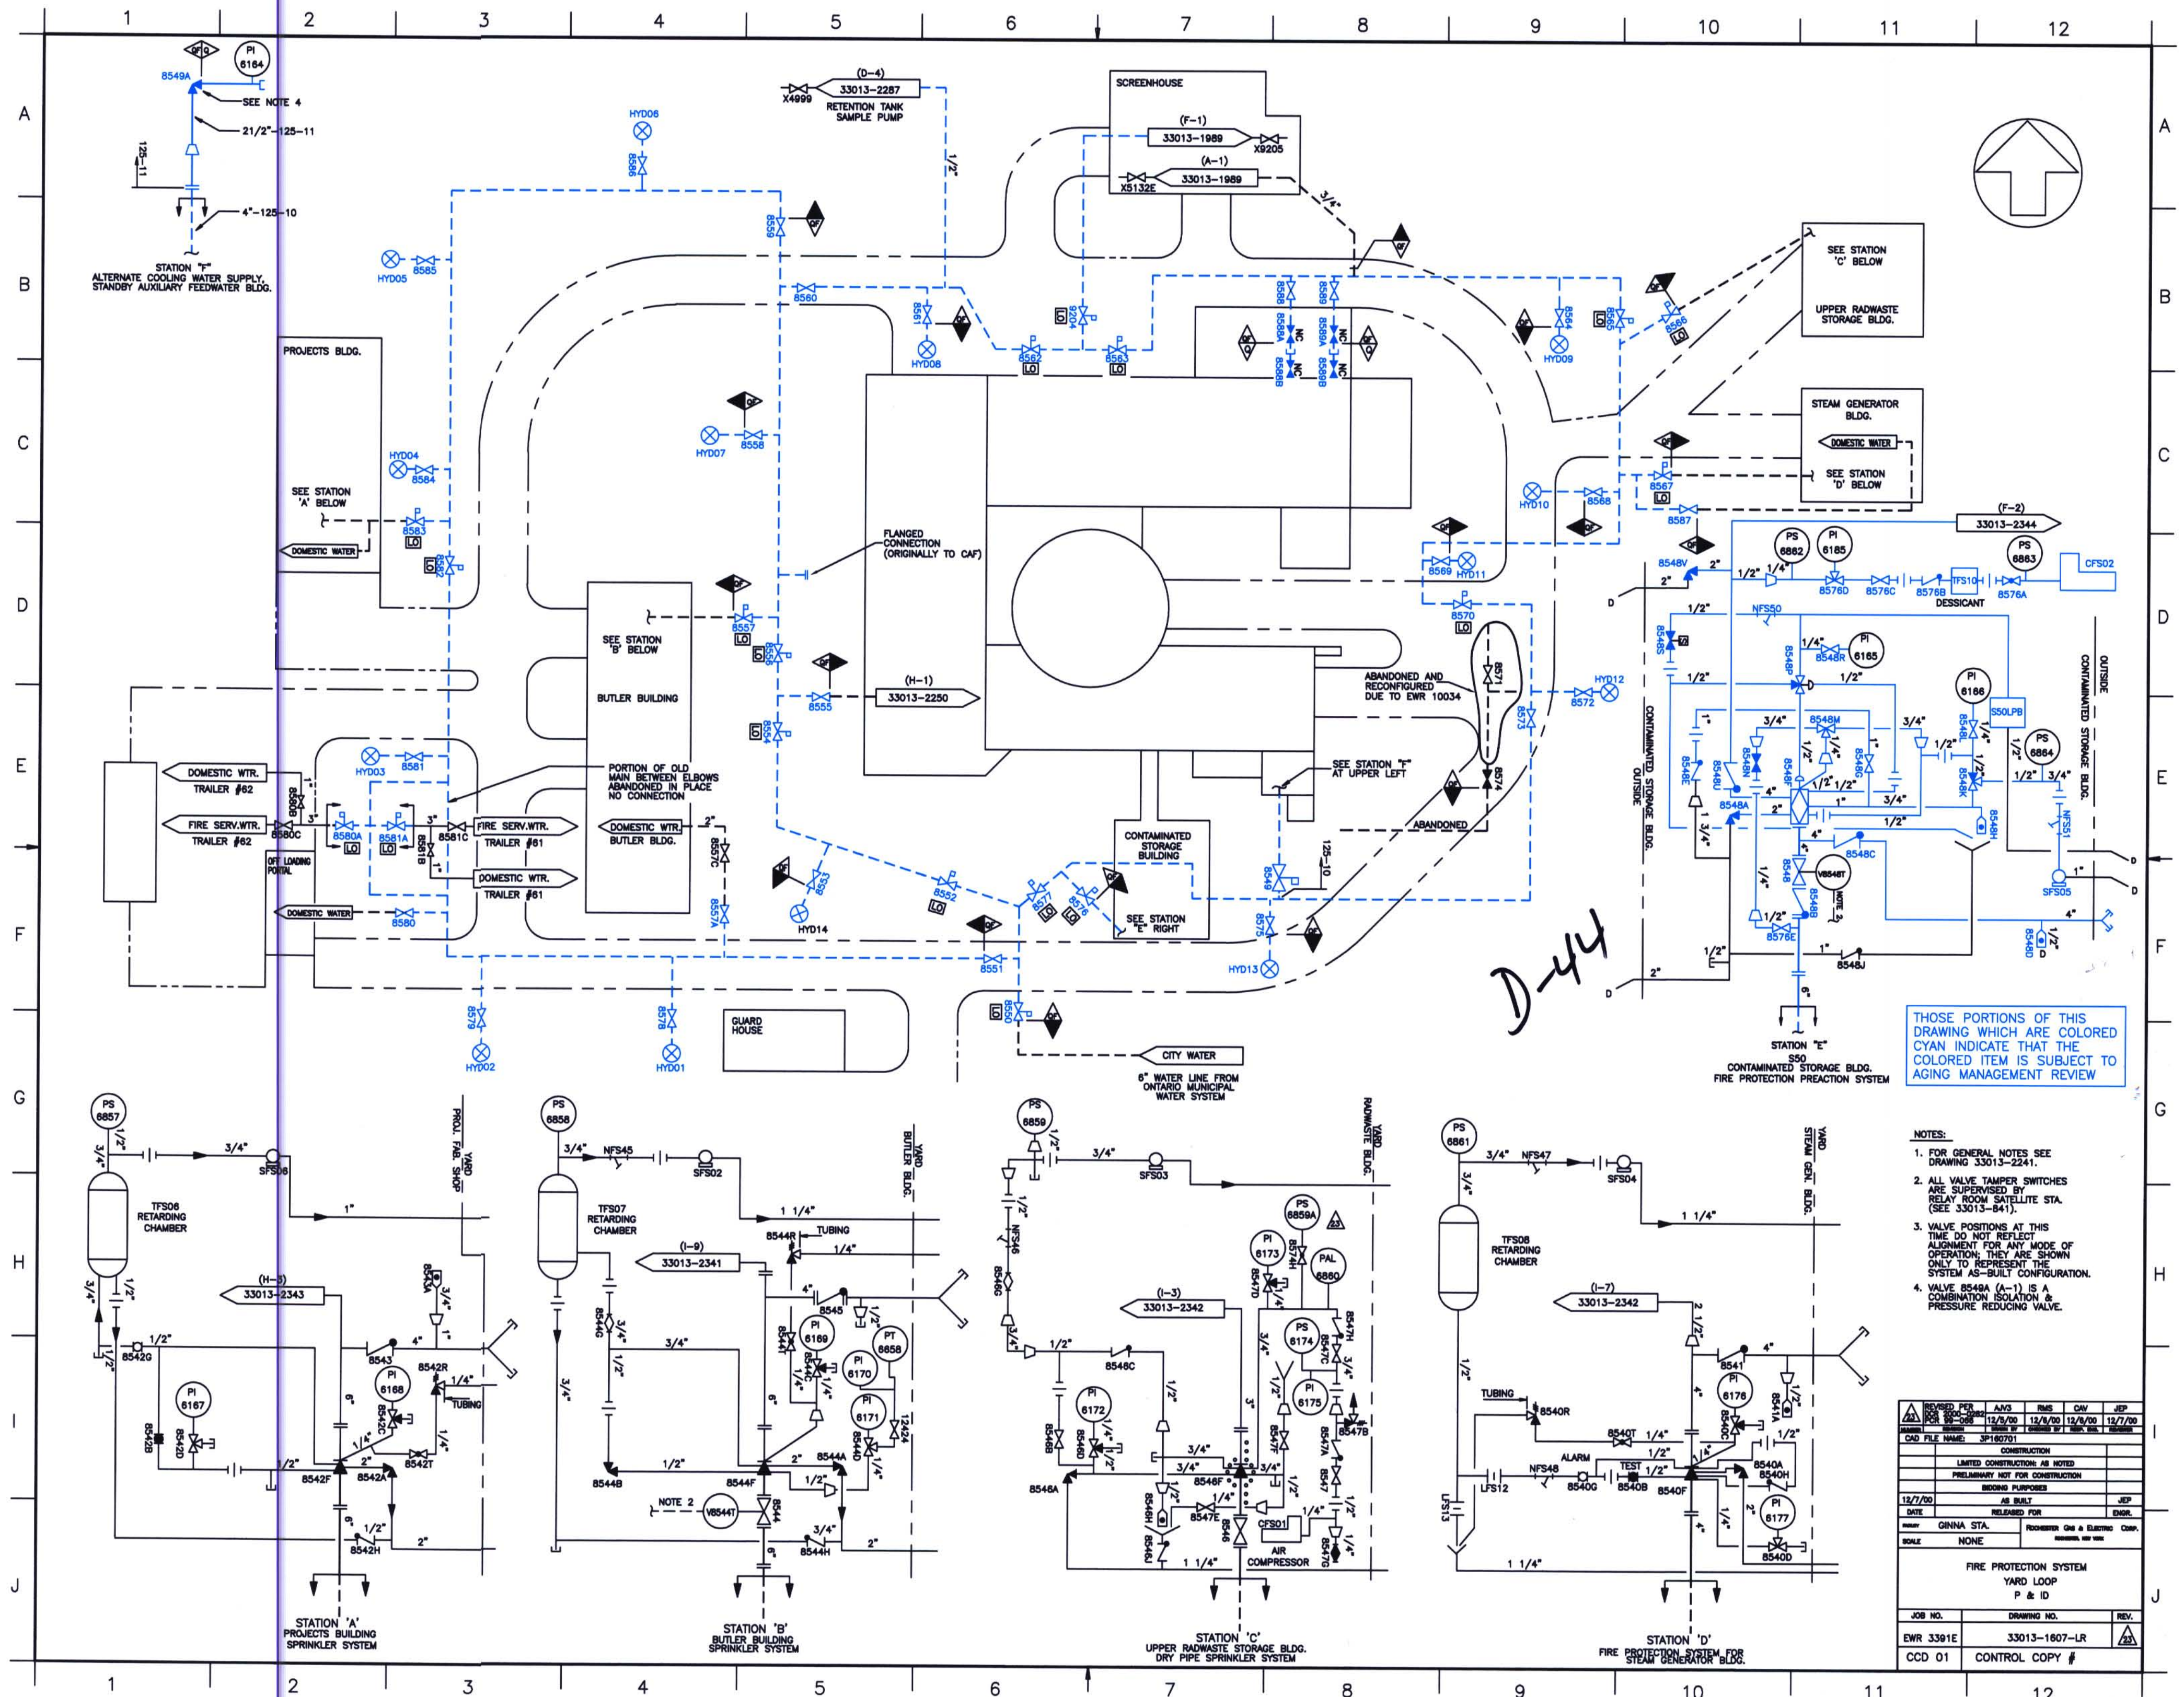

- NOTES:
- 1. FOR GENERAL NOTES SEE DRAWING 33013-2241.
 - 2. ALL VALVE TAMPER SWITCHES ARE SUPERVISED BY RELAY ROOM SATELLITE STA. (SEE 33013-841).
 - 3. VALVE POSITIONS AT THIS TIME DO NOT REFLECT ALIGNMENT FOR ANY MODE OF OPERATION. THEY ARE SHOWN ONLY TO REPRESENT THE SYSTEM AS-BUILT CONFIGURATION.
 - 4. VALVE 8548A (A-1) IS A COMBINATION ISOLATION & PRESSURE REDUCING VALVE.

REVISION	BY	DATE	DESCRIPTION
1	AVS	12/5/00	FOR 33013-2241
2	AVS	12/5/00	FOR 33013-2241
3	AVS	12/5/00	FOR 33013-2241
4	AVS	12/5/00	FOR 33013-2241
5	AVS	12/5/00	FOR 33013-2241
6	AVS	12/5/00	FOR 33013-2241
7	AVS	12/5/00	FOR 33013-2241
8	AVS	12/5/00	FOR 33013-2241
9	AVS	12/5/00	FOR 33013-2241
10	AVS	12/5/00	FOR 33013-2241
11	AVS	12/5/00	FOR 33013-2241
12	AVS	12/5/00	FOR 33013-2241

CONSTRUCTION	
LIMITED CONSTRUCTION AS NOTED	
PRELIMINARY NOT FOR CONSTRUCTION	
SECOND PURPOSES	
12/7/00	AS BUILT
DATE	RELEASED FOR
GINNA STA.	FOR MASTER ONE & ELECTRIC COMP.
SCALE	NONE
FIRE PROTECTION SYSTEM	
YARD LOOP	
P & ID	
JOB NO.	DRAWING NO.
EWR 3301E	33013-1607-LR
CCD 01	CONTROL COPY #