


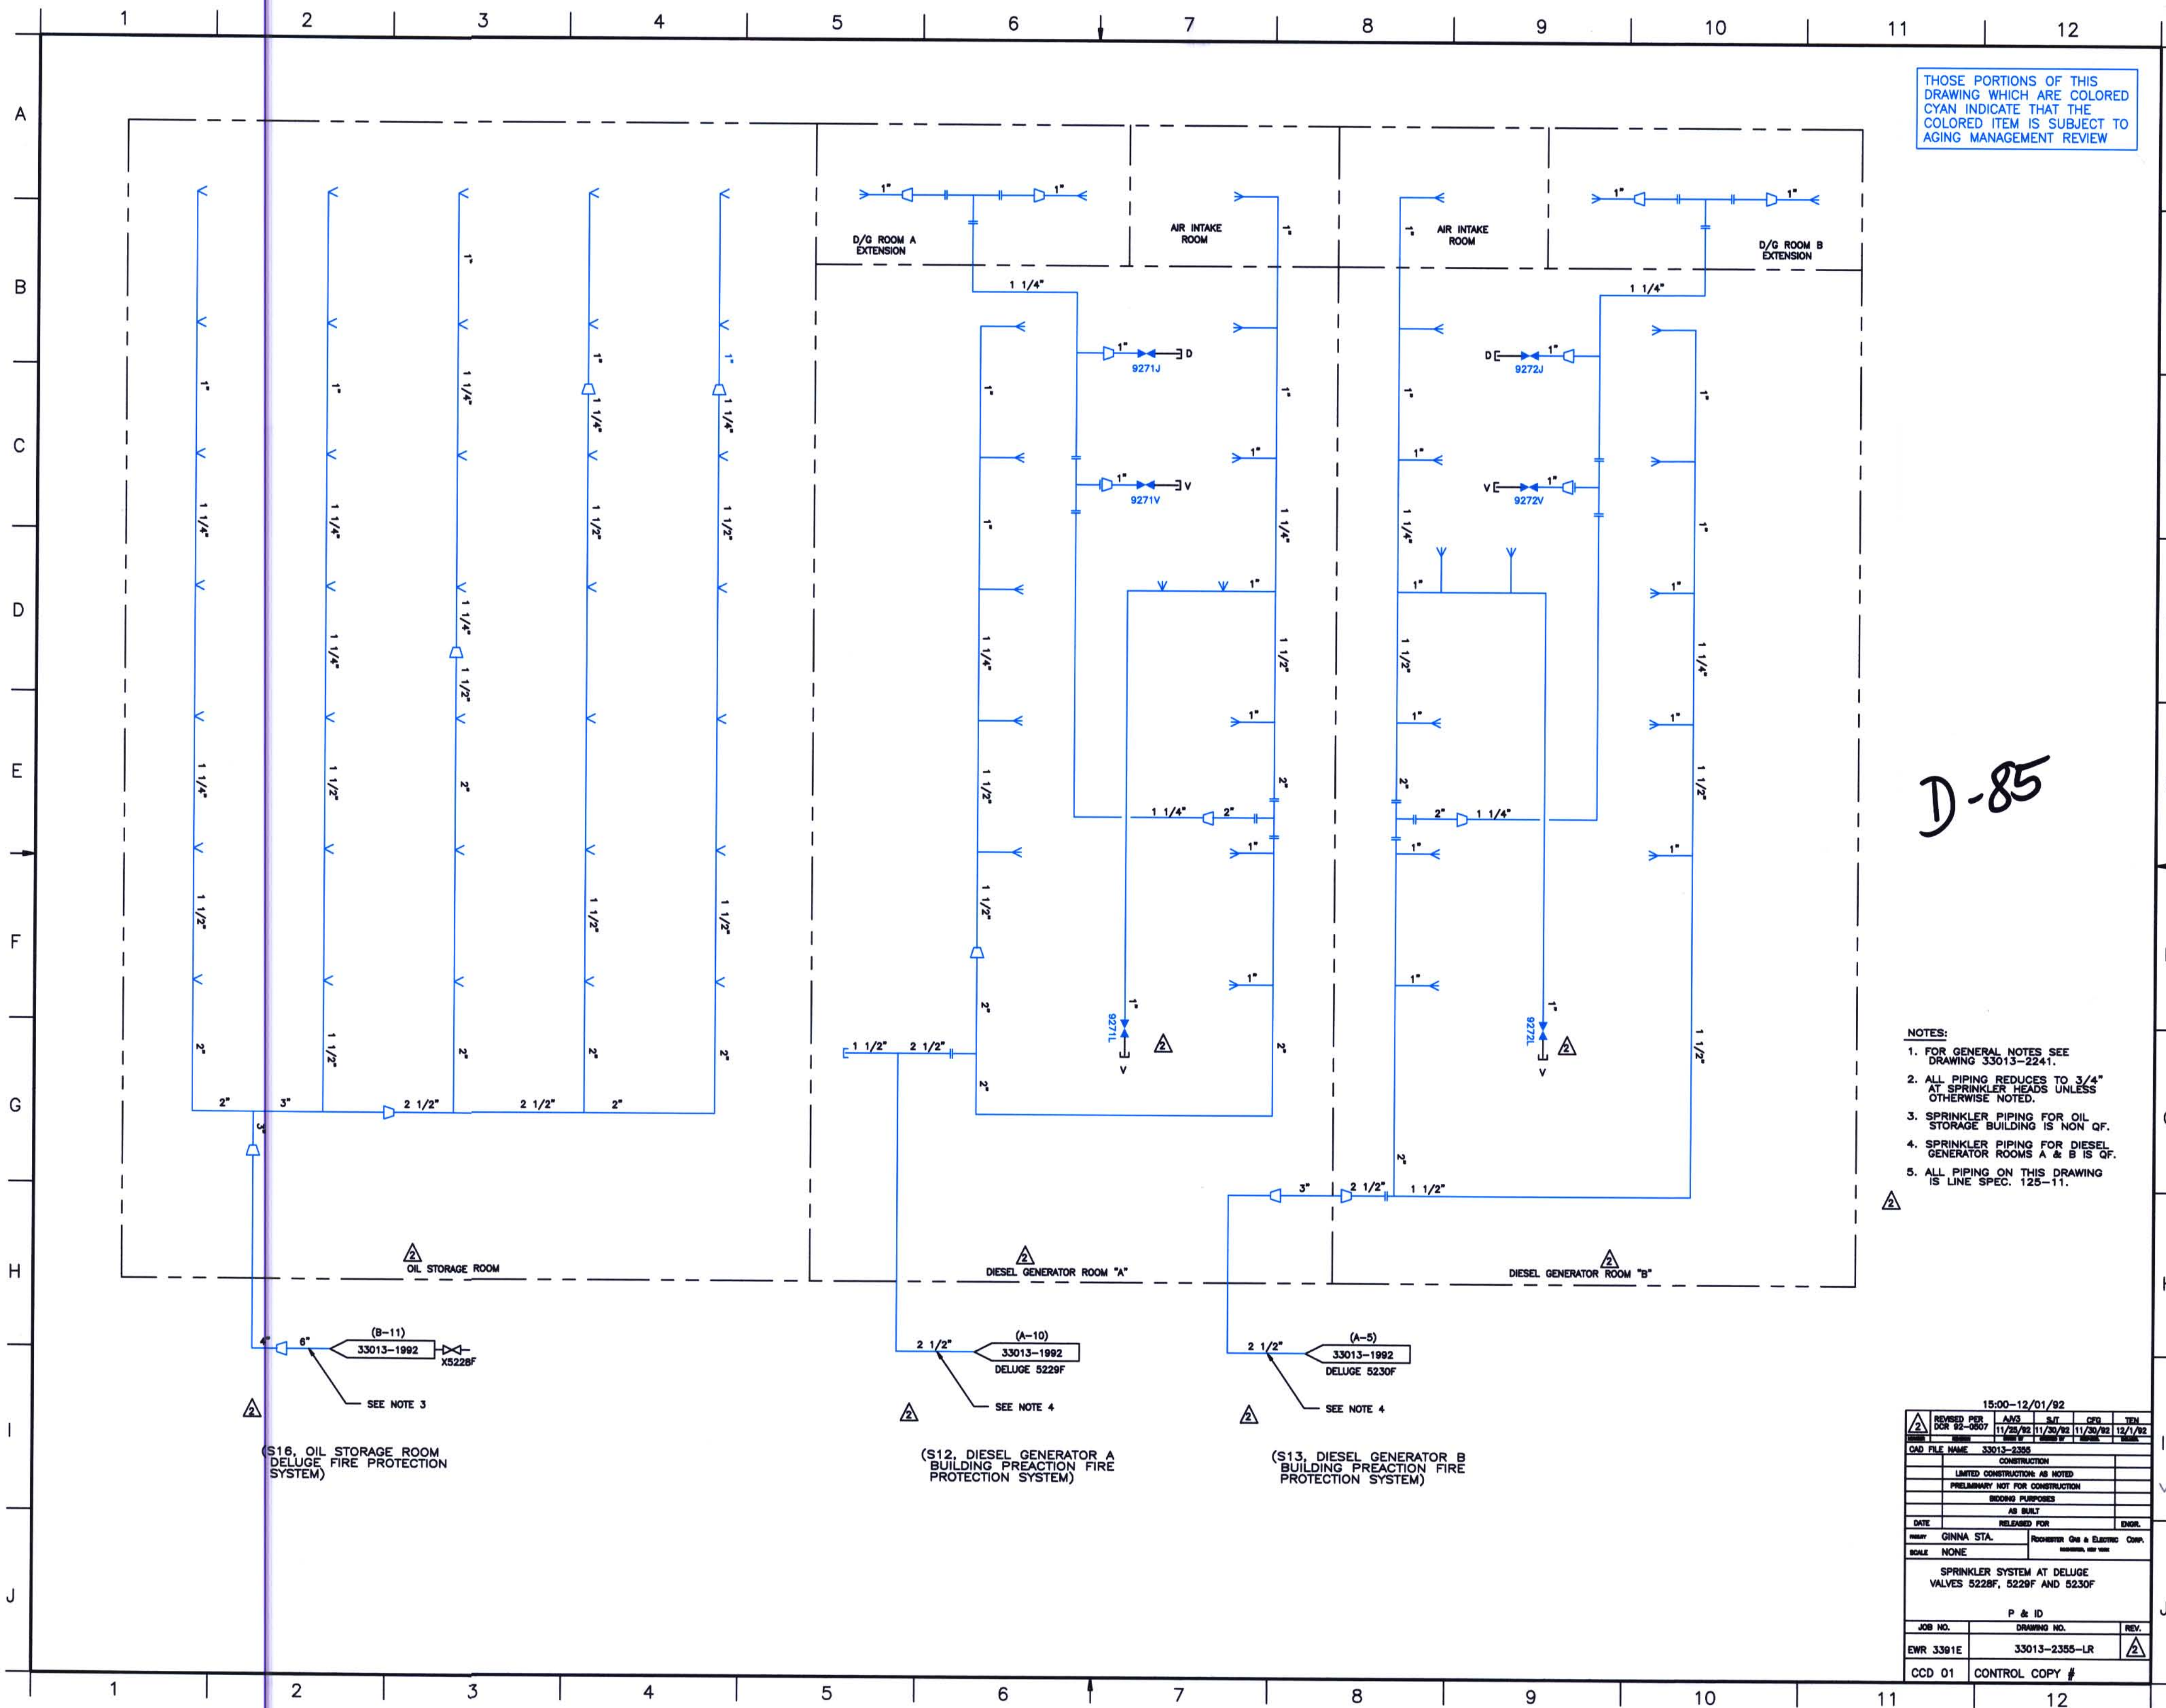

THOSE PORTIONS OF THIS
DRAWING WHICH ARE COLORED
CYAN INDICATE THAT THE
COLORED ITEM IS SUBJECT TO
AGING MANAGEMENT REVIEW

D-85

- NOTES:
1. FOR GENERAL NOTES SEE DRAWING 33013-2241.
 2. ALL PIPING REDUCES TO 3/4" AT SPRINKLER HEADS UNLESS OTHERWISE NOTED.
 3. SPRINKLER PIPING FOR OIL STORAGE BUILDING IS NON-QF.
 4. SPRINKLER PIPING FOR DIESEL GENERATOR ROOMS A & B IS QF.
 5. ALL PIPING ON THIS DRAWING IS LINE SPEC. 125-11.

(B-11)
33013-1992
XS228F
SEE NOTE 3
(S18, OIL STORAGE ROOM
DELUGE FIRE PROTECTION
SYSTEM)

(A-10)
33013-1992
DELUGE 5229F
SEE NOTE 4
(S12, DIESEL GENERATOR A
BUILDING PREACTION FIRE
PROTECTION SYSTEM)

(A-5)
33013-1992
DELUGE 5230F
SEE NOTE 4
(S13, DIESEL GENERATOR B
BUILDING PREACTION FIRE
PROTECTION SYSTEM)

15:00-12/01/92					
	REVISED PER DRAWING NO. 32-0007	AWG 11/29/92	SJT 11/29/92	CRJ 11/29/92	TEM 12/1/92
	CAD FILE NAME 33013-2355-LR				
CONSTRUCTION					
LIMITED CONSTRUCTION AS NOTED					
PRELIMINARY NOT FOR CONSTRUCTION					
RECORD PURPOSES					
AS BUILT					
DATE	RELEASED FOR				ENGR.
PROJECT	GINNA STA.		REVISION: One & Electric Corp.		
SCALE	NONE				
SPRINKLER SYSTEM AT DELUGE VALVES 5228F, 5229F AND 5230F					
P & ID					
JOB NO.	DRAWING NO.				REV.
EWR 3301E	33013-2355-LR				
CCD 01	CONTROL COPY #				