

8

7

6

5

4

3

2

1

H

G

F

E

D

C

B

A

H

G

F










E

D

C

B

A

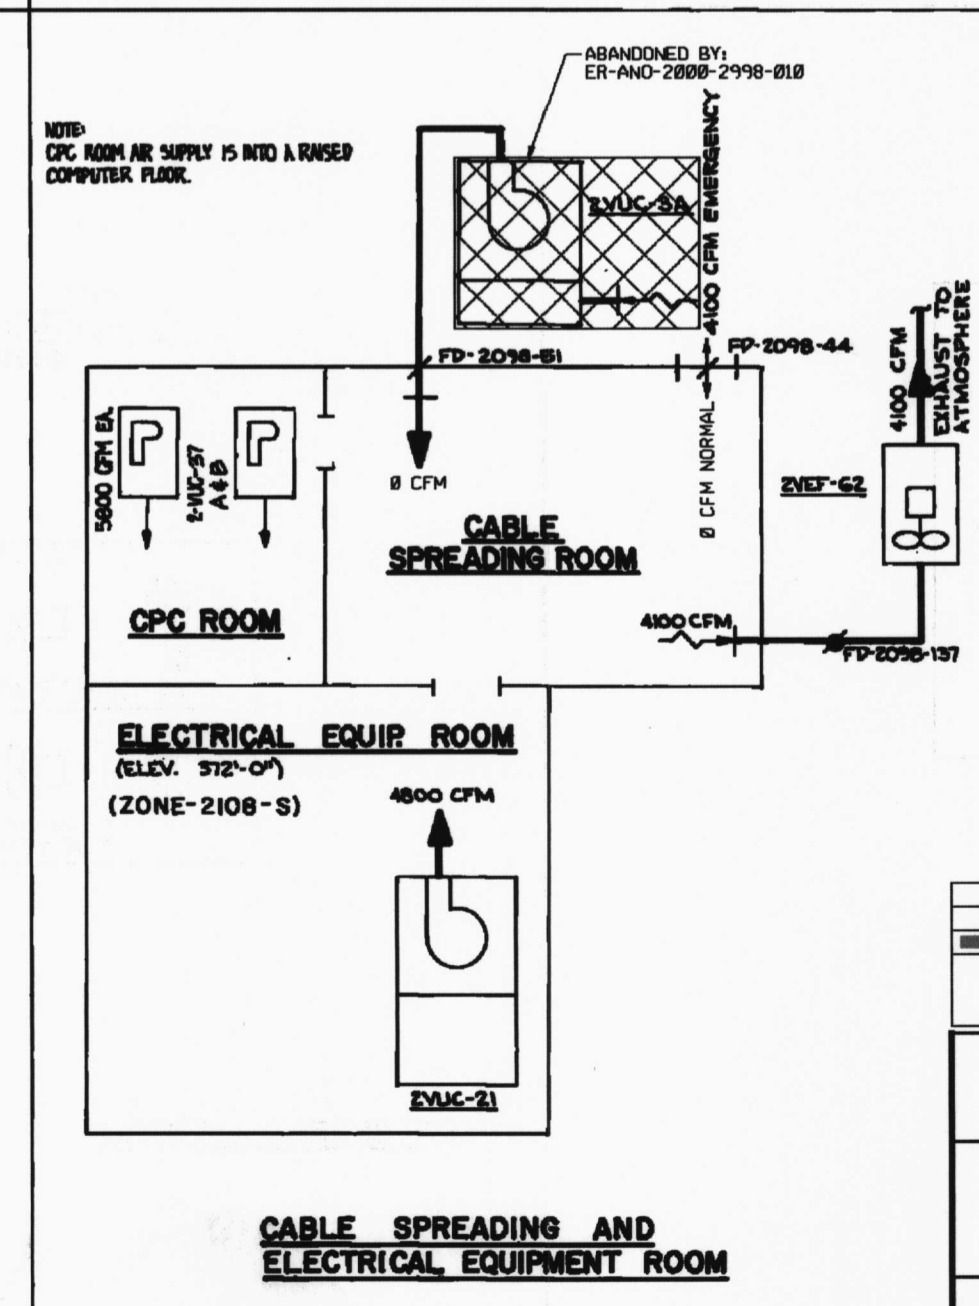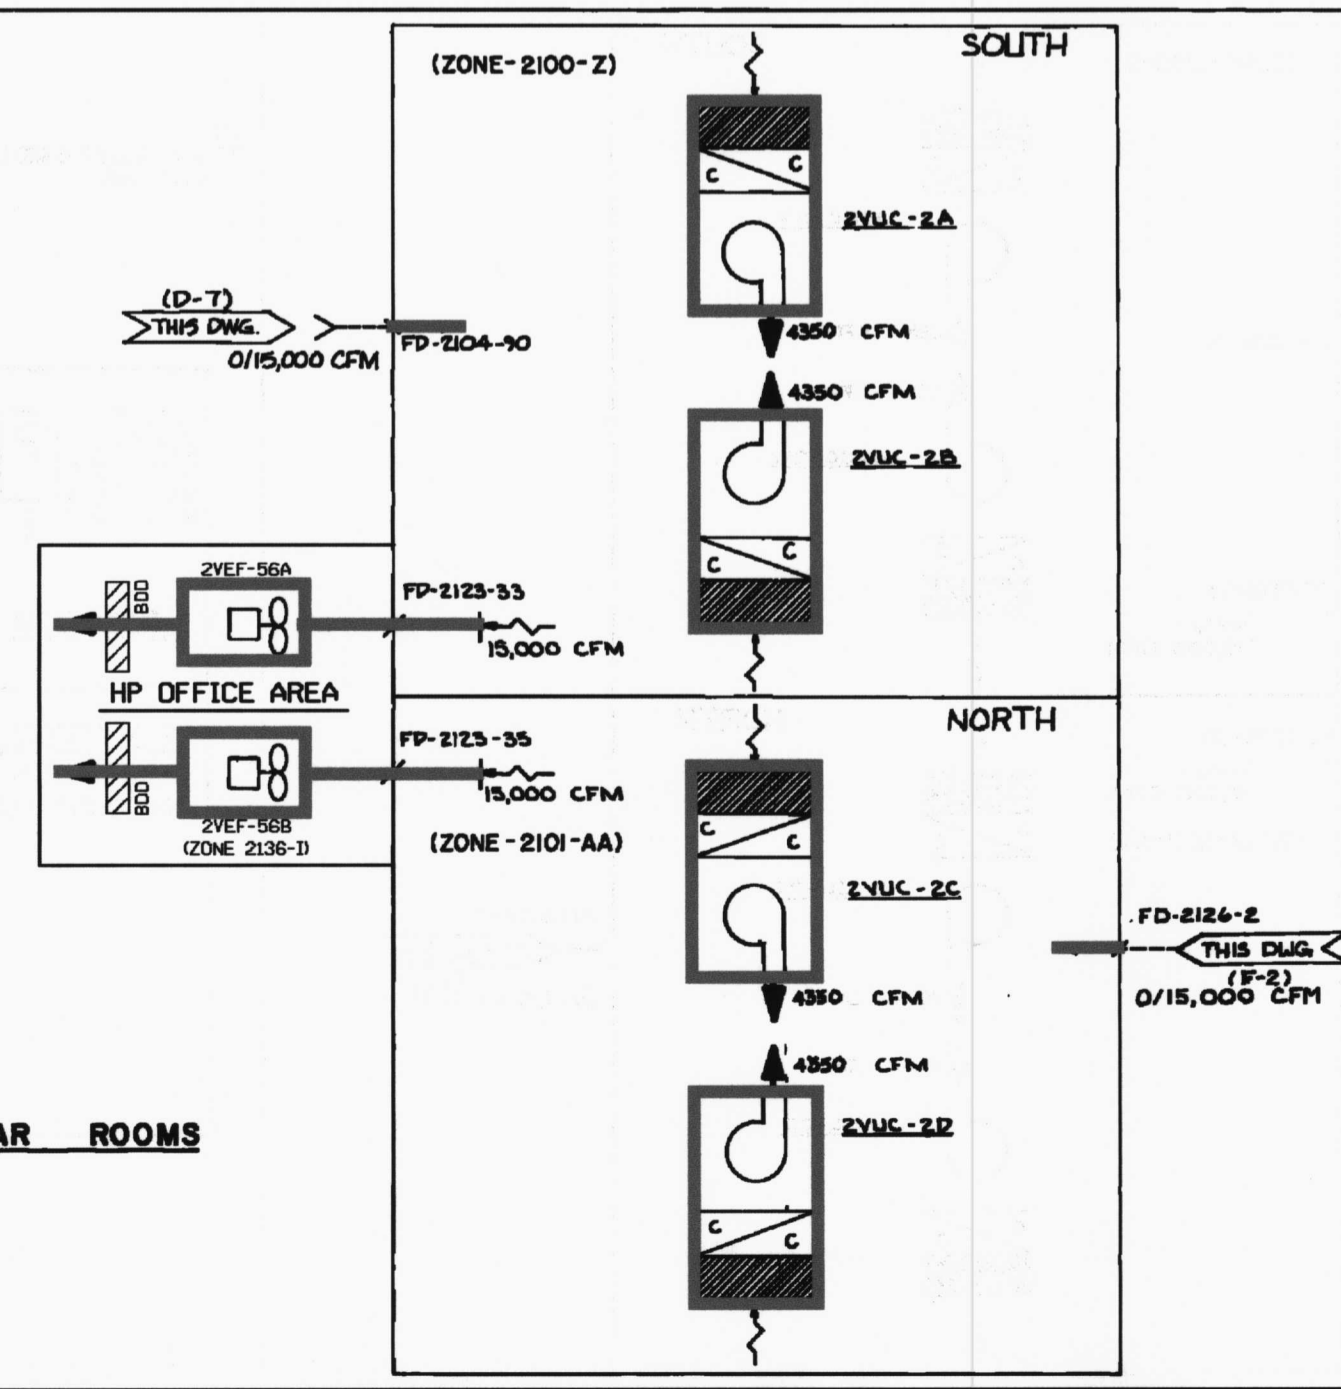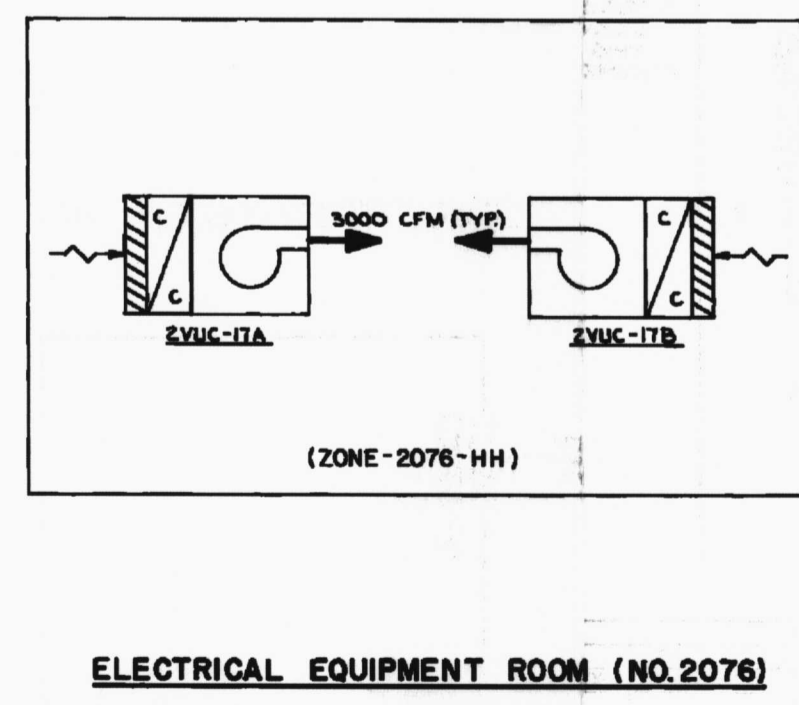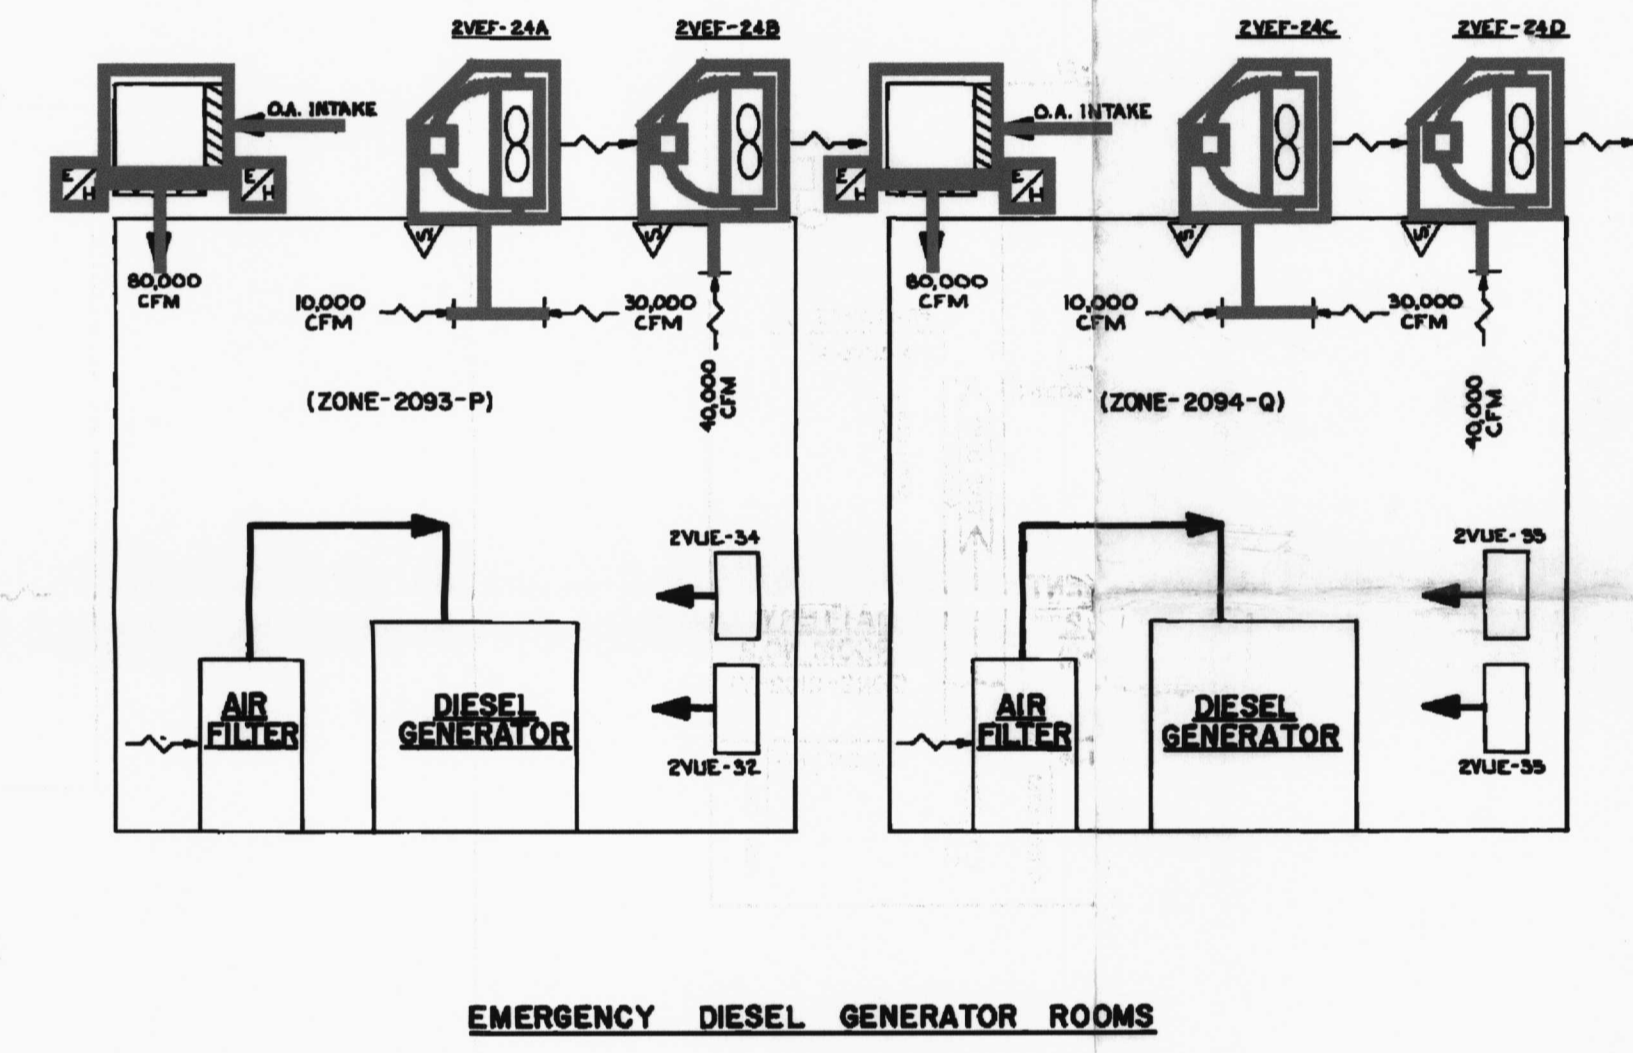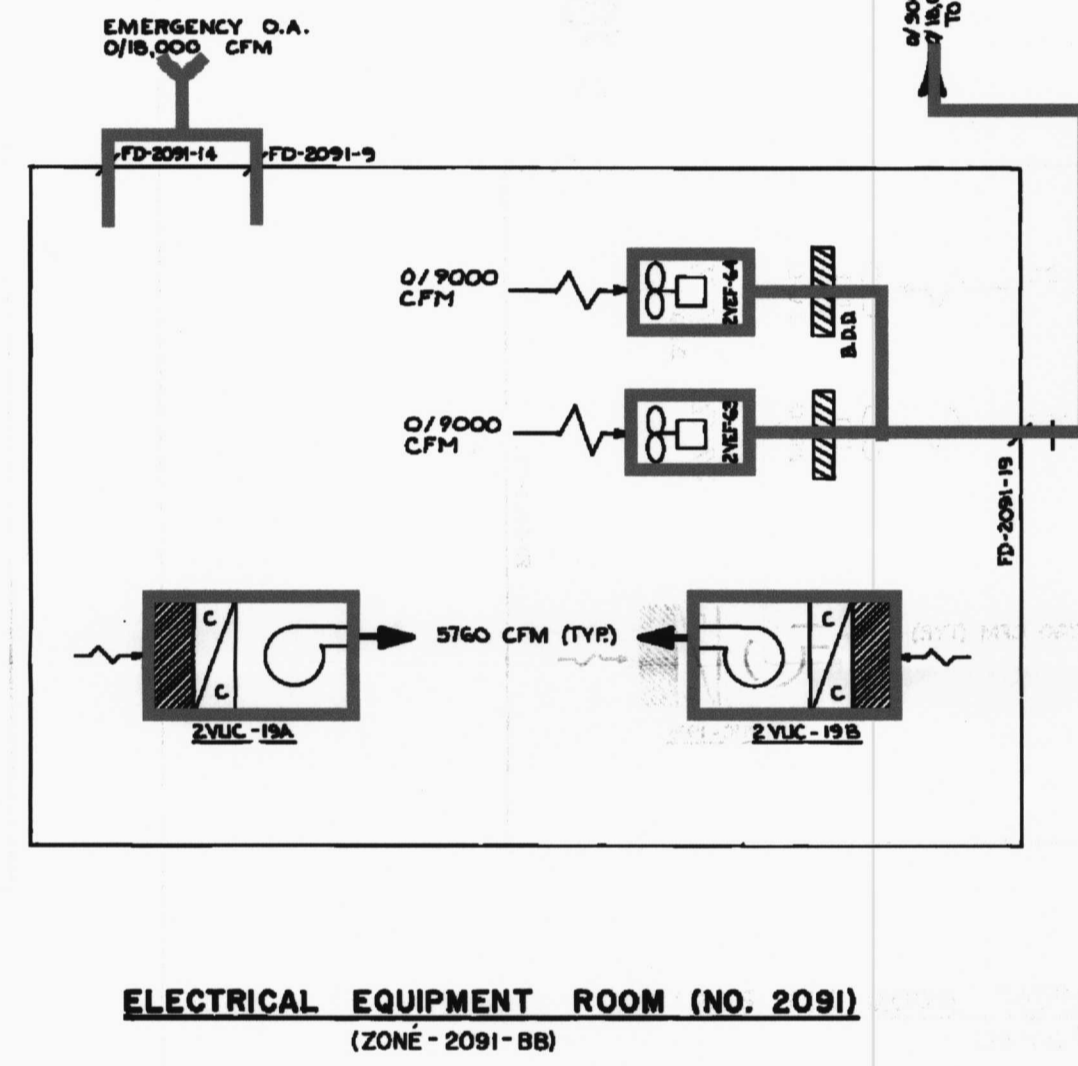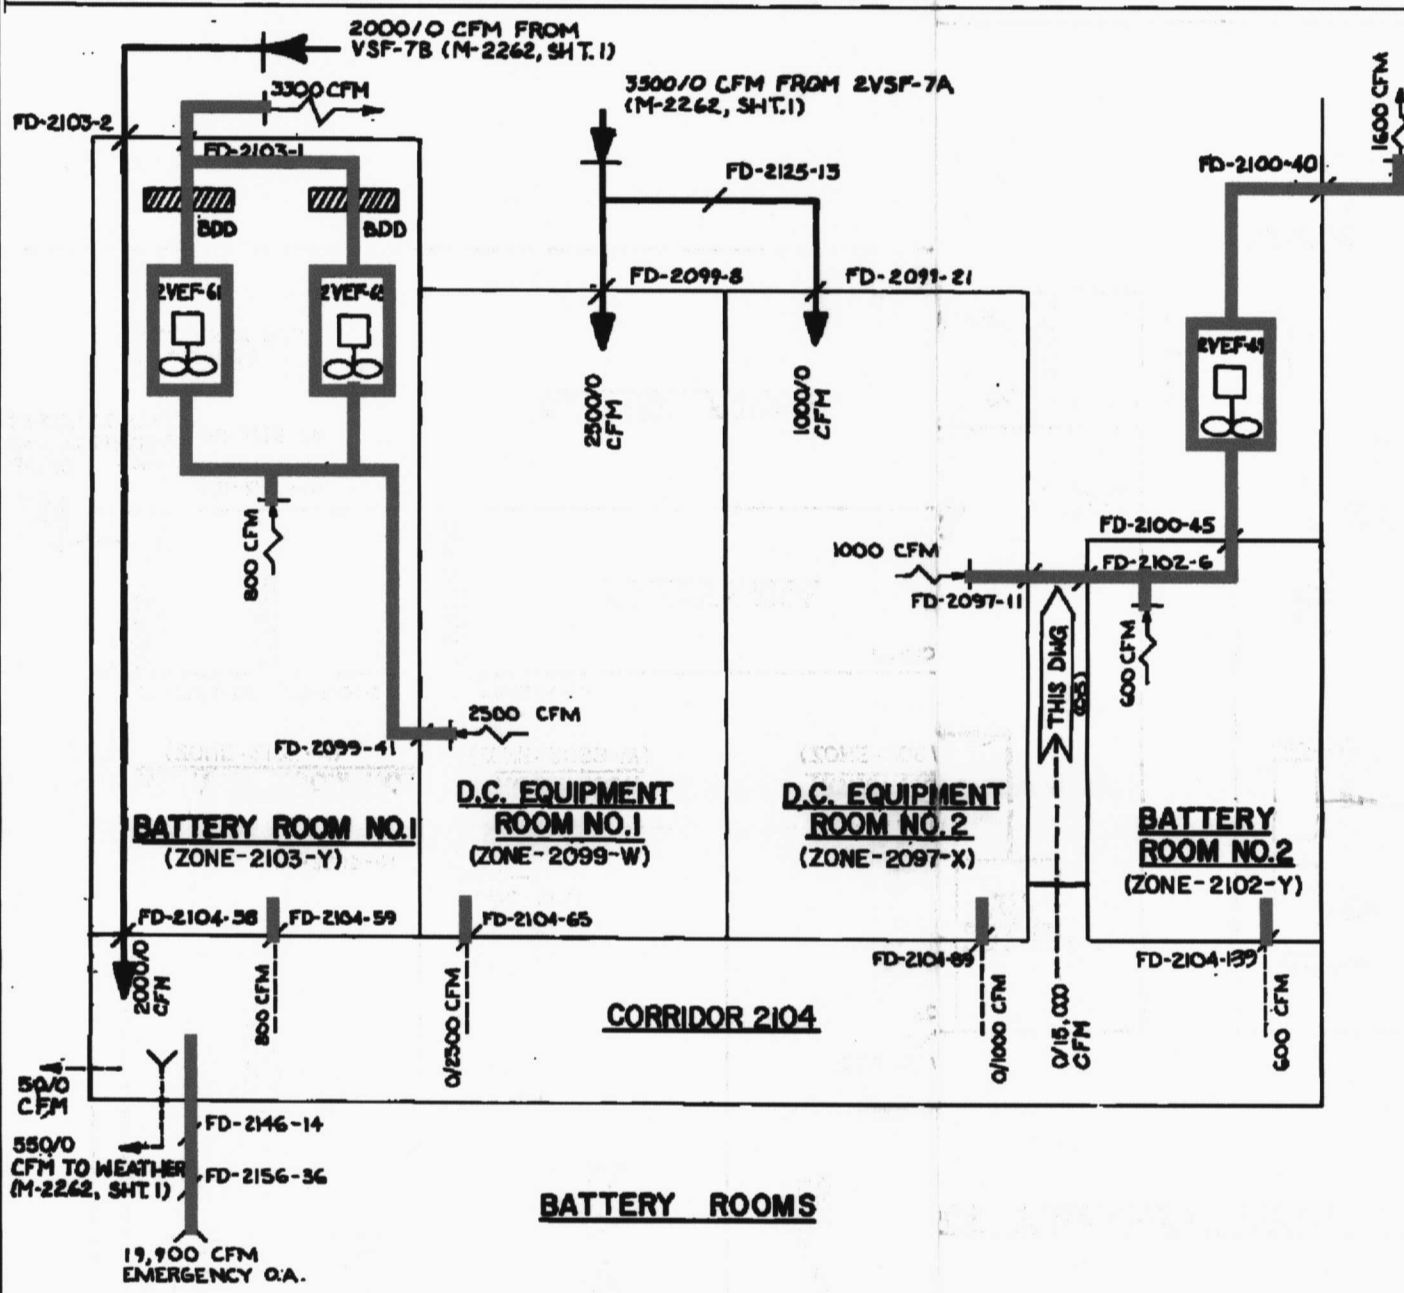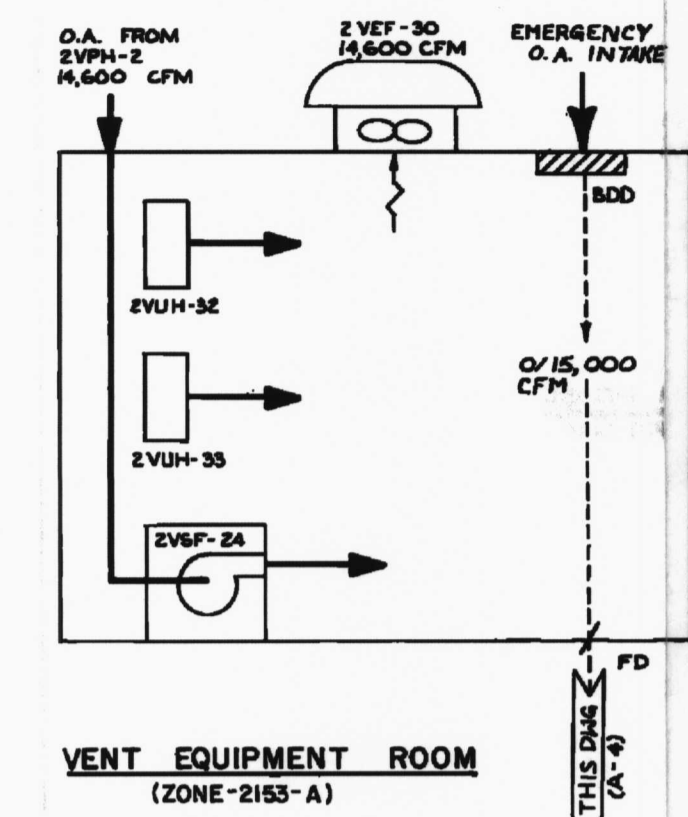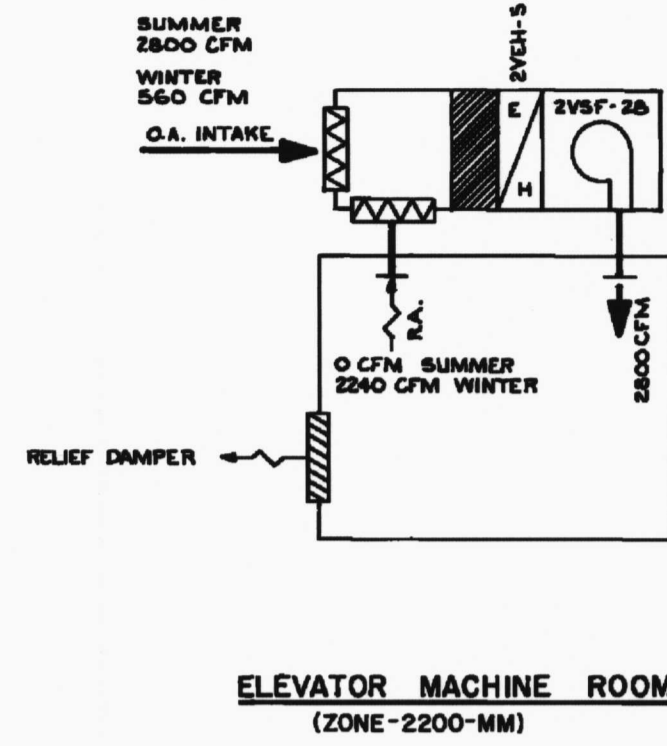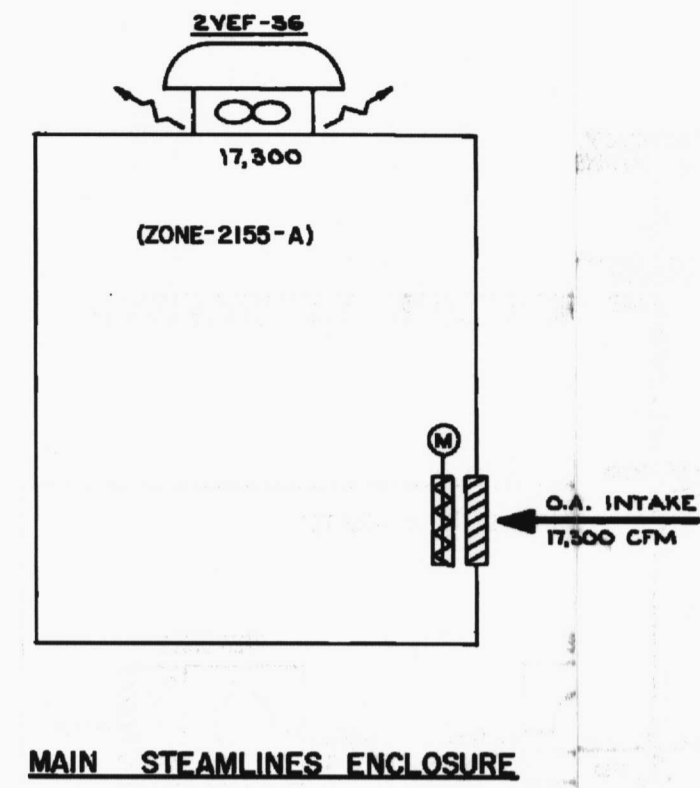

- NOTES:**
1. FOR GENERAL NOTES AND DRAWING INDEX, SEE DRAWING NO. M-2176.
 2. FOR CONTROL DIAGRAM, SEE DRAWING M-2263 SH. 2.
 3. FOR LOGIC DIAGRAM, SEE DRAWING M-2423.
 4. ALL FANS, PAMPERS, LOUVERS, DUCTS AND SUPPORTS ON EMERGENCY DIESEL GENERATOR ROOM VENTILATION SYSTEM ARE "Q".
 5. "ZONE XIX" PERMITS THE FIRE ZONE WHICH IS SERVED BY THE RESPECTIVE FANS SHOWN ON THIS DRAWING.
 6. NOMENCLATURE FOR CFM: NORMAL/EMERGENCY.

LEGEND	
[Symbol]	SYSTEM/AHR REPORT
[Symbol]	AUXILIARY BUILDING VENTILATION/82-R-2095-17
[Symbol]	LICENSE RENEWAL BOUNDARY
ARKANSAS NUCLEAR ONE UNIT 2 RUSSELLVILLE, ARKANSAS	
PIPING & INSTRUMENT DIAGRAM AIR FLOW DIAGRAM HVAC AUX. BLDG.-MISC. ROOMS	
DRAWING NO.	SHEET
LRA-M-2263	6
REV	REVISION
	0

D-64