


J-90081-R

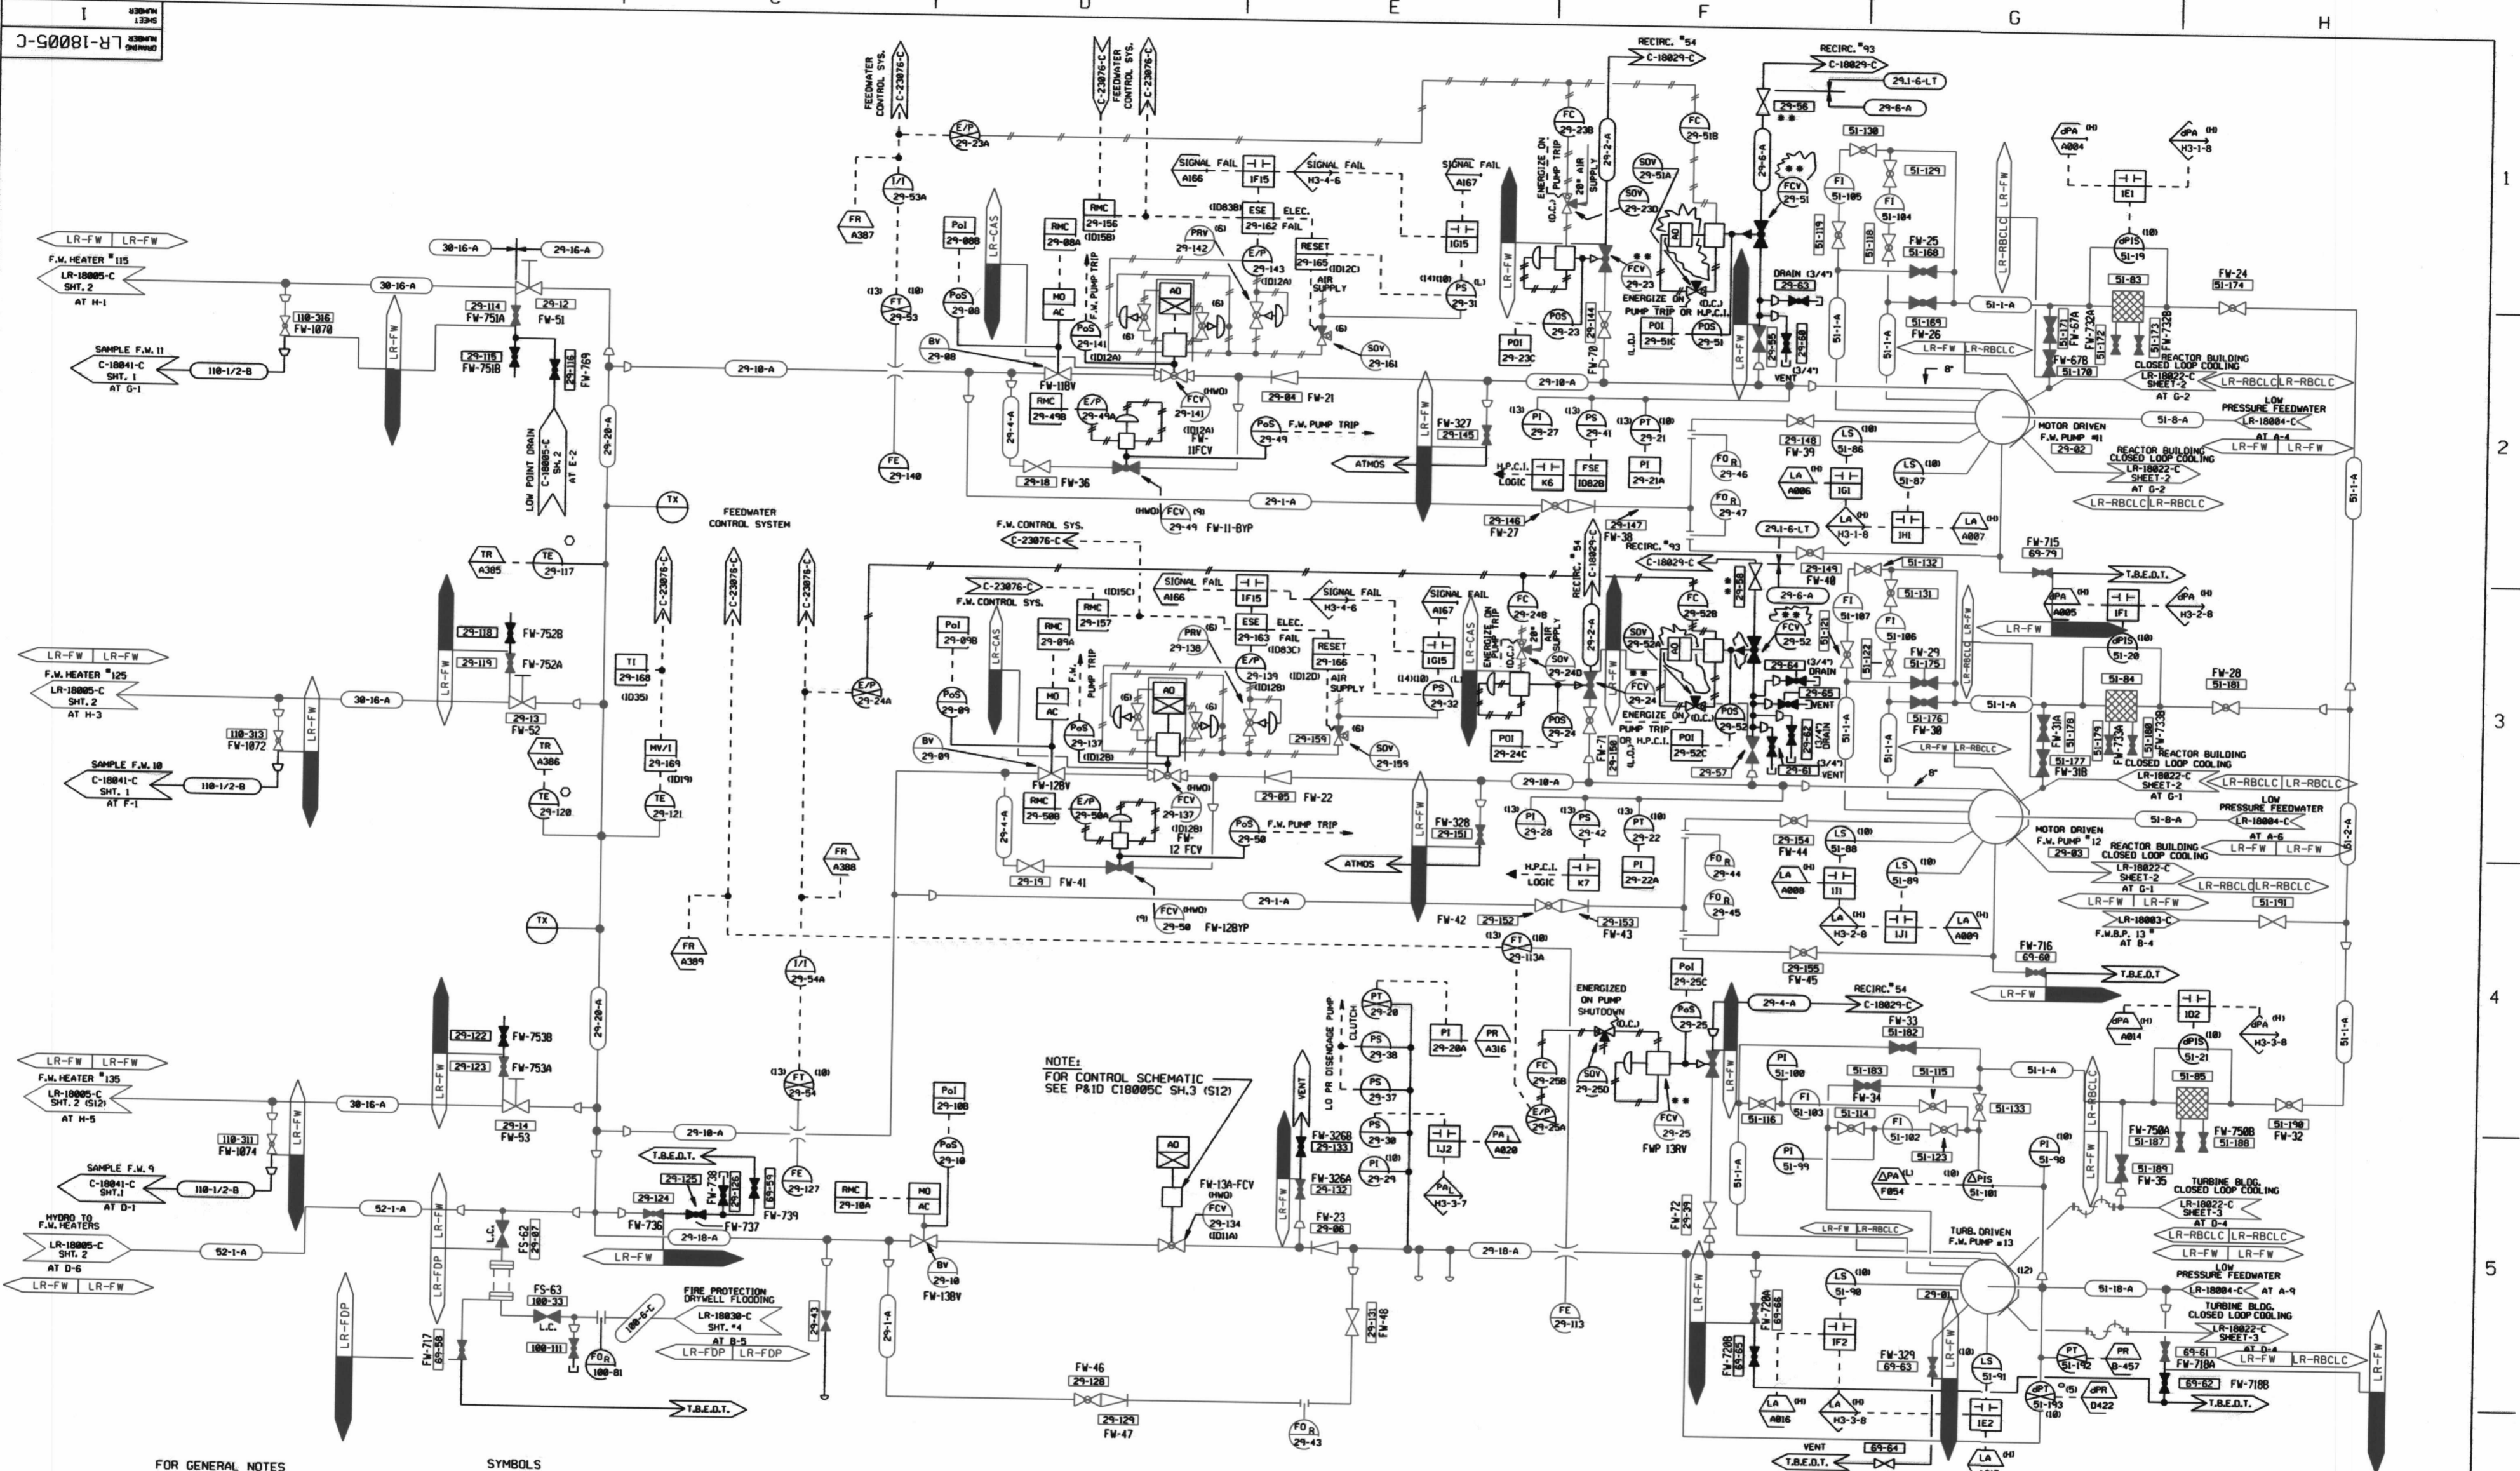

NOTE:  
FOR CONTROL SCHEMATIC  
SEE P&ID C18005C SH.3 (S12)

LR NOTE:  
PLEASE REFER TO DRAWING LR-18000-C SHEETS 1 AND 2 FOR  
LR BOUNDARY DRAWING NOTES, SYMBOLS, AND ACRONYMS.

NOTE: THIS DRAWING WAS CREATED USING  
COMPUTER AIDED DRAFTING  
DO NOT MAKE MANUAL CHANGES

FOR GENERAL NOTES  
SEE SHEET #2

- SYMBOLS
- PERFORMANCE CALCULATION
  - LOCATED NEAR CONDENSER
  - ▲ LOCATED NEAR 4th F.W. HEATER
  - FOR ISOLATION VALVE LEAKAGE TEST  
PIPING SEE DWG. C-18006-C SH.1

CONSTITUTION ENERGY GROUP		NINE MILE POINT NUCLEAR STATION UNIT NO. 1	
FEED WATER FLOW HIGH PRESSURE P & I DIAGRAM			
APP	APP	DATE	10/14/77
APP	MPN	DR	LRB
DES	DR	SCALE	NONE
HP	SCALE	DWG NO	LR-18005-C
INDEX	3-N2-S12	SH	1
REV			

D007