


J-91069-R1
 1334
 1335

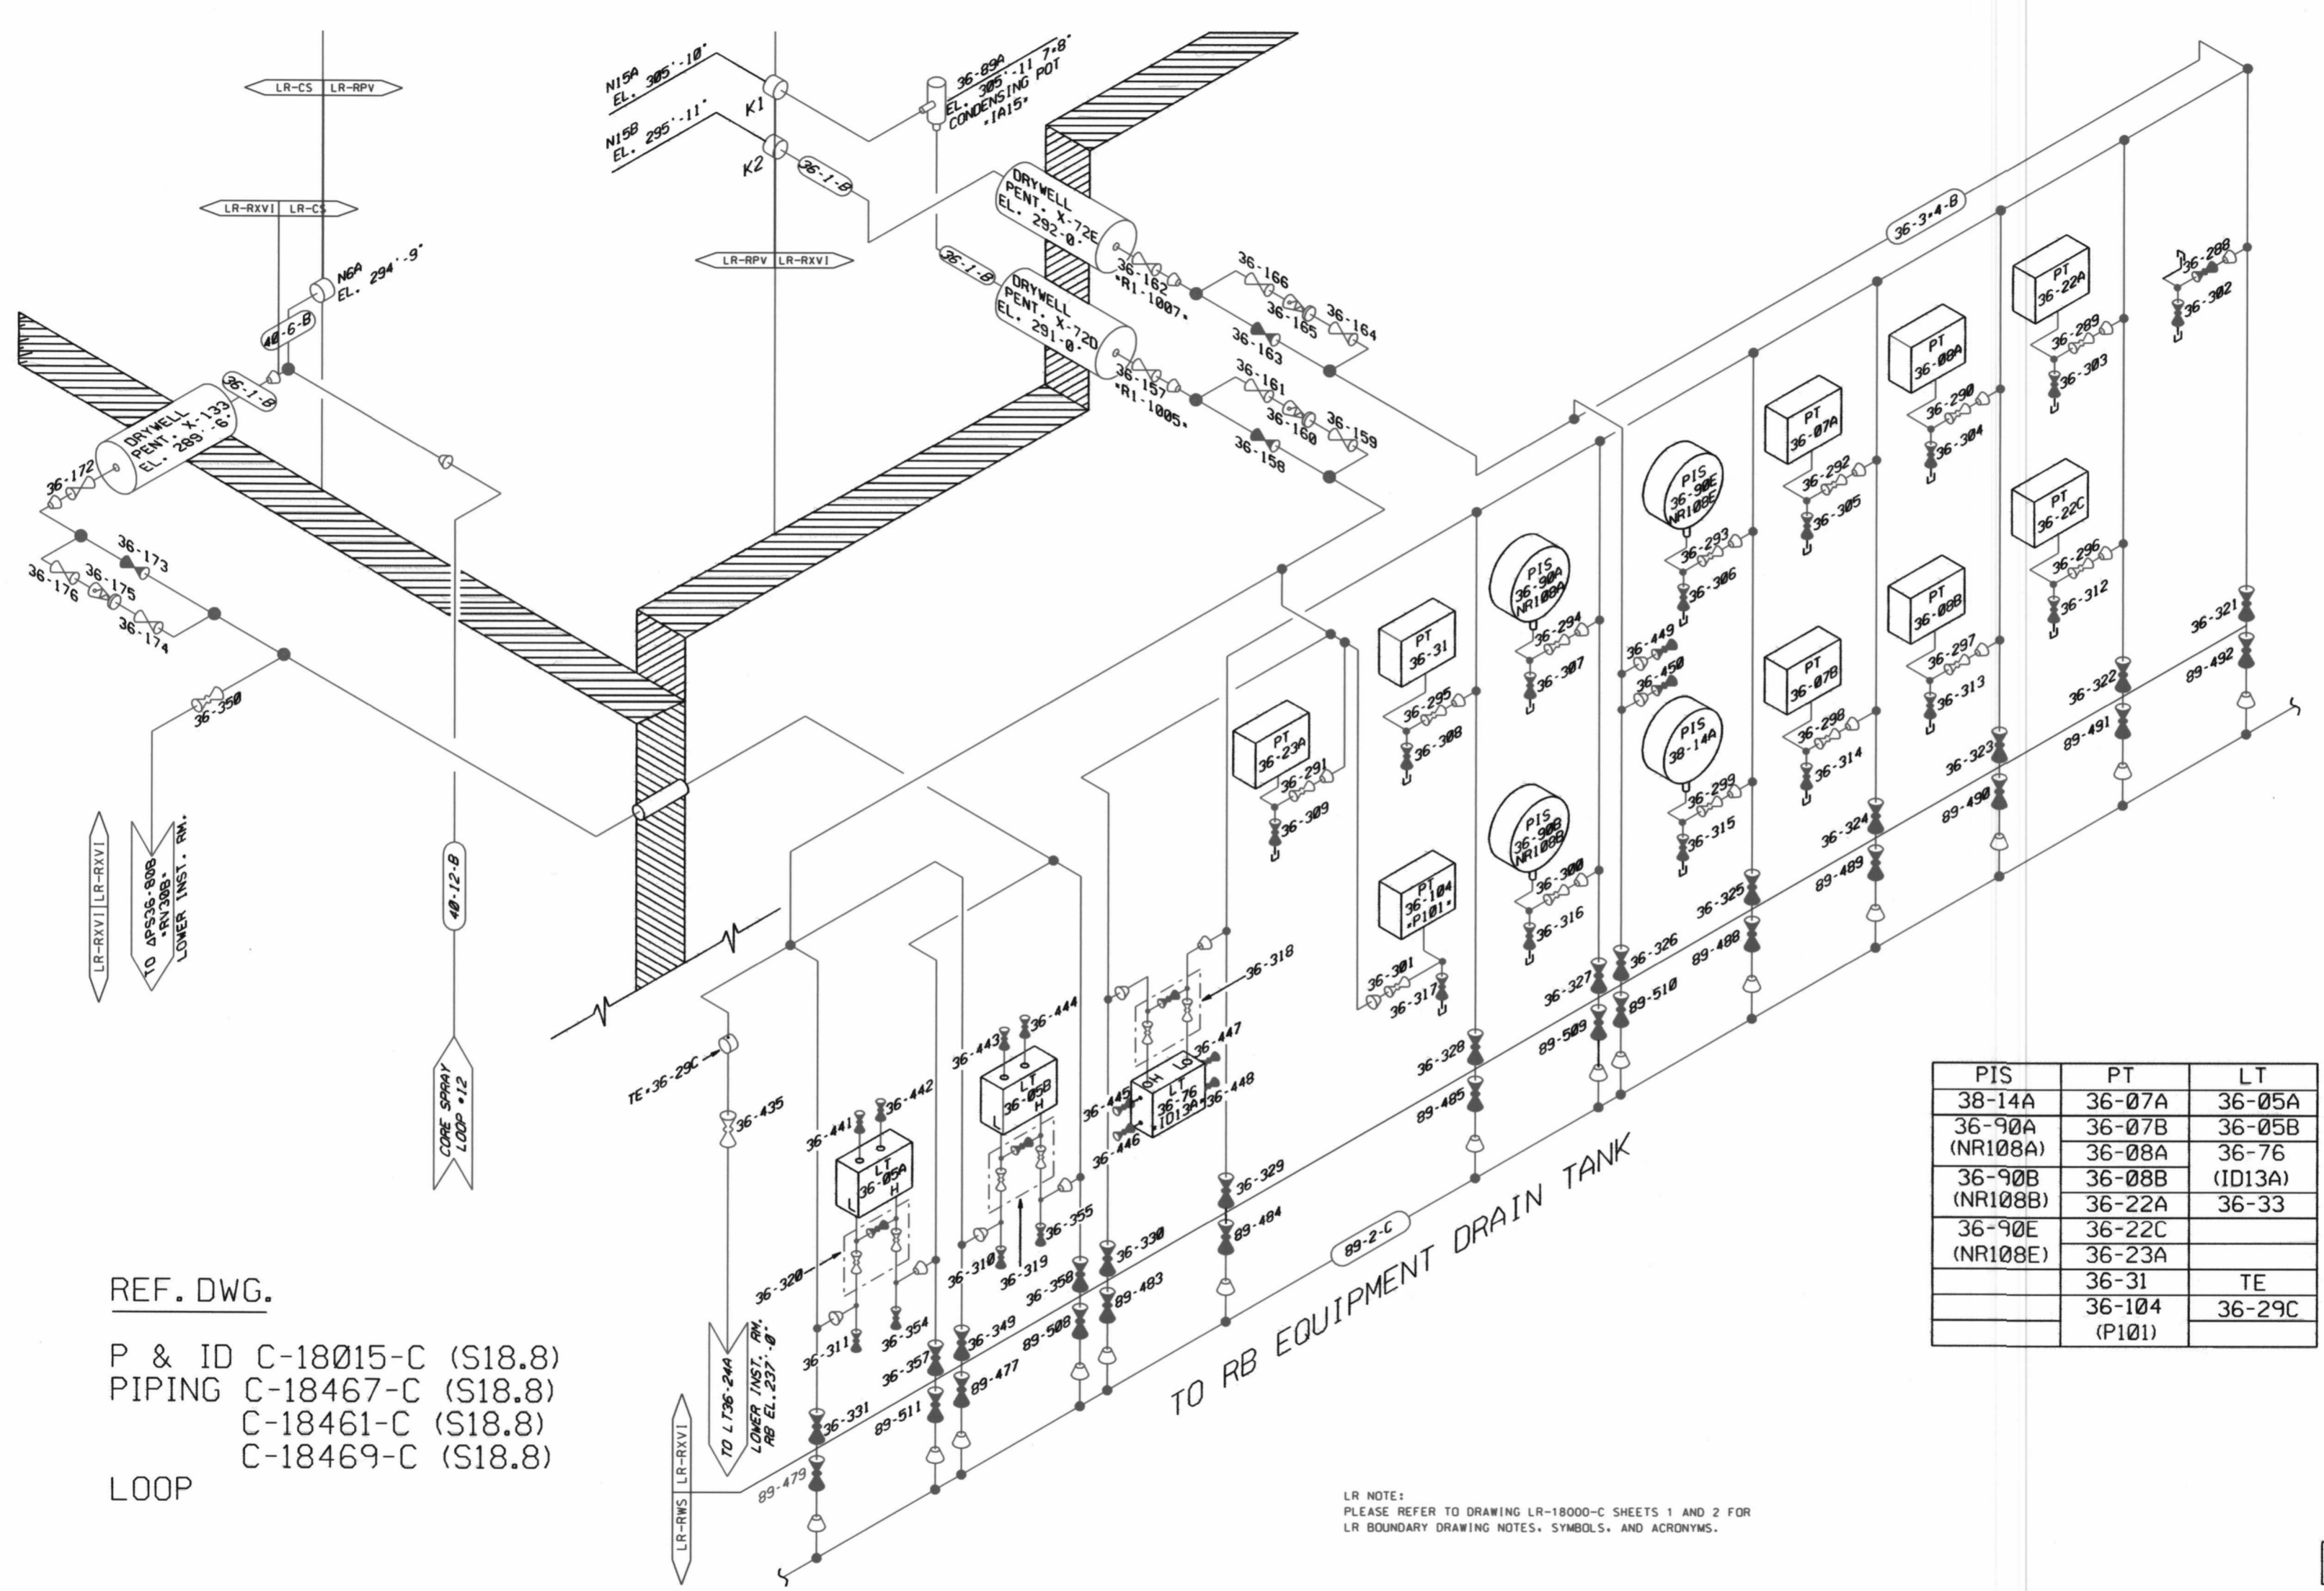

REF. DWG.
 P & ID C-18015-C (S18.8)
 PIPING C-18467-C (S18.8)
 C-18461-C (S18.8)
 C-18469-C (S18.8)
 LOOP

PIS	PT	LT
38-14A	36-07A	36-05A
36-90A (NR108A)	36-07B	36-05B
36-90B (NR108B)	36-08A	36-76 (ID13A)
36-90E (NR108E)	36-08B	36-33
	36-22C	
	36-23A	
	36-31	TE
	36-104 (P101)	36-29C

LR NOTE:
 PLEASE REFER TO DRAWING LR-18000-C SHEETS 1 AND 2 FOR LR BOUNDARY DRAWING NOTES, SYMBOLS, AND ACRONYMS.

NOTE: THIS DRAWING WAS CREATED USING COMPUTER AIDED DRAFTING DO NOT MAKE MANUAL CHANGES

CONSTELLATION ENERGY GROUP		STA NINE MILE POINT NUCLEAR STATION UNIT NO. 1	
APP	DATE	REACTOR VESSEL LEVEL & PRESSURE WEST INSTRUMENT ROOM EL. 284'-0" REACTOR BLDG INSTRUMENT DIAGRAM	
DES	DR	SCALE	DWG NO
REV	REV	INDEX	REV
		LR-F69015-C	4

D091