


LR-69015-C

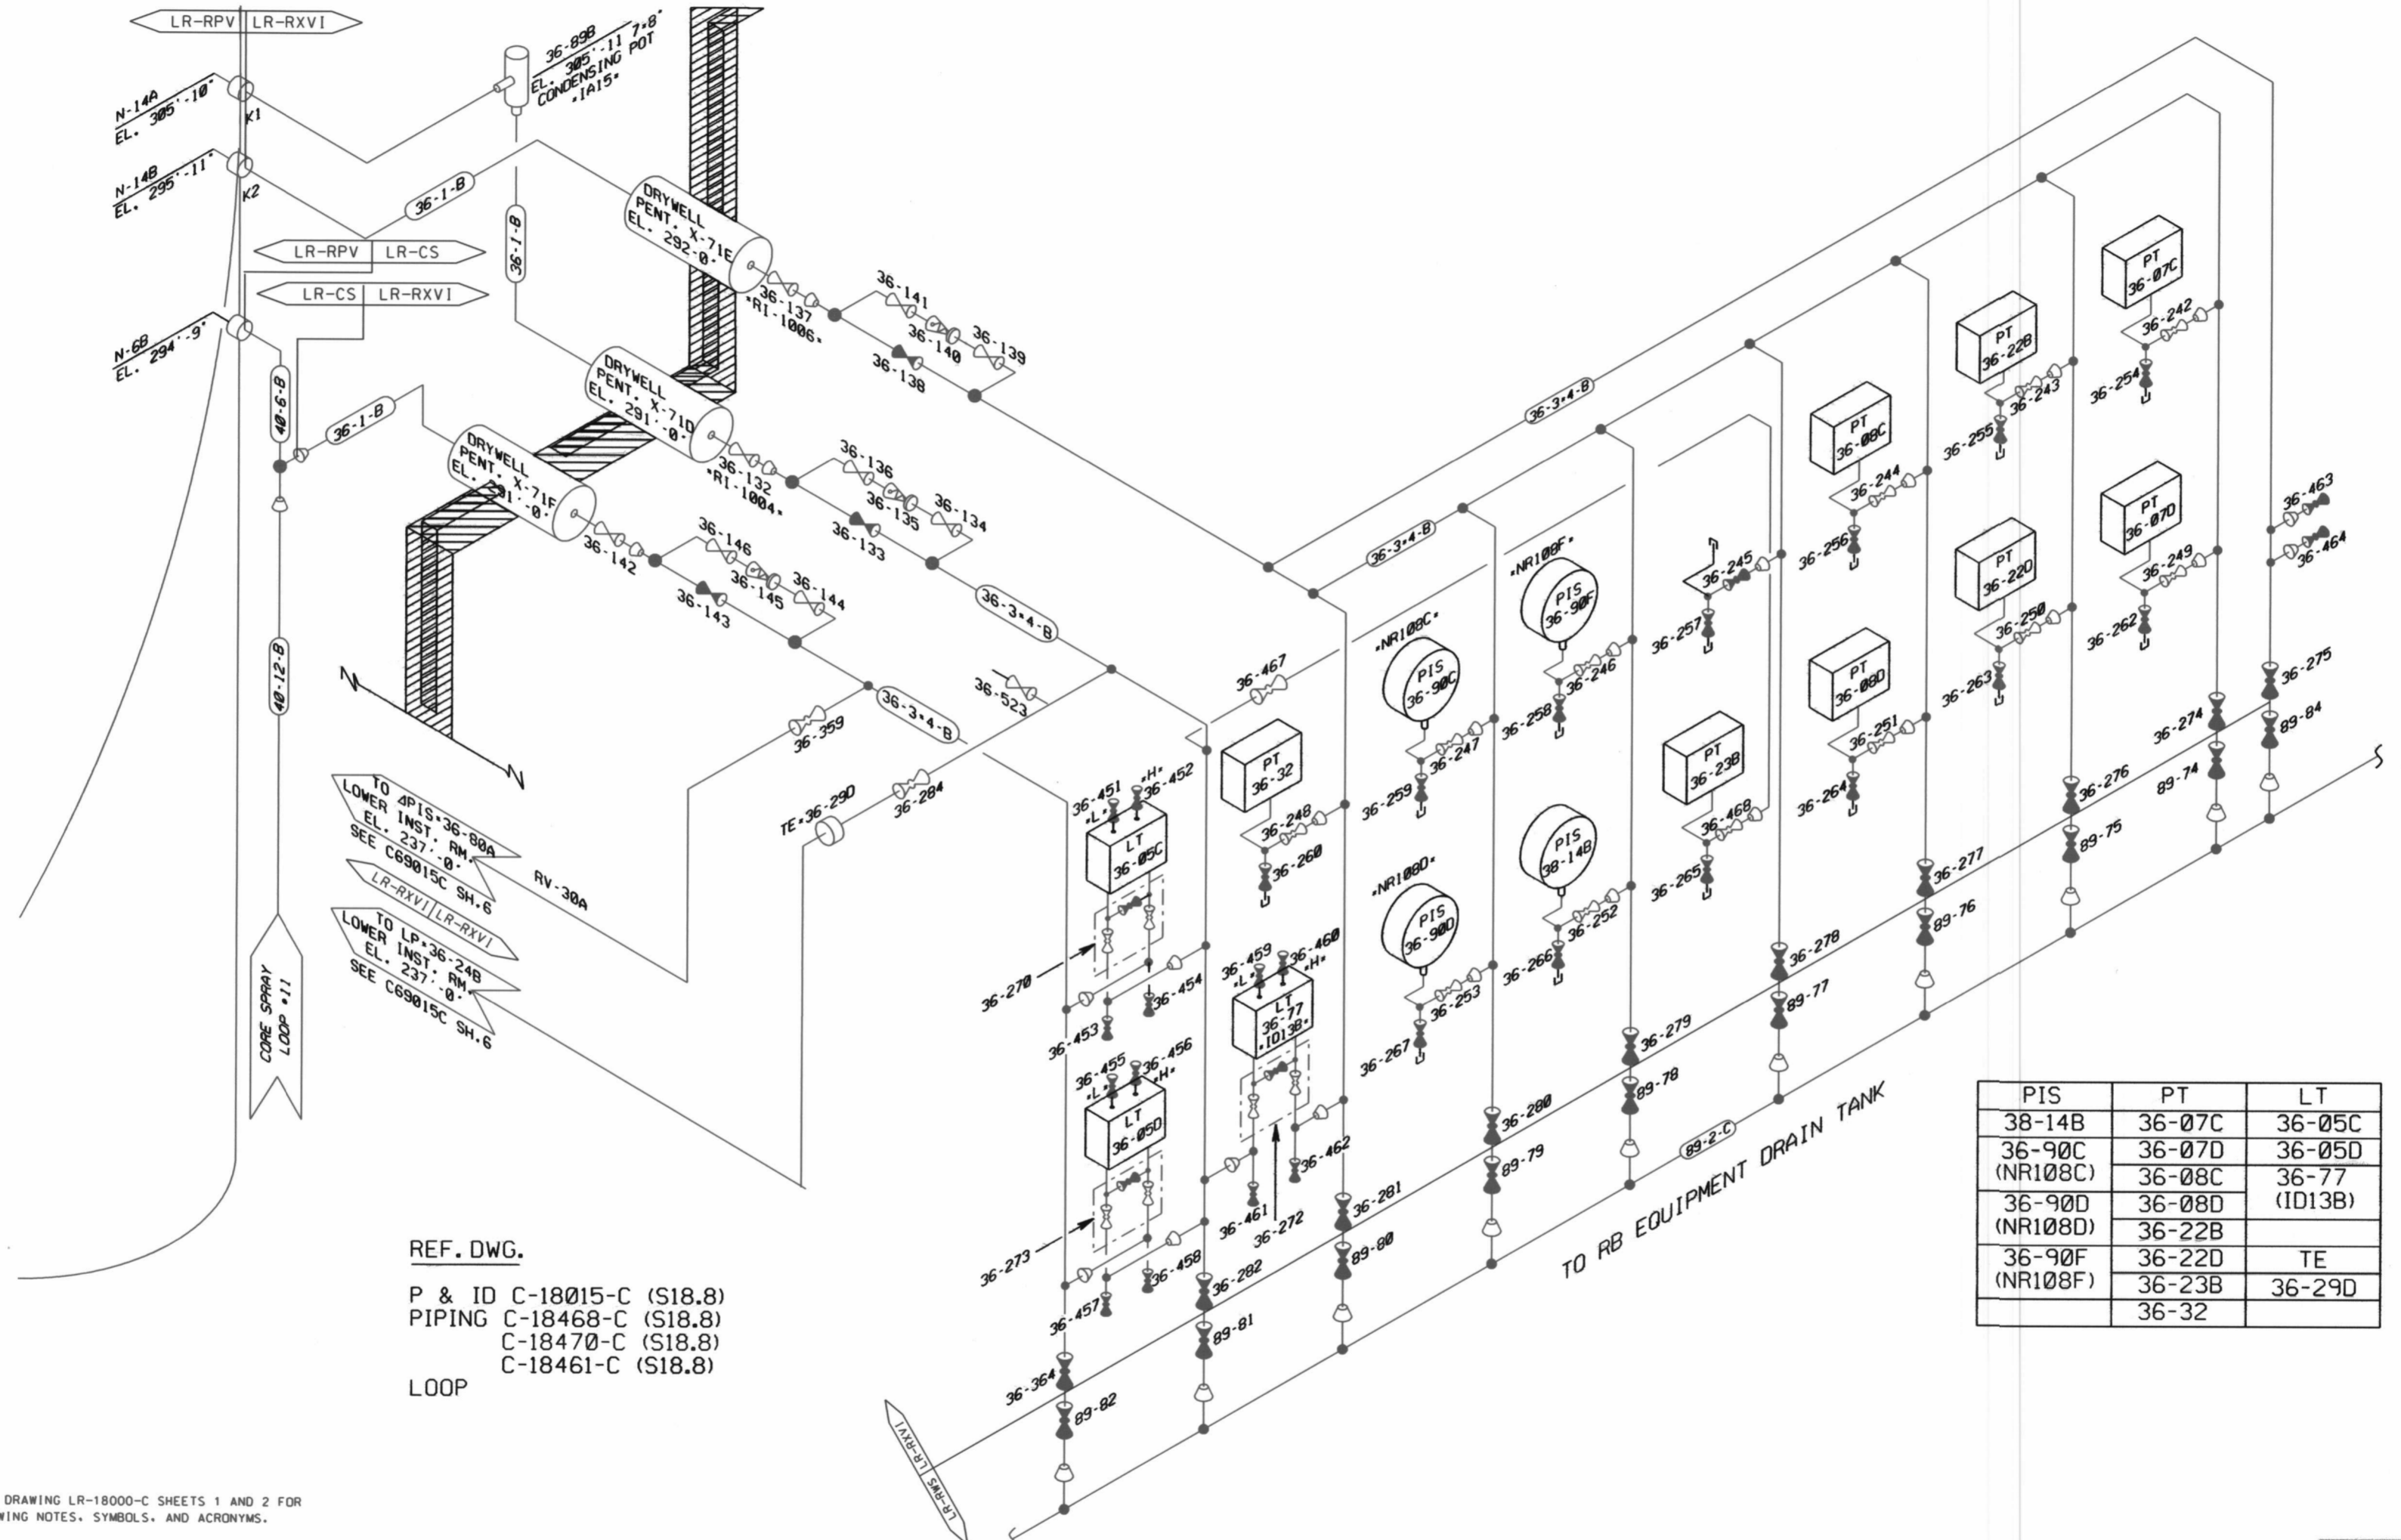

REF. DWG.
 P & ID C-18015-C (S18.8)
 PIPING C-18468-C (S18.8)
 C-18470-C (S18.8)
 LOOP C-18461-C (S18.8)

LR NOTE:
 PLEASE REFER TO DRAWING LR-18000-C SHEETS 1 AND 2 FOR
 LR BOUNDARY DRAWING NOTES, SYMBOLS, AND ACRONYMS.

PIS	PT	LT
38-14B	36-07C	36-05C
36-90C (NR108C)	36-07D	36-05D
36-90D (NR108D)	36-08C	36-77 (ID13B)
36-90F (NR108F)	36-22B	
	36-22D	TE
	36-23B	36-29D
	36-32	

NOTE: THIS DRAWING WAS CREATED USING
 COMPUTER AIDED DRAFTING
 DO NOT MAKE MANUAL CHANGES

CONSTELLATION ENERGY GROUP		NINE MILE POINT NUCLEAR STATION UNIT NO. 1	
APP	APP	REACTOR VESSEL LEVEL & PRESSURE	
APP	DATE	EAST INSTRUMENT ROOM	
DES	DATE	EL. 284'-0"	
INSTRUMENT DIAGRAM			
SCALE	DWG NO	INDEX	REV
NONE	LR-69015-C		5 0

0092