


0109

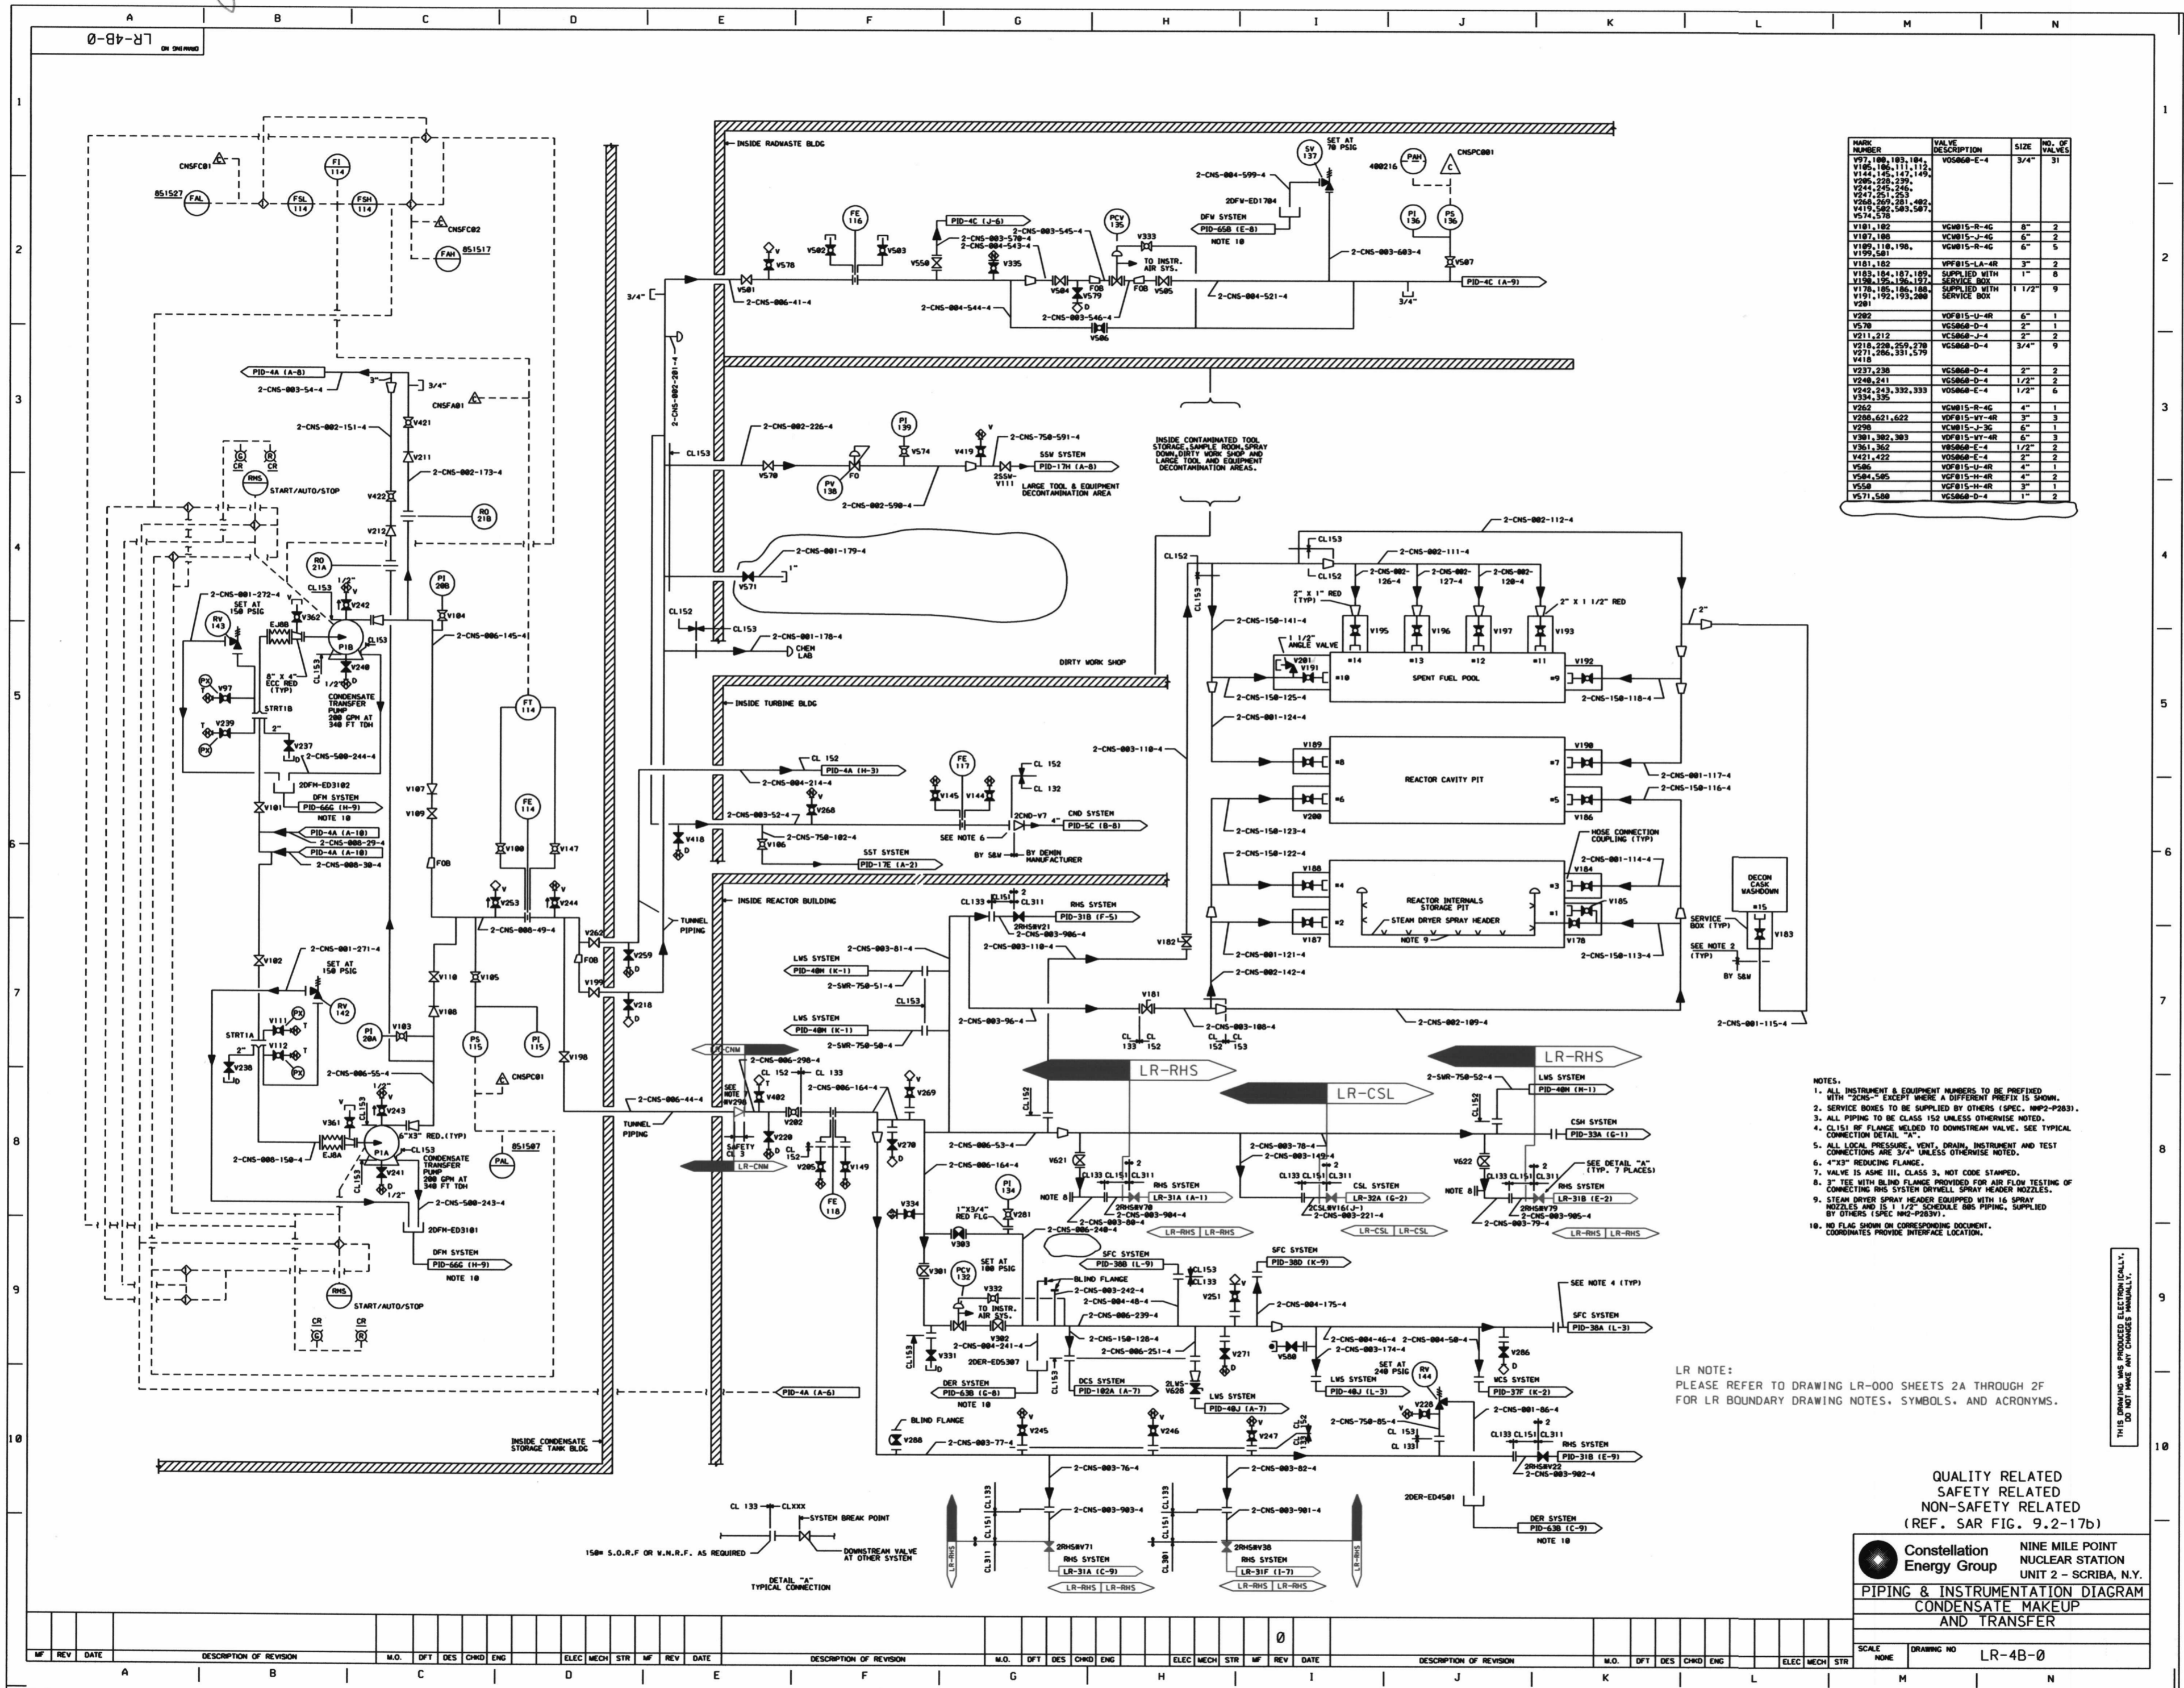

MARK NUMBER	VALVE DESCRIPTION	SIZE	NO. OF VALVES
V07, 100, 103, 104, 105, 106, 111, 112, 113, 114, 117, 149, 150, 151, 999, 1000.			

- NOTES:
1. ALL INSTRUMENT & EQUIPMENT NUMBERS TO BE PREFIXED WITH "2CHS-" EXCEPT WHERE A DIFFERENT PREFIX IS SHOWN.
 2. SERVICE BODIES TO BE SUPPLIED BY OTHERS (SPEC. INP2-P203).
 3. ALL PIPING TO BE CLASS 152 UNLESS OTHERWISE NOTED.
 4. CL151 OF FLANGE WELDED TO DOWNSTREAM FLETCH. SEE TYPICAL CONNECTION DETAIL "A".
 5. ALL LOCAL PRESSURE, VENT, DRAIN, INSTRUMENT AND TEST CONNECTIONS ARE 3/4" UNLESS OTHERWISE NOTED.
 6. 4"x3" REDUCING FLANGE.
 7. VALVE IS ASME III, CLASS 3, NOT CODE STAMPED.
 8. TEE WITH BLIND FLANGE PROVIDED FOR AIR FLOW TESTING OF CONNECTING RNS SYSTEM DRYWELL SPRAY HEADER MODULES.
 9. STEAM DRYER SPRAY HEADER EQUIPPED WITH 16 SPRAY NOZZLES AND IS 1 1/2" SCHEDULE 80S PIPING, SUPPLIED BY OTHERS (SPEC. INP2-P203).
 10. NO FLAG SHOWN ON CORRESPONDING DOCUMENT. COORDINATES PROVIDE INTERFACE LOCATION.

LR NOTE:
PLEASE REFER TO DRAWING LR-000 SHEETS 2A THROUGH 2F FOR LR BOUNDARY DRAWING NOTES, SYMBOLS, AND ACRONYMS.

QUALITY RELATED
SAFETY RELATED
NON-SAFETY RELATED
(REF. SAR FIG. 9.2-17b)

Constellation Energy Group
NINE MILE POINT NUCLEAR STATION
UNIT 2 - SCRIBA, N.Y.

PIPING & INSTRUMENTATION DIAGRAM
CONDENSATE MAKEUP AND TRANSFER

SCALE	DRAWING NO	LR-4B-0
-------	------------	---------

NO.	REV.	DATE	DESCRIPTION OF REVISION	M.O.	DFT	DES	CHRD	ENG	ELEC	MECH	STR	NO.	REV.	DATE	DESCRIPTION OF REVISION	M.O.	DFT	DES	CHRD	ENG	ELEC	MECH	STR

D-109