

 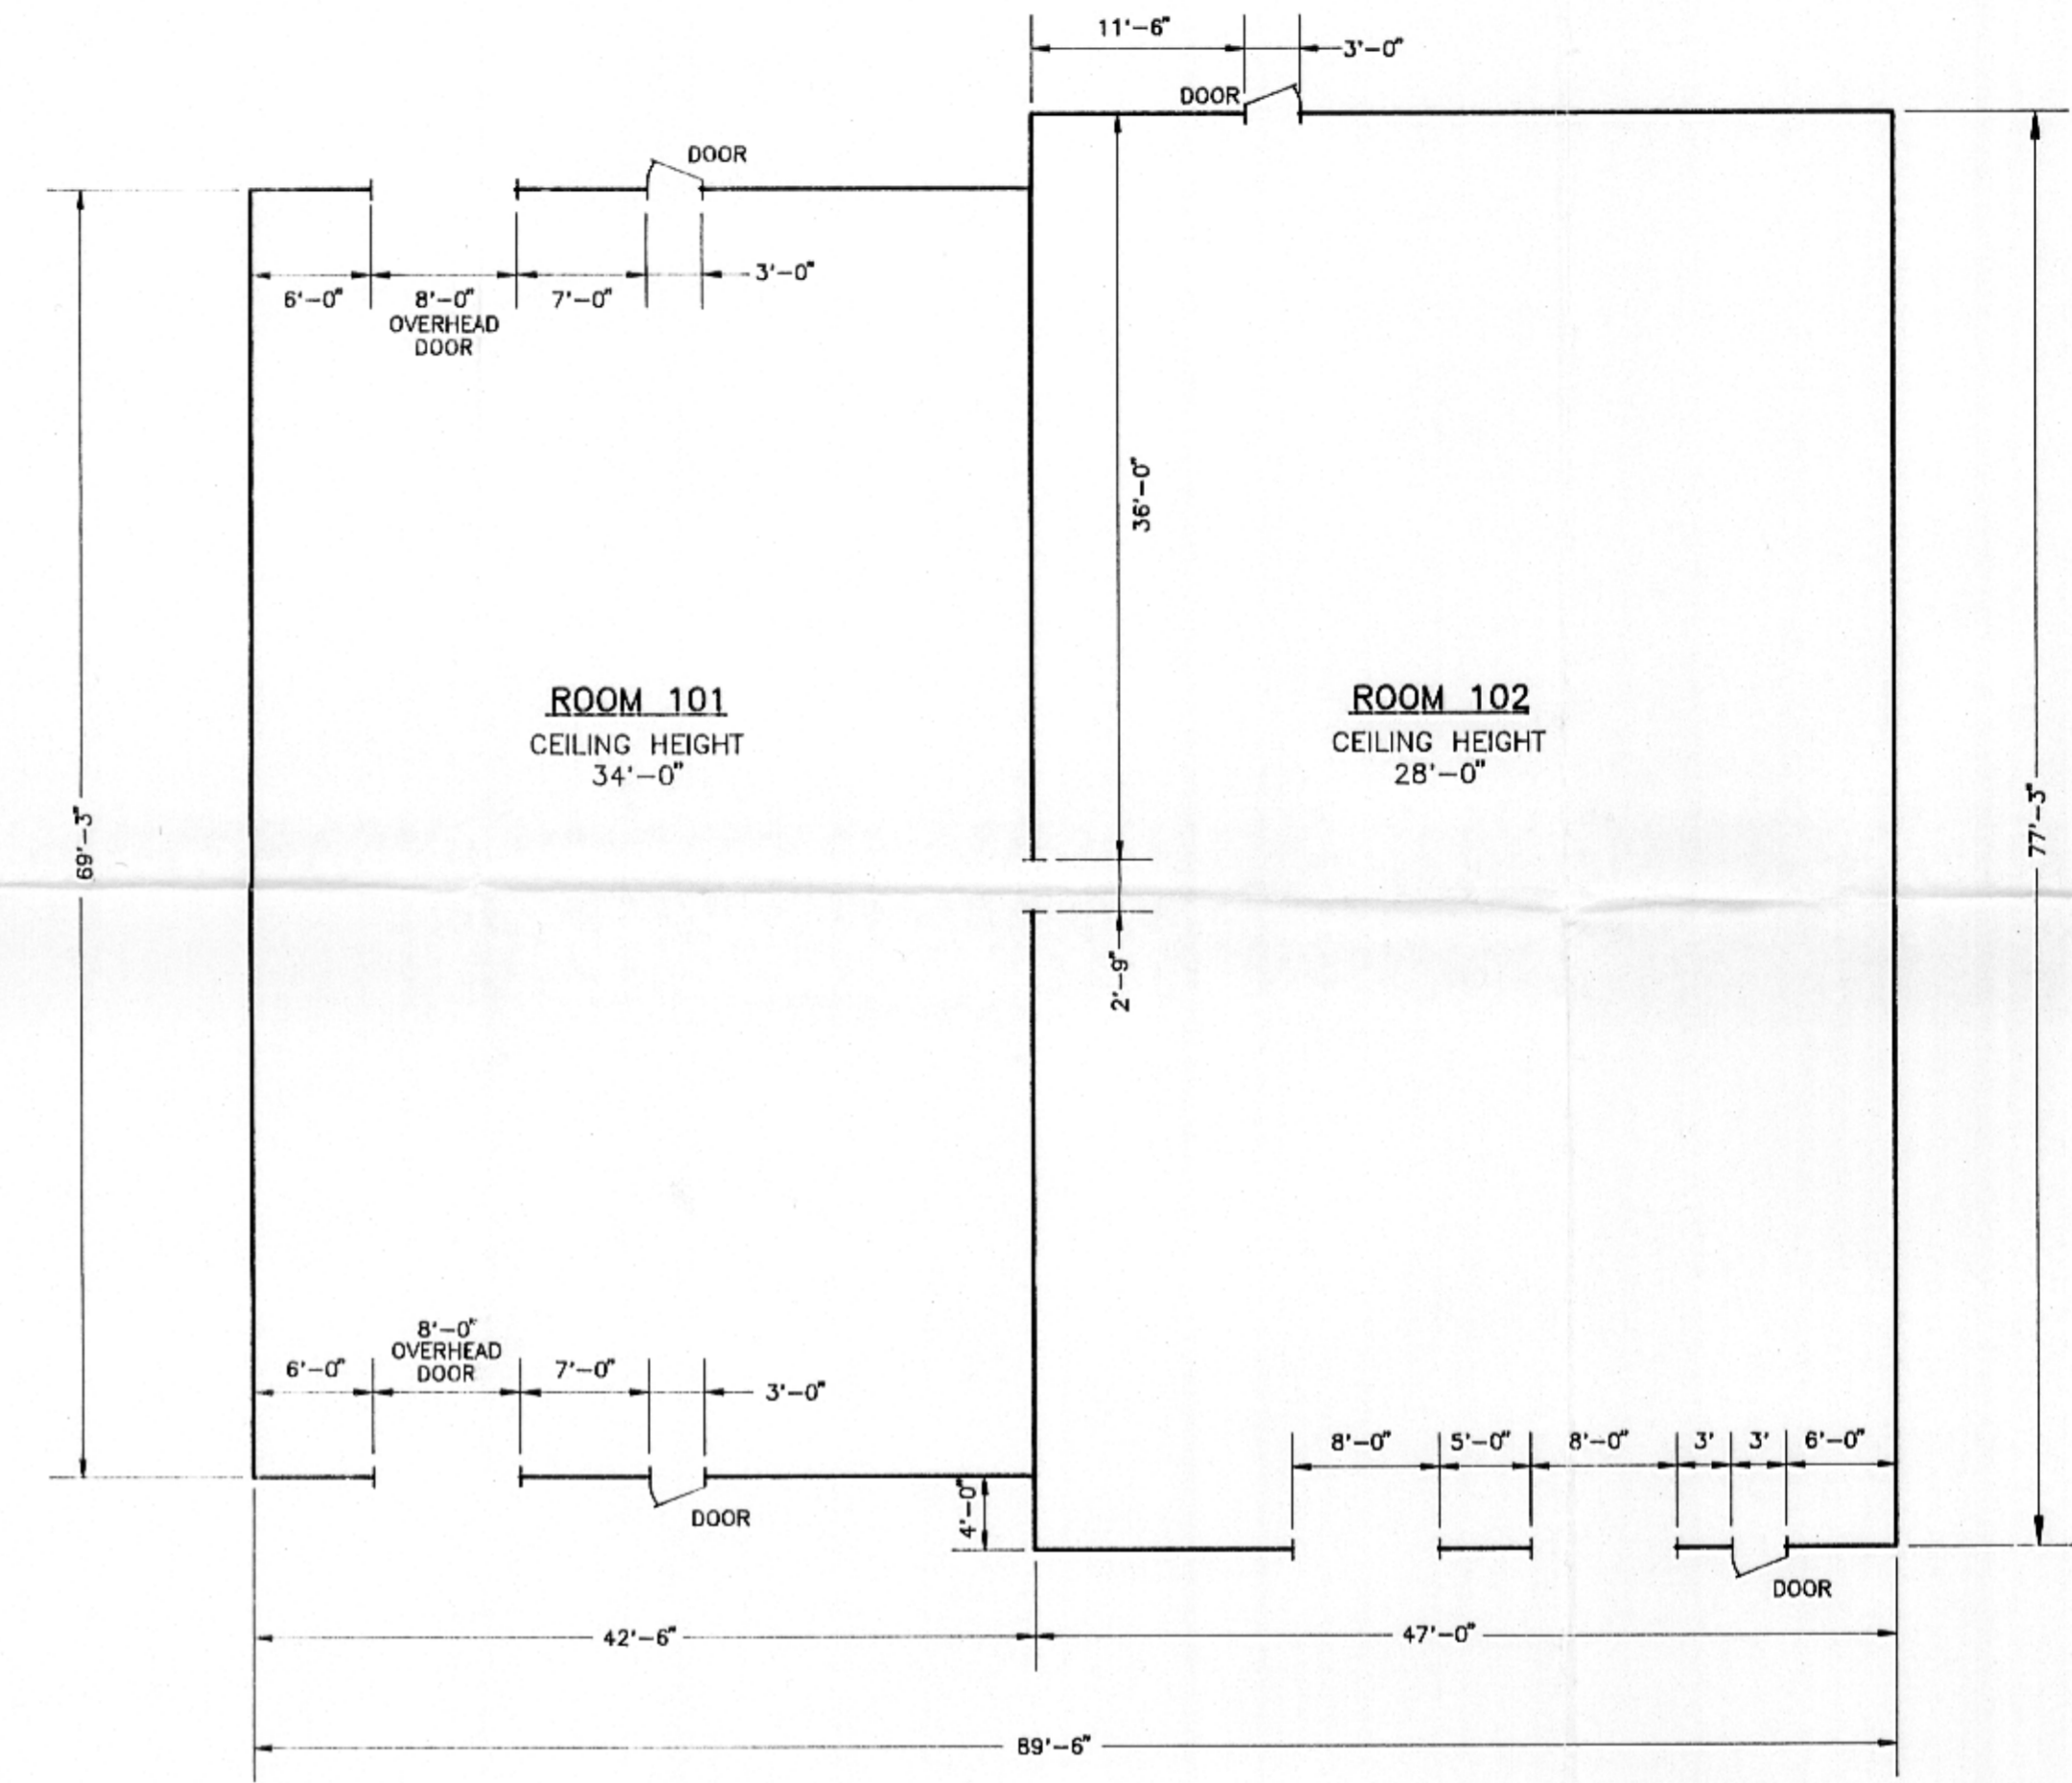


BUILDING 11
SODIUM REDUCTION BUILDING

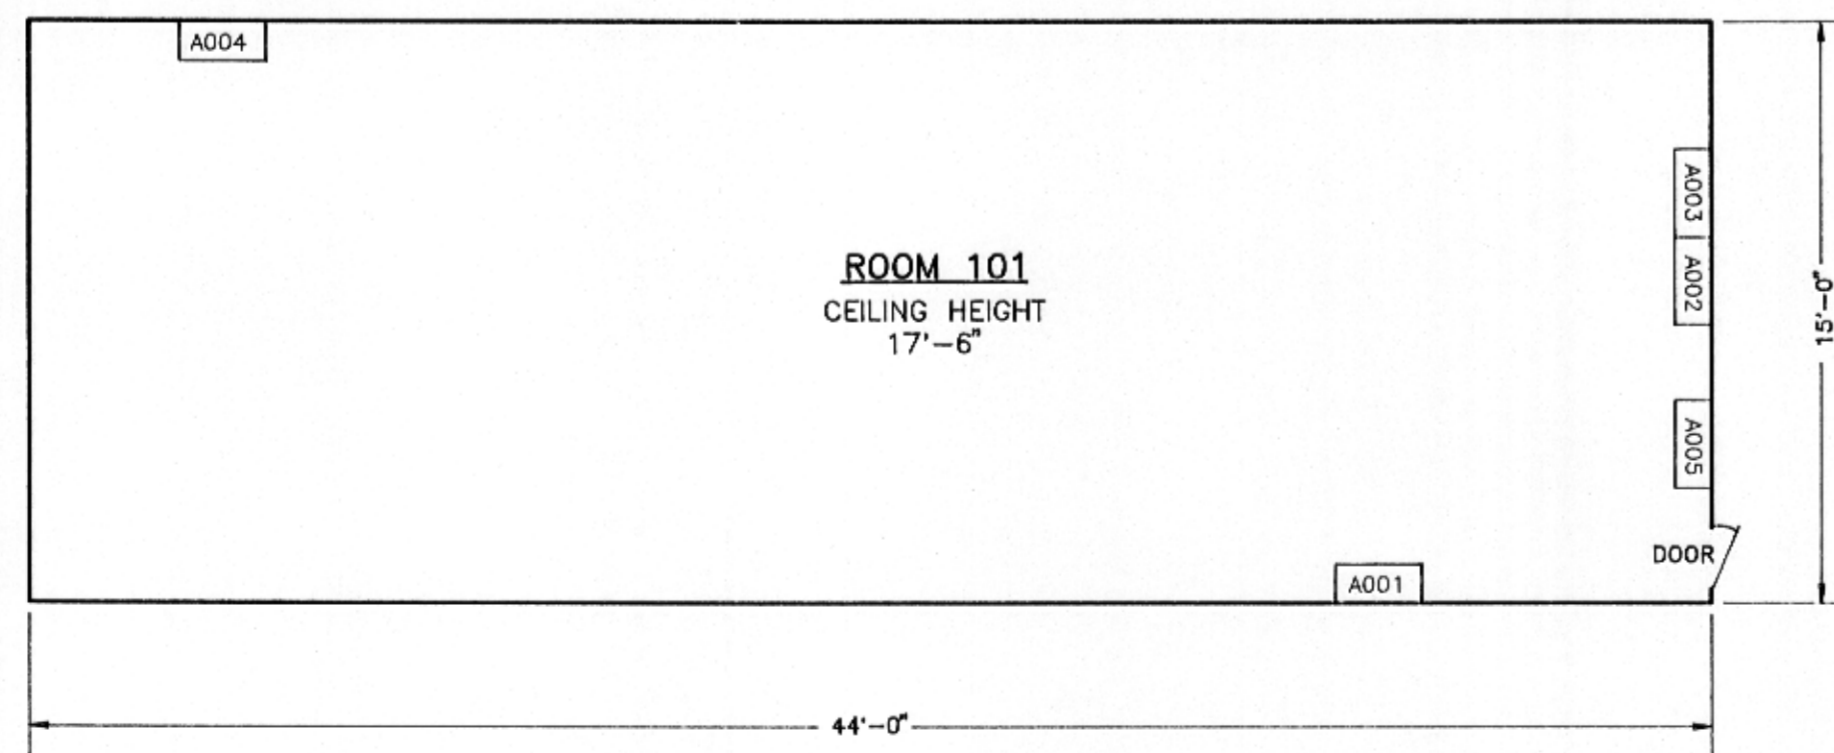


BUILDING 13
CHEM "C" BUILDING



BUILDING 12
LITTLE BERTHA



ANSTEC
APERTURE
CARD

REVISION	DATE	DESCRIPTION
FIGURE D-3 BUILDINGS 11, 12 AND 13 FLOOR PLANS FANSTEEL, INC. MUSKOGEE, OKLAHOMA		
PREPARED FOR KIRKPATRICK & LOCKHART PITTSBURGH, PENNSYLVANIA		
APPROVED	JWH 12/27/93	
CHECKED	CLS 12/27/93	
DRAWN	JWK/110483	
DRAWING NUMBER		
0111-528		
		 Earth Sciences Consultants, Inc.

9402030173 D-03