


Legend

- NFEP2 Earth Probe & Hand Boring ID
- Earth Probe Location
- 215 Monitoring Well ID
- Monitoring Well Location
- West Well Drinking Water Well ID
- ⊗ Drinking Water Well
- ▨ Recognized Environmental Condition Areas
- Property Line
- - - - - Subject Property Perimeter Fence
- River Shoreline
- ⊠ Transmission Towers

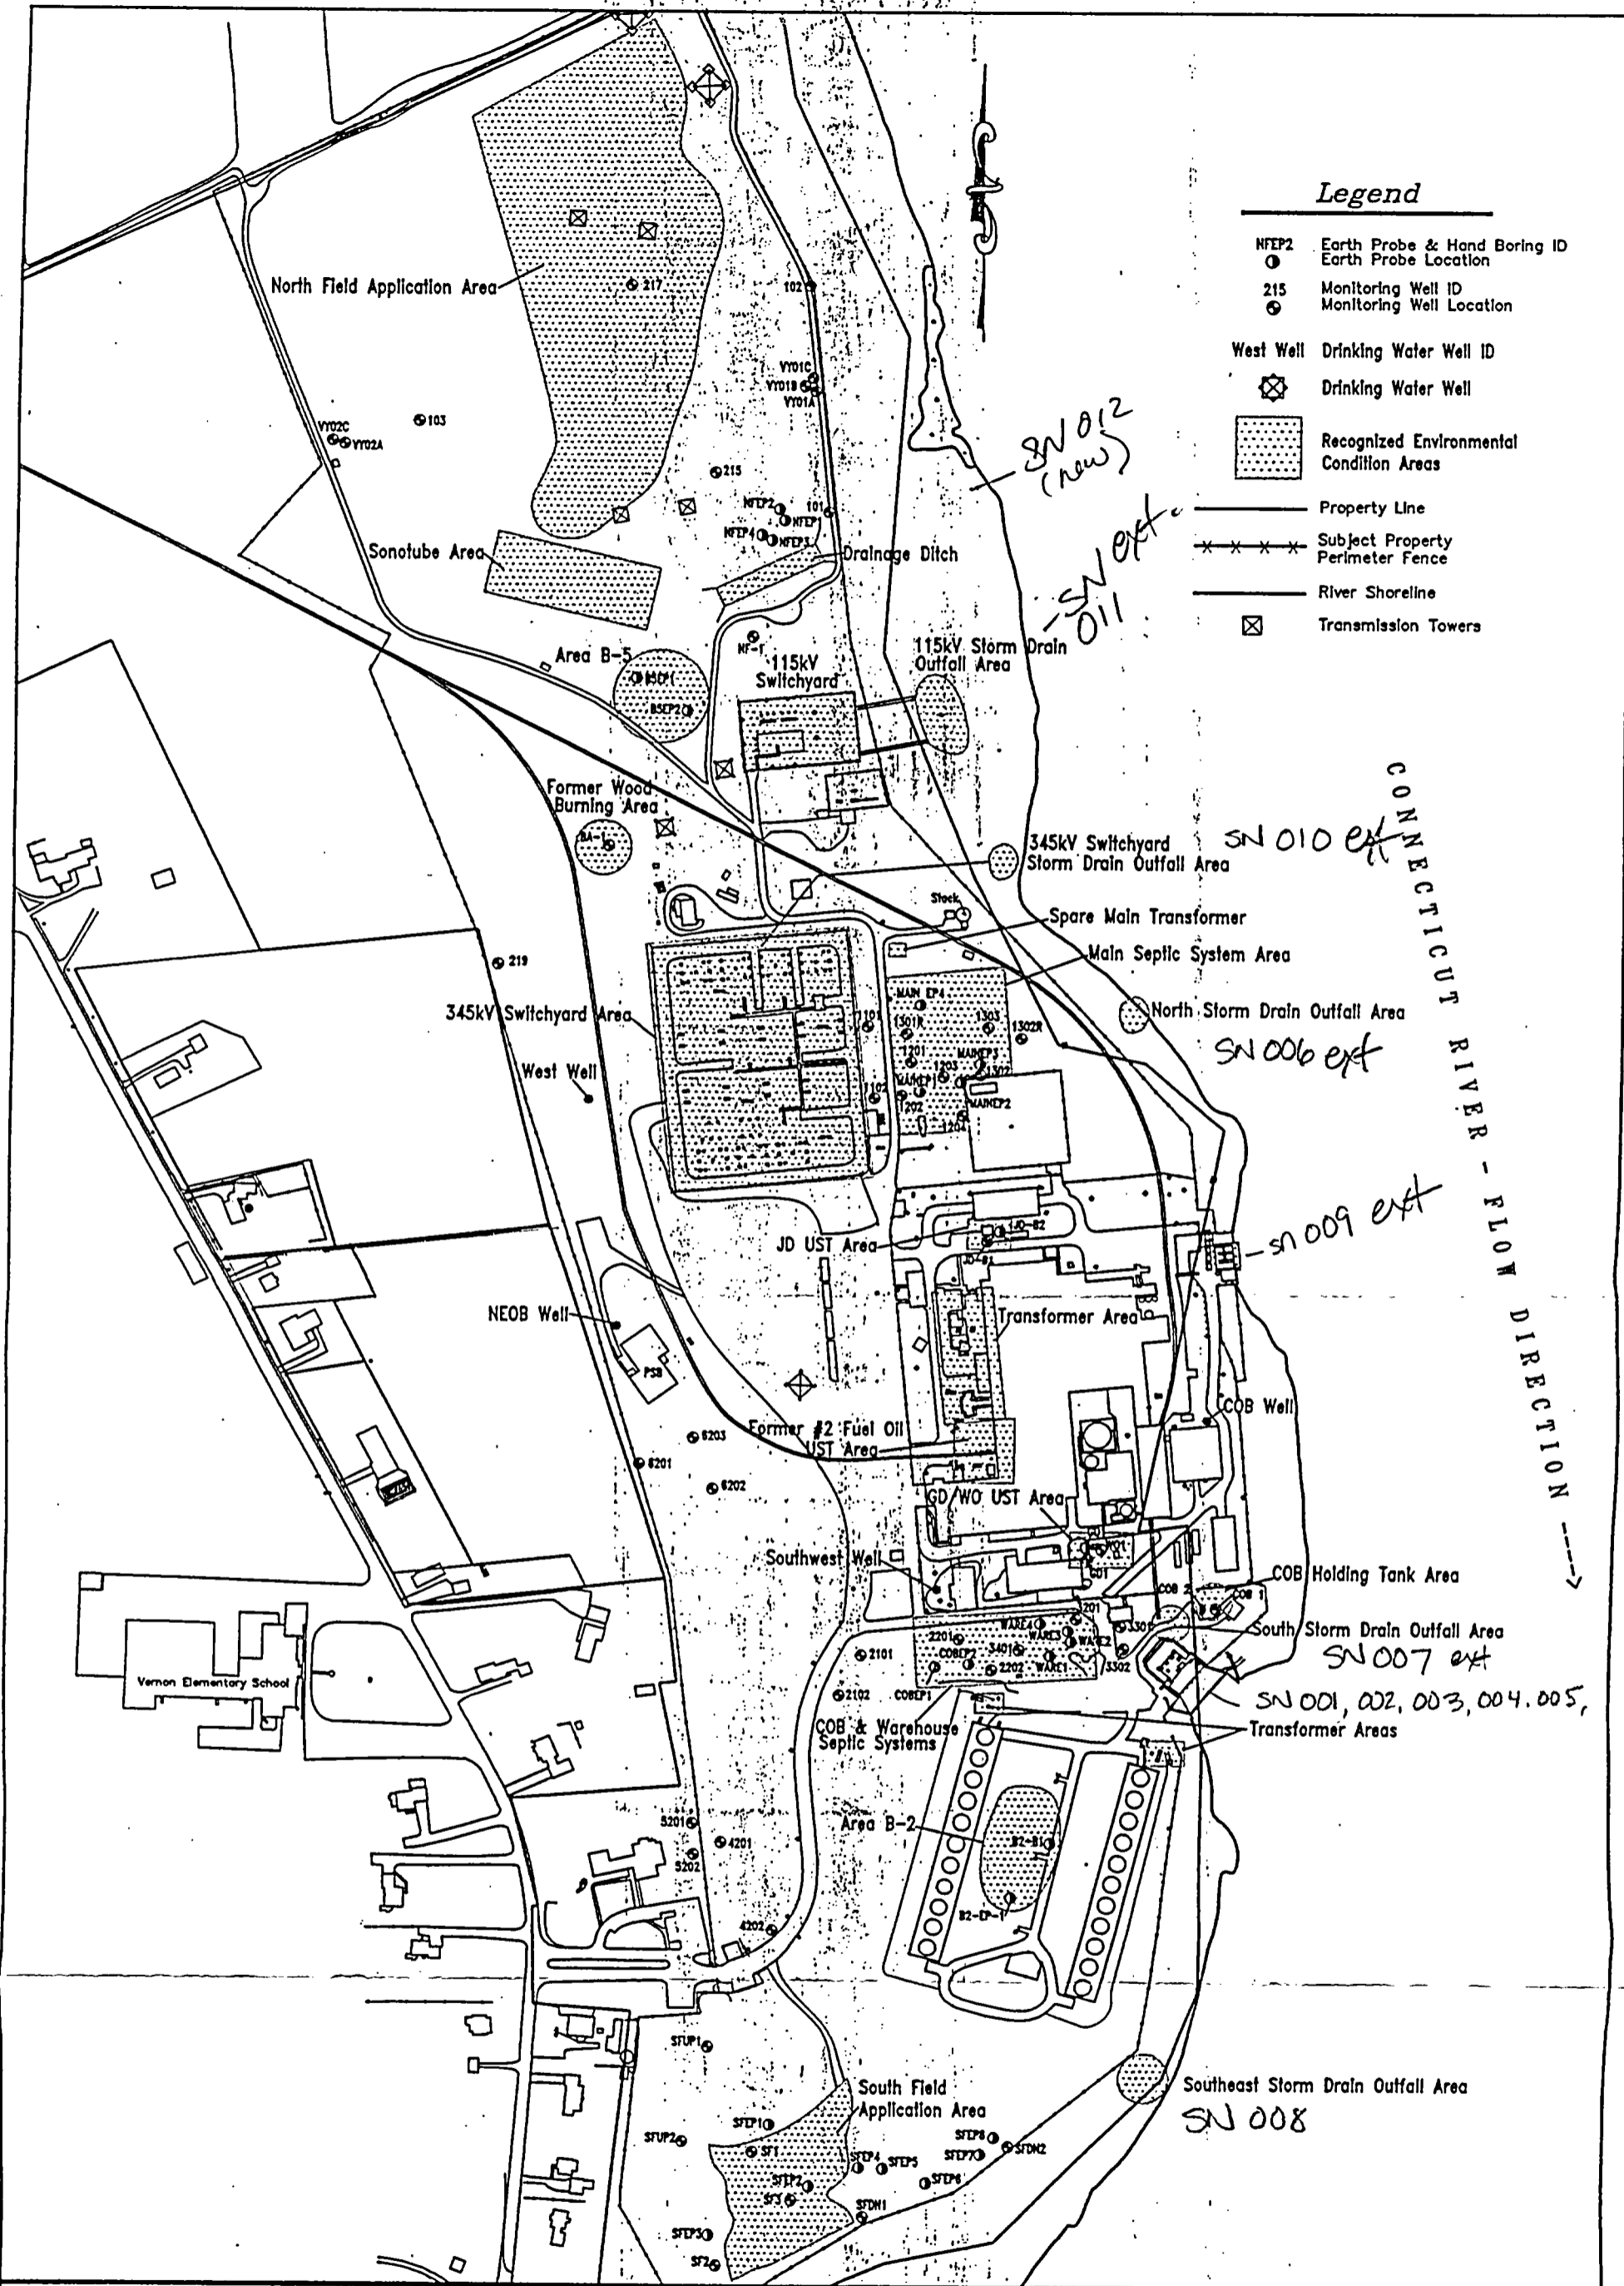

ENVIRONMENTAL COMPLIANCE SERVICES, INC.
30 Harris Place • Brattleboro, VT 05301

GRAPHIC SCALE:
0 150 300

PROJECT:
Vermont Yankee Nuclear Power Corporation
Governor Hunt Road
Vernon, Vermont 05354

TITLE:
Site Plan - Recognized Environmental Conditions

CADFILE: 40320_300sc.dwg			
DRAWN BY:	DESIGNED BY:	CHECKED BY:	APPROVED BY:
CS	SVE	FJS	FJS
SCALE:	DATE:	JOB NO.:	FIGURE NO.:
1" = 300'	May 2001	40320	3