


RELEASE POINT LOCATION FOR UNIT 2 LOW PRESSURE TURBINES

RELEASE POINT LOCATION FOR UNIT 1 LOW PRESSURE TURBINES

NEW OUTSIDE AIR INTAKE LOCATION  
BOTTOM ELEVATION OF AIR INTAKE EL. 81'-3"  
INTAKE Q. 2-3 WEST OF COLUMN W

LOCATION OF SGTS AND UNIT 1 & 2 TURBINE BUILDING EXHAUST VENTS, ELEVATION 87'-8 1/2".  
SEE ATTACHMENT 1 TO THE 11/24/2006 RESPONSE TO REQUEST FOR ADDITIONAL INFORMATION FOR DIMENSIONS FOR PLANT VENT RELEASE LOCATIONS.

REFERENCE DRAWINGS		
A-105	E105023	CONTROL ROOM
A-106	E105049	STAIR NO. 101
A-107	E105051	" NO. 102
A-108	E105048	" NO. 100 & ELEVATOR
A-109	E105045	" NO. 101 & 102
A-110	E105046	" NO. 201
A-111	E105047	" NO. 202 & ELEVATOR
A-112	E105048	" NO. 201, 202 & ELEVATOR
A-113	E105049	" NO. 201 & 202
A-114	E105047	" NO. 205
A-115	E105046	STAIR SCHEDULE
A-116	E105045	GENERAL CROSS SECTION
A-117	E105044	DOOR SCHEDULE
A-118	E105043	FINISH SCHEDULE
A-119	E105042	FIRE PROTECTION DWG
A-120	E105041	EMERGENCY PERSONNEL DECONTAMINATION STATION
A-121	E105040	STAIR NO. 100 & 200

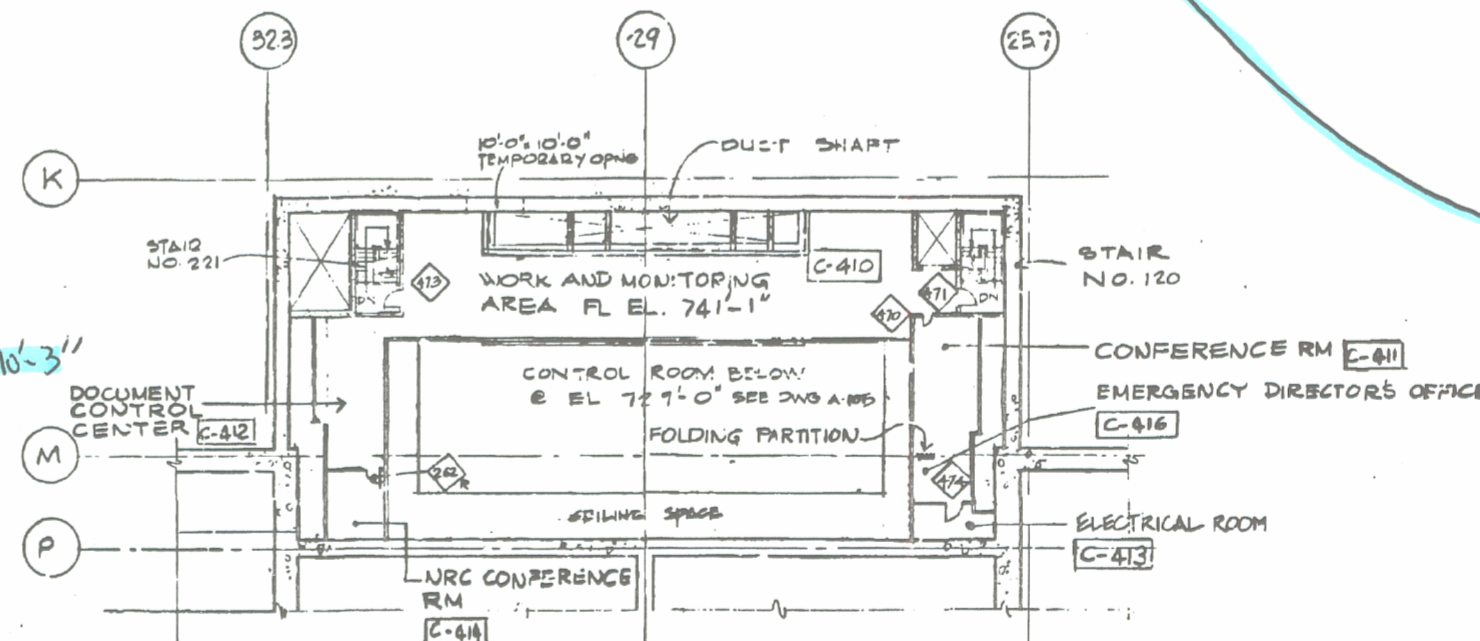

PLAN - TECHNICAL SUPPORT CENTER  
@ EL 741'-1"  
NOTE: SEE DWG A-105 FOR LARGE SCALE PLAN

REV	DESCRIPTION	DATE	BY	CHKD	APP'D
25	INCORP. IDCN & (ECC) 434714	11/24/06	BR/LOH	Y&M	

SUSQUEHANNA S. E. S.  
UNIT 1 & 2  
GENERAL FLOOR PLANS  
EL. 719'-1" & 729'-0"

AREA	N/A	ELEV	SCALE	1"=20'
PPL DRAWING NO.	E105004	SHEET NO.	4	REV. NO.
AE DRAWING NO.	A-14	SHEET NO.	1	25

D-01X