


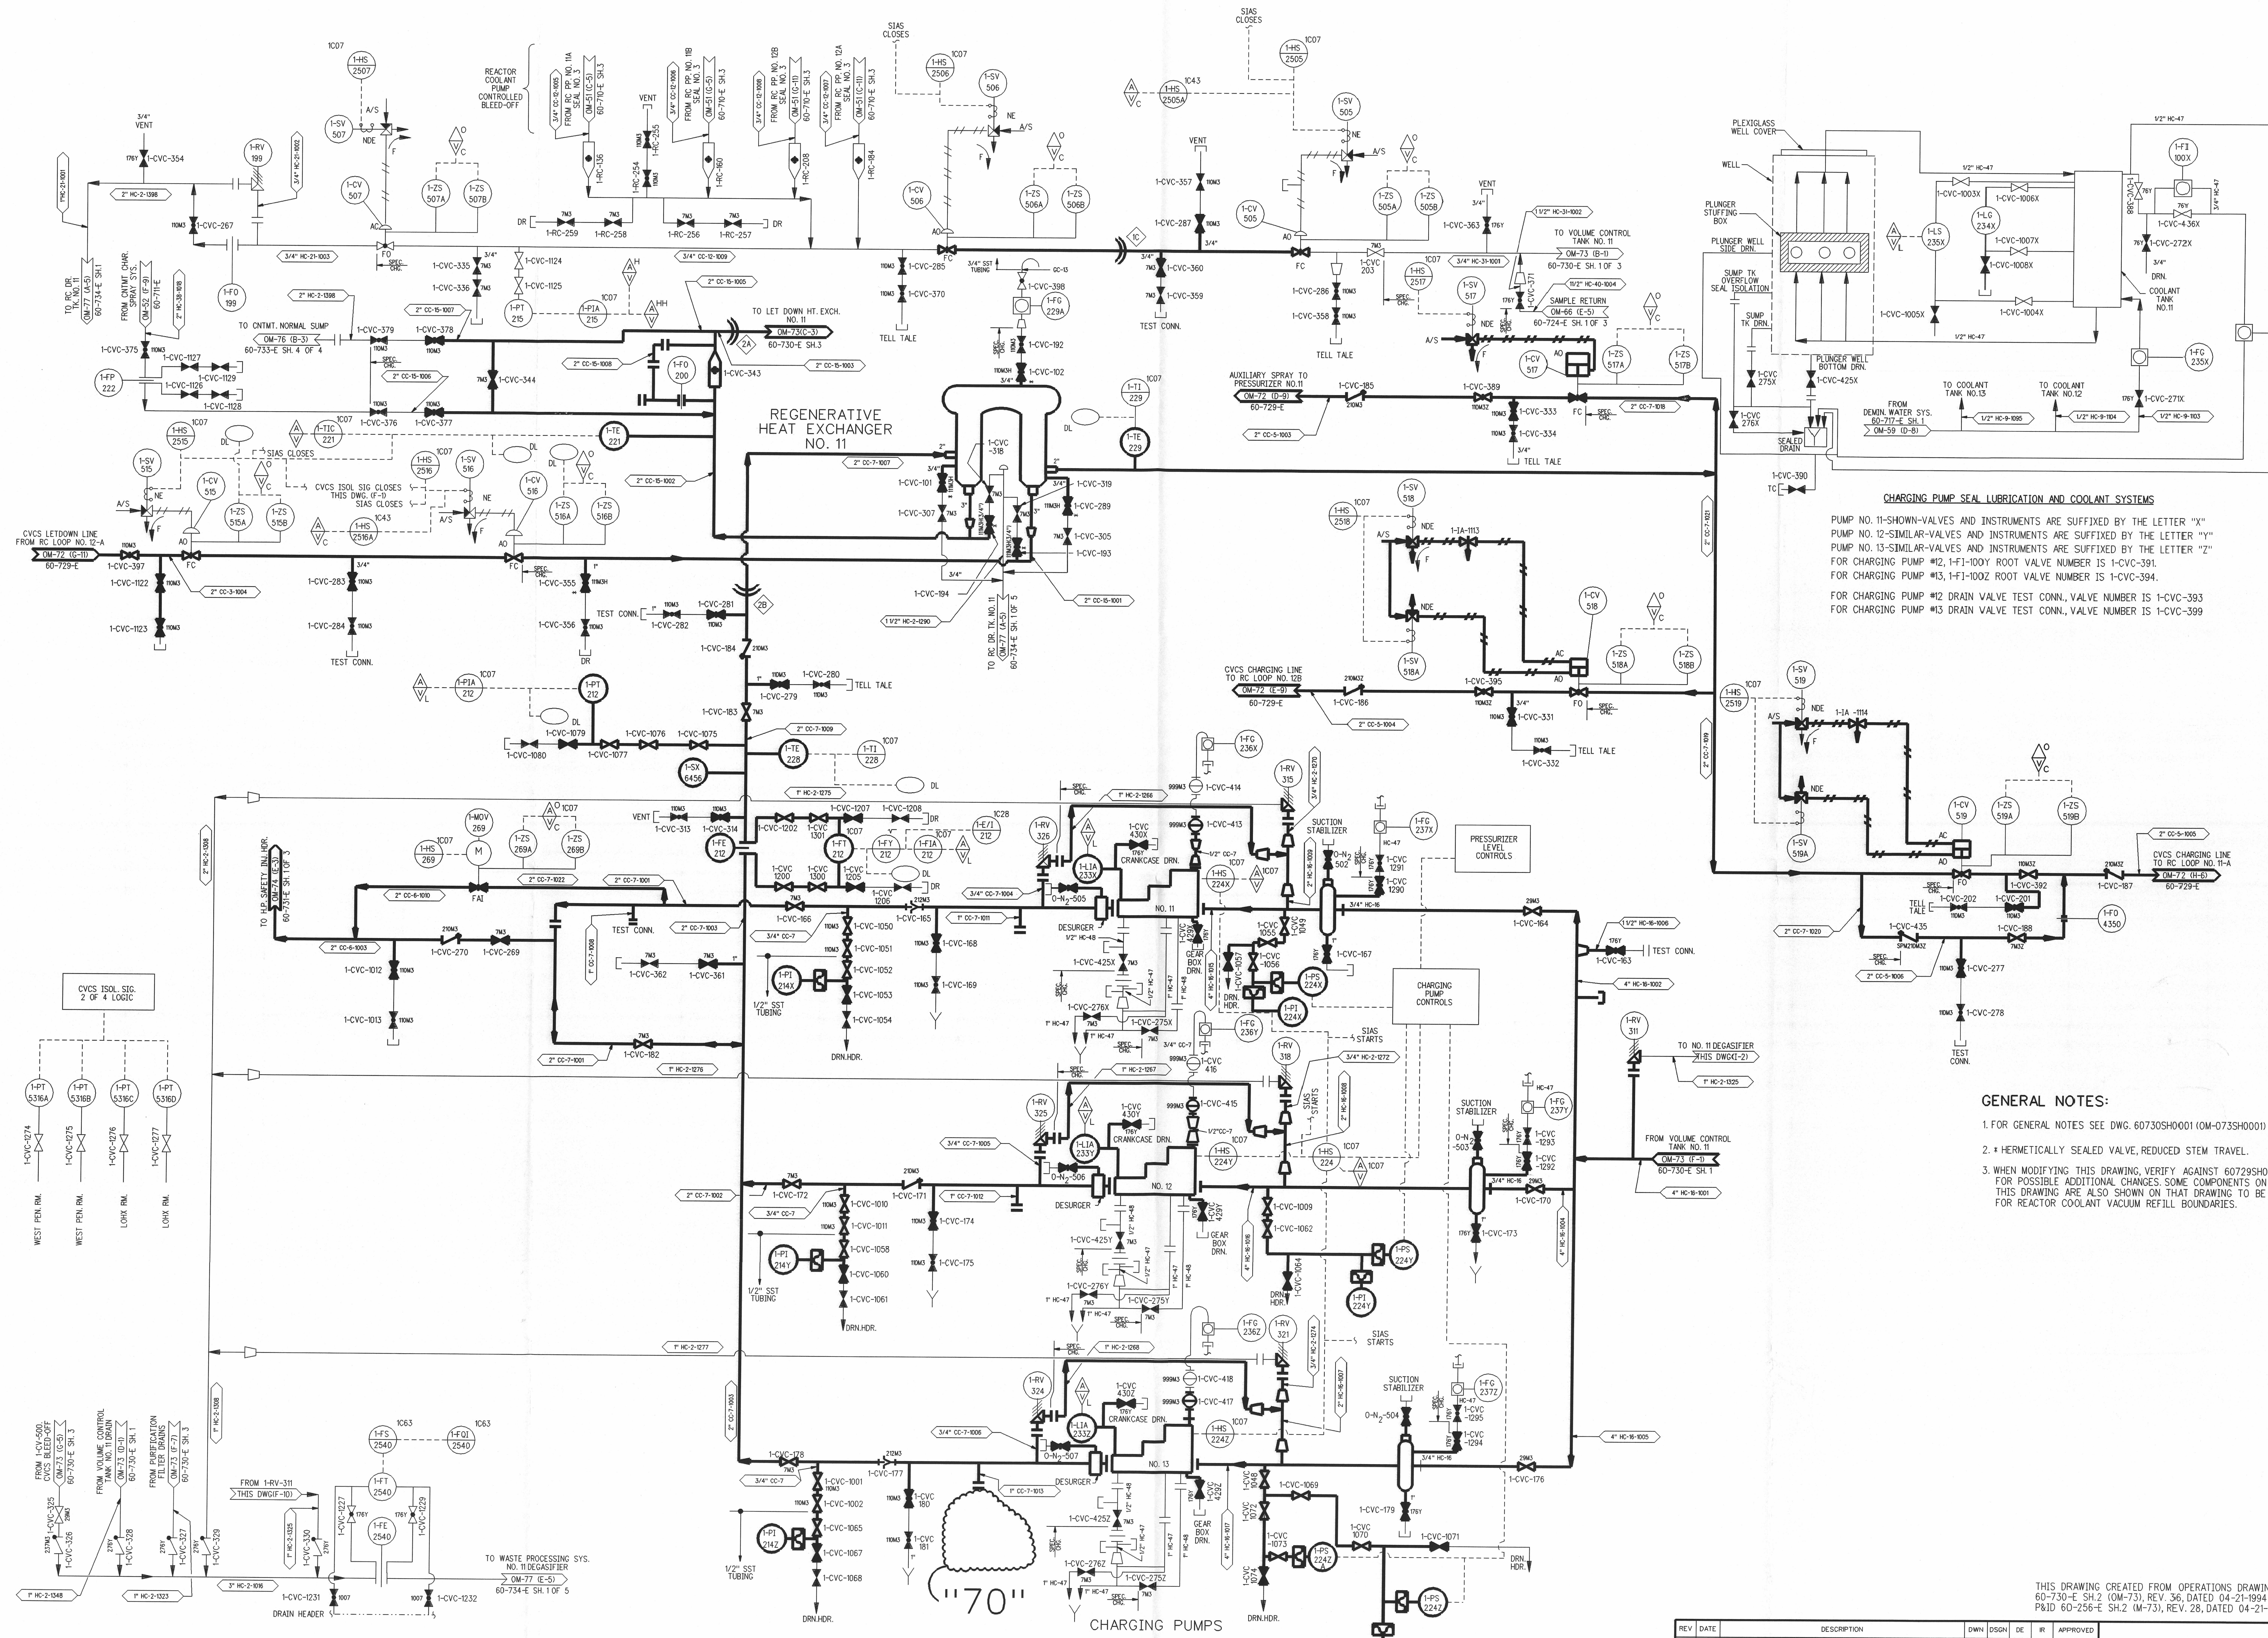

THIS DRAWING CREATED FROM OPERATIONS DRAWING
60-730-E SH.2 (OM-73), REV. 36, DATED 04-21-1994 &
P&ID 60-256-E SH.2 (M-73), REV. 28, DATED 04-21-1994.

REV	DATE	DESCRIPTION	OWN	DSGN	DE	APPROVED
66	4/7/93	AS BUILT DCN 60730SH0002-2008SH0001 ES2004000040-000	WHR	REL	-	REL
67	5/8/93	AS BUILT DCN 60730SH0002-2009SH0001 ES200200663-000	WHR	REL	-	REL
68	11/30/96	AS BUILT DCN 60730SH0002-2010SH0001 ES200400451-000	WHR	REL	-	REL
69	6/6/96	AS BUILT DCN 60730SH0002-2009SH0002 ES200200663-000	WHR	REL	-	REL
70	8/2/96	AS BUILT DCN 60730SH0002-2009SH0003 ES200200663-000	WHR	REL	-	REL

CHEMICAL AND VOLUME CONTROL SYSTEM

CALVERT CLIFFS NUCLEAR POWER PLANT
ENGINEERING SERVICES DEPARTMENT
CALVERT CLIFFS UNIT 1

SCALE: NONE
DWG. NO. 60730SH0002
REV. 70