


GENERAL NOTES:

1. FOR GENERAL NOTES SEE DRAWING 62-467-E SH.1.

MATCH LINE SEE DWG. 62-467-E SH.1

1A-GENERATOR

© 1A2-ENGINE SKID

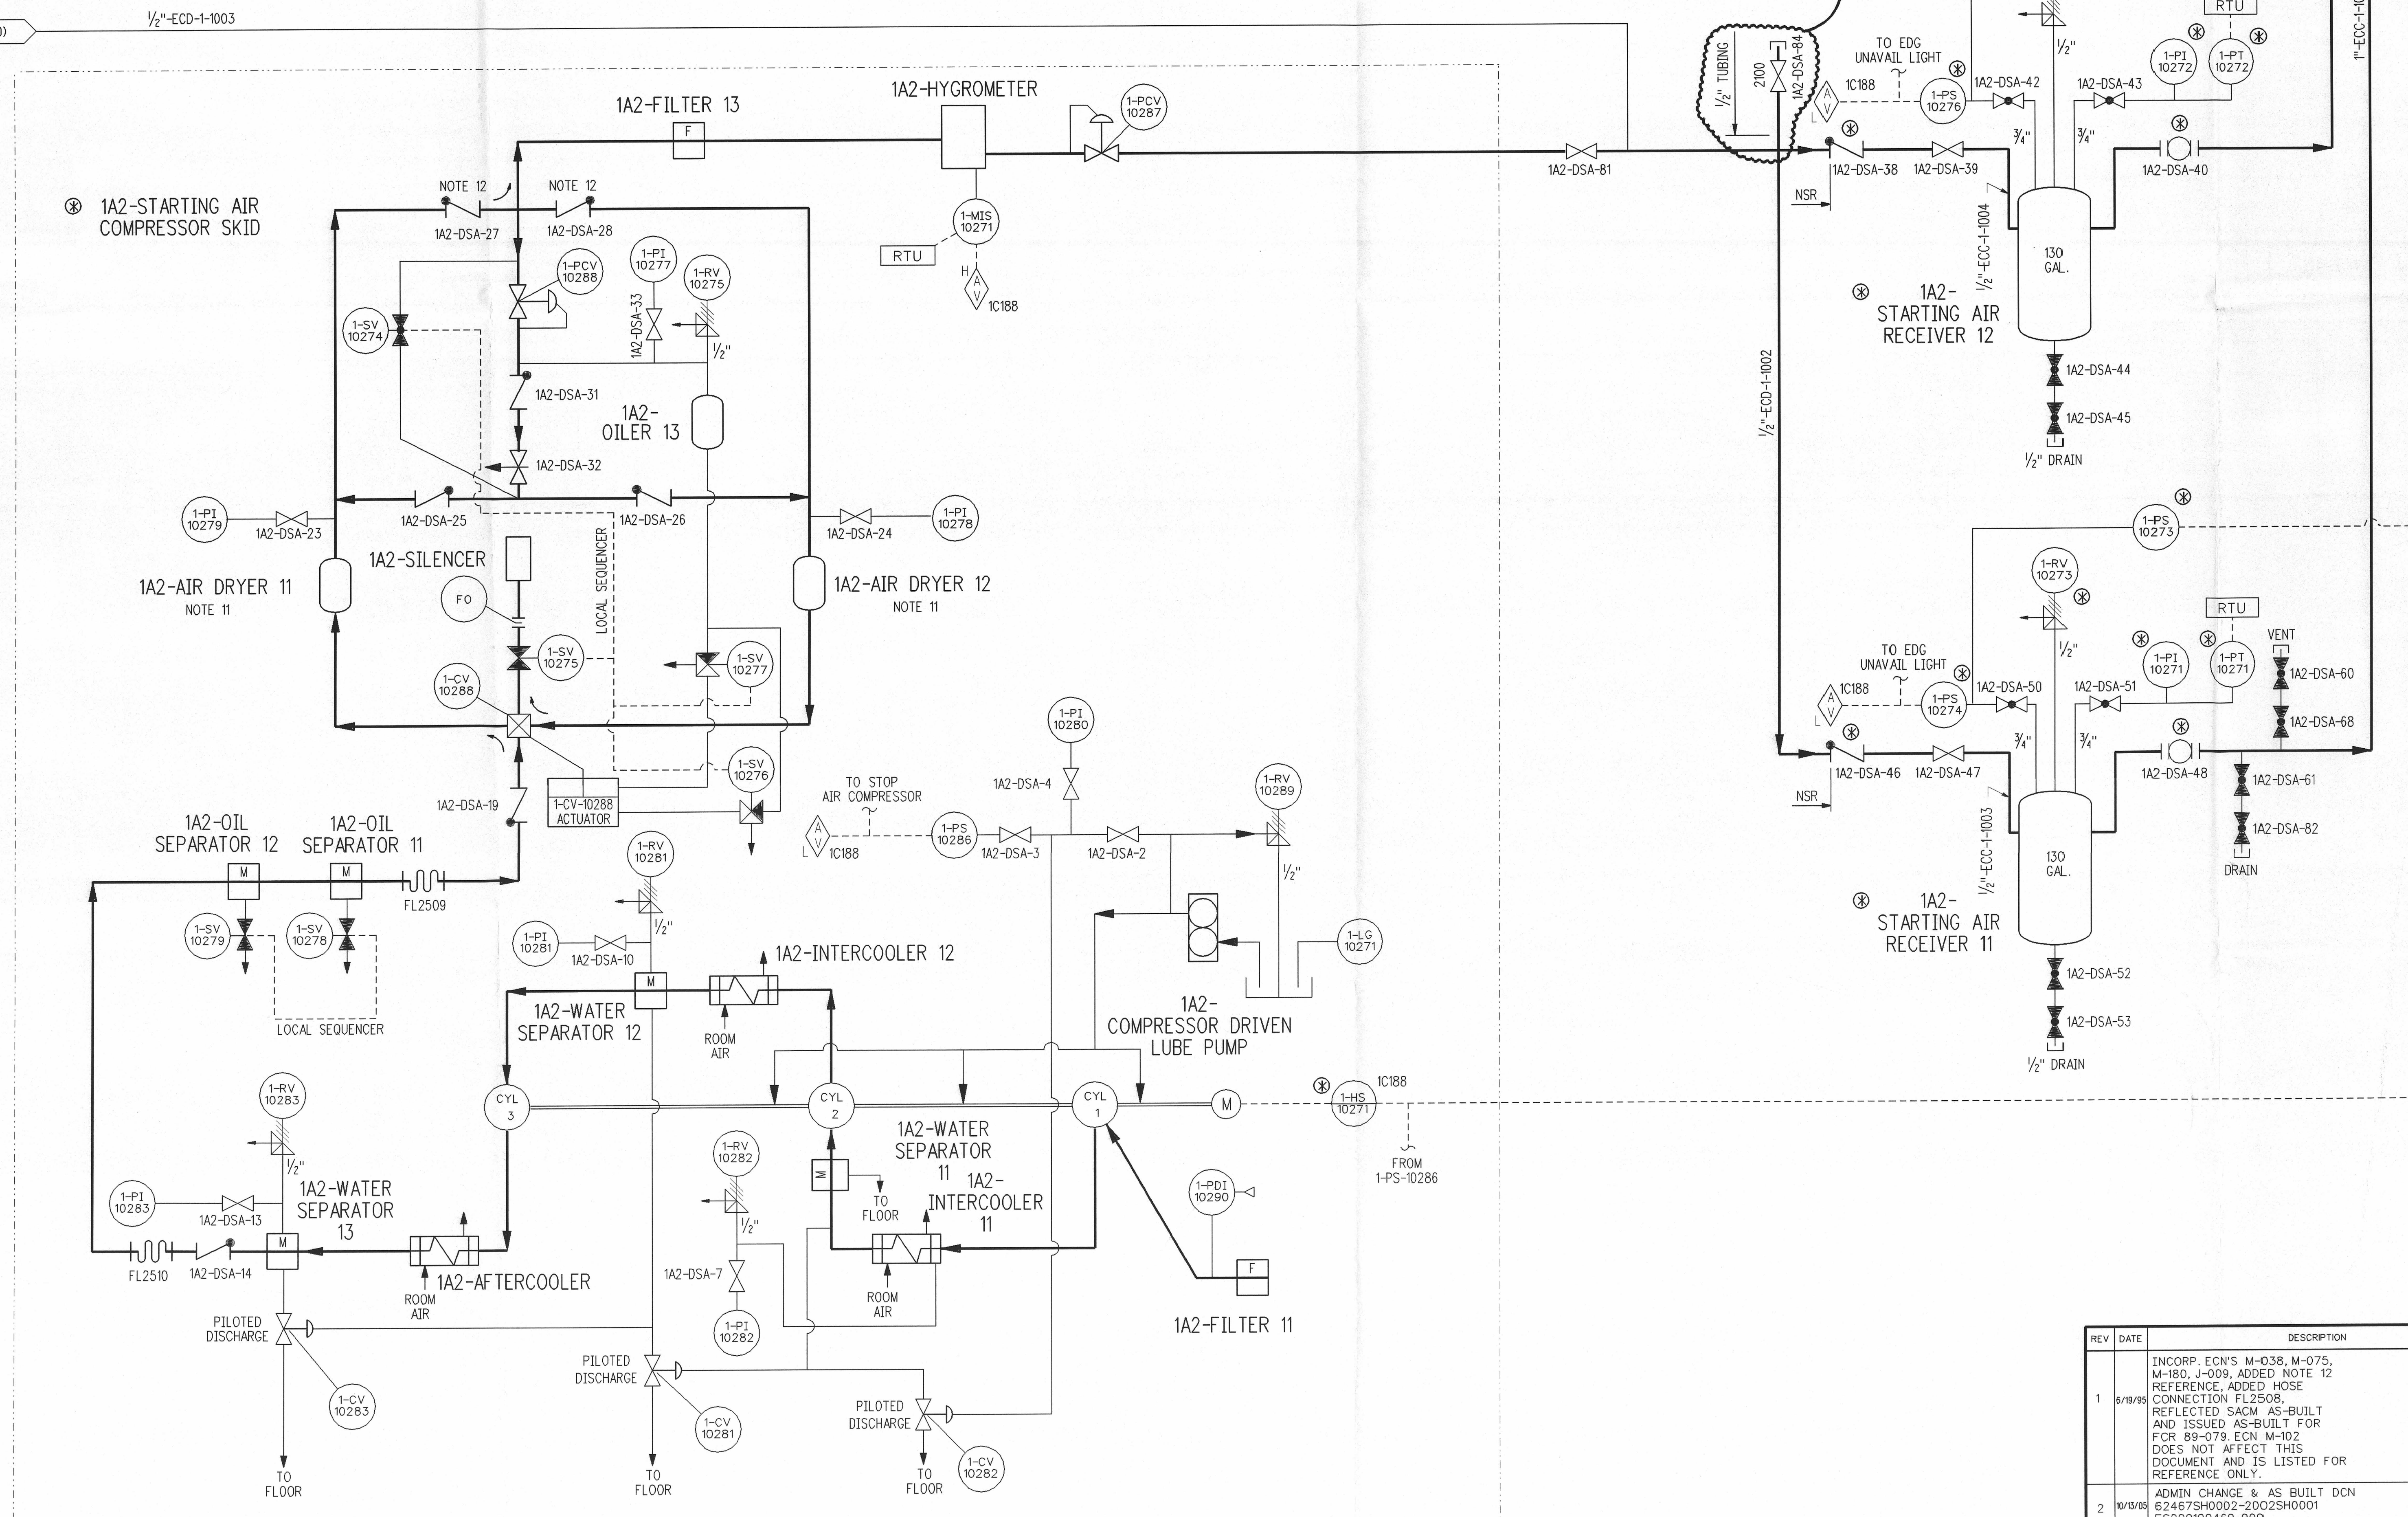

REV	DATE	DESCRIPTION	DWN	DSGN	DE	IR	APPROVED
1	8/18/95	INCORP. ECN'S M-038, M-075, M-180, J-009, ADDED NOTE 12 REFERENCE, ADDED HOSE CONNECTION FL2508, REFLECTED SACM AS-BUILT AND ISSUED AS-BUILT FOR FCR 89-079, ECN M-102 DOES NOT AFFECT THIS DOCUMENT AND IS LISTED FOR REFERENCE ONLY.	SW	-	-	-	RFY
2	10/10/95	ADMIN CHANGE & AS BUILT DCN 62467SH0002-2002SH0001 ES200100460-000	WHR	REL	-	-	REL
3	11/2/95	AS BUILT DCN 62467SH0002-2002SH0001 ES200000242-000	WHR	REL	-	-	REL

CALVERT CLIFFS NUCLEAR POWER PLANT ENGINEERING SERVICES DEPARTMENT	
CALVERT CLIFFS UNIT 1	
SCALE: NONE	DWG. NO. 62467SH0002
REV. 3	