



FLOOR PLAN EL. 820'-6"

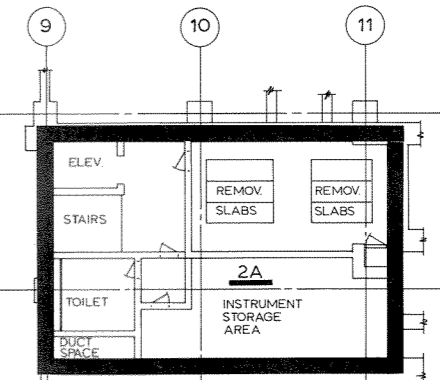


PARTIAL FLOOR PLAN EL. 832'-0"

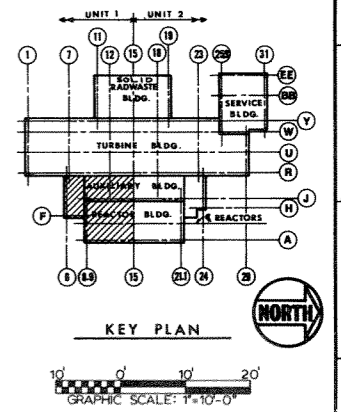



REV. 3 APRIL 1987

LA SALLE COUNTY STATION  
 UPDATED FINAL SAFETY ANALYSIS REPORT  
 FIGURE 9.5-1a  
 FIRE PROTECTION SYSTEM  
 (SHEET 1 OF 18) EL. 820'-6"

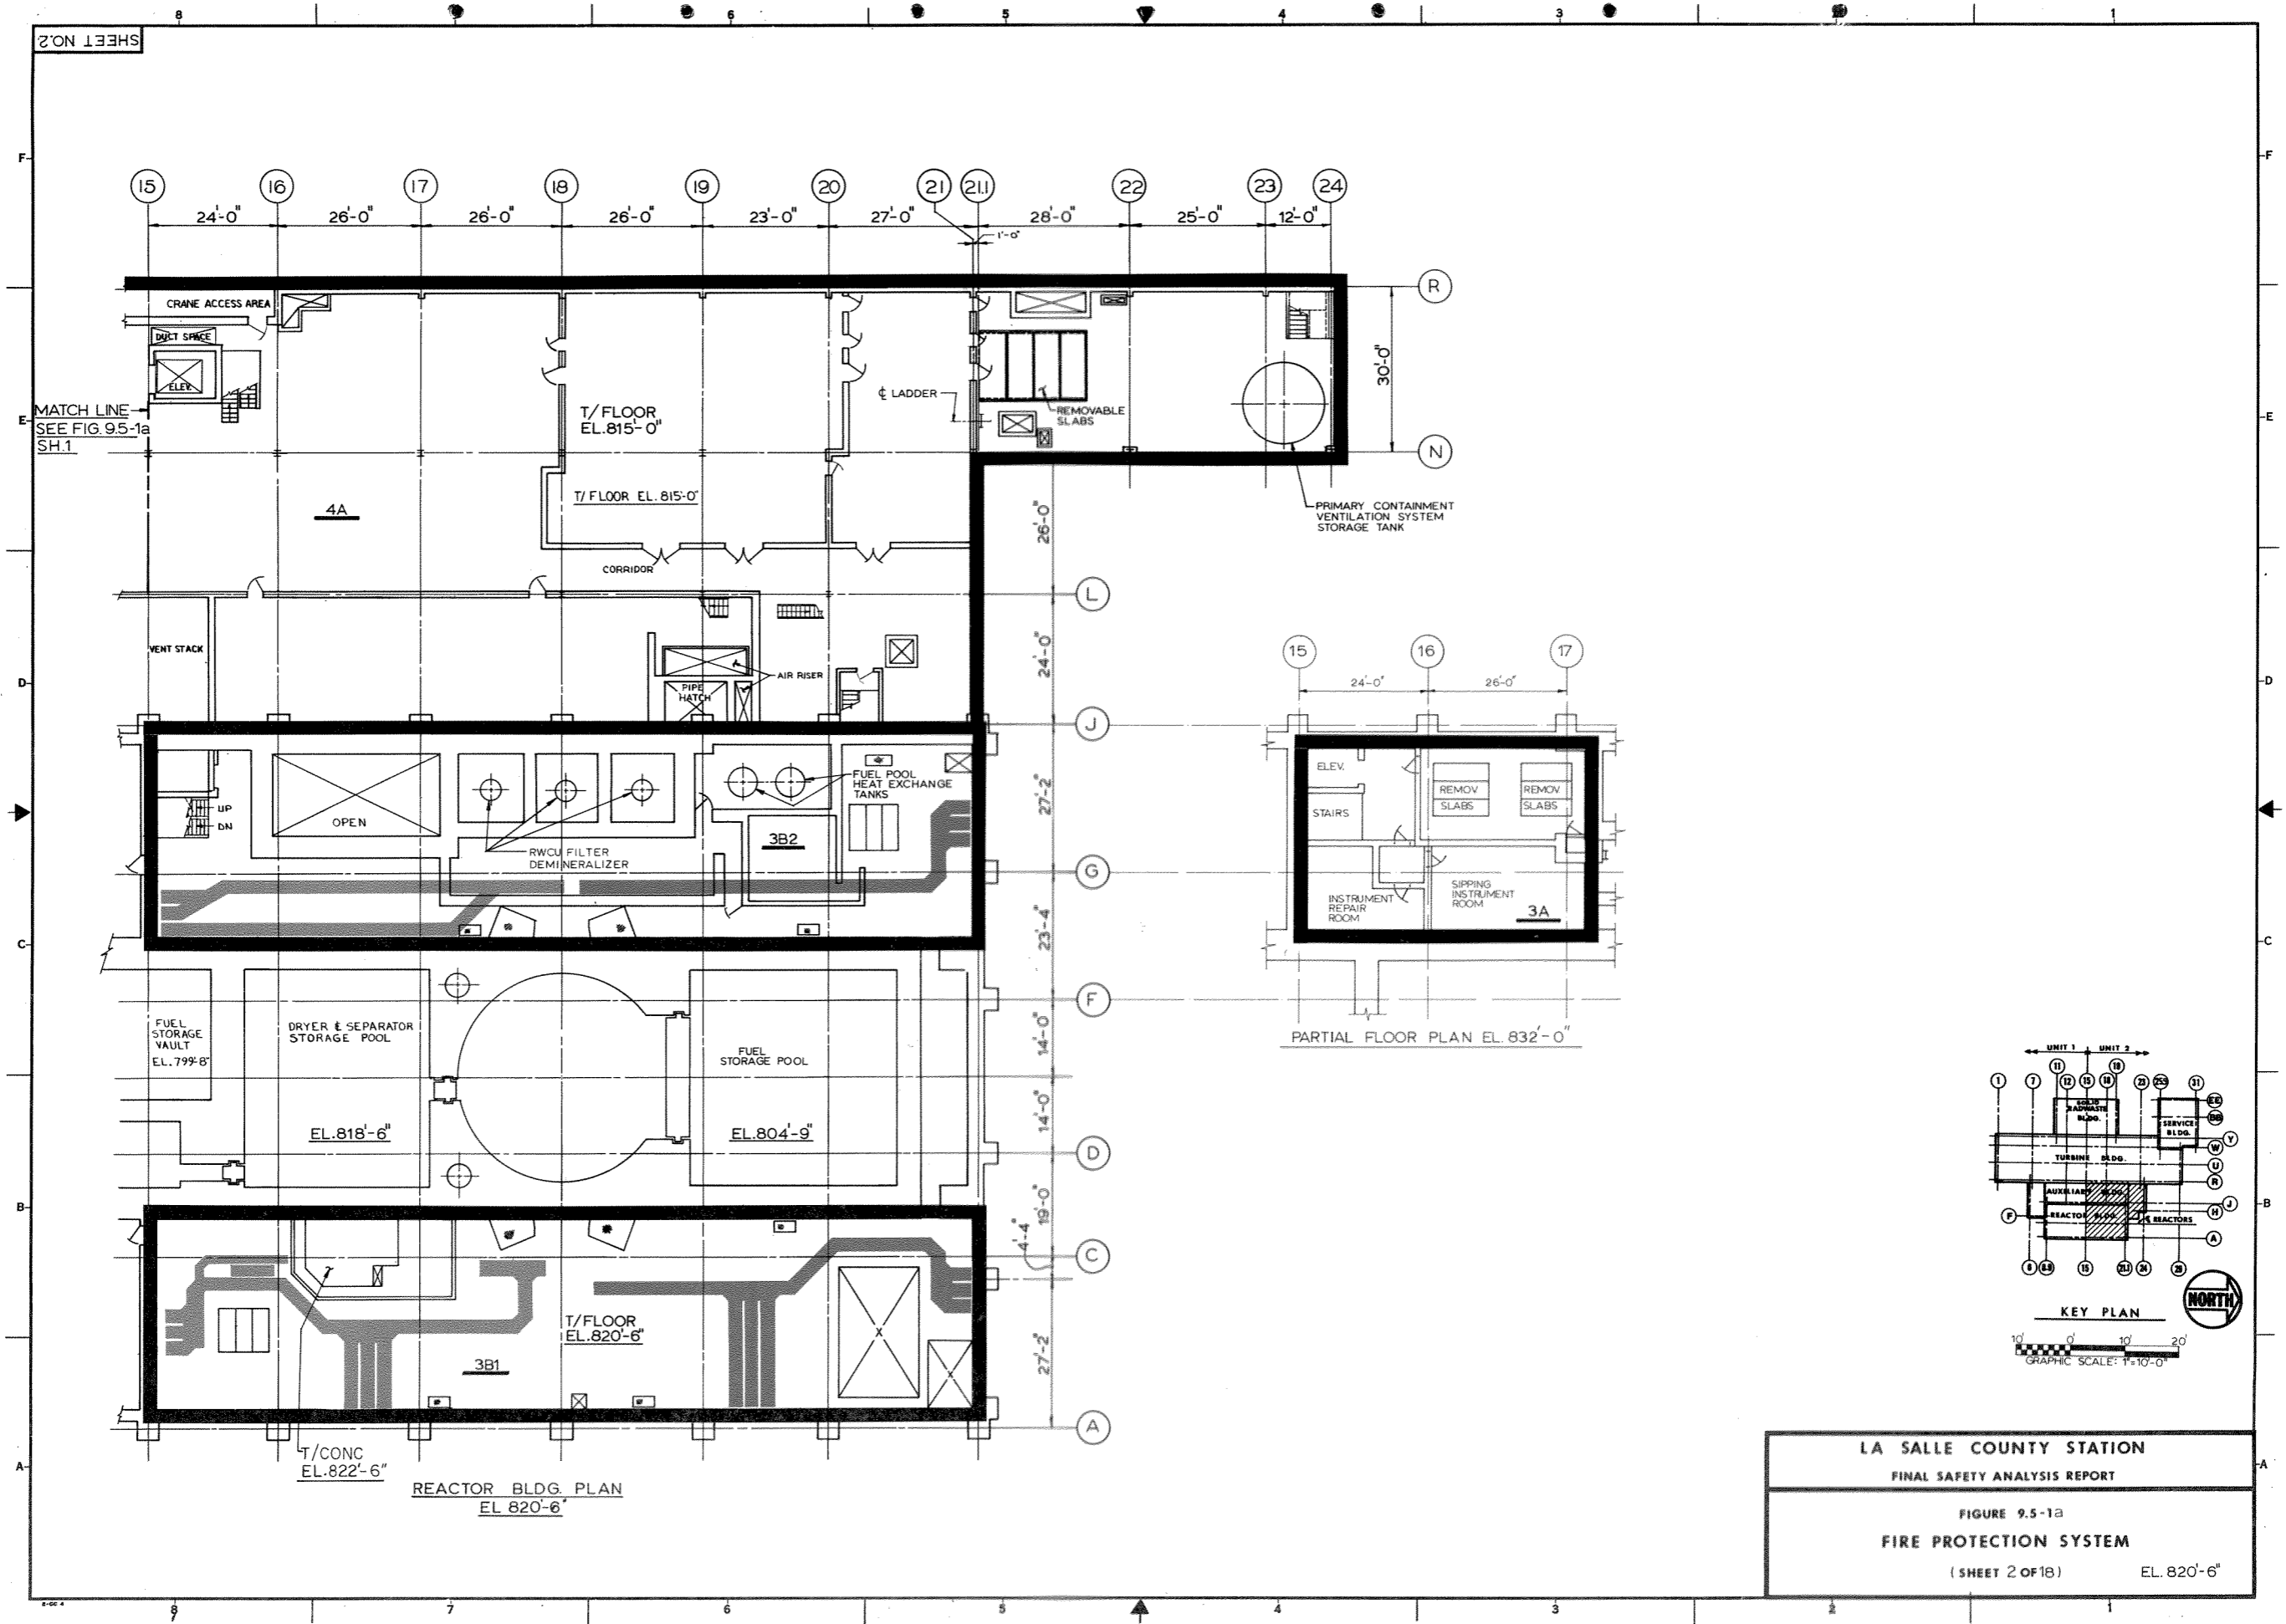



LA SALLE COUNTY STATION  
FINAL SAFETY ANALYSIS REPORT

FIGURE 9.5-1a  
FIRE PROTECTION SYSTEM  
(SHEET 2 OF 18) EL. 820'-6"

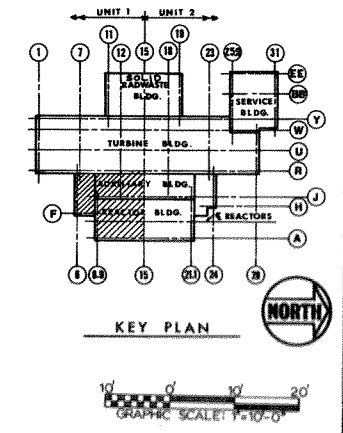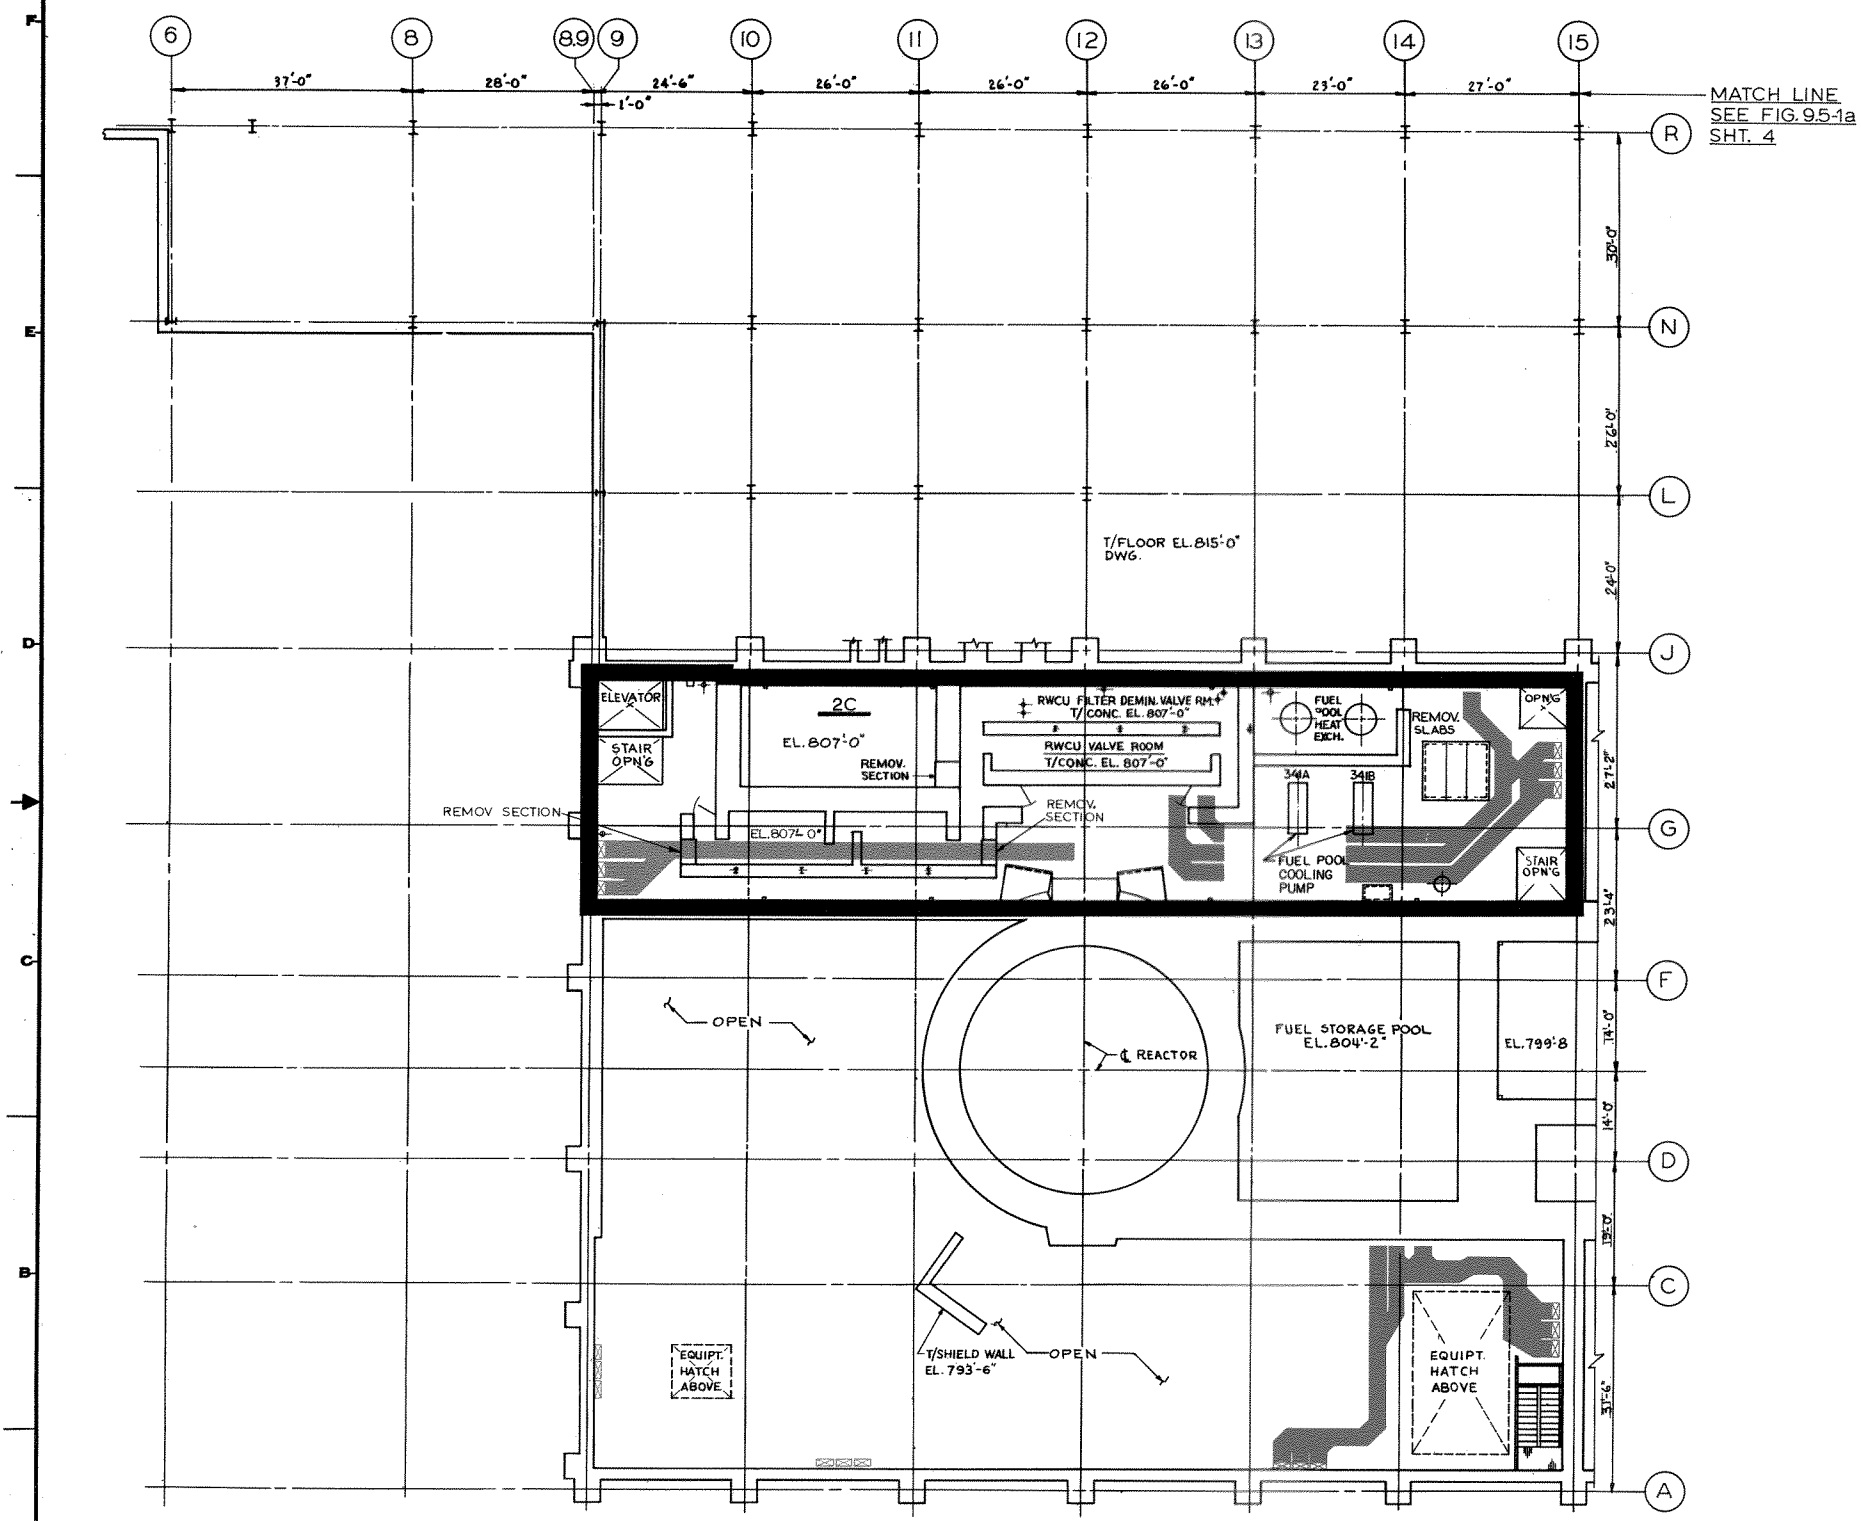

LA SALLE COUNTY STATION  
UPDATED FINAL SAFETY ANALYSIS REPORT


FIGURE 9.5-1B  
FIRE PROTECTION SYSTEM  
( SHEET 3 OF 10 ) EL. 807'-0"

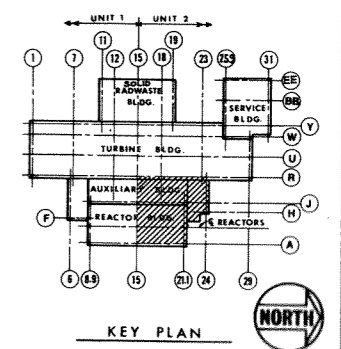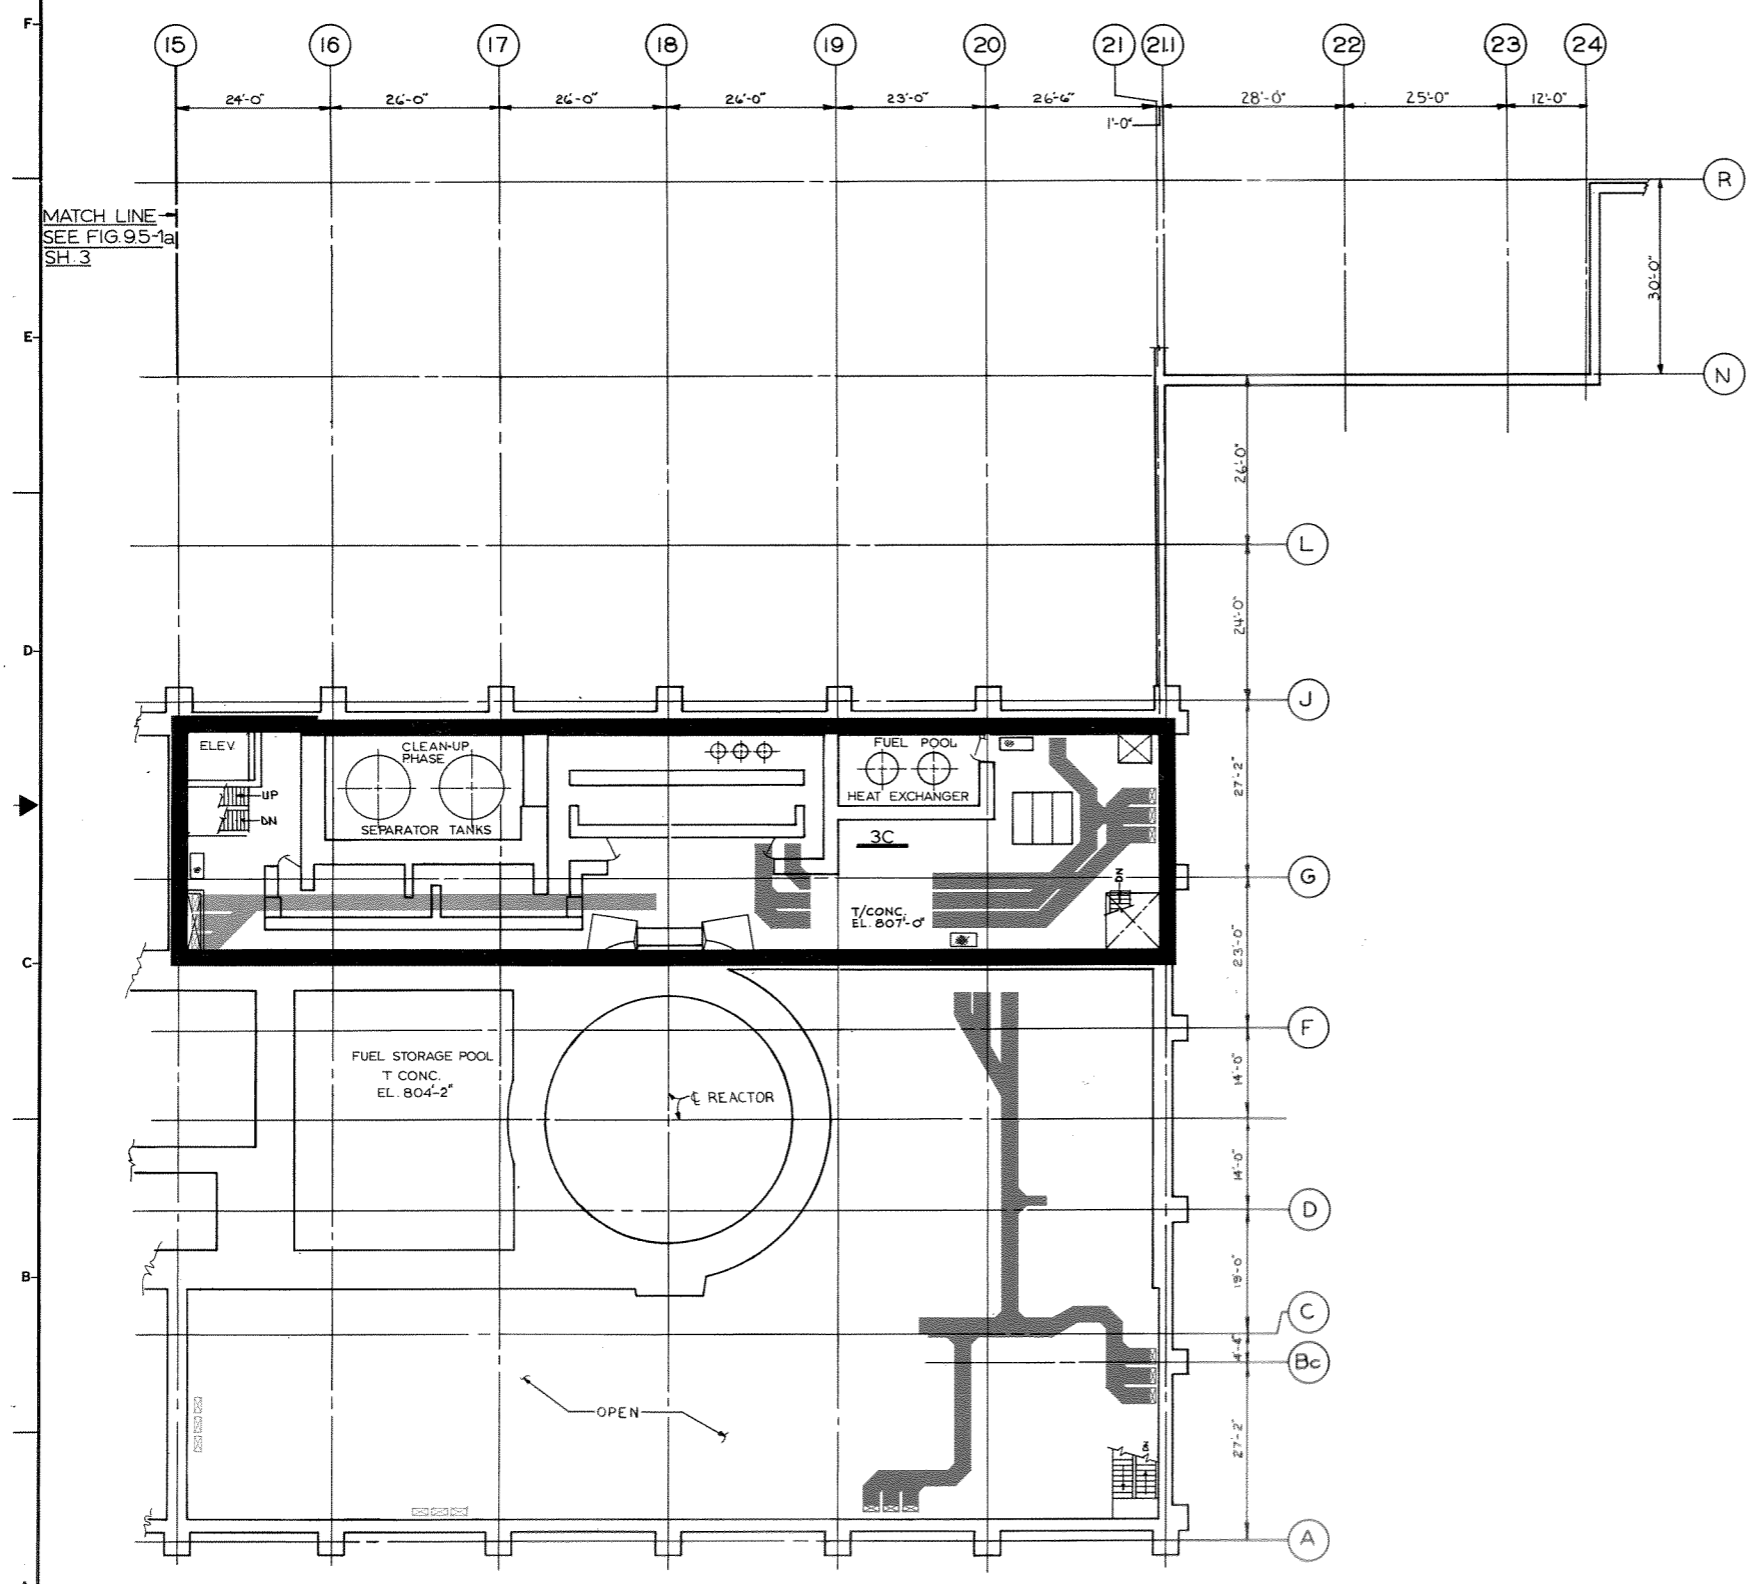

REV. 3 APRIL 1987


LA SALLE COUNTY STATION  
UPDATED FINAL SAFETY ANALYSIS REPORT

FIGURE 9.5-1a  
FIRE PROTECTION SYSTEM  
(SHEET 4 OF 13) EL. 807'-0"

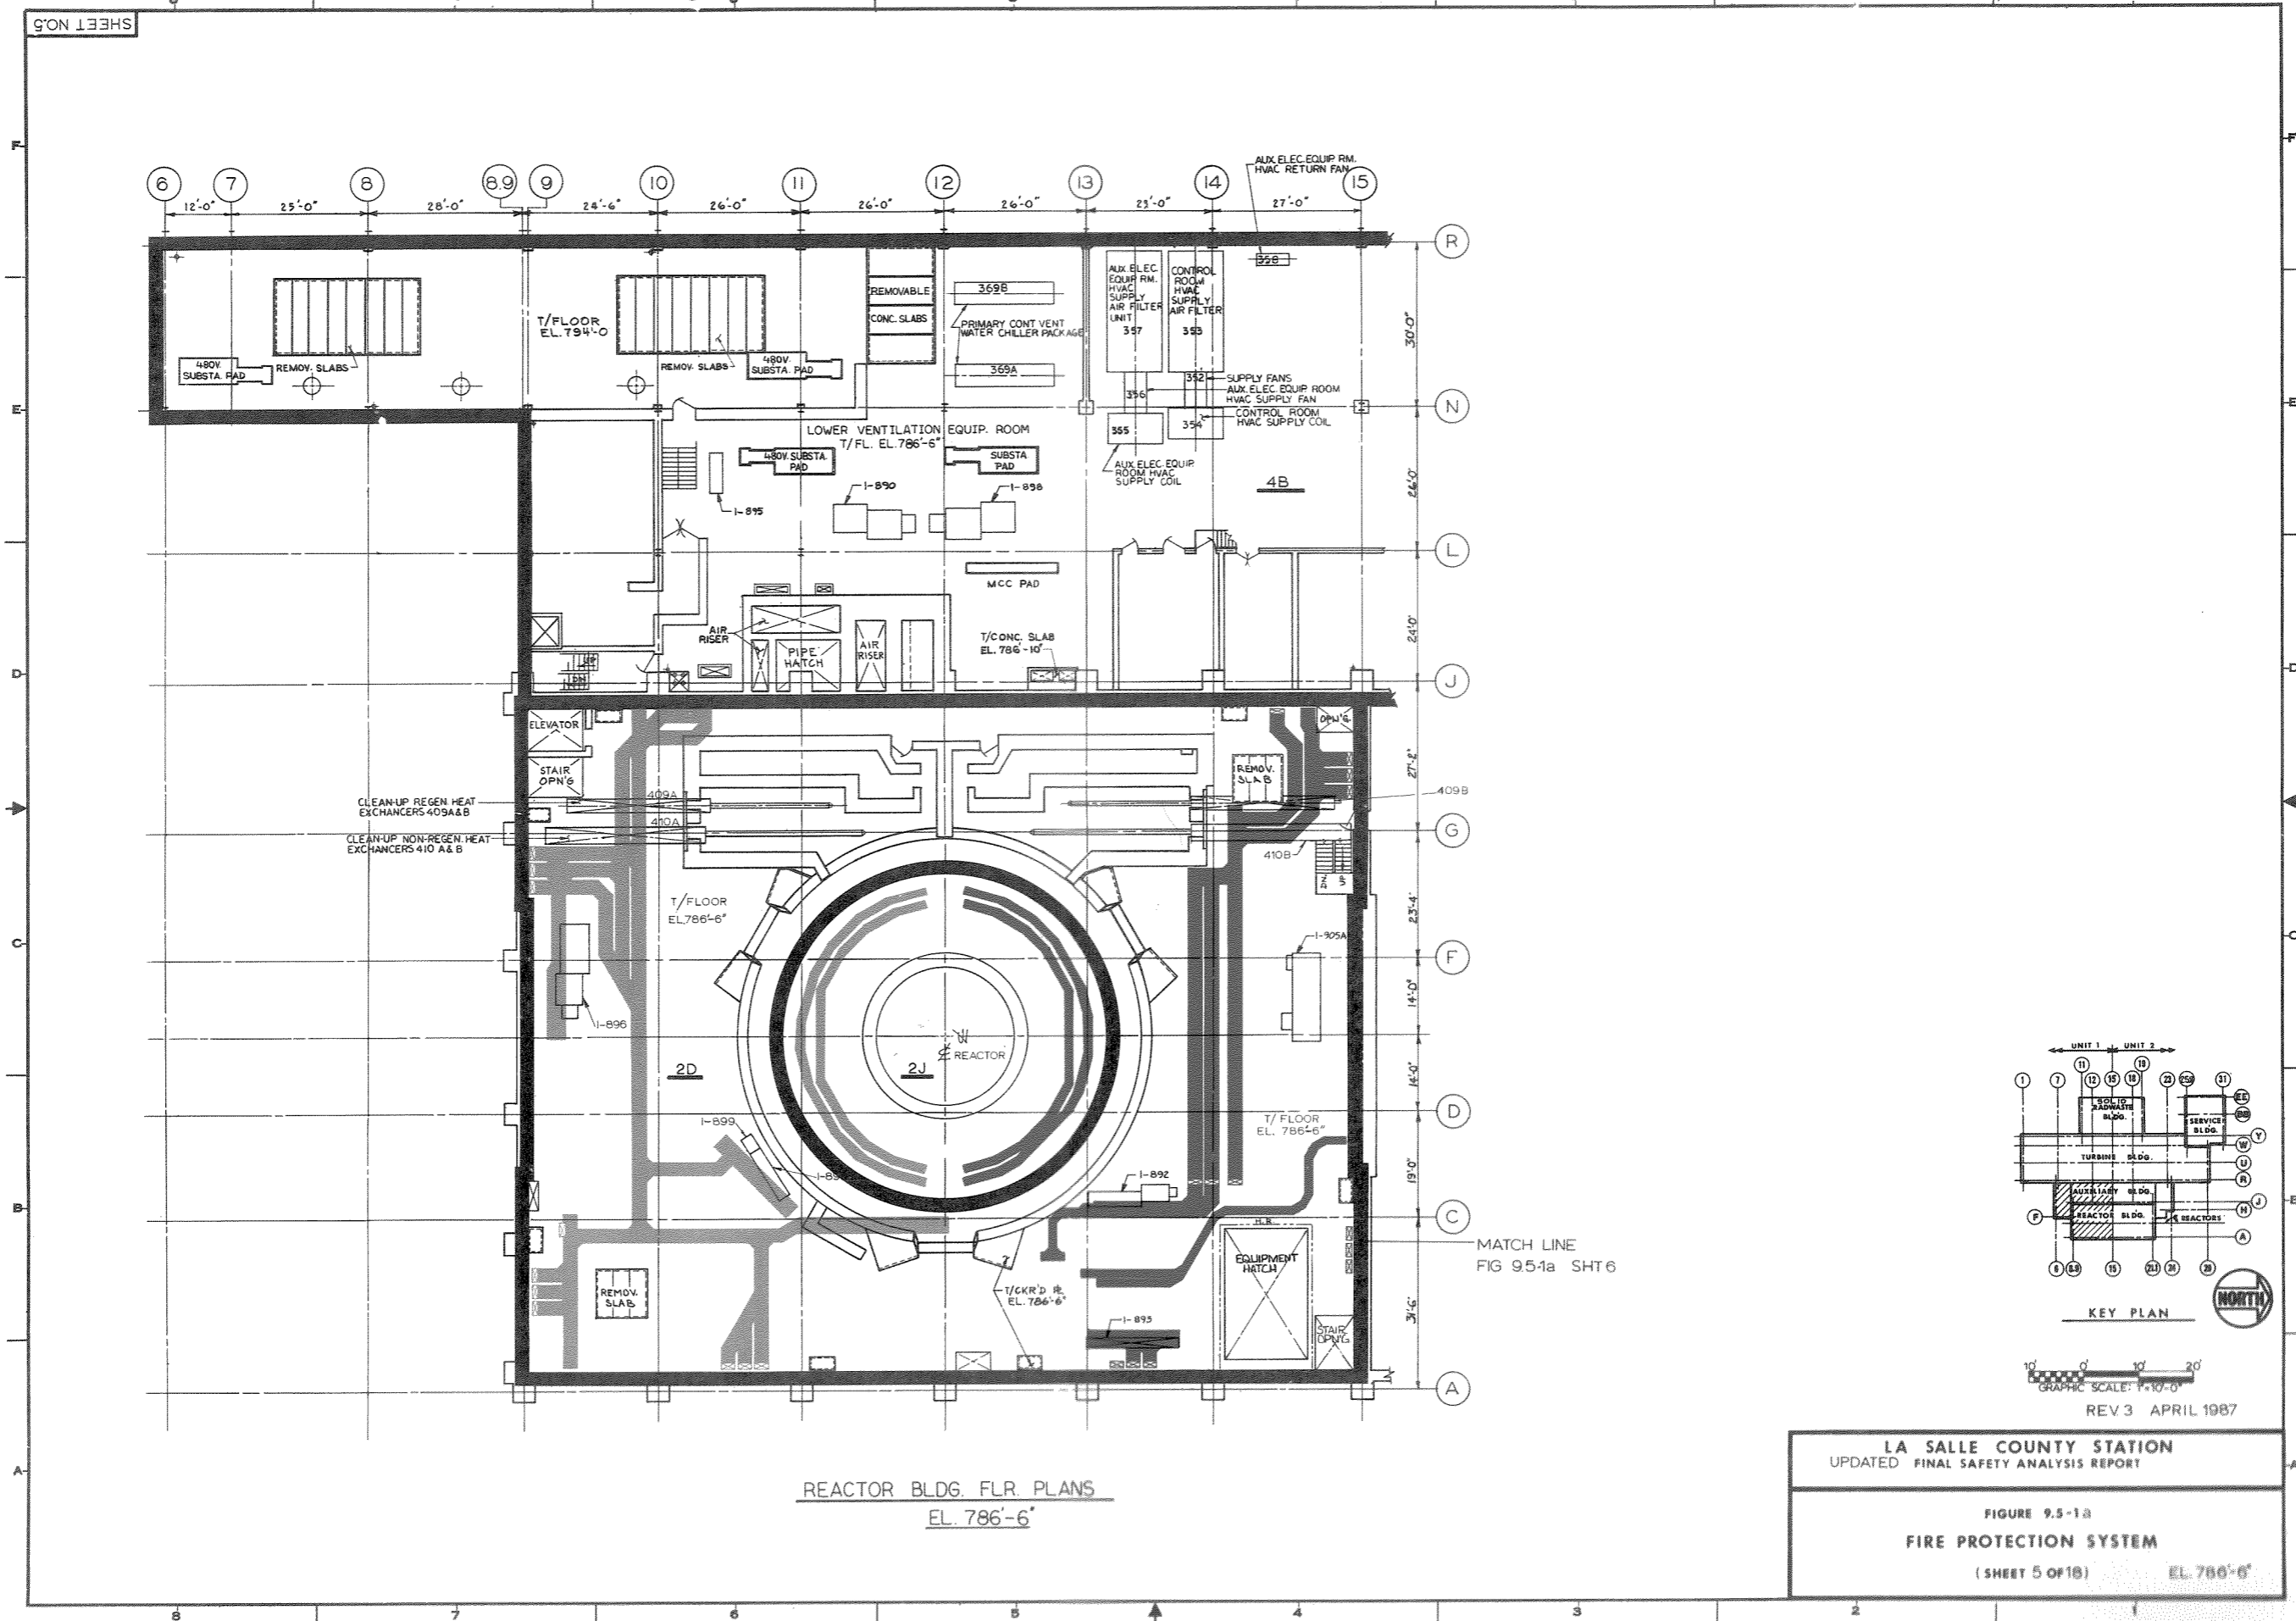

REACTOR BLDG. FLR. PLANS  
EL. 786'-6"


MATCH LINE  
FIG 9.5-1a SHT 6

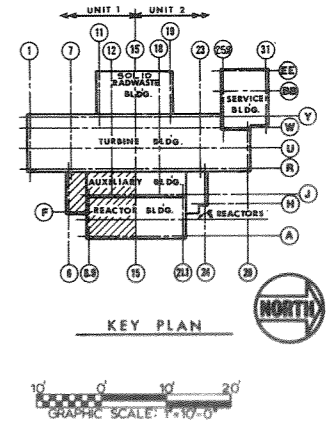


REV 3 APRIL 1987

LA SALLE COUNTY STATION  
UPDATED FINAL SAFETY ANALYSIS REPORT

FIGURE 9.5-1a  
FIRE PROTECTION SYSTEM  
(SHEET 5 OF 18) EL. 786'-6"

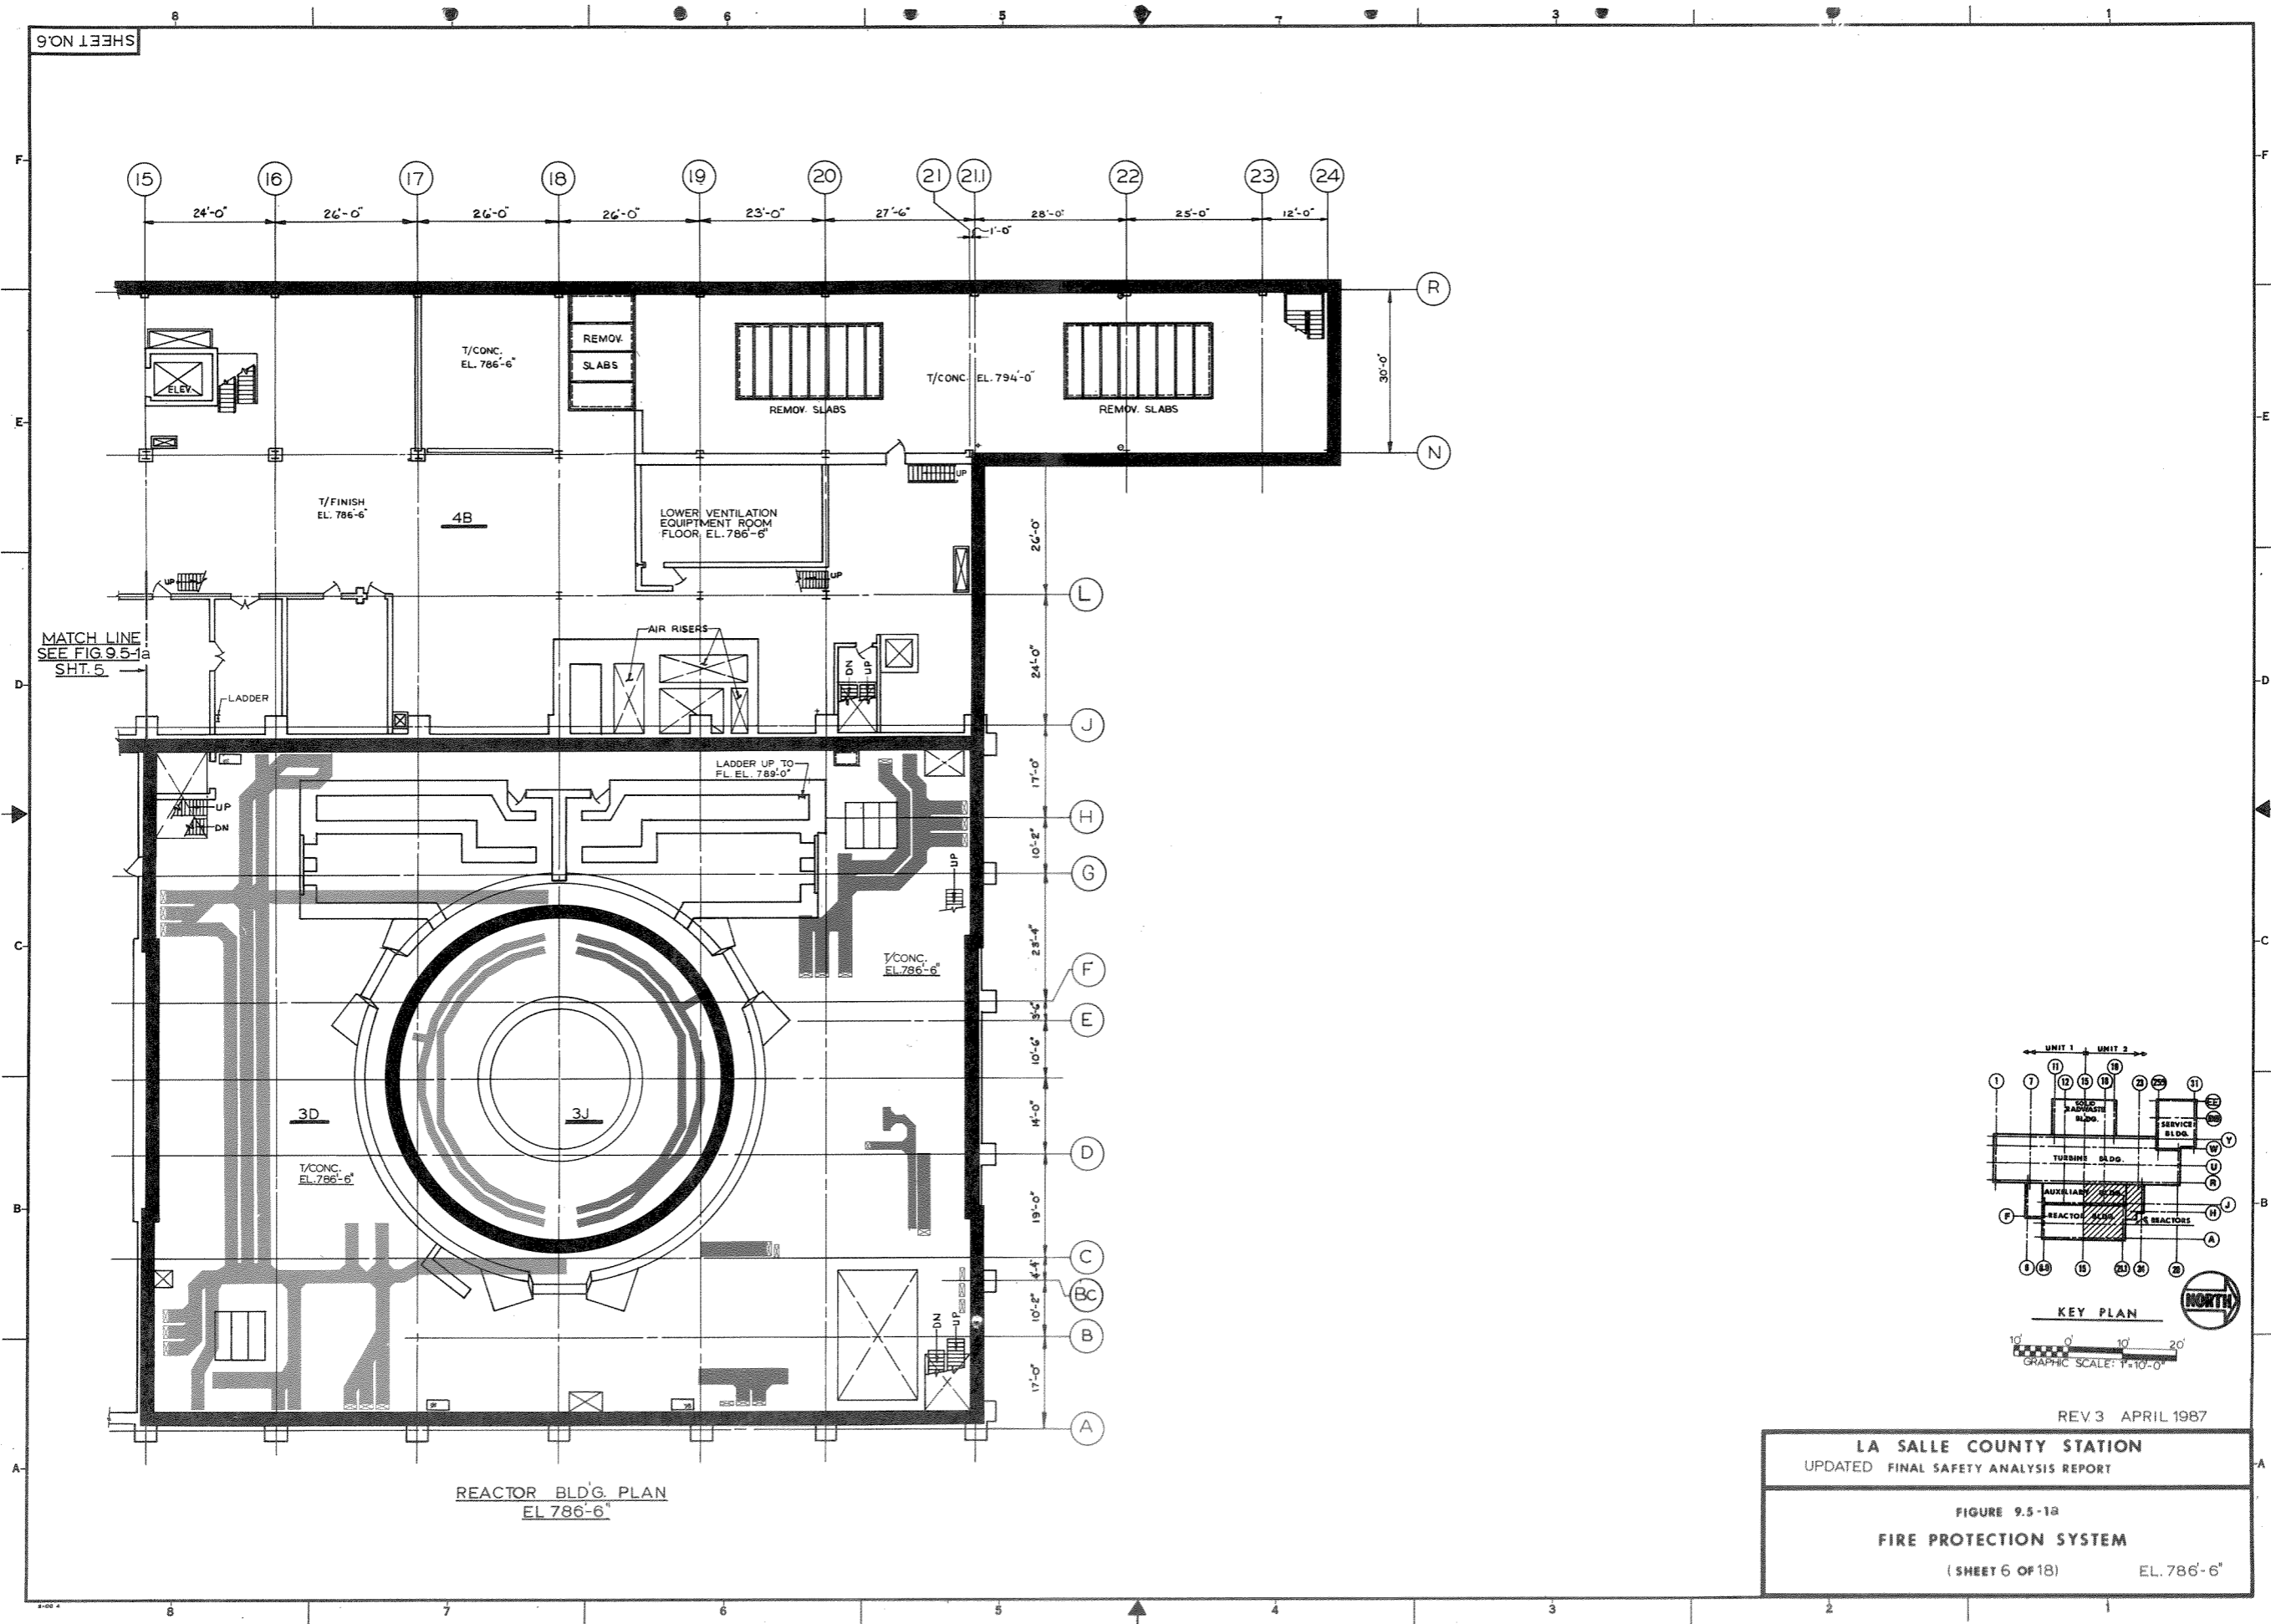




REACTOR BLD'G. PLAN  
EL 786'-6"

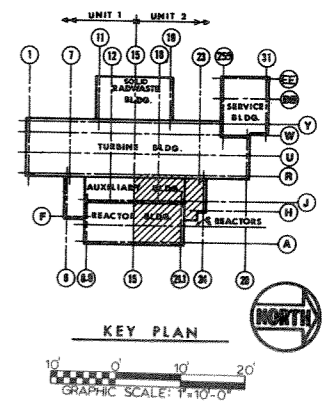

REV 3 APRIL 1987

LA SALLE COUNTY STATION  
 UPDATED FINAL SAFETY ANALYSIS REPORT

FIGURE 9.5-1a  
 FIRE PROTECTION SYSTEM  
 (SHEET 6 OF 18) EL. 786'-6"

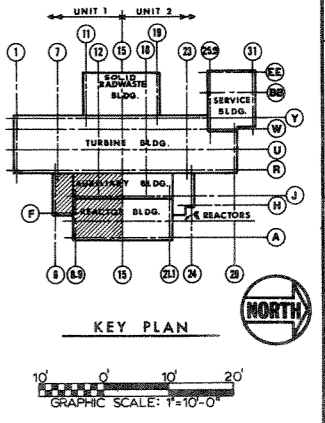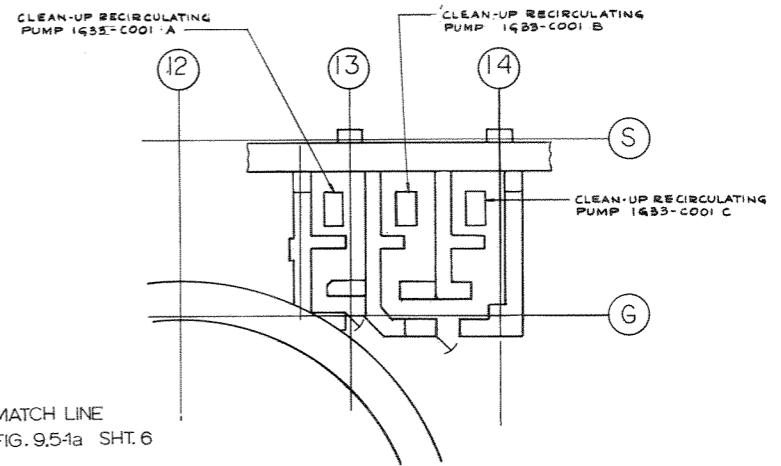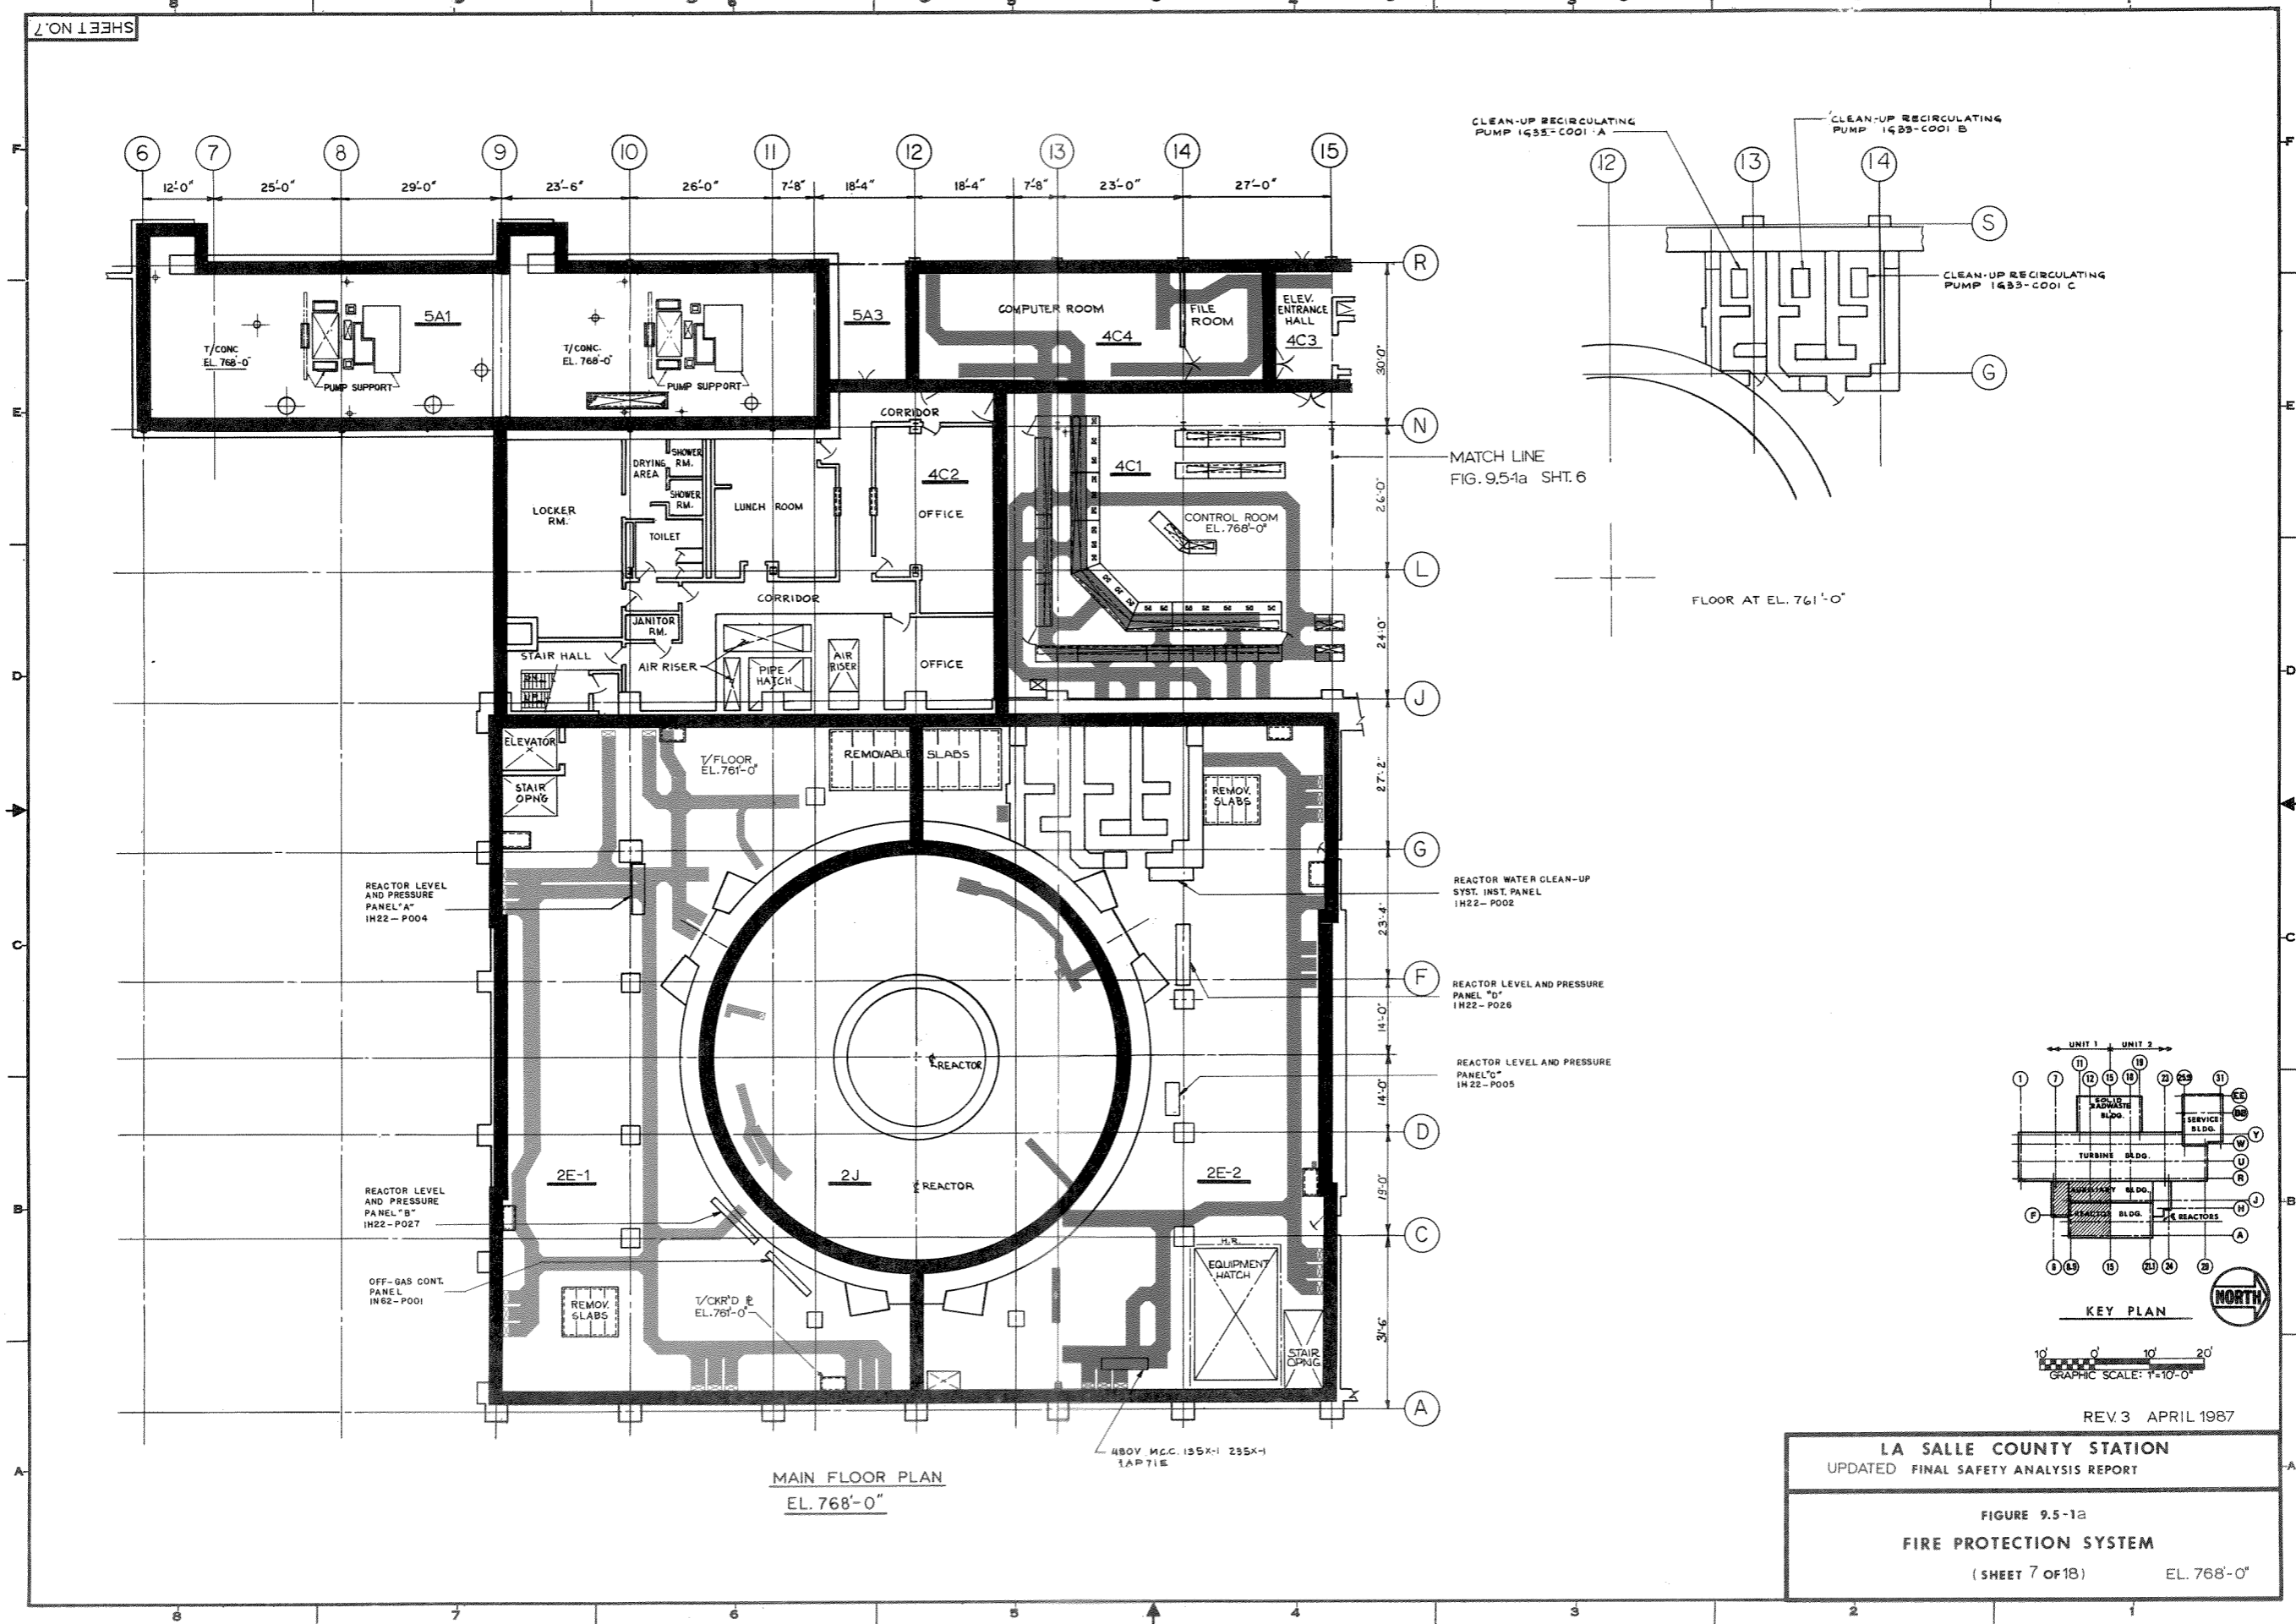


MAIN FLOOR PLAN  
 EL. 768'-0"

REV. 3 APRIL 1987

LA SALLE COUNTY STATION  
 UPDATED FINAL SAFETY ANALYSIS REPORT


FIGURE 9.5-1a  
 FIRE PROTECTION SYSTEM  
 (SHEET 7 OF 18) EL. 768'-0"

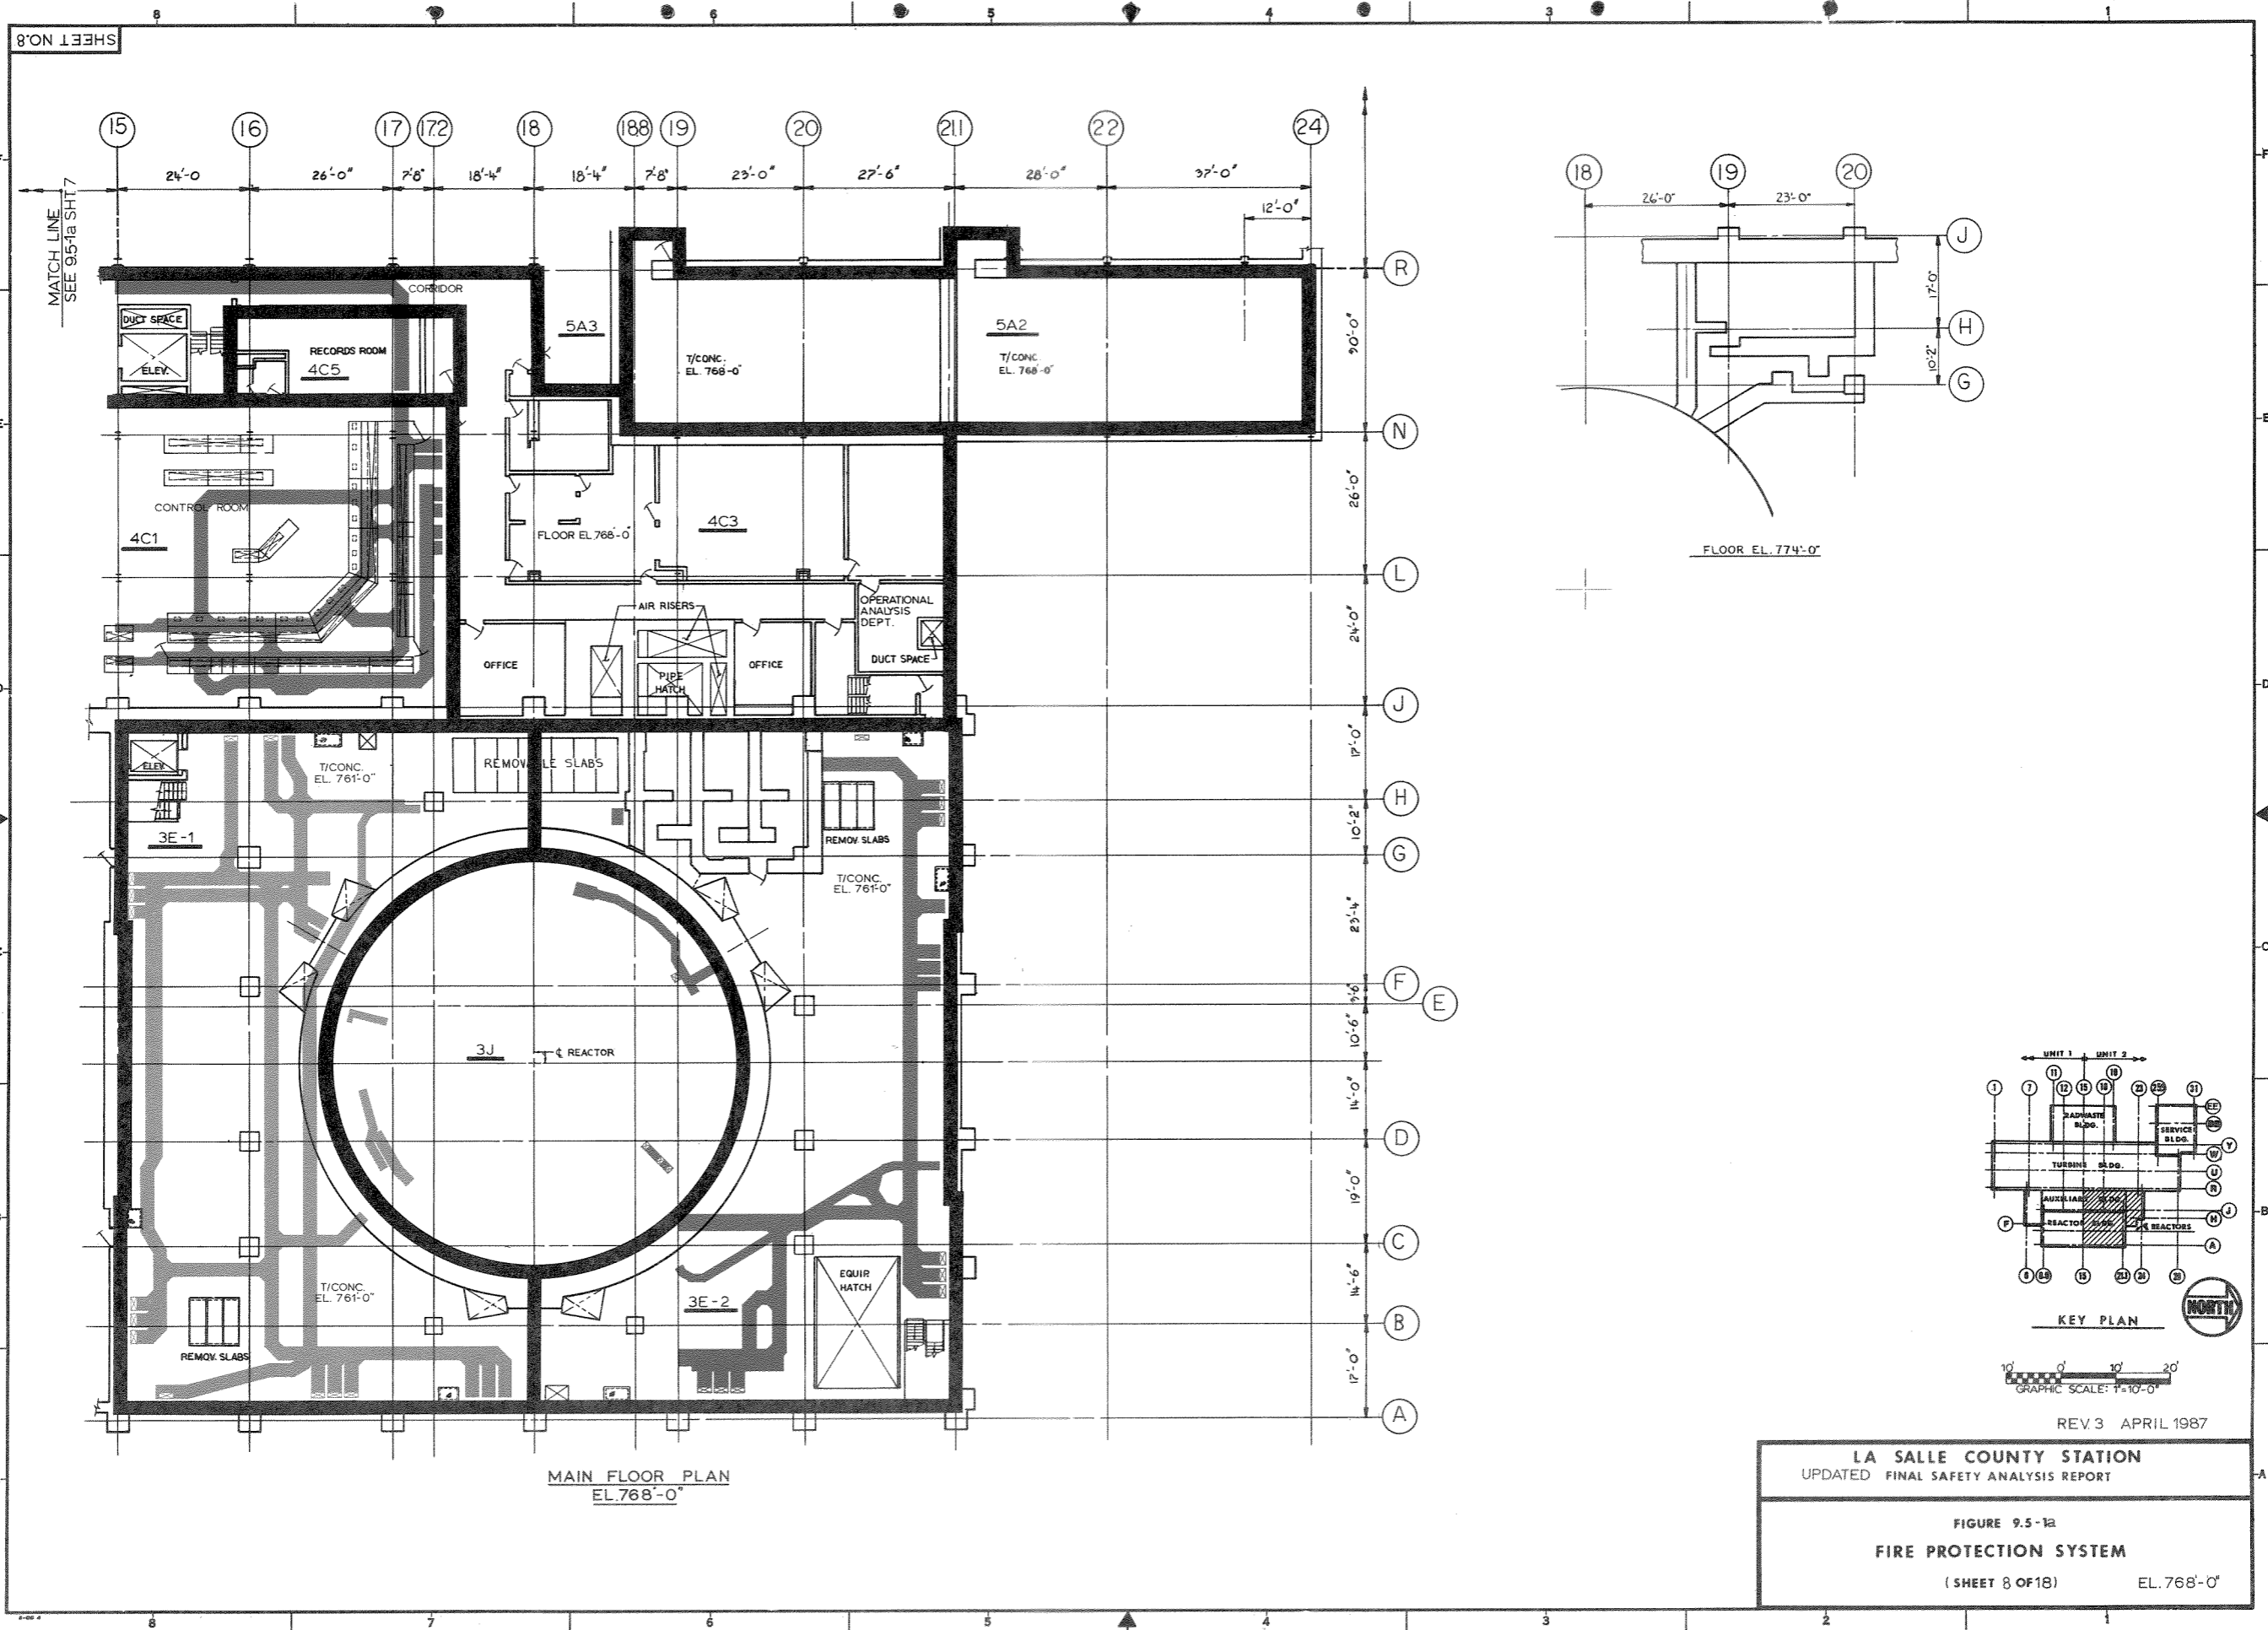


LA SALLE COUNTY STATION  
 UPDATED FINAL SAFETY ANALYSIS REPORT

FIGURE 9.5-12  
**FIRE PROTECTION SYSTEM**  
 (SHEET 8 OF 18) EL. 768'-0"



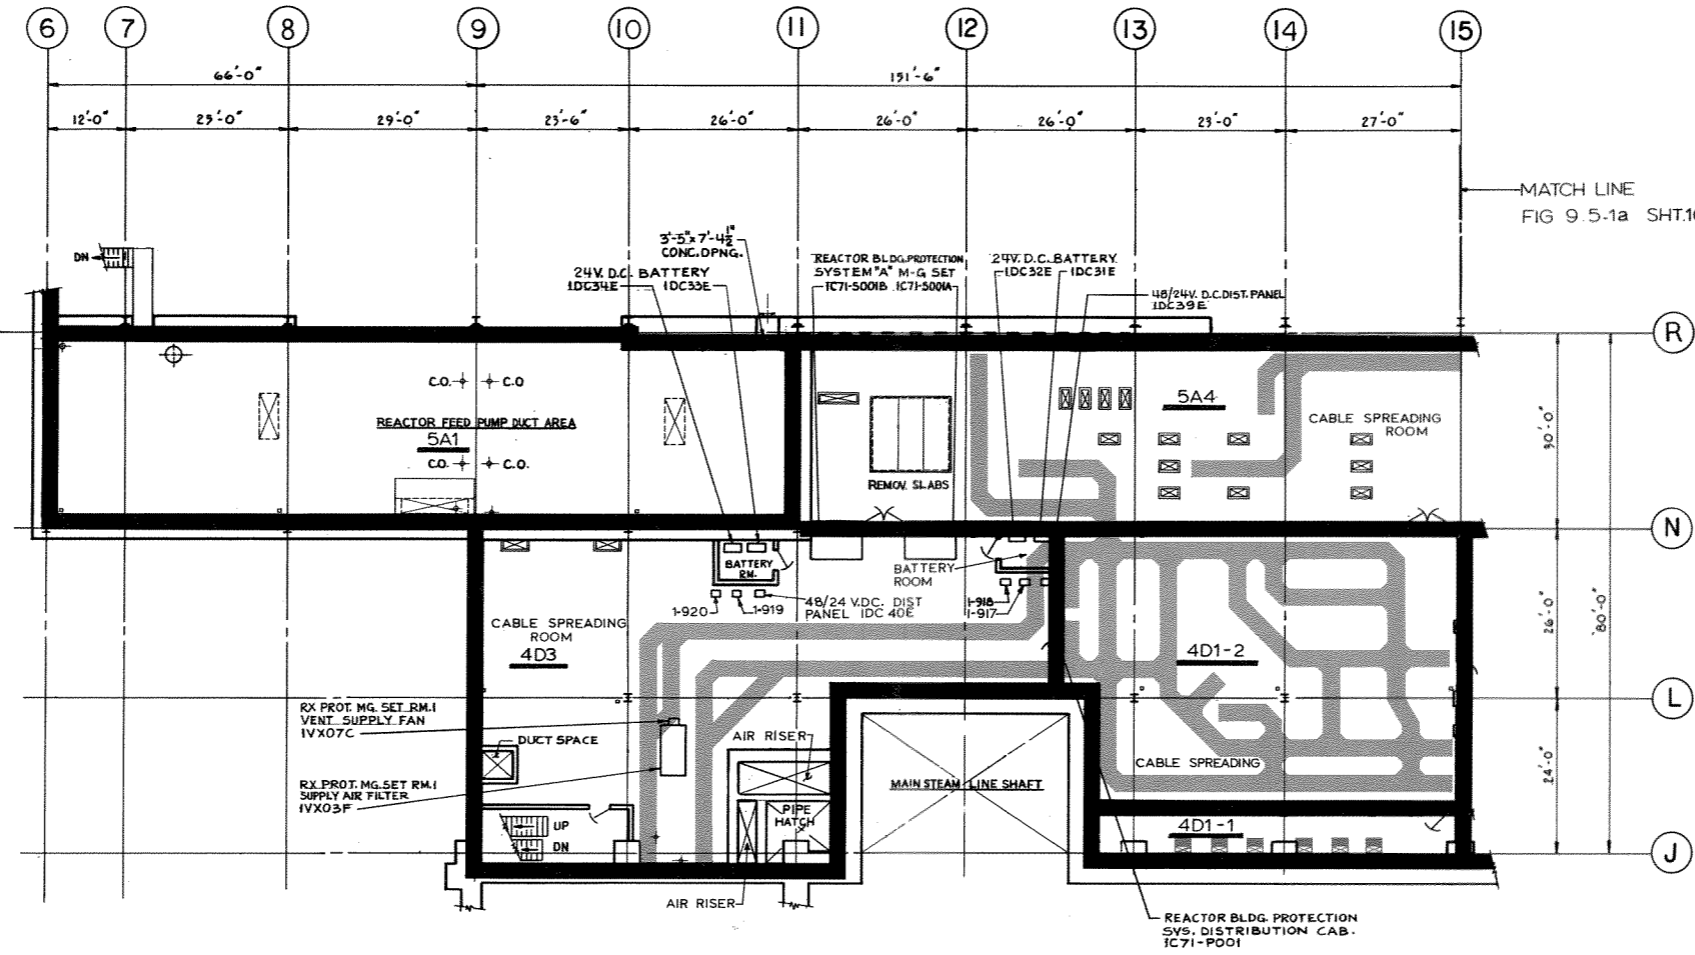


FLOOR PLAN ELEV. 749'-0"

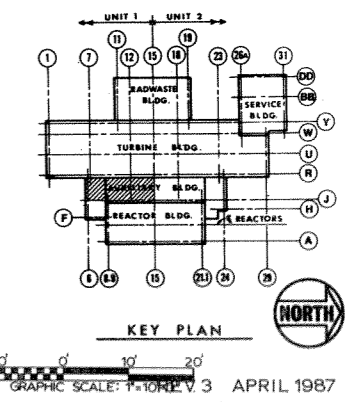


LA SALLE COUNTY STATION  
 UPDATED FINAL SAFETY ANALYSIS REPORT

FIGURE 9.5-1R  
 FIRE PROTECTION SYSTEM  
 (SHEET 9 OF 18) EL. 749'-0"

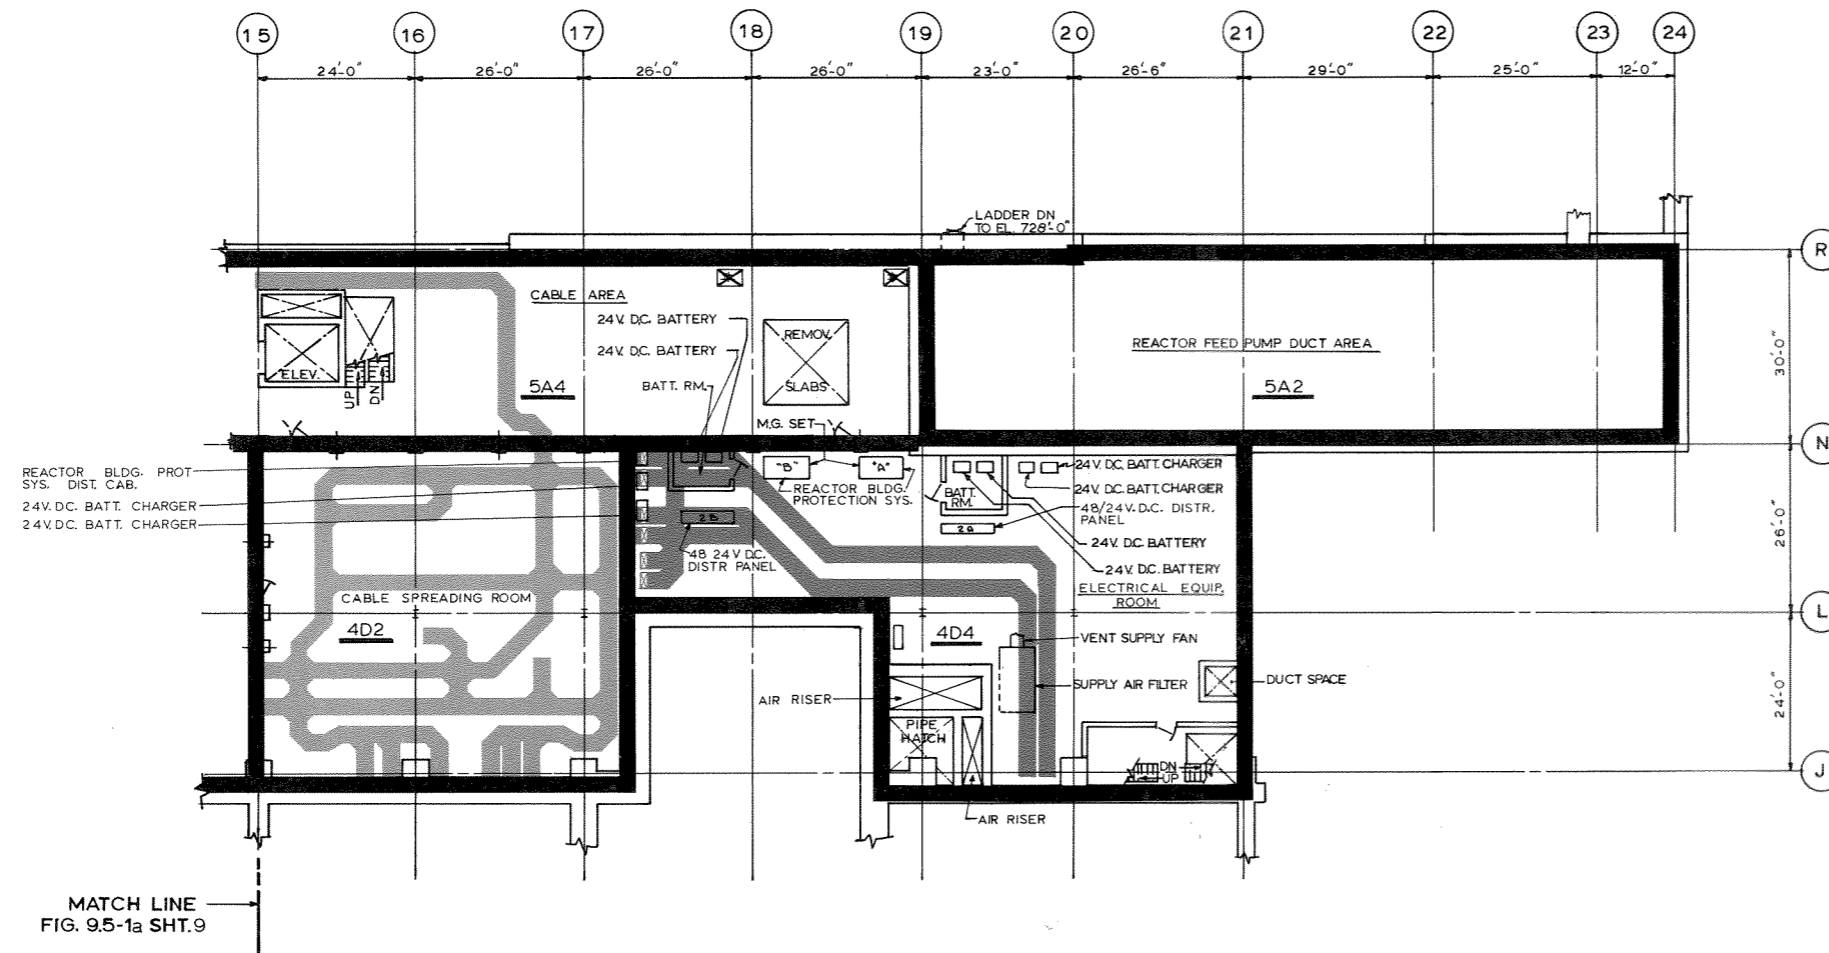

MATCH LINE  
FIG. 9.5-1a SHT. 9

AUXILIARY BUILDING FLOOR PLAN EL. 749'-0"

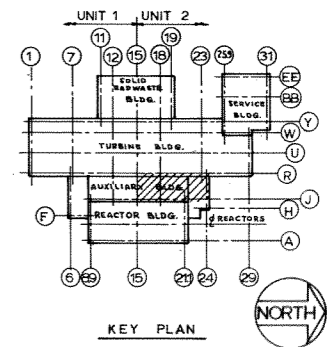


REV 3 APRIL 1987

LA SALLE COUNTY STATION  
 UPDATED FINAL SAFETY ANALYSIS REPORT


FIGURE 9.5-1a  
 FIRE PROTECTION SYSTEM  
 (SHEET 10 OF 18) EL. 749'-0"

SHEET NO. 11

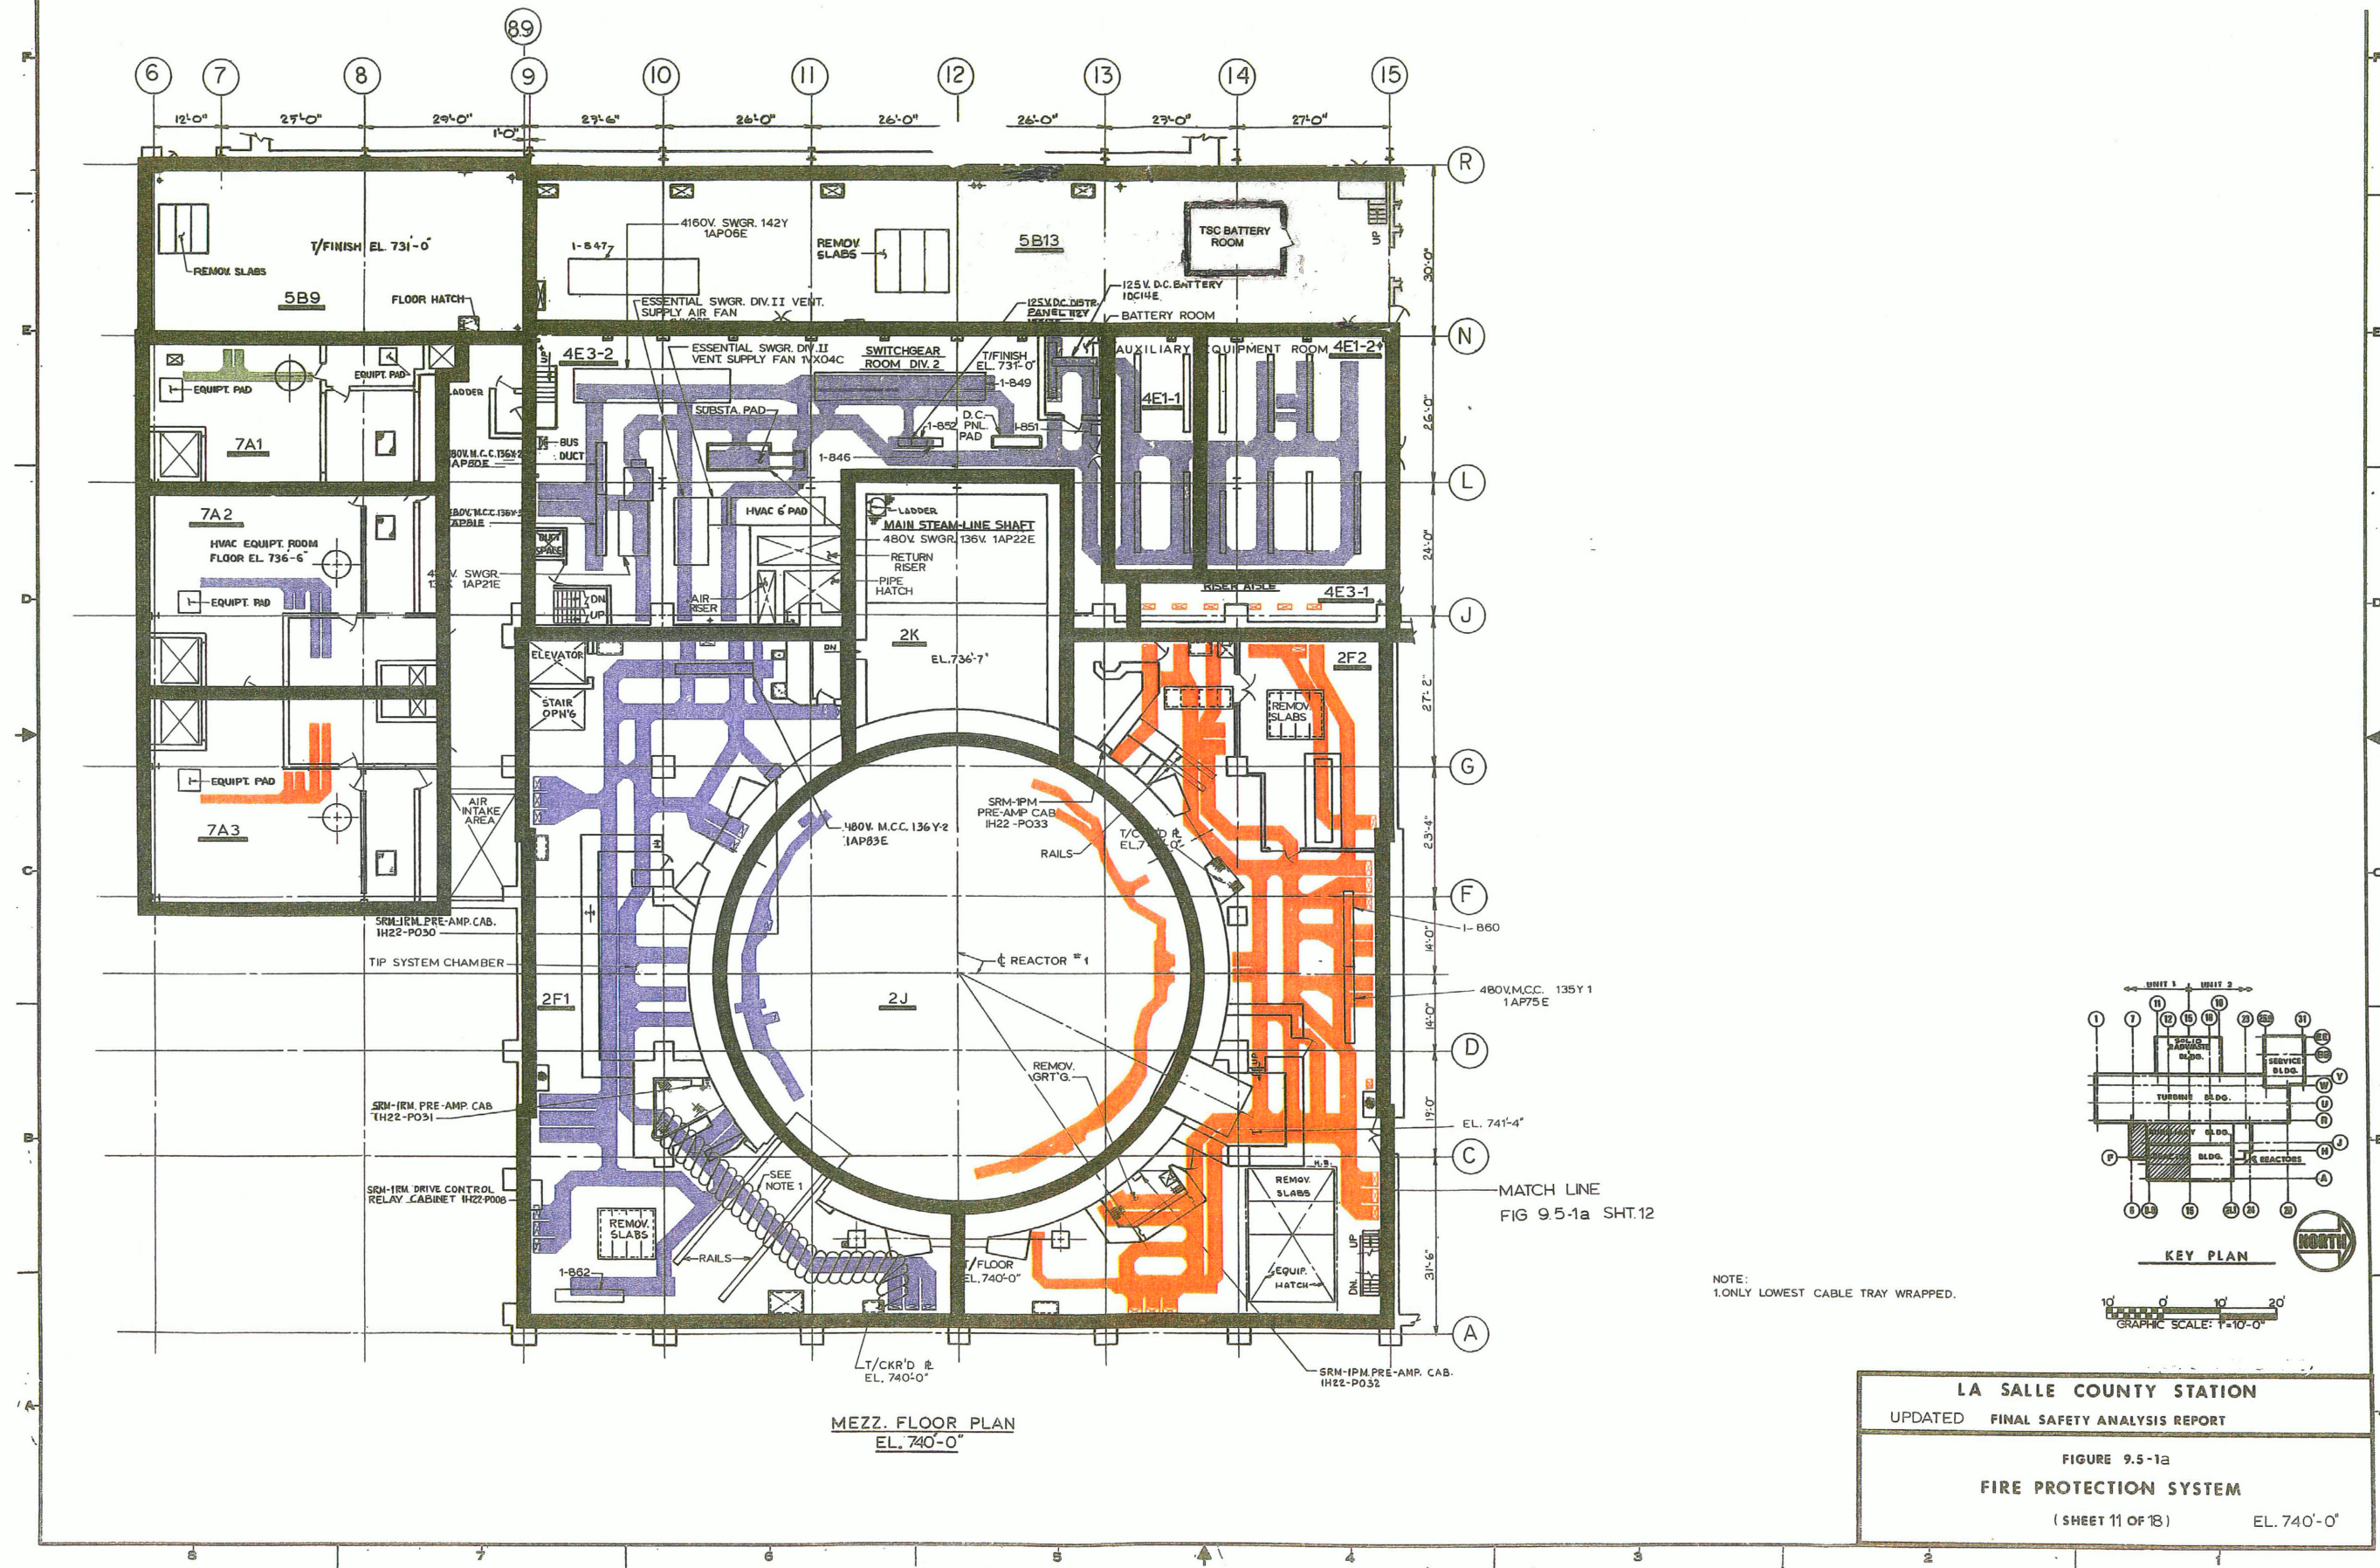


MEZZ. FLOOR PLAN  
EL. 740'-0"

NOTE:  
1. ONLY LOWEST CABLE TRAY WRAPPED.

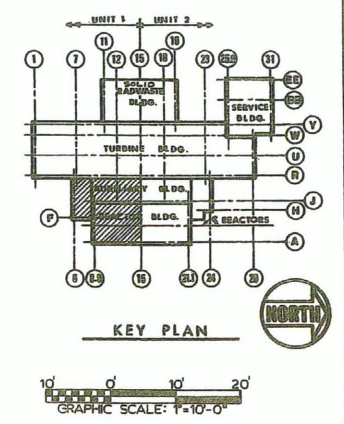


**LA SALLE COUNTY STATION**  
 UPDATED FINAL SAFETY ANALYSIS REPORT

**FIGURE 9.5-1a**  
**FIRE PROTECTION SYSTEM**  
 ( SHEET 11 OF 13 ) EL. 740'-0"

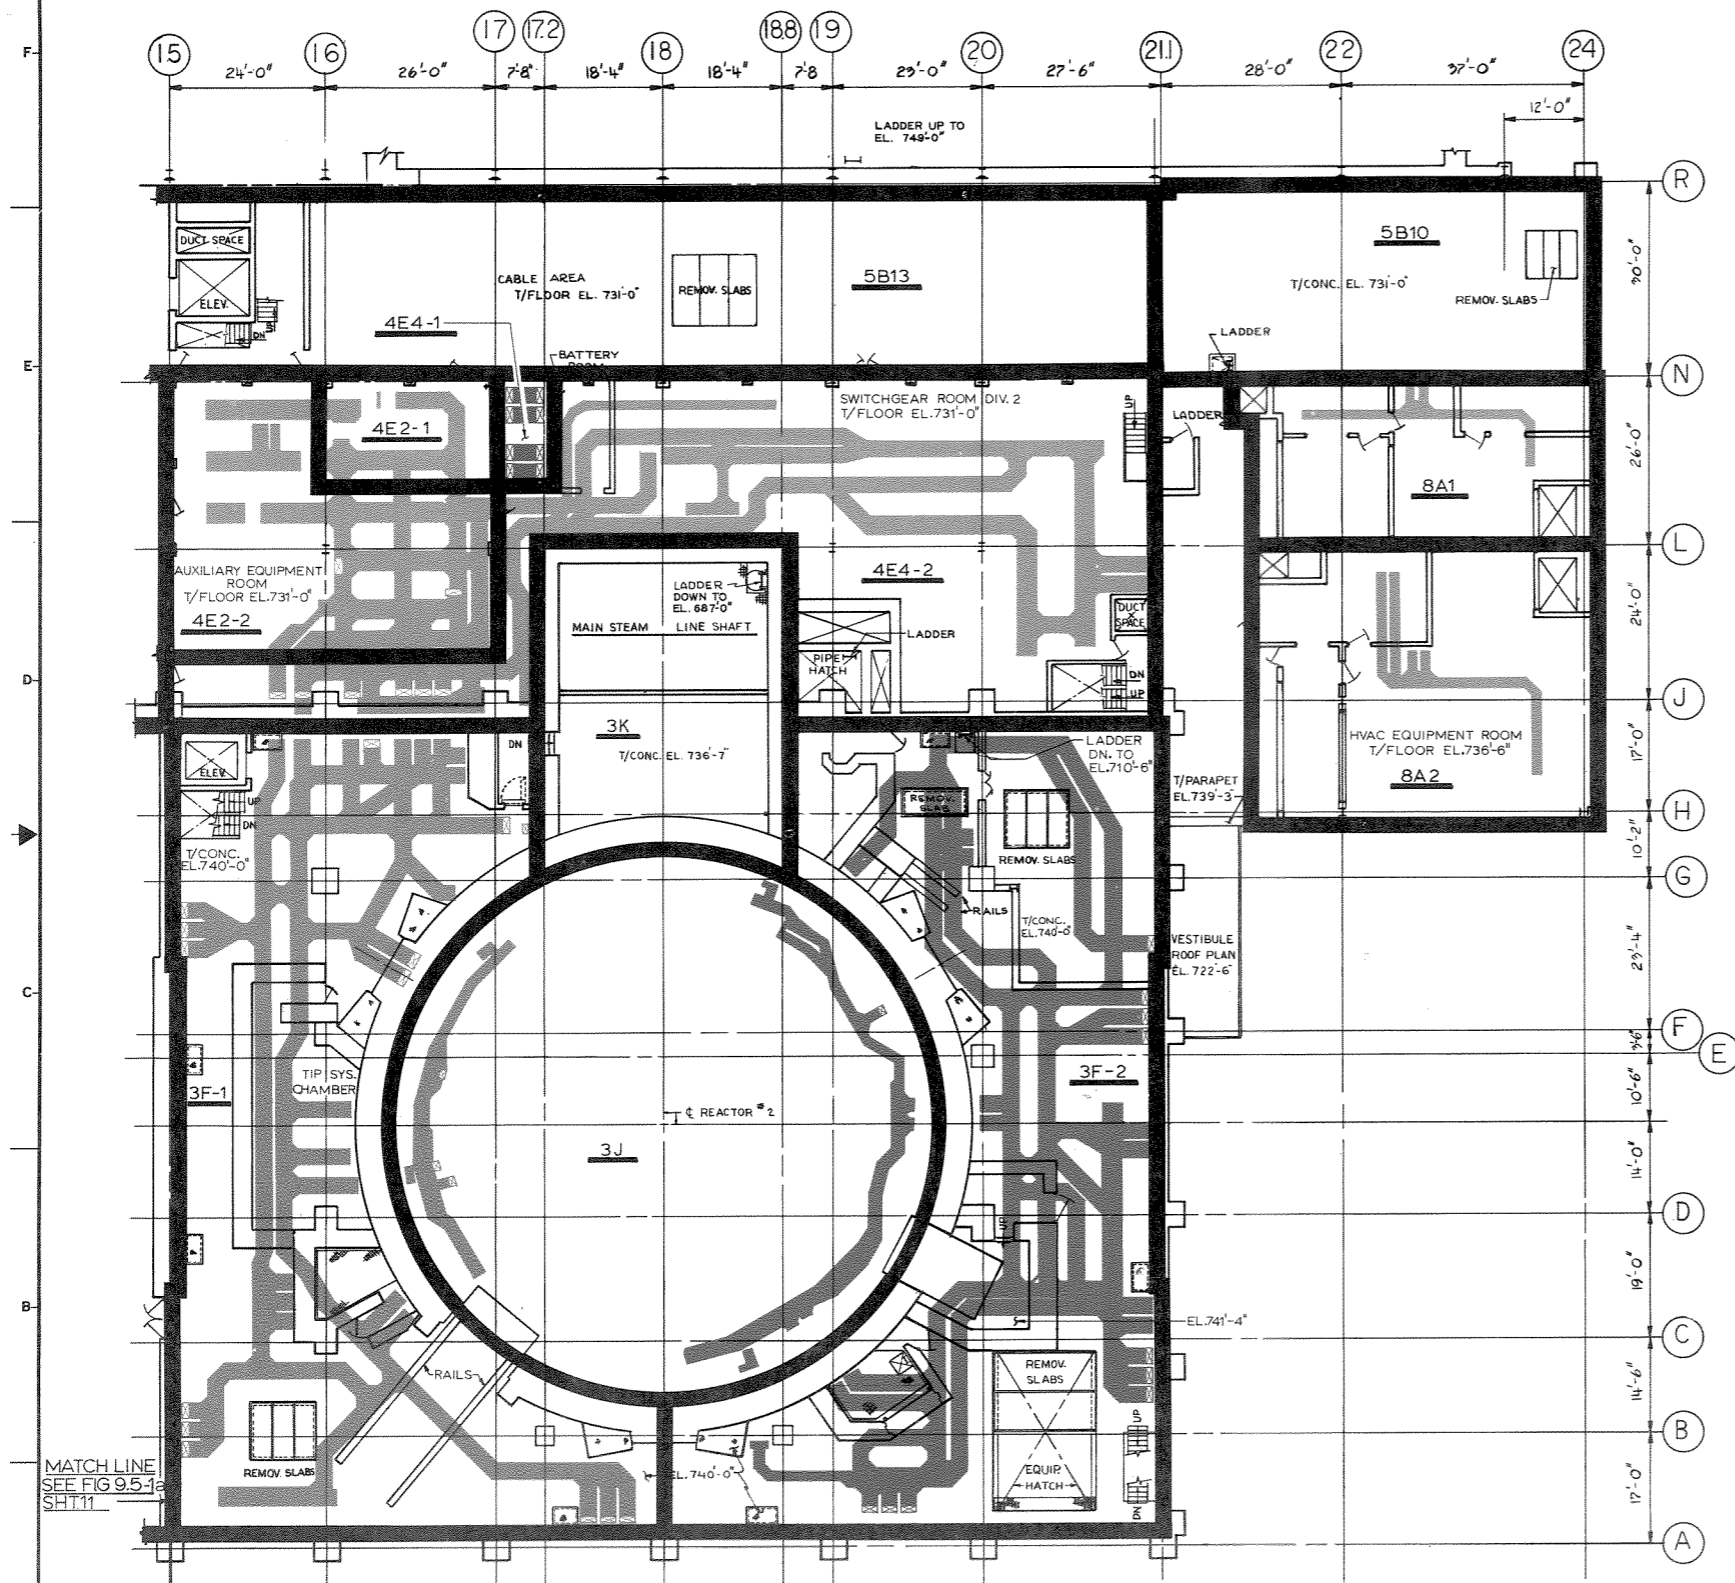


MEZZ. FLOOR PLAN  
EL. 740'-0"

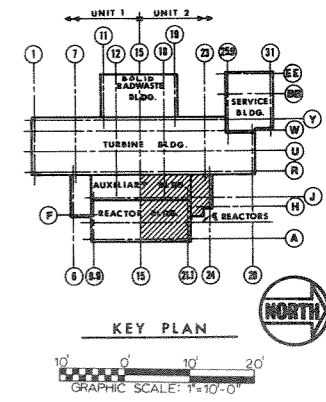

REV.3 APRIL 1987

LA SALLE COUNTY STATION  
 UPDATED FINAL SAFETY ANALYSIS REPORT


FIGURE 9.5-1a  
 FIRE PROTECTION SYSTEM  
 (SHEET 12 OF 18) EL. 740'-0"

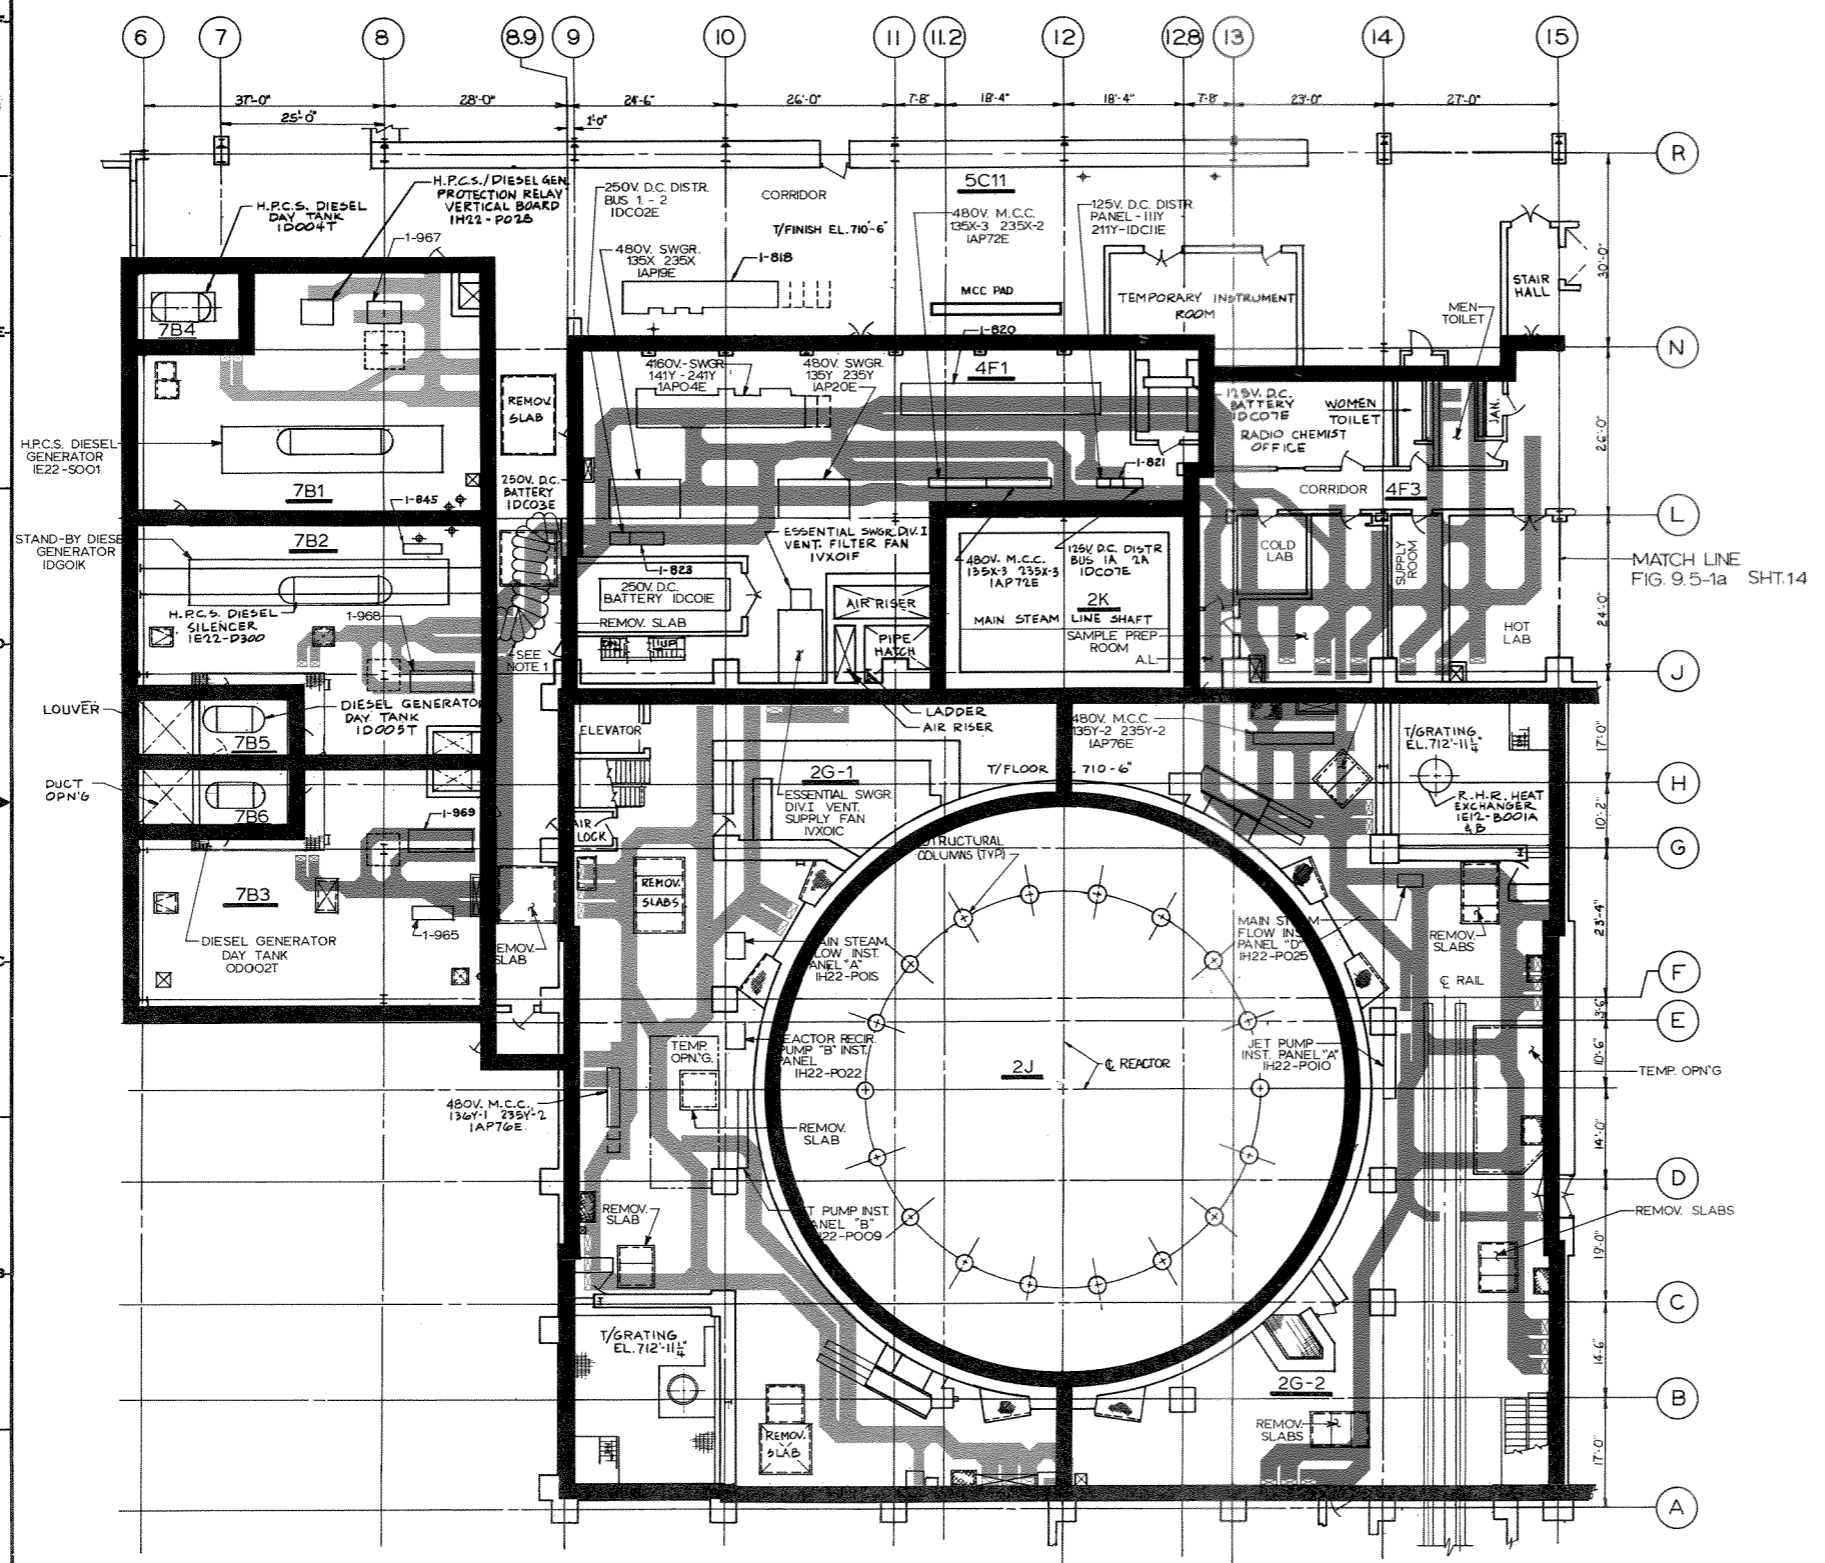

MATCH LINE  
FIG. 9.5-1a SHT. 14

GROUND FLOOR PLAN  
EL. 710'-6"


NOTE:  
1. ONLY LOWEST CABLE TRAY WRAPPED.

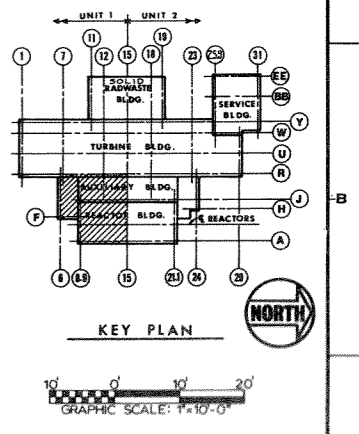

REV. 3 APRIL 1987


**LA SALLE COUNTY STATION**  
 UPDATED FINAL SAFETY ANALYSIS REPORT

**FIGURE 9.5-1a**  
**FIRE PROTECTION SYSTEM**  
 (SHEET 13 OF 18) EL. 710'-6"

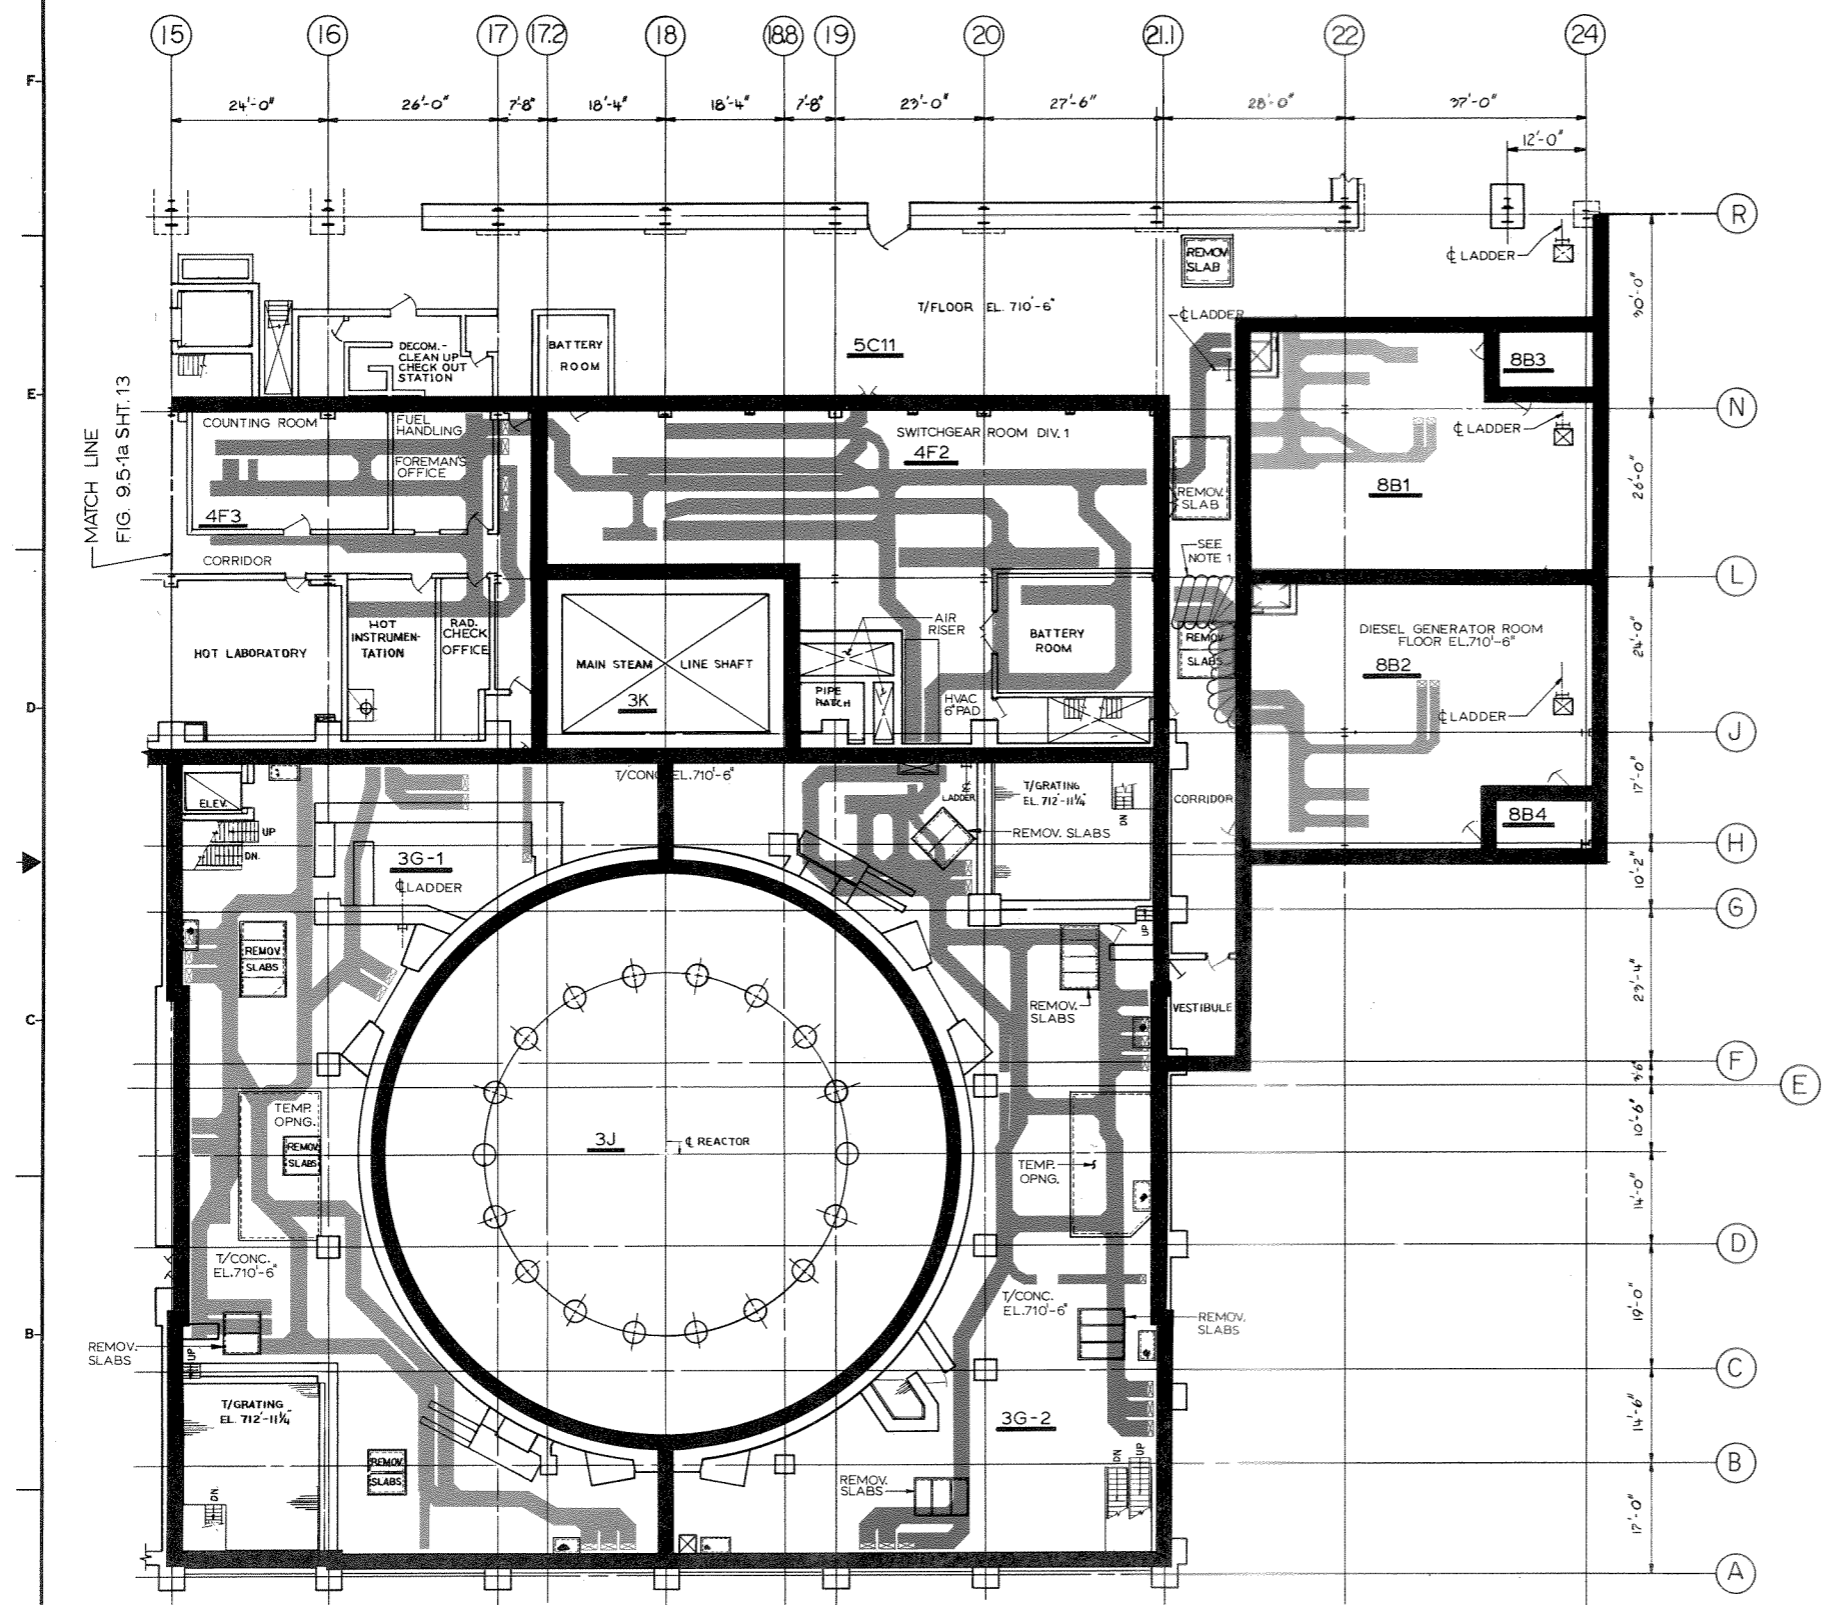

GROUND FLOOR PLAN  
EL. 710'-6"


NOTE:  
1. CABLE TRAYS ARE WRAPPED SEPARATELY.

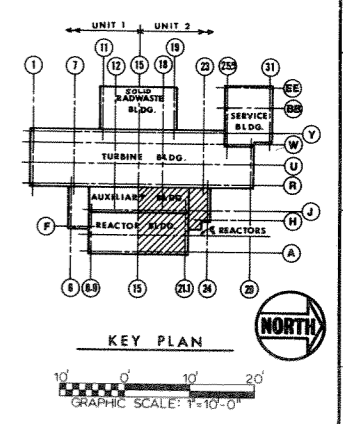


REV. 3 APRIL 1987

**LA SALLE COUNTY STATION**  
UPDATED FINAL SAFETY ANALYSIS REPORT

FIGURE 9.5-12  
**FIRE PROTECTION SYSTEM**  
(SHEET 14 OF 18) EL. 710'-6"

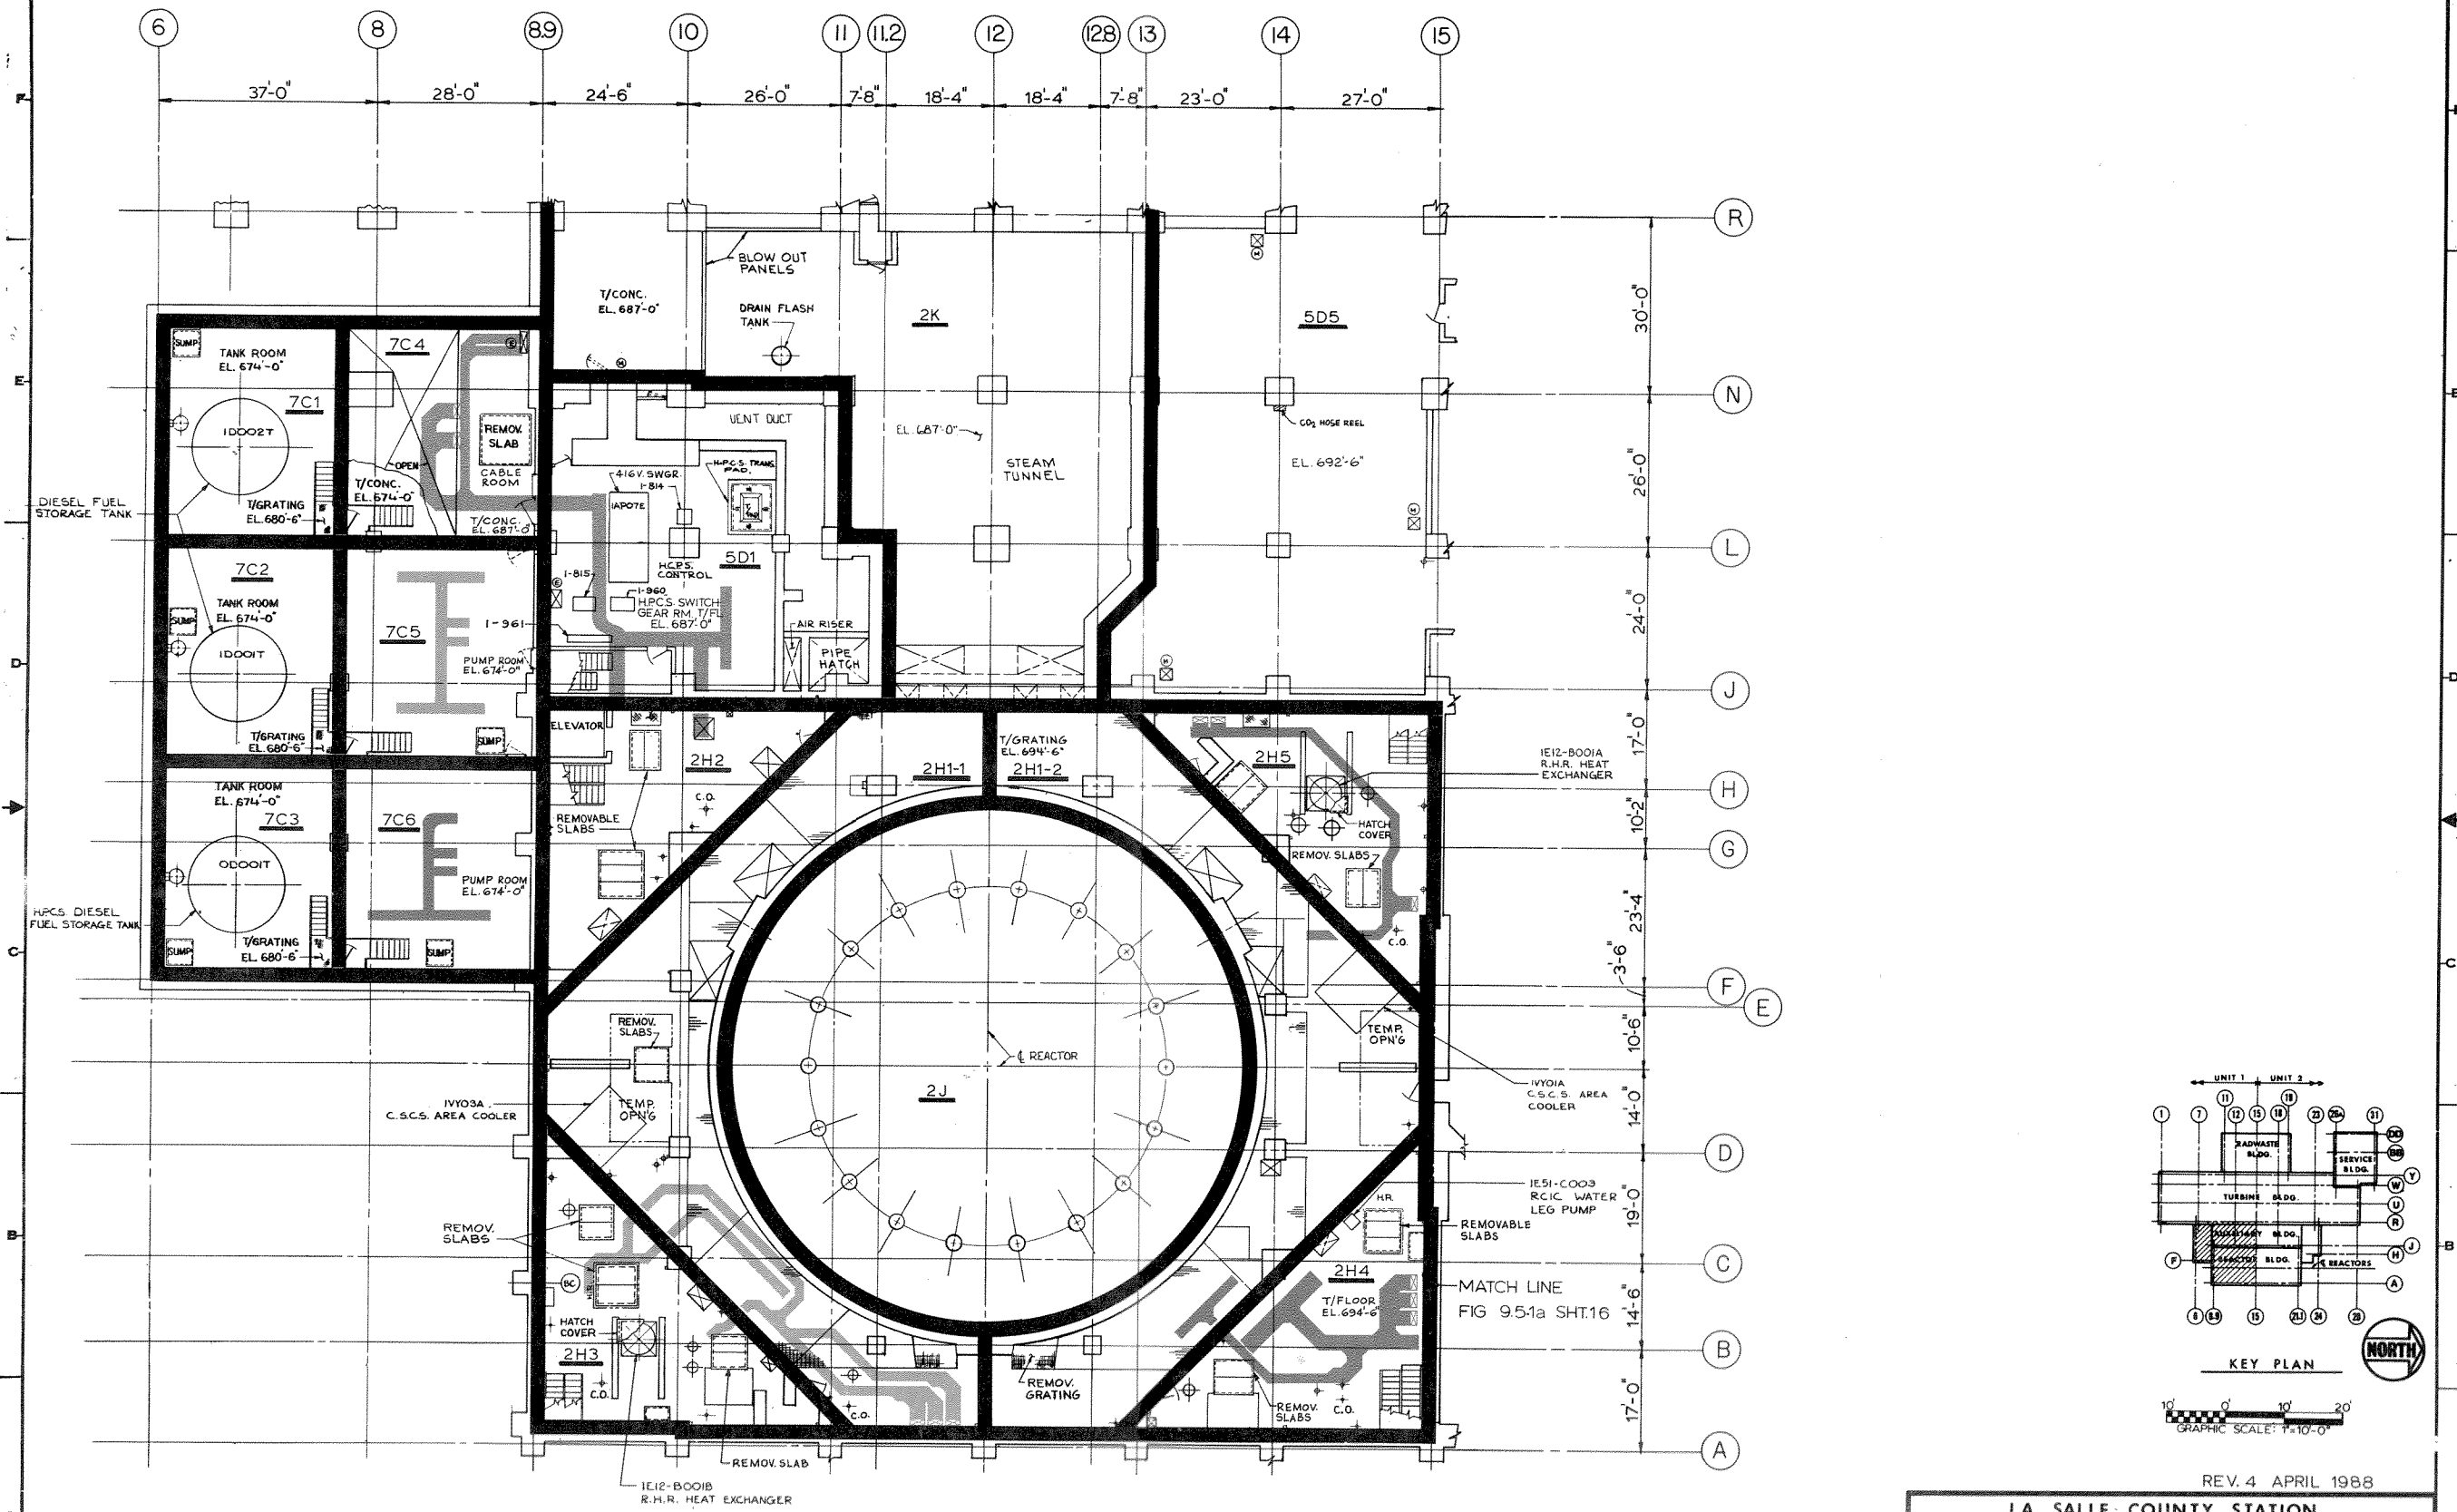


UPPER BASEMENT FLOOR PLAN  
EL. 687'-0"

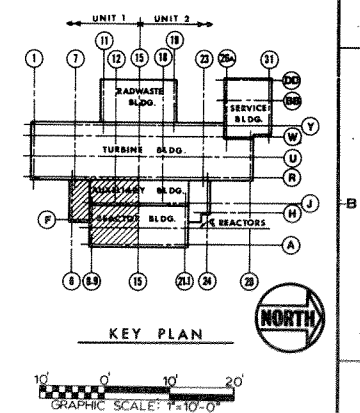


REV. 4 APRIL 1988

**LA SALLE COUNTY STATION**  
 UPDATED FINAL SAFETY ANALYSIS REPORT

**FIGURE 9.5-1a**  
**FIRE PROTECTION SYSTEM**  
 (SHEET 15 OF 18) EL. 687'-0"

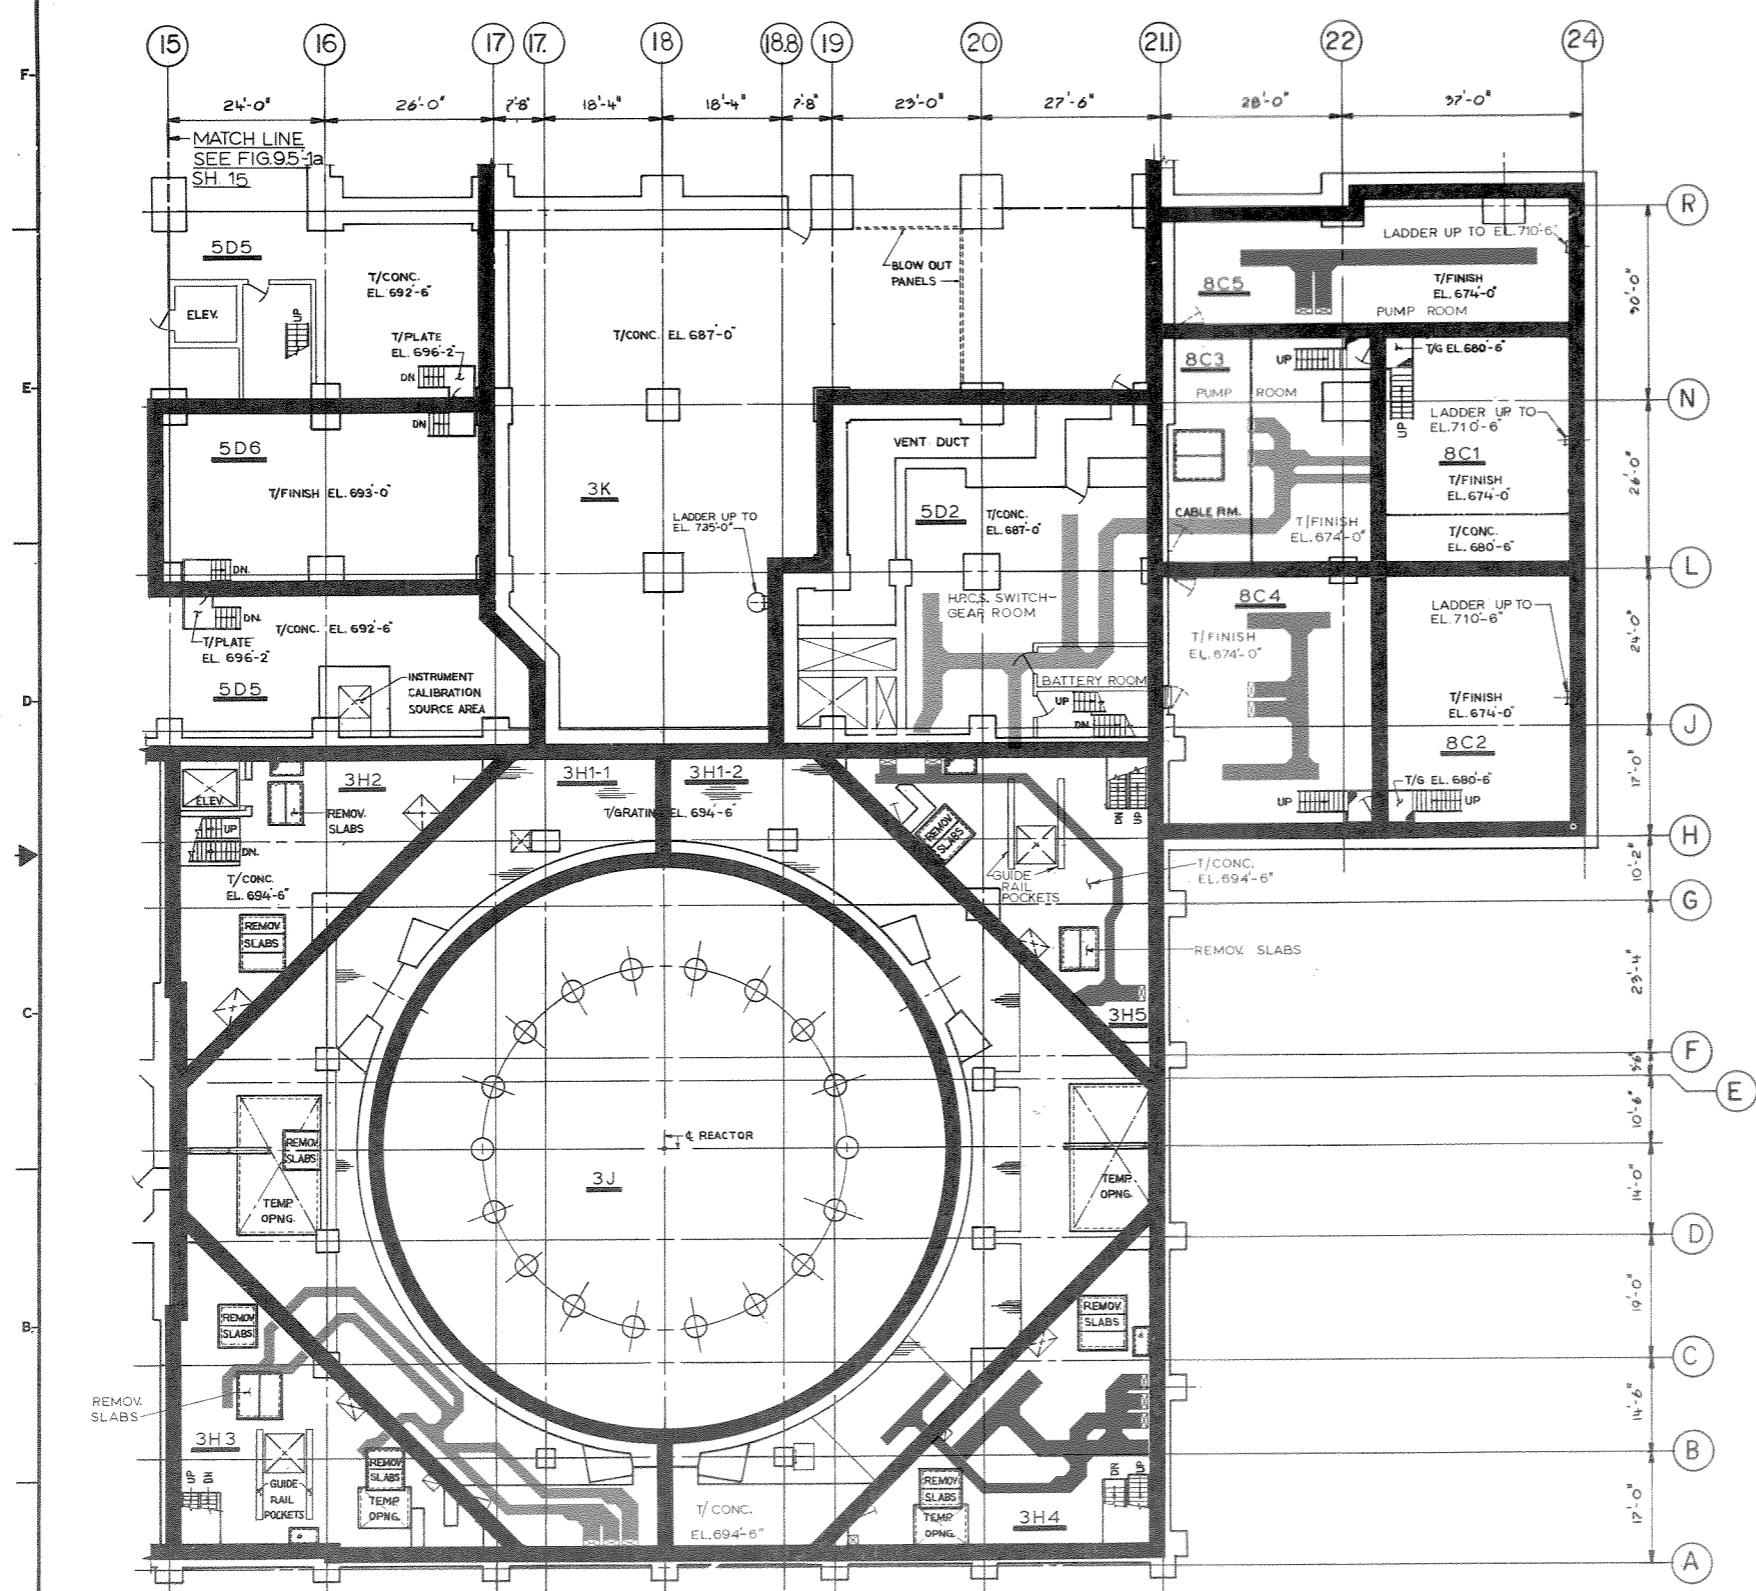

UPPER BASEMENT FLOOR PLAN  
EL. 687'-0"

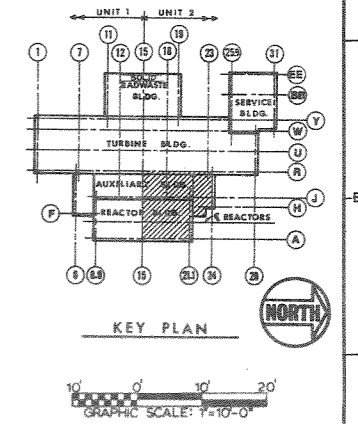


REV. 3 APRIL 1987

LA SALLE COUNTY STATION  
 UPDATED FINAL SAFETY ANALYSIS REPORT


FIGURE 9.5-1a  
 FIRE PROTECTION SYSTEM  
 (SHEET 16 OF 18) EL. 687'-0"



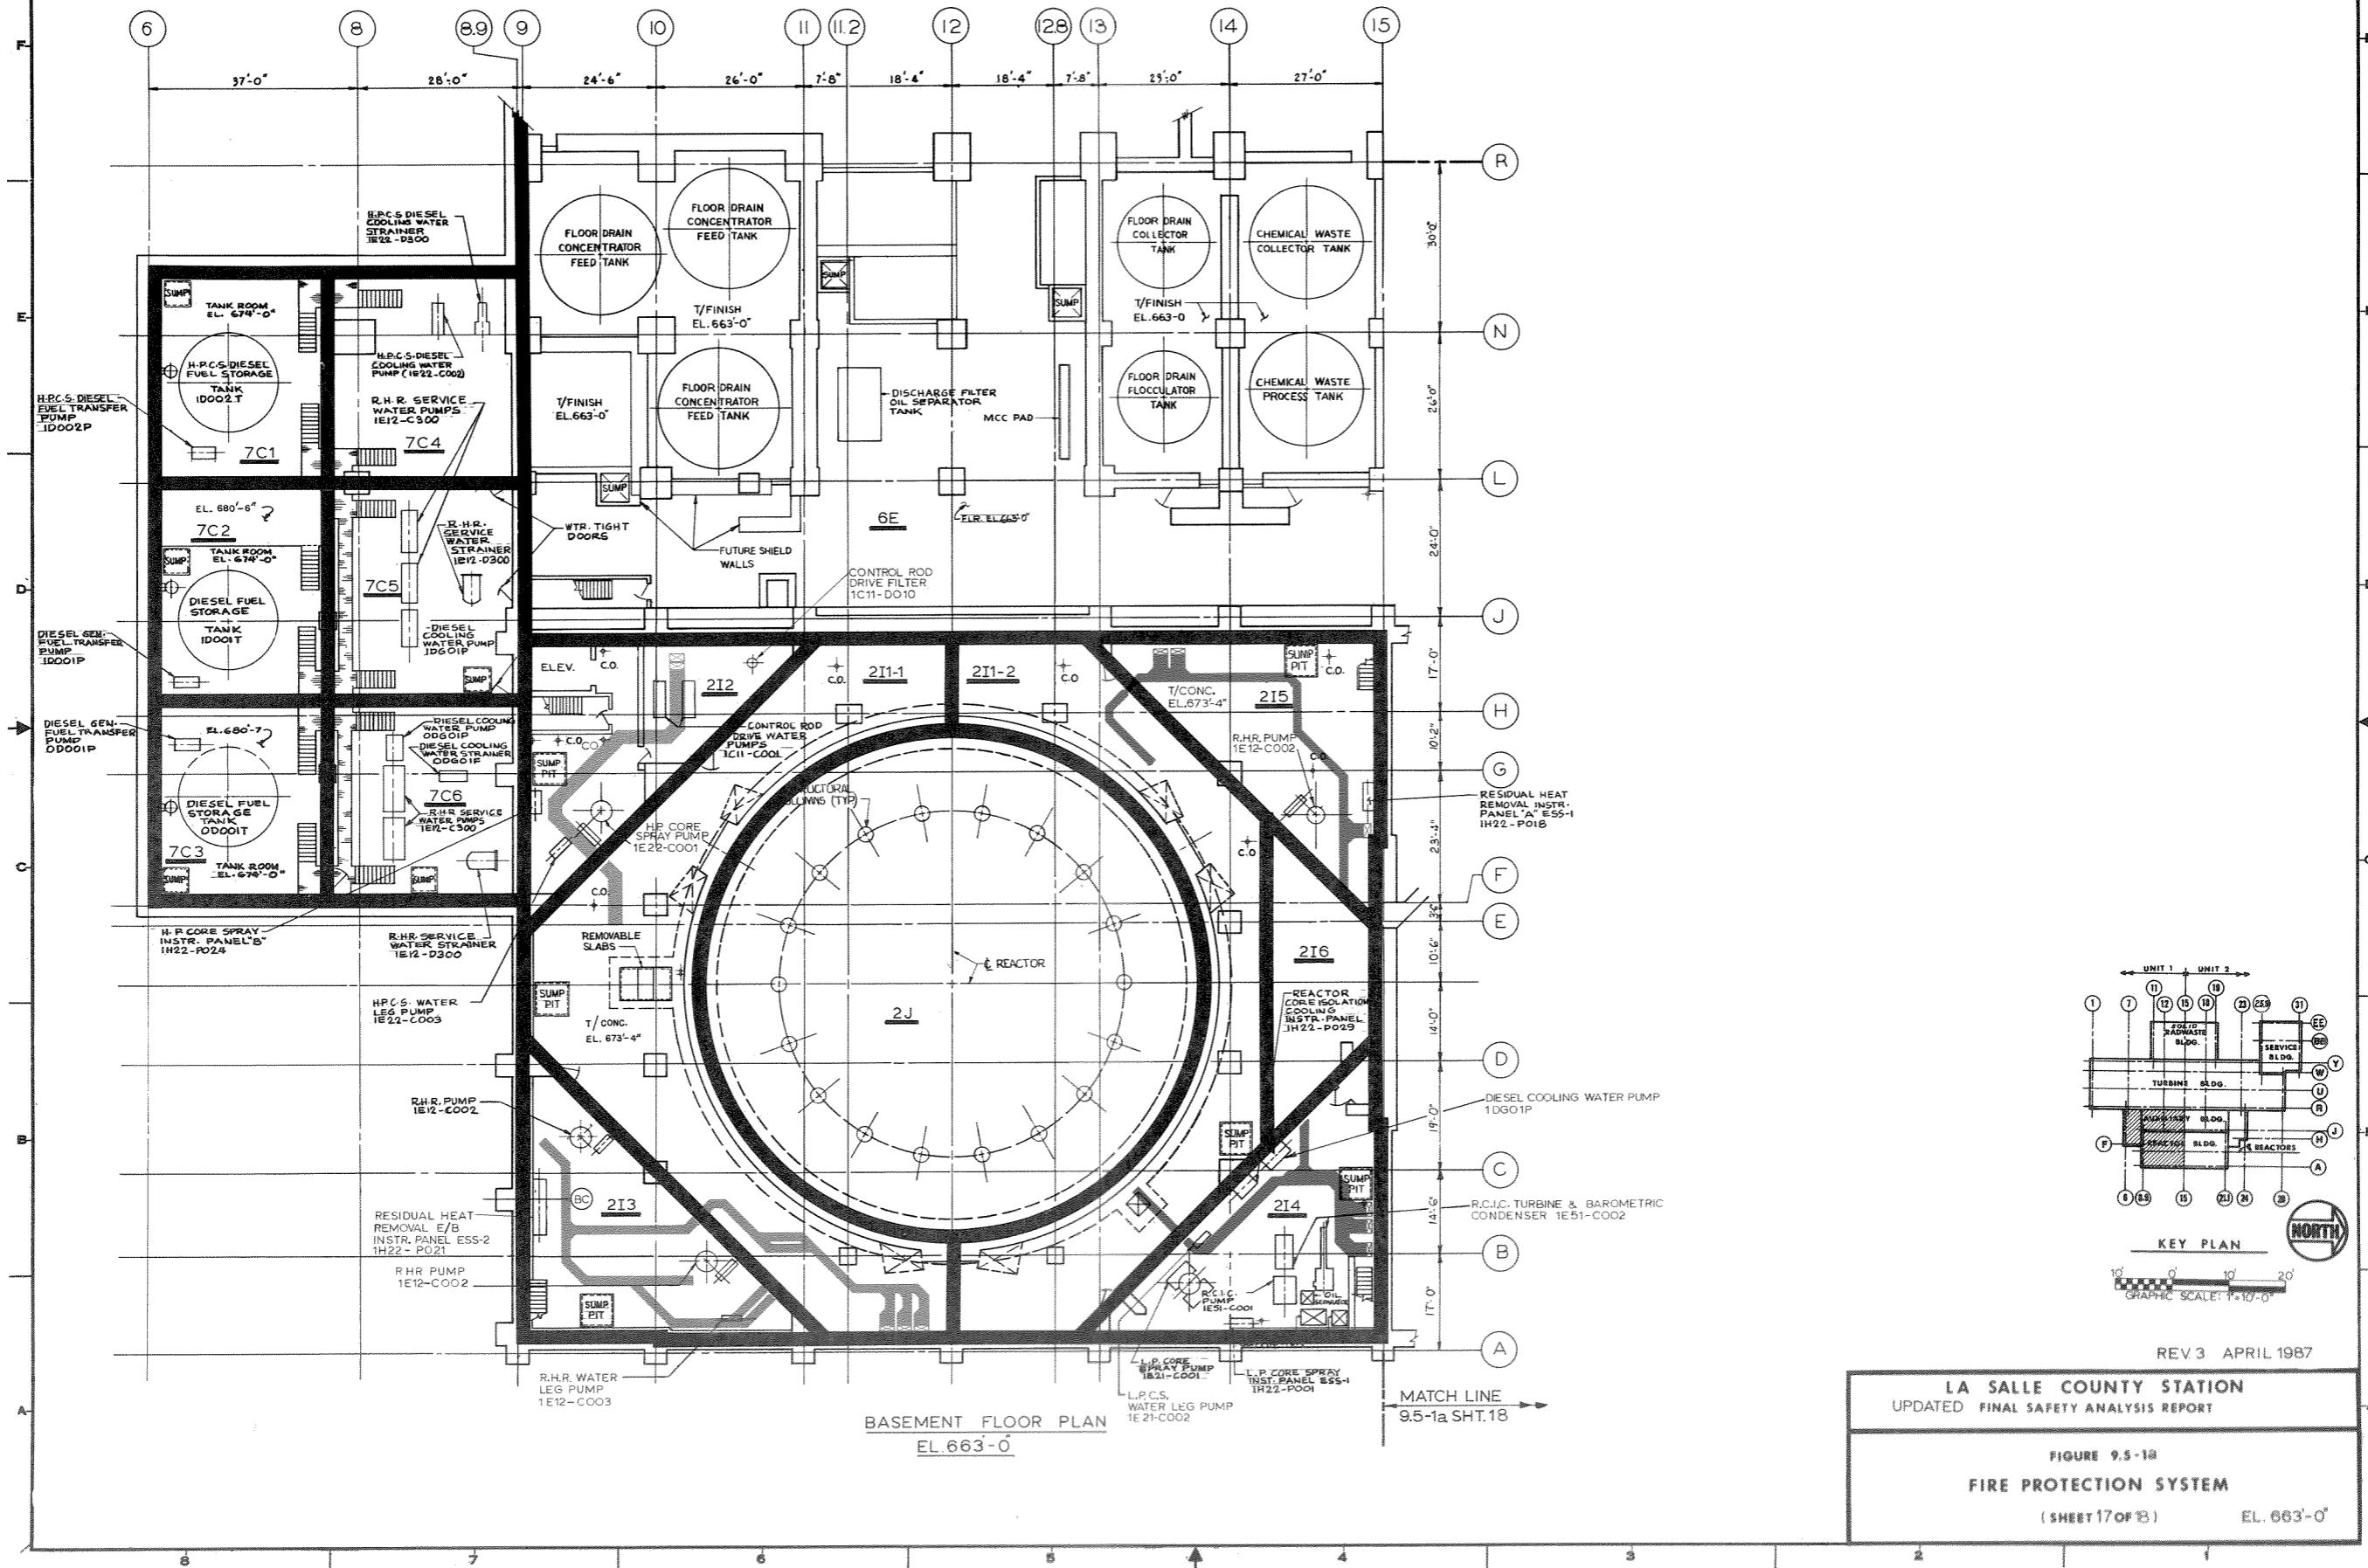

BASEMENT FLOOR PLAN  
EL. 663'-0"


MATCH LINE  
9.5-1a SHT. 18

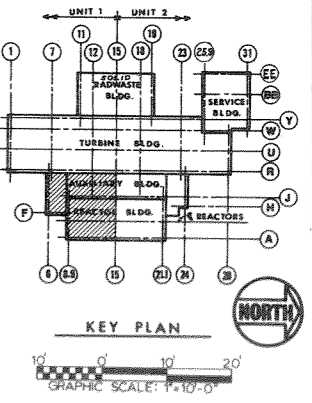

REV. 3 APRIL 1987

LA SALLE COUNTY STATION  
UPDATED FINAL SAFETY ANALYSIS REPORT

FIGURE 9.5-18  
FIRE PROTECTION SYSTEM  
(SHEET 17 OF 18) EL. 663'-0"

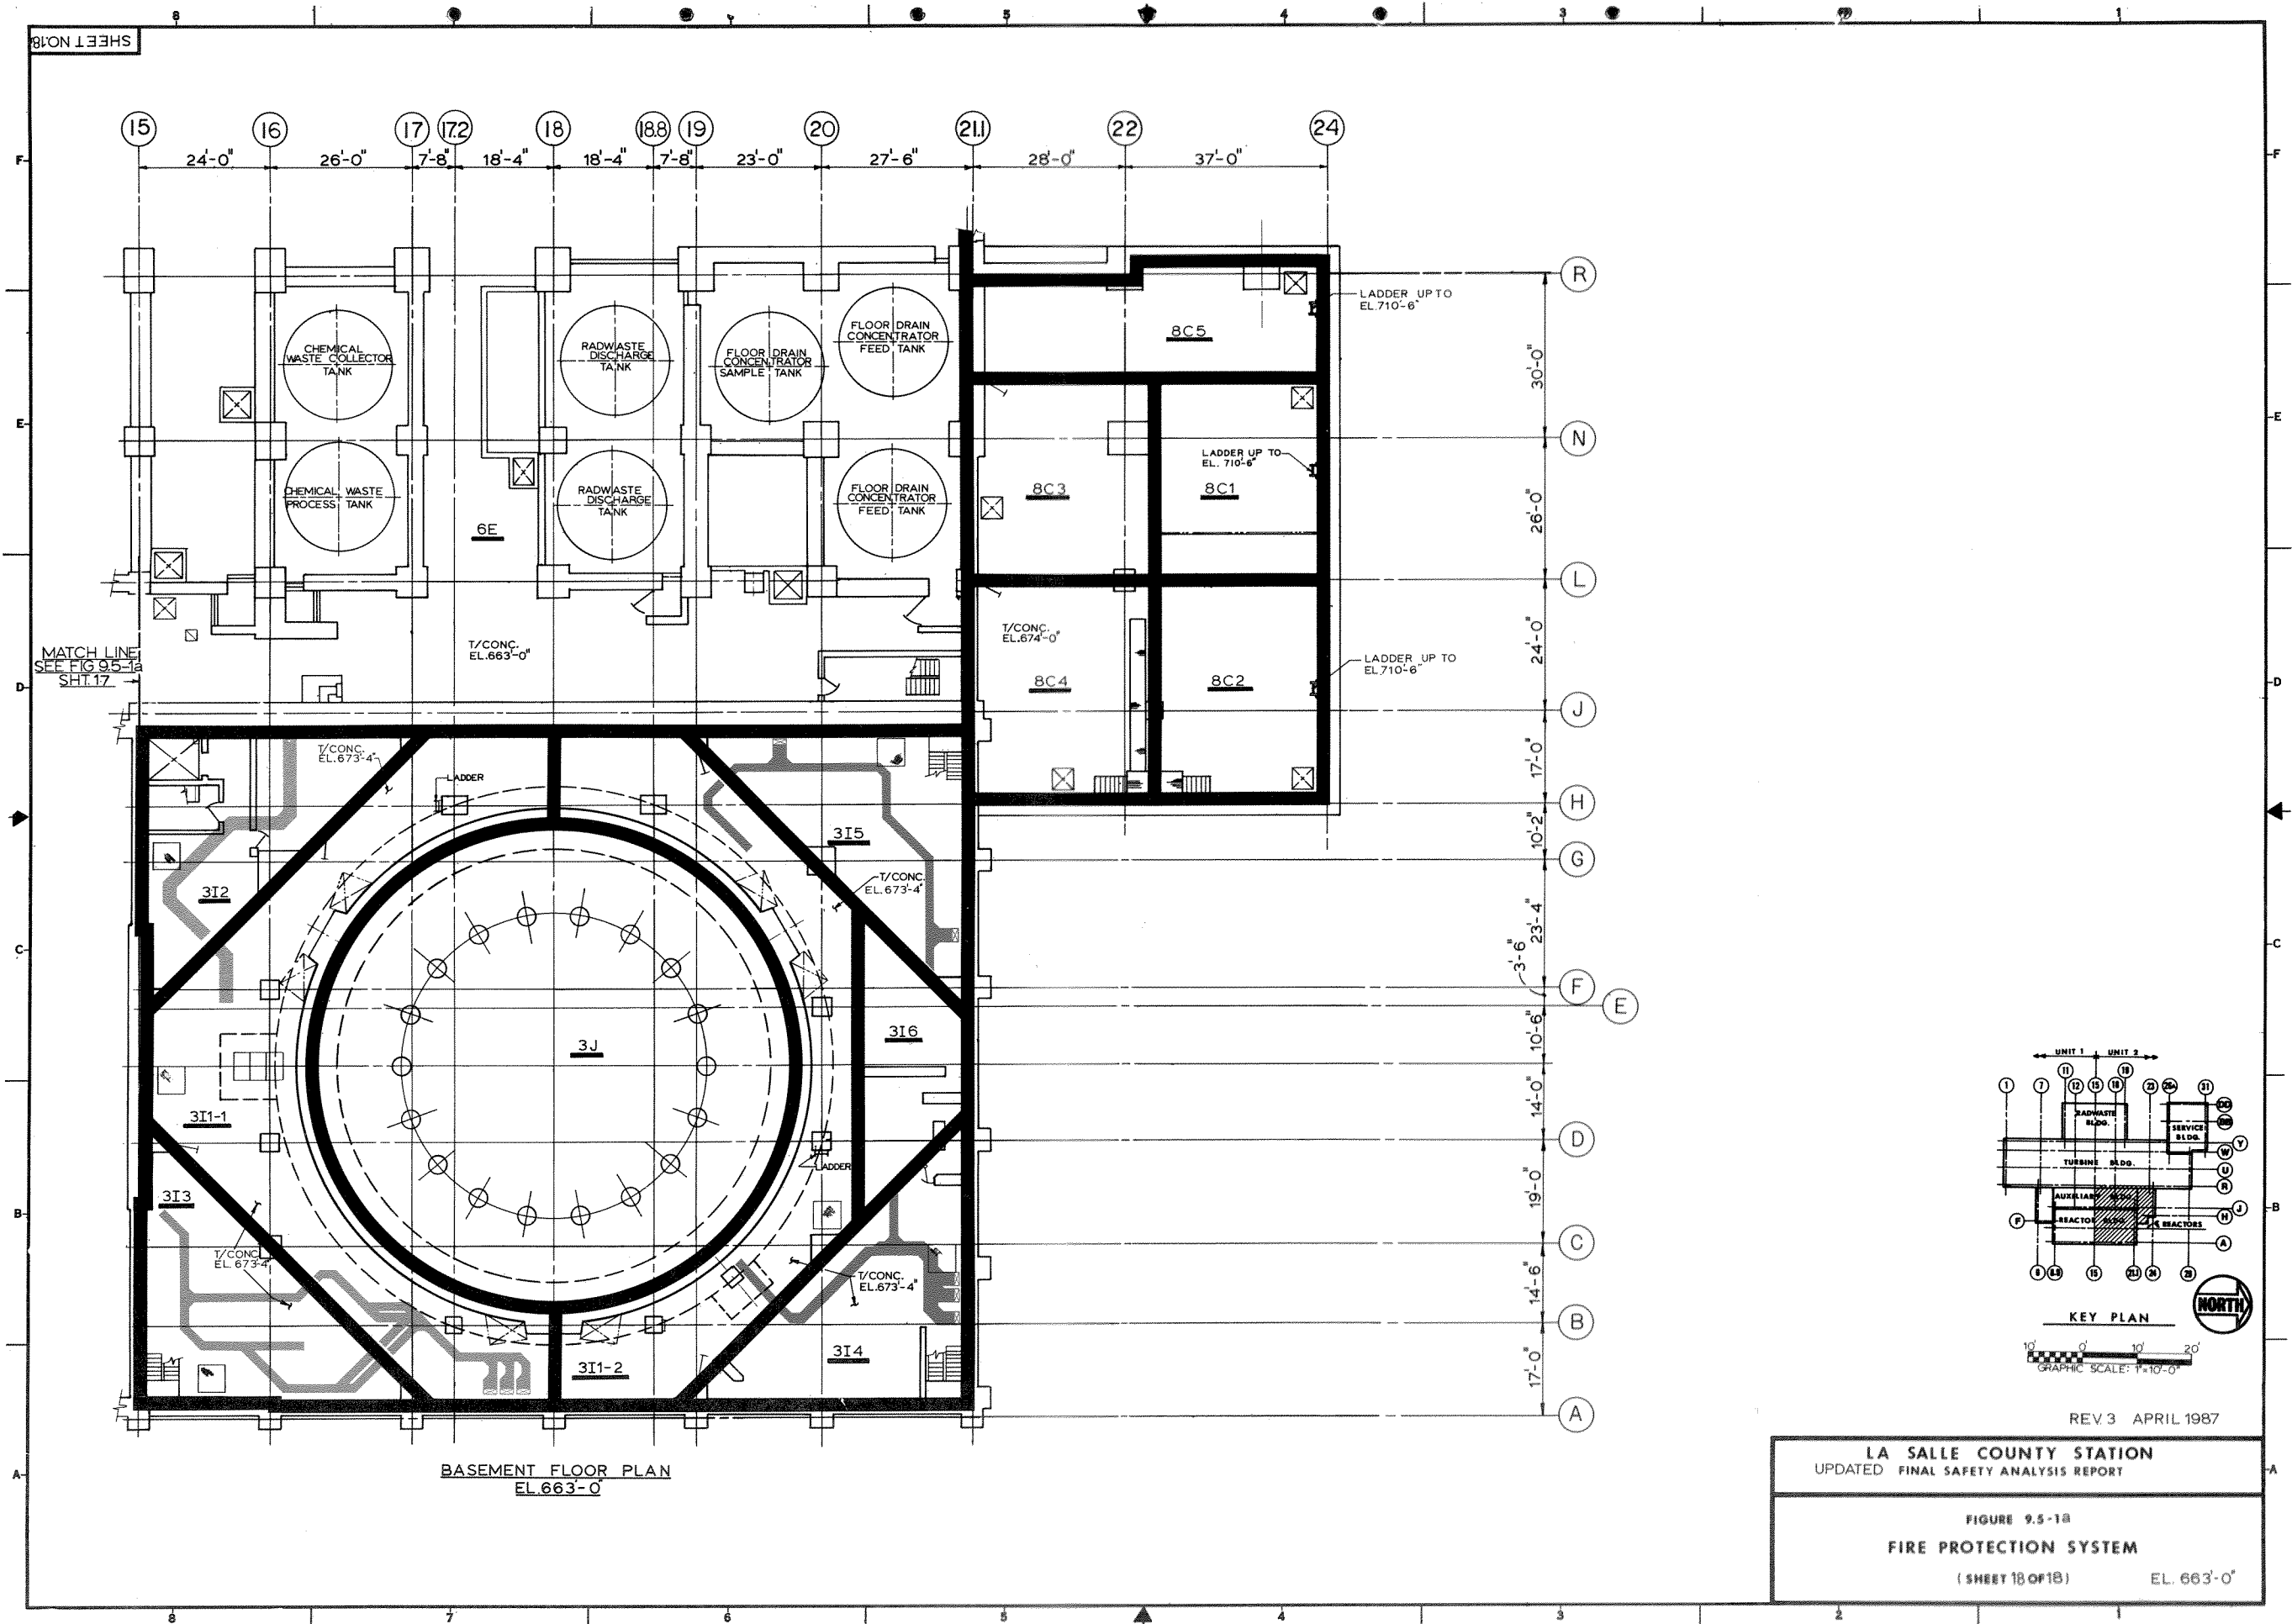


BASEMENT FLOOR PLAN  
EL. 663'-0"

REV. 3 APRIL 1987

**LA SALLE COUNTY STATION**  
UPDATED FINAL SAFETY ANALYSIS REPORT

FIGURE 9.5-18  
**FIRE PROTECTION SYSTEM**  
(SHEET 18 OF 18) EL. 663'-0"

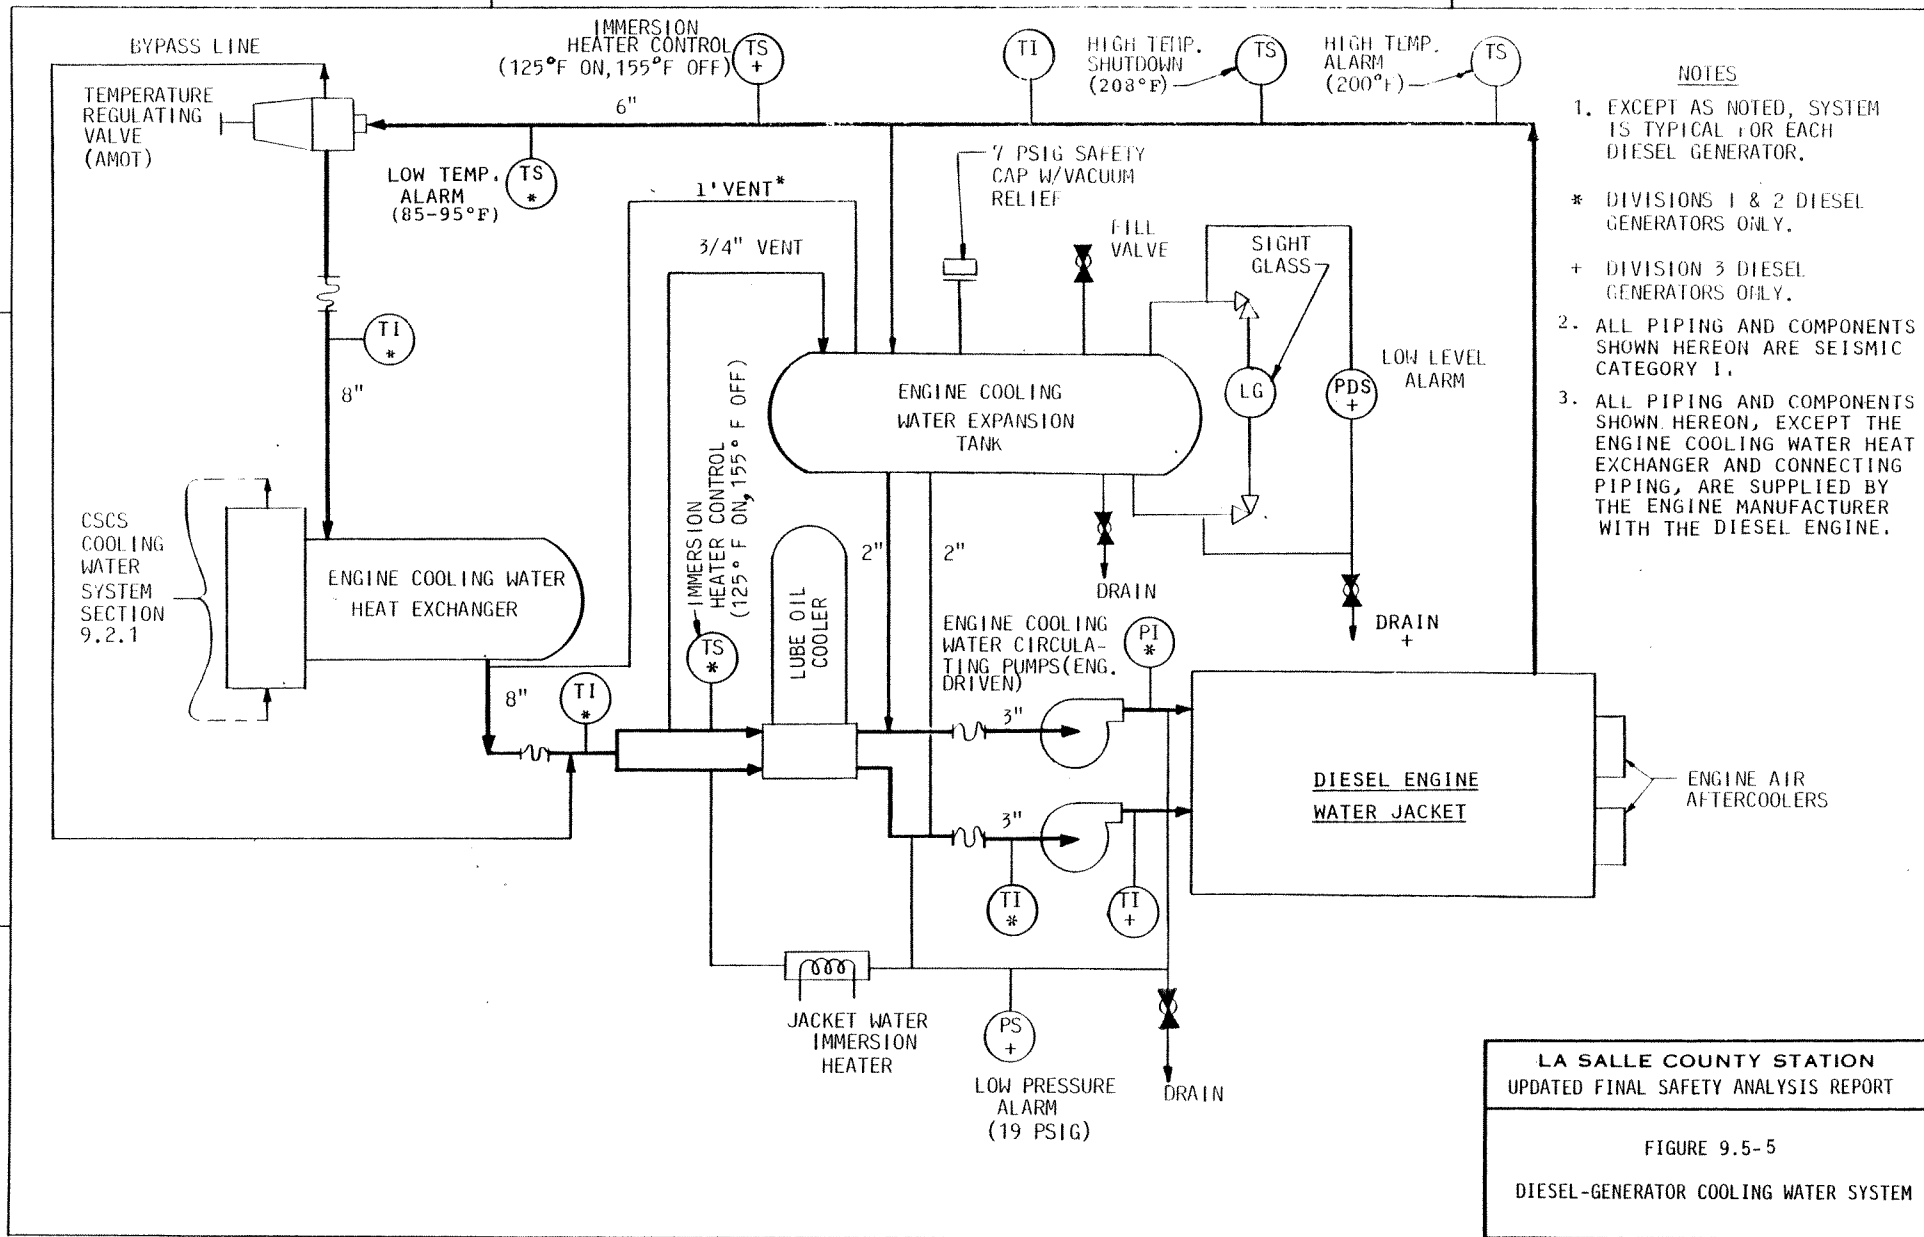


**NOTES**


1. EXCEPT AS NOTED, SYSTEM IS TYPICAL FOR EACH DIESEL GENERATOR.
- \* DIVISIONS 1 & 2 DIESEL GENERATORS ONLY.
- + DIVISION 3 DIESEL GENERATORS ONLY.
2. ALL PIPING AND COMPONENTS SHOWN HEREON ARE SEISMIC CATEGORY 1.
3. ALL PIPING AND COMPONENTS SHOWN HEREON, EXCEPT THE ENGINE COOLING WATER HEAT EXCHANGER AND CONNECTING PIPING, ARE SUPPLIED BY THE ENGINE MANUFACTURER WITH THE DIESEL ENGINE.

LA SALLE COUNTY STATION  
 UPDATED FINAL SAFETY ANALYSIS REPORT  
 FIGURE 9.5-5  
 DIESEL-GENERATOR COOLING WATER SYSTEM



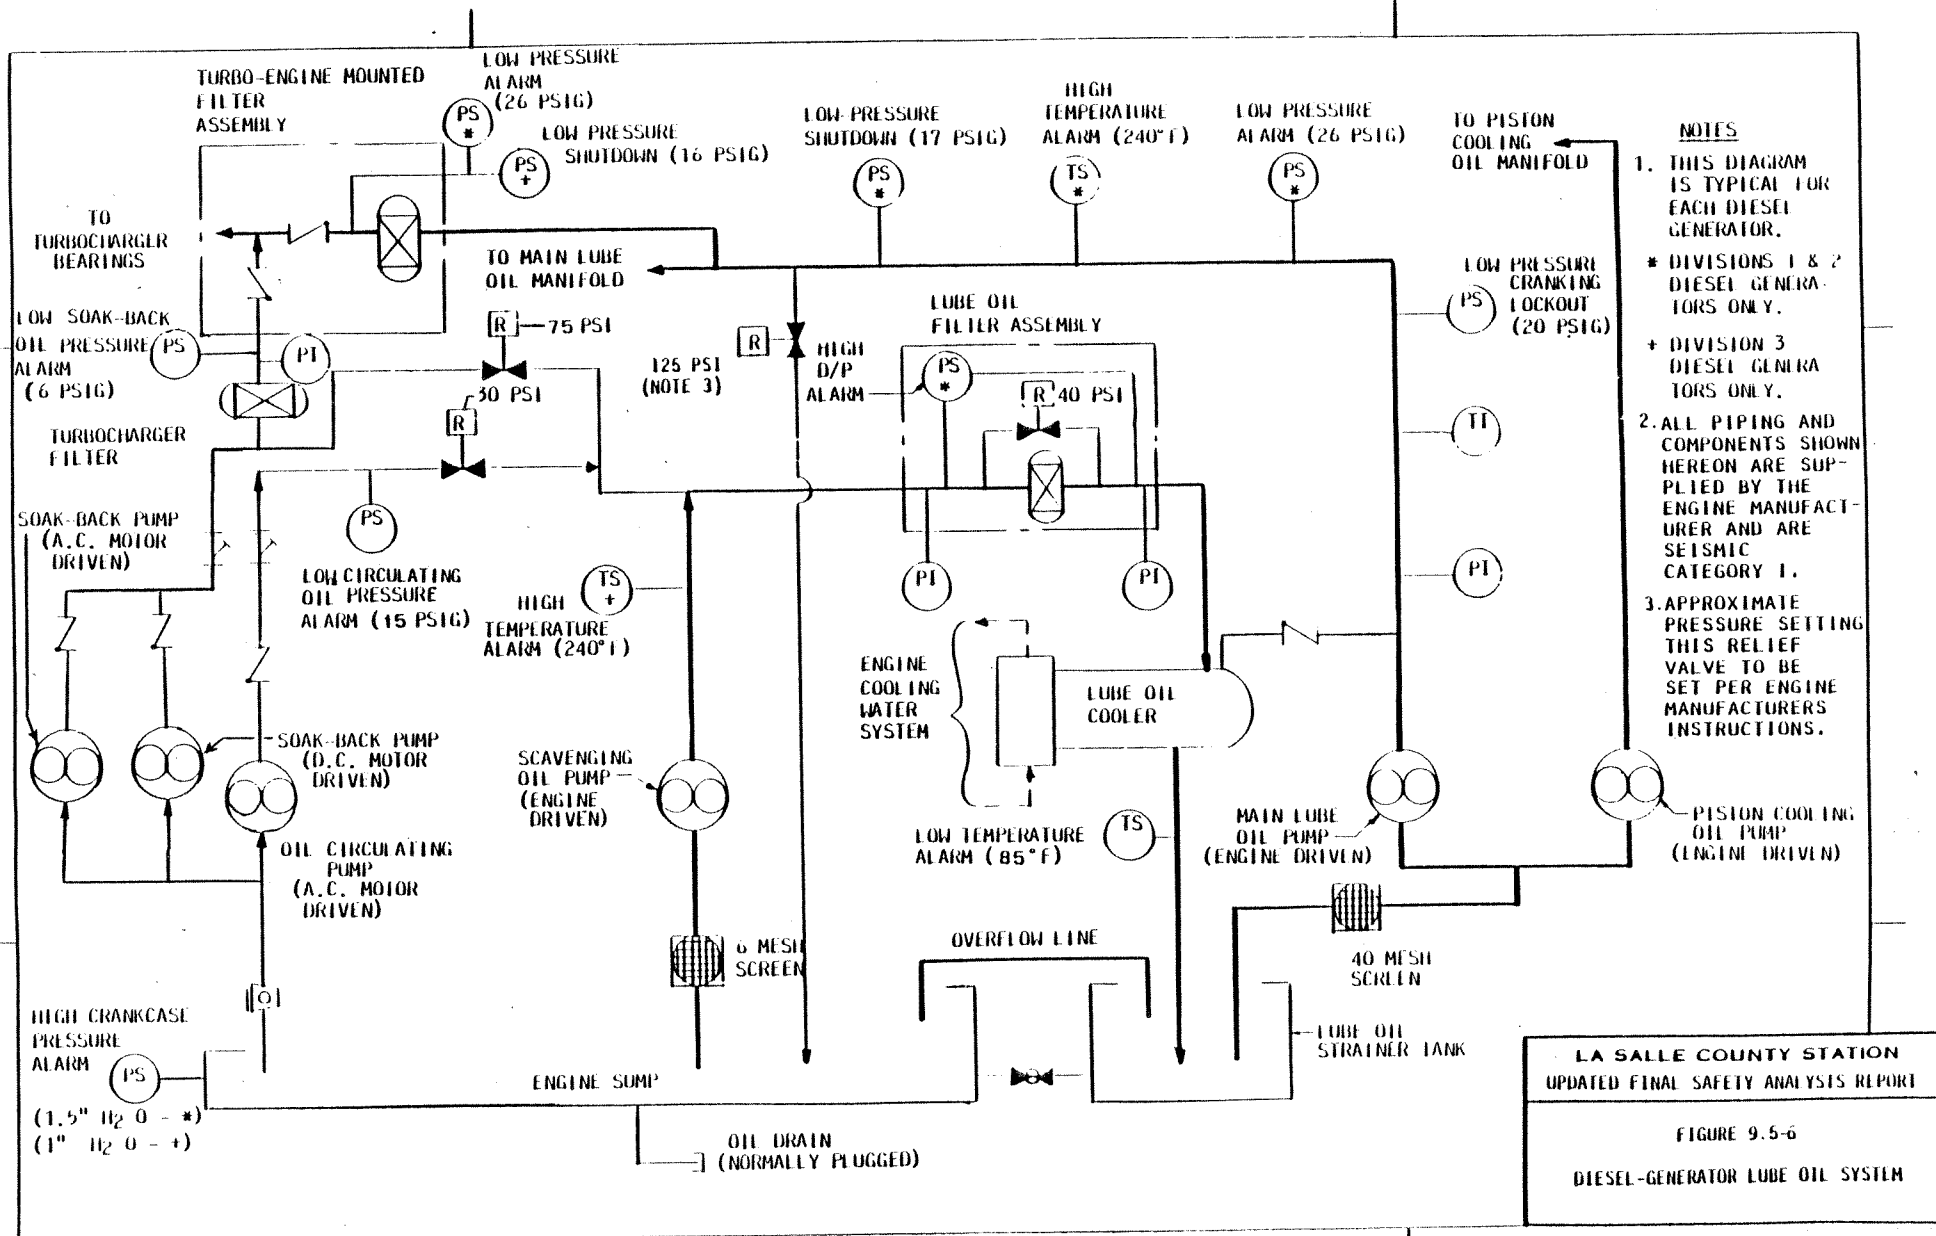

- NOTES**
1. THIS DIAGRAM IS TYPICAL FOR EACH DIESEL GENERATOR.
  - \* DIVISIONS 1 & 2 DIESEL GENERATORS ONLY.
  - + DIVISION 3 DIESEL GENERATORS ONLY.
  2. ALL PIPING AND COMPONENTS SHOWN HEREON ARE SUPPLIED BY THE ENGINE MANUFACTURER AND ARE SEISMIC CATEGORY 1.
  3. APPROXIMATE PRESSURE SETTING THIS RELIEF VALVE TO BE SET PER ENGINE MANUFACTURERS INSTRUCTIONS.

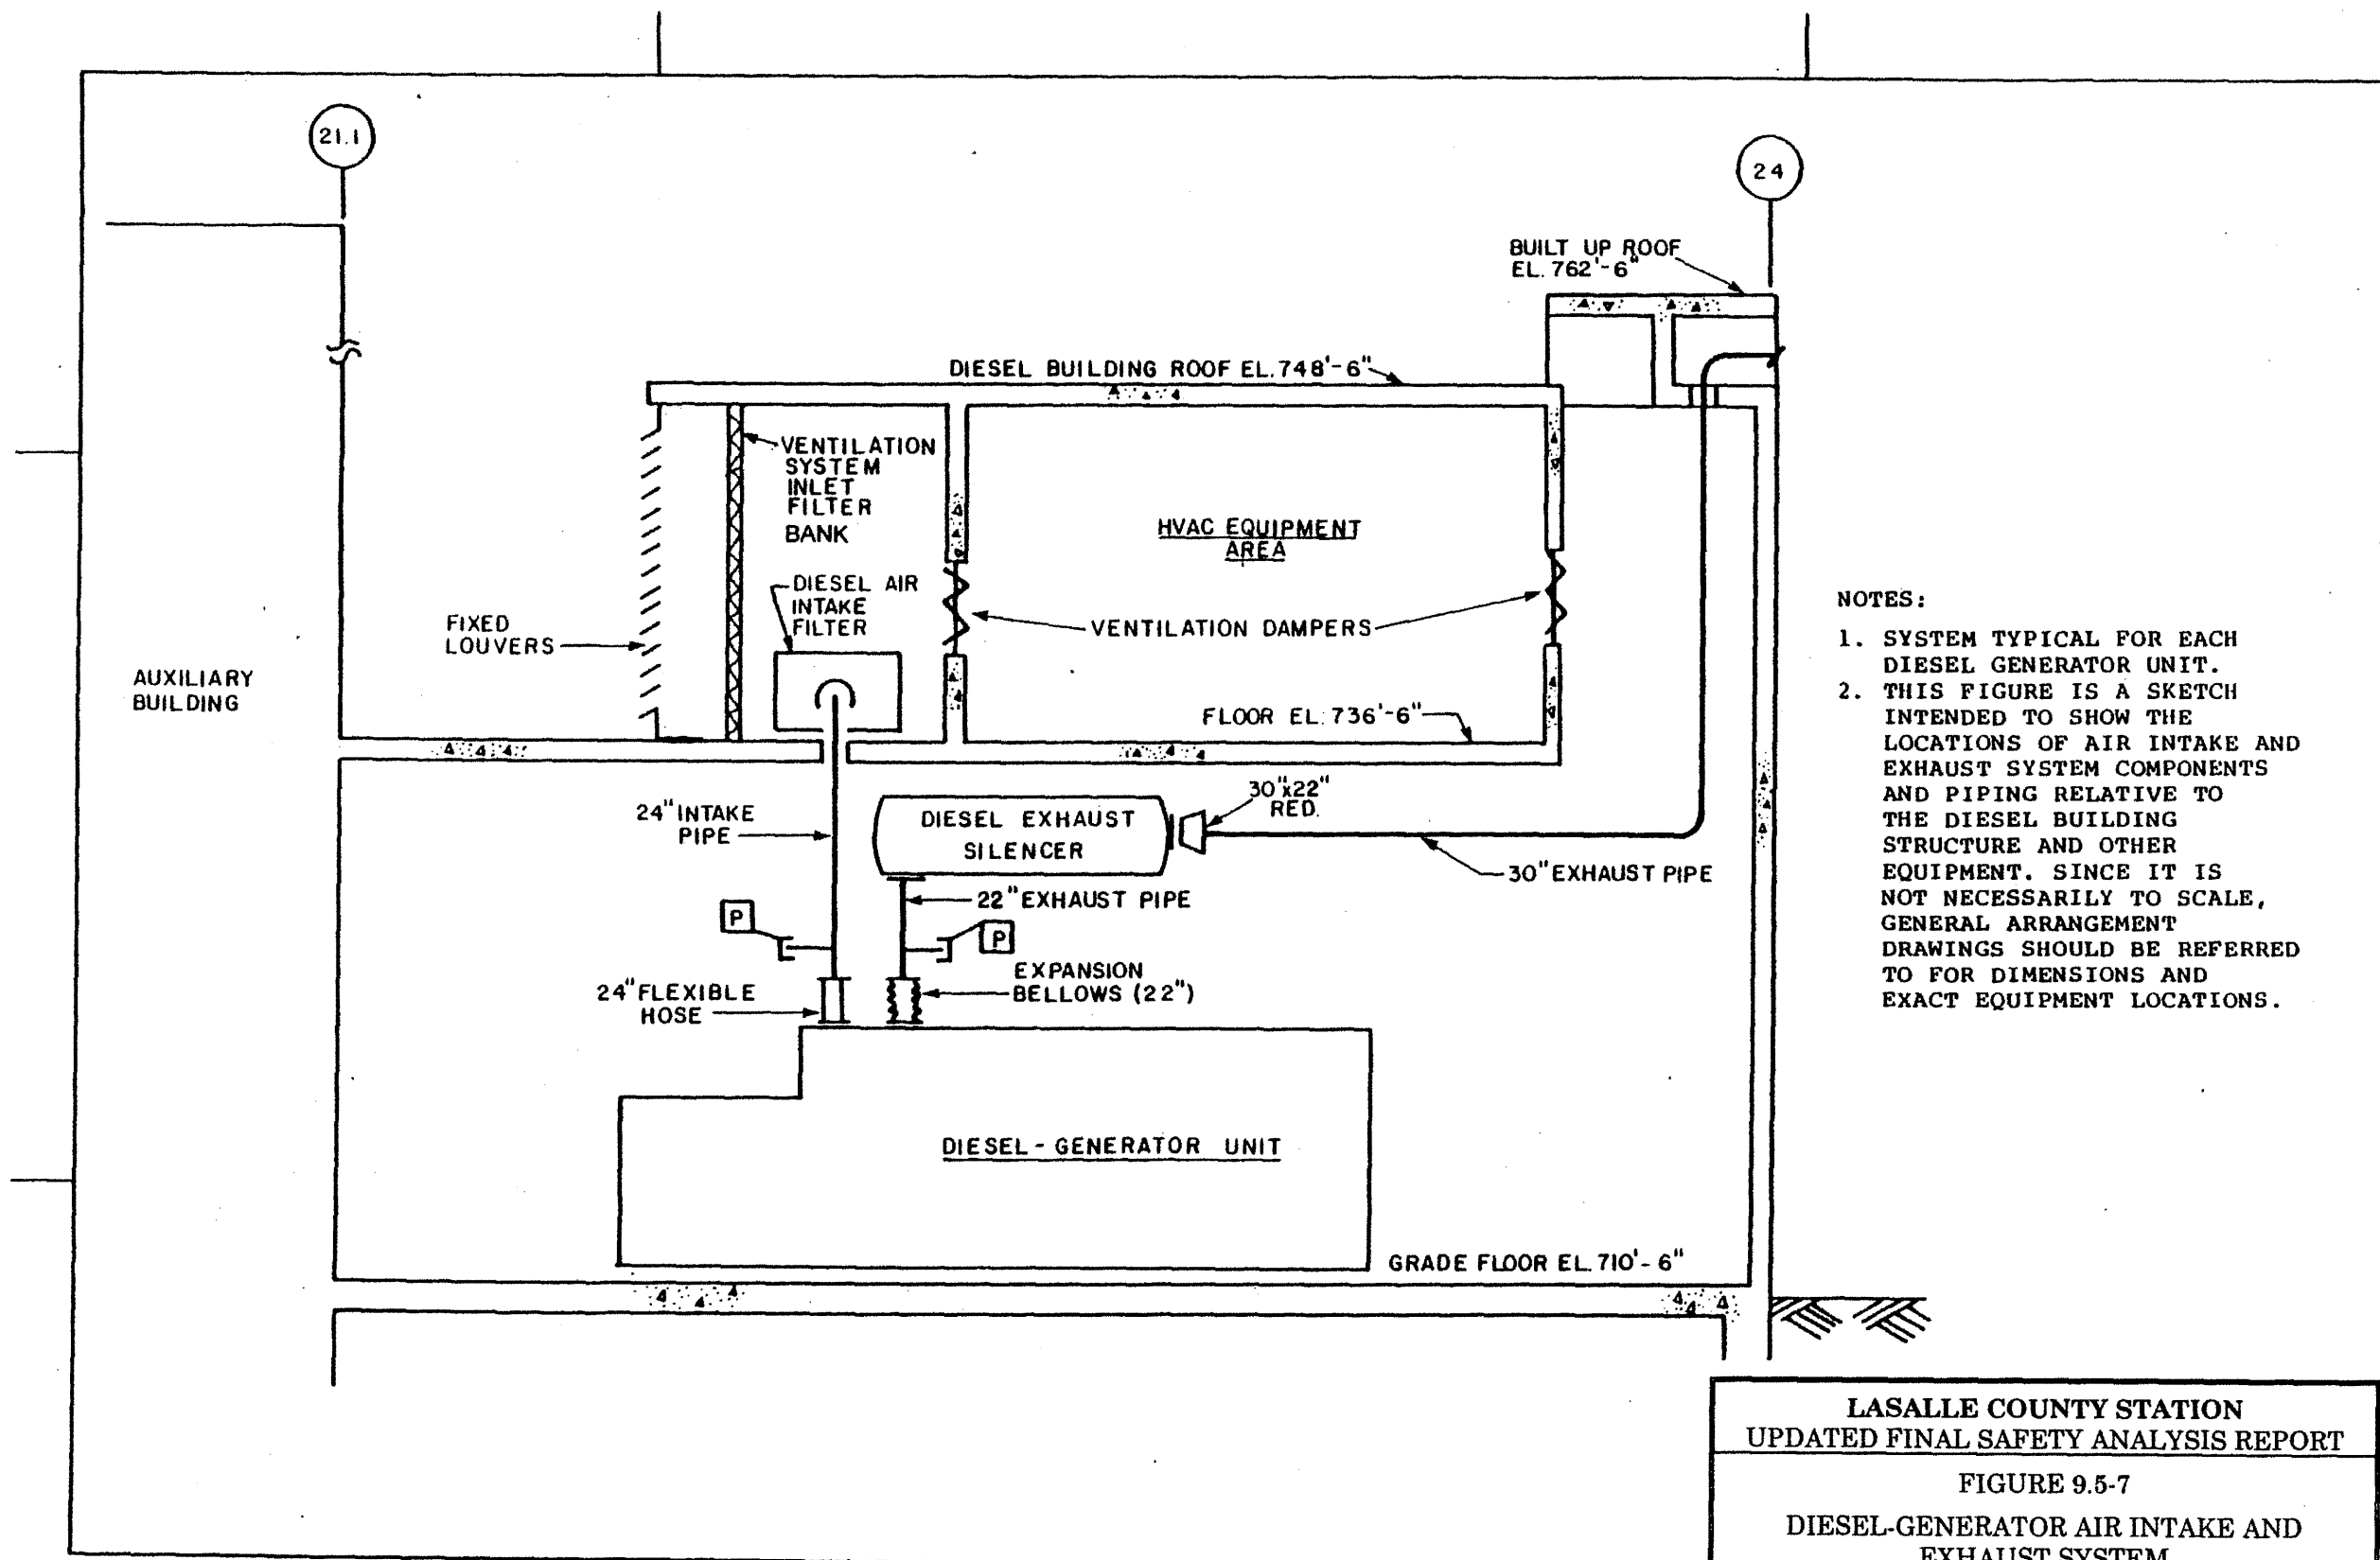

- NOTES:
1. SYSTEM TYPICAL FOR EACH DIESEL GENERATOR UNIT.
  2. THIS FIGURE IS A SKETCH INTENDED TO SHOW THE LOCATIONS OF AIR INTAKE AND EXHAUST SYSTEM COMPONENTS AND PIPING RELATIVE TO THE DIESEL BUILDING STRUCTURE AND OTHER EQUIPMENT. SINCE IT IS NOT NECESSARILY TO SCALE, GENERAL ARRANGEMENT DRAWINGS SHOULD BE REFERRED TO FOR DIMENSIONS AND EXACT EQUIPMENT LOCATIONS.

LASALLE COUNTY STATION  
 UPDATED FINAL SAFETY ANALYSIS REPORT  
 FIGURE 9.5-7  
 DIESEL-GENERATOR AIR INTAKE AND  
 EXHAUST SYSTEM

REV 15, APRIL 2004