


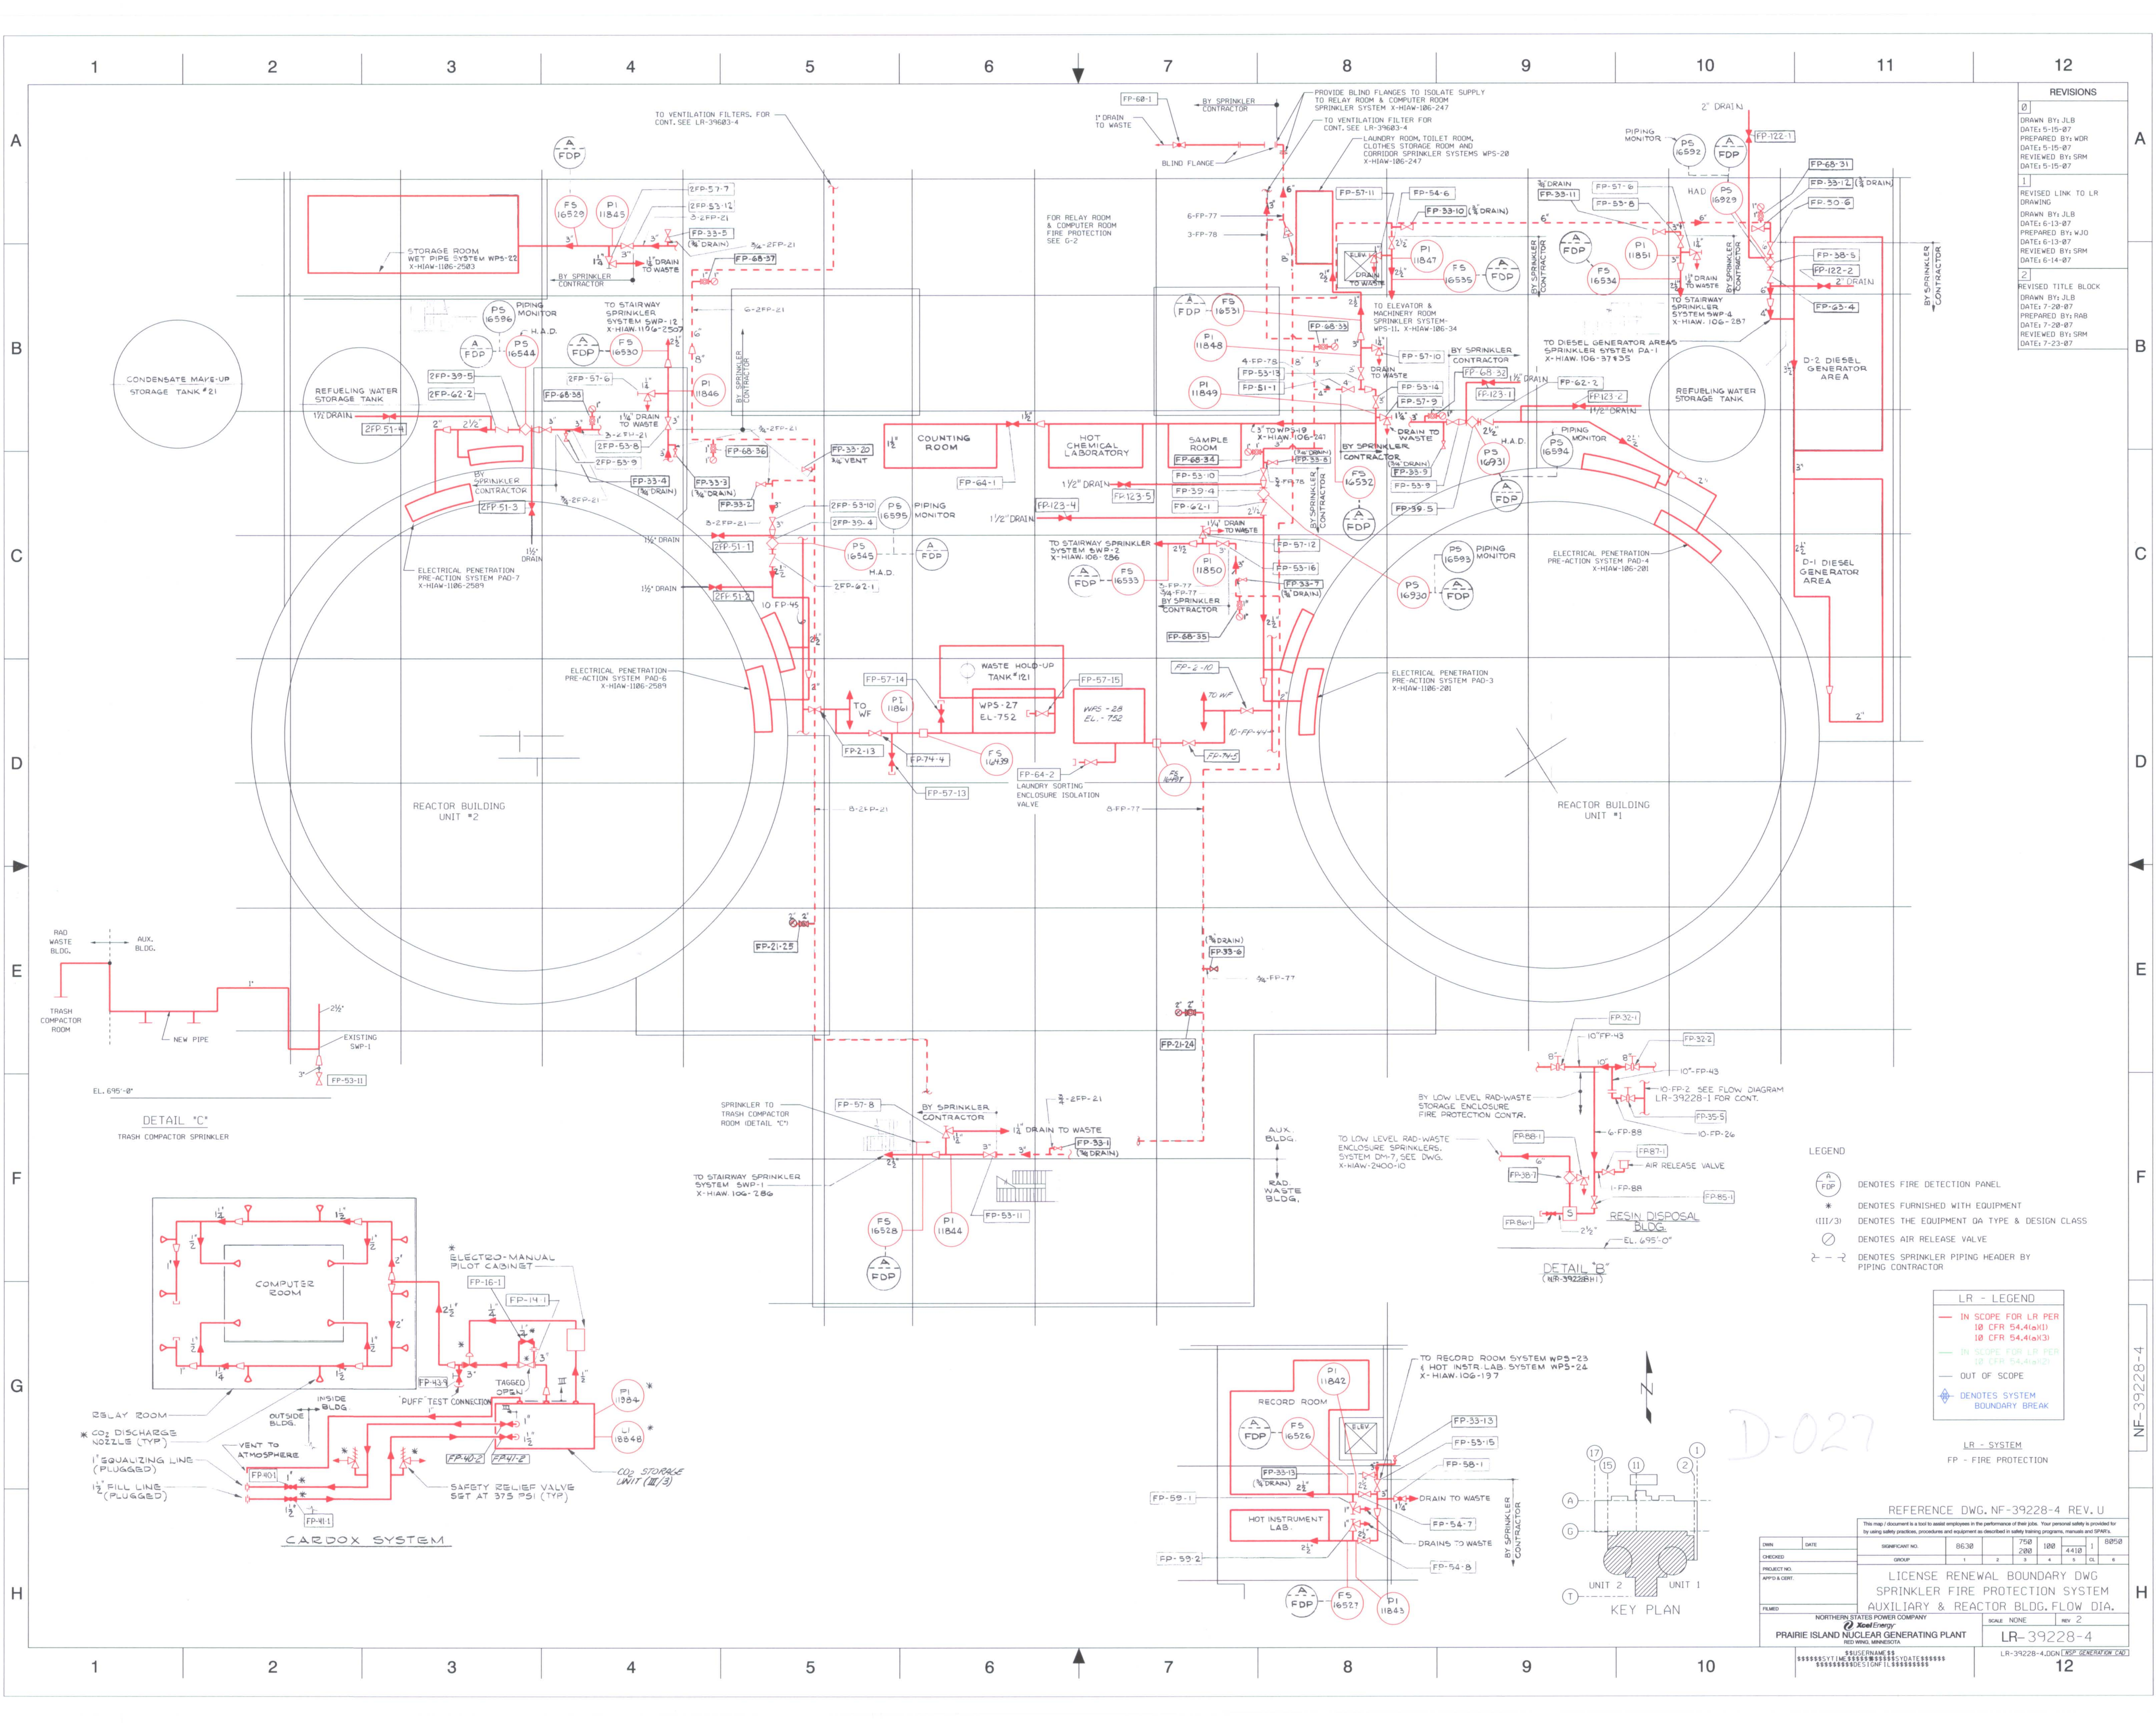

REVISIONS	
0	DRAWN BY: JLB DATE: 5-15-07 PREPARED BY: WDR DATE: 5-15-07 REVIEWED BY: SRM DATE: 5-15-07
1	REVISED LINK TO LR DRAWING DRAWN BY: JLB DATE: 6-13-07 PREPARED BY: WJO DATE: 6-13-07 REVIEWED BY: SRM DATE: 6-14-07
2	REVISED TITLE BLOCK DRAWN BY: JLB DATE: 7-28-07 PREPARED BY: RAB DATE: 7-28-07 REVIEWED BY: SRM DATE: 7-23-07

- LEGEND
- (A) FDP DENOTES FIRE DETECTION PANEL
 - (*) DENOTES FURNISHED WITH EQUIPMENT
 - (III/3) DENOTES THE EQUIPMENT QA TYPE & DESIGN CLASS
 - (Z) DENOTES AIR RELEASE VALVE
 - DENOTES SPRINKLER PIPING HEADER BY PIPING CONTRACTOR

LR - LEGEND	
—	IN SCOPE FOR LR PER 10 CFR 54.4(a)(1)
—	IN SCOPE FOR LR PER 10 CFR 54.4(a)(3)
—	IN SCOPE FOR LR PER 10 CFR 54.4(a)(2)
---	OUT OF SCOPE
—	DENOTES SYSTEM BOUNDARY BREAK

LR - SYSTEM
FP - FIRE PROTECTION

REFERENCE DWG. NF-39228-4 REV. U

This map/document is a tool to assist employees in the performance of their jobs. Your personal safety is provided for by using safety practices, procedures and equipment as described in safety training programs, manuals and SOP's.

OWN	DATE	SIGNATURE NO.	8630	750	100	4410	1	8050
CHECKED		GROUP	1	2	3	4	5	6
PROJECT NO.								
APP'D & CERT.								
FILED								
NORTHERN STATES POWER COMPANY		SCALE: NONE		REV 2				
PRAIRIE ISLAND NUCLEAR GENERATING PLANT		RED WING, MINNESOTA		LR-39228-4				
\$\$\$SYSTE\$\$\$		\$\$\$SYSTE\$\$\$		\$\$\$SYSTE\$\$\$				
\$\$\$DESIGN I L		\$\$\$DESIGN I L		\$\$\$DESIGN I L				

LR-39228-4.DGN (NPP GENERATION CAD)

