


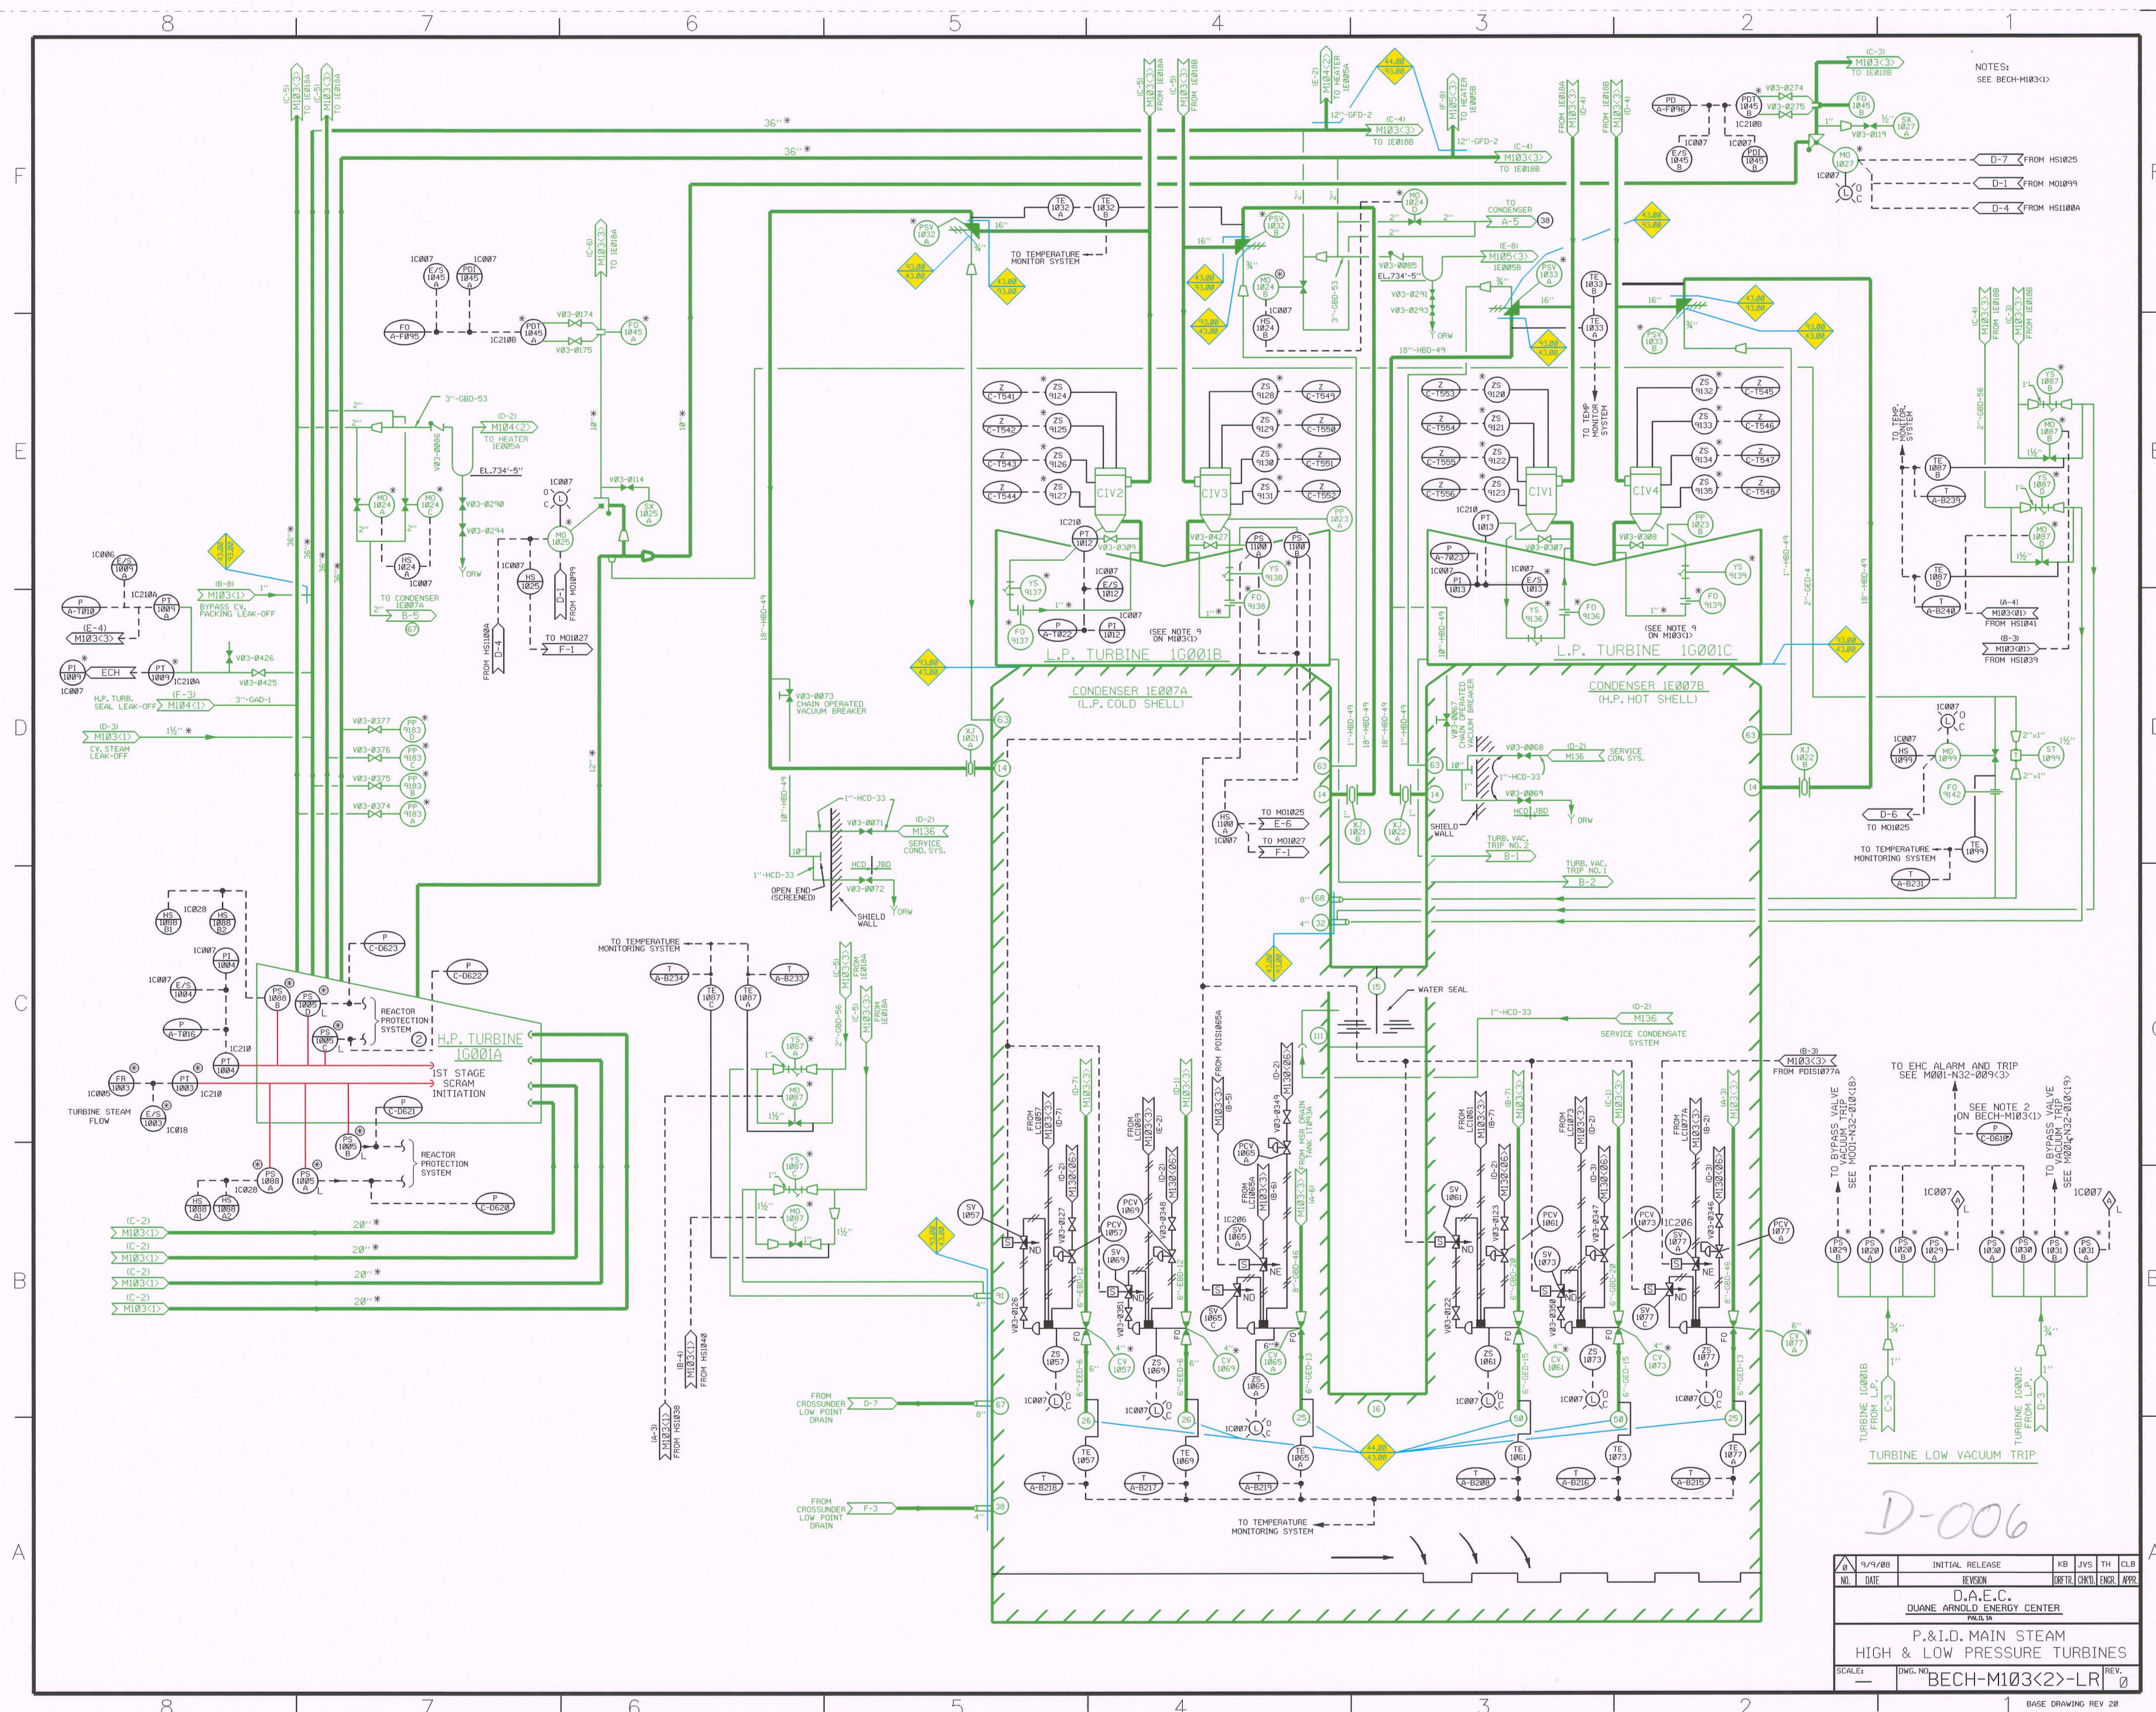

NOTES:
SEE BECH-M103(1)

D-006

④	9/9/88	INITIAL RELEASE	KB	JVS	TH	CLB
	NO. DATE	REVISION	DATE	CHKD	ENGR	APPV
D.A.E.C.						
DUANE ARNOLD ENERGY CENTER						
P&ID, IA						
P.&I.D. MAIN STEAM						
HIGH & LOW PRESSURE TURBINES						
SCALE:	DWG. NO.				REV.	
—	BECH-M103(2)-LR				0	

- LR NOTES:
1. ALL EXPOSED DRAIN PIPING AND FUNNELS ARE IN SCOPE FOR LICENSE RENEWAL.
- LR LEGEND:
COMPONENTS IN SCOPE PER 10CFR54.4(a)(1) AND/OR (a)(3) AND SUBJECT TO AMR PER 54.21
COMPONENTS NOT SUBJECT TO AMR
COMPONENTS IN SCOPE PER 10CFR54.4(a)(2) AND SUBJECT TO AMR PER 54.21
SYSTEM BOUNDARY INTERFACE
43.00 MAIN CONDENSER
44.00 CONDENSATE AND FEEDWATER EXTRACTION STEAM
45.00 MAIN TURBINE