


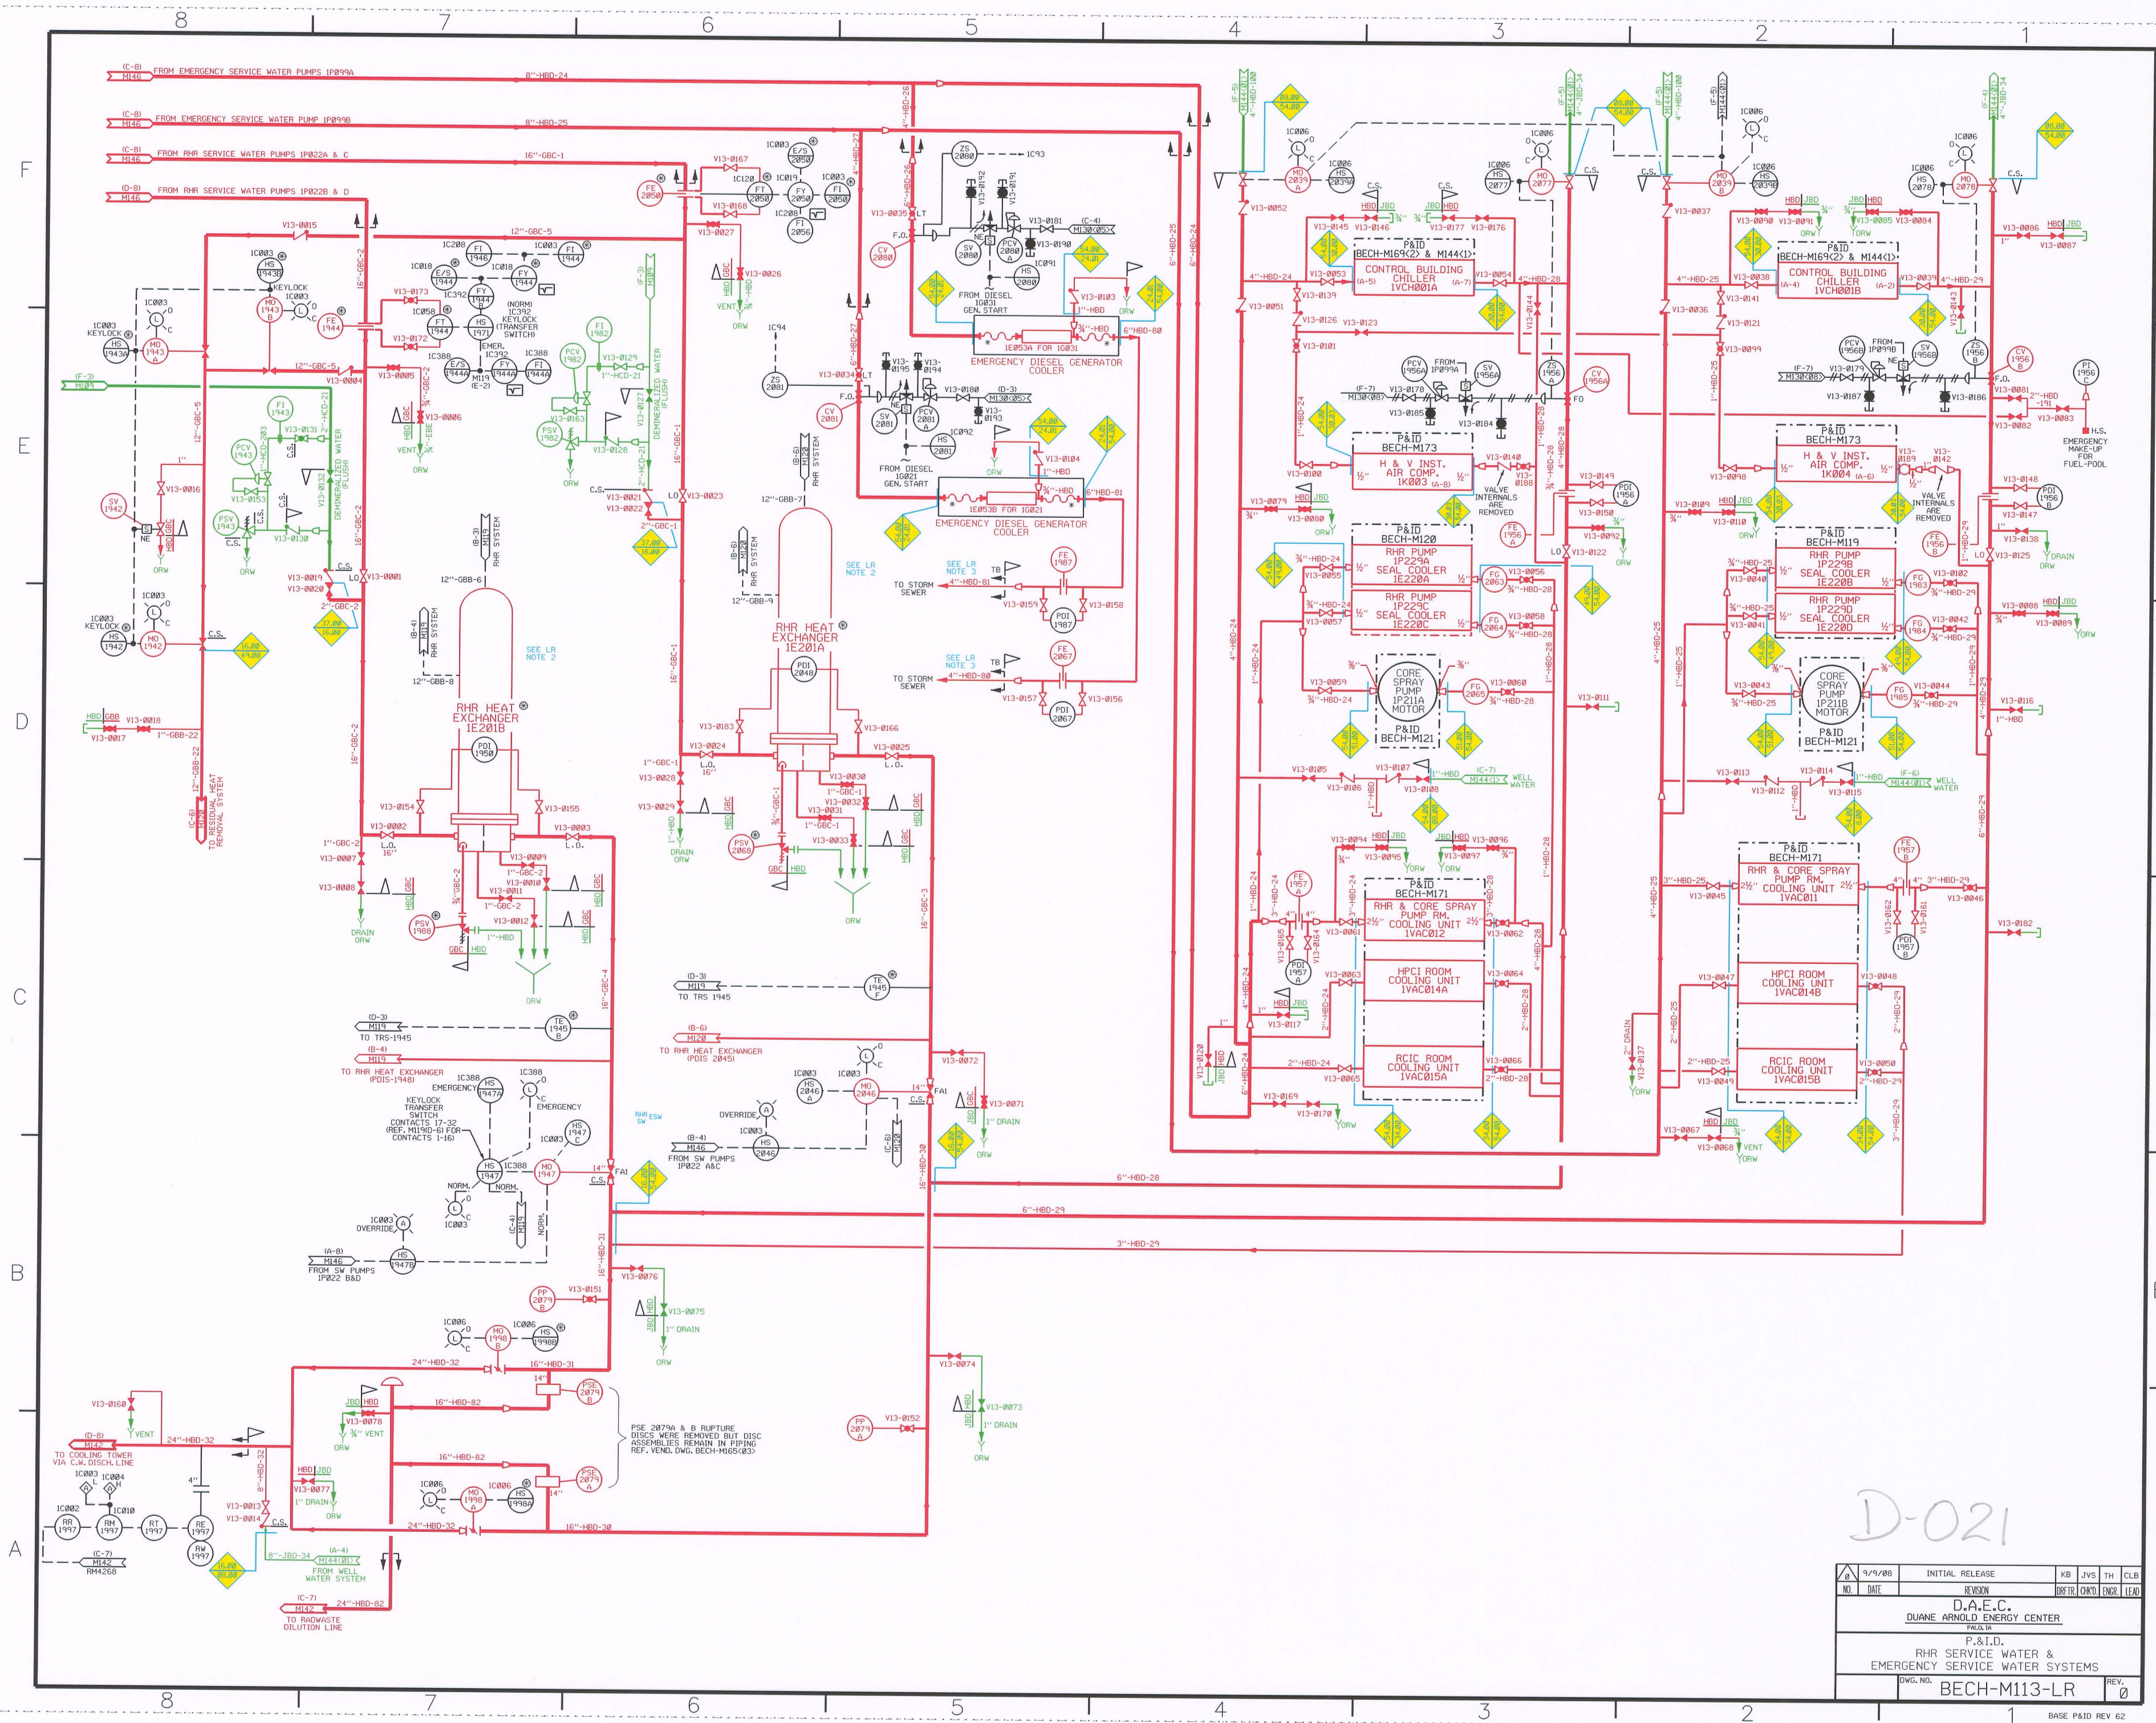

LR NOTES:

1. ALL EXPOSED DRAIN PIPING AND FUNNELS ARE IN SCOPE FOR LICENSE RENEWAL.
2. RHR HEAT EXCHANGERS IE201A AND IE201B ARE EVALUATED IN SUS 45.08.
3. LINES GO UNDERGROUND AND ACT AS THE ANCHOR.

LR LEGEND:

- COMPONENTS IN SCOPE PER 18CFR54.4(a)(1) AND/OR (a)(3) AND SUBJECT TO AMR PER 54.21
- COMPONENTS NOT SUBJECT TO AMR
- COMPONENTS IN SCOPE PER 18CFR54.4(a)(2) AND SUBJECT TO AMR PER 54.21
- SYSTEM BOUNDARY INTERFACE

80.00 WELL WATER
16.00 RHR SERVICE WATER
24.00 STANDBY DIESEL GENERATORS
38.00 CONTROL BUILDING HVAC
38.00 "A" & "B" SAFETY RELATED AIR
37.00 CONDENSATE & DEMINERALIZED WATER
47.00 RESIDUAL HEAT REMOVAL
53.00 CORE SPRAY
54.00 EMERGENCY SERVICE WATER

D-021

9/9/08	INITIAL RELEASE	KB	JVS	TH	CLB
	REVISION				
D.A.E.C.					
DUANE ARNOLD ENERGY CENTER					
P&I.D.					
RHR SERVICE WATER & EMERGENCY SERVICE WATER SYSTEMS					
Dwg. No. BECH-M113-LR					
REV. 0					

BASE P&ID REV 62