


LEGEND

- C — CONDUIT
- CAS — CONDUIT TO CABINET AS
- CC — CONDUIT TO CABINET C
- CCM — CONDUIT TO CABINET CM
- CDU — COMBINED DRAIN, UNDERGROUND
- CDX — CONDUIT TO CABINET DX
- CI — CAST IRON
- CIT — CONDUIT TO CABINET IT
- CLD — CONCRETE LINED DITCH
- CM — CONDUIT TO CABINET M
- CMP — CORRIGATED METAL PIPE
- CRS — CONDUIT RIGID STEEL
- CULP — CULVERT PIPE
- CW — CHILLED WATER OR CONDUIT TO CAB
- CWDU — COOLING WATER DRAIN, UNDERGROUND
- CWE — COOLING WATER EMERGENCY
- CWED — COOLING WATER EMERGENCY DRAIN
- CWEDU — COOLING WATER EMERGENCY DRAIN UNDERGROUND
- CWS — COOLING WATER SUPPLY
- CWSR — COOLING WATER SUPPLY RETURN
- CWSU — COOLING WATER SUPPLY UNDERGROUND
- DO — DIESEL OIL
- DPW — DISPOSAL PIT WASTE
- DWC — DOMESTIC WATER COLD
- DWCU — DOMESTIC WATER COLD UNDERGROUND
- DWW — DISPOSAL WELL WASTE
- FO — FUEL OIL
- FW — FIRE WATER
- FWDU — FIRE WATER TEST DRAIN, UNDERGROUND
- FWU — FIRE WATER, UNDERGROUND (HEADER)
- GW — GROUNDWATER
- HPS — HIGH PRESSURE STEAM
- HX — HEXANE
- LPG — LIQUEFIED PETROLEUM GAS
- LPS — LOW PRESSURE STEAM
- NG — NATURAL GAS
- PA — PLANT AIR
- PIV — VALVE
- PPL — VALVE
- PW — PROCESS WATER
- RCP — REINFORCED CONCRETE PIPE
- RW — RAINWATER
- RWU — RAIN WATER, UNDERGROUND
- SDR — DRISCO PIPE
- SDU — STORM DRAIN, UNDERGROUND
- SS — SANITARY SEWER
- SSU — SANITARY SEWER, UNDERGROUND
- VCP — VITRIFIED CLAY PIPE
- YSD — STORM DRAIN

- > UTILITY LOCATION, TYPE, OR EXTENTS UNKNOWN
- PLUG
- RISER TO SURFACE
- ⊗ FIRE HYDRANT
- MANHOLE
- AREA INLET
- UNDERGROUND UTILITY LINE
- ⊗ LIGHT POLE
- x — FENCE
- ⋯ UNPAVED DRIVING SURFACE
- ▭ PAVED OR CONCRETE SURFACE
- HYDRAULIC BARRIER
- COLLECTION SUMP

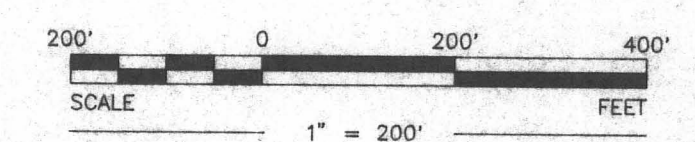

D04

Drawing Title: FACILITY UNDERGROUND UTILITY PLAN - INDEX MAP		Client: SEQUOYAH FUELS CORPORATION	
Document Title: FEI FINDINGS REPORT		Location: GORE, OKLAHOMA	
ROBERTS/SCHORNICK & ASSOCIATES, INC. Environmental Consultants <small>3700 West Robinson, Suite 200 Norman, Oklahoma 73072 (405) 321-3966</small>		DATE: 1991	PREPARED BY: SFC
		SCALE: 1" = 200'	CHECKED BY: RSA
		PROJECT NO: 90067N08	DRAFTED BY: RSA
			DRAWING No. 4