

E 8000


E 8500

N 14500

N 14000


SHEET INDEX

+	+	+	+	+	+
+	SHEET 1	+	+	+	+
+	+	+	+	+	+
SHEET 3		SHEET 4			
SHEET 5		SHEET 6			
SHEET 7		SHEET 8			

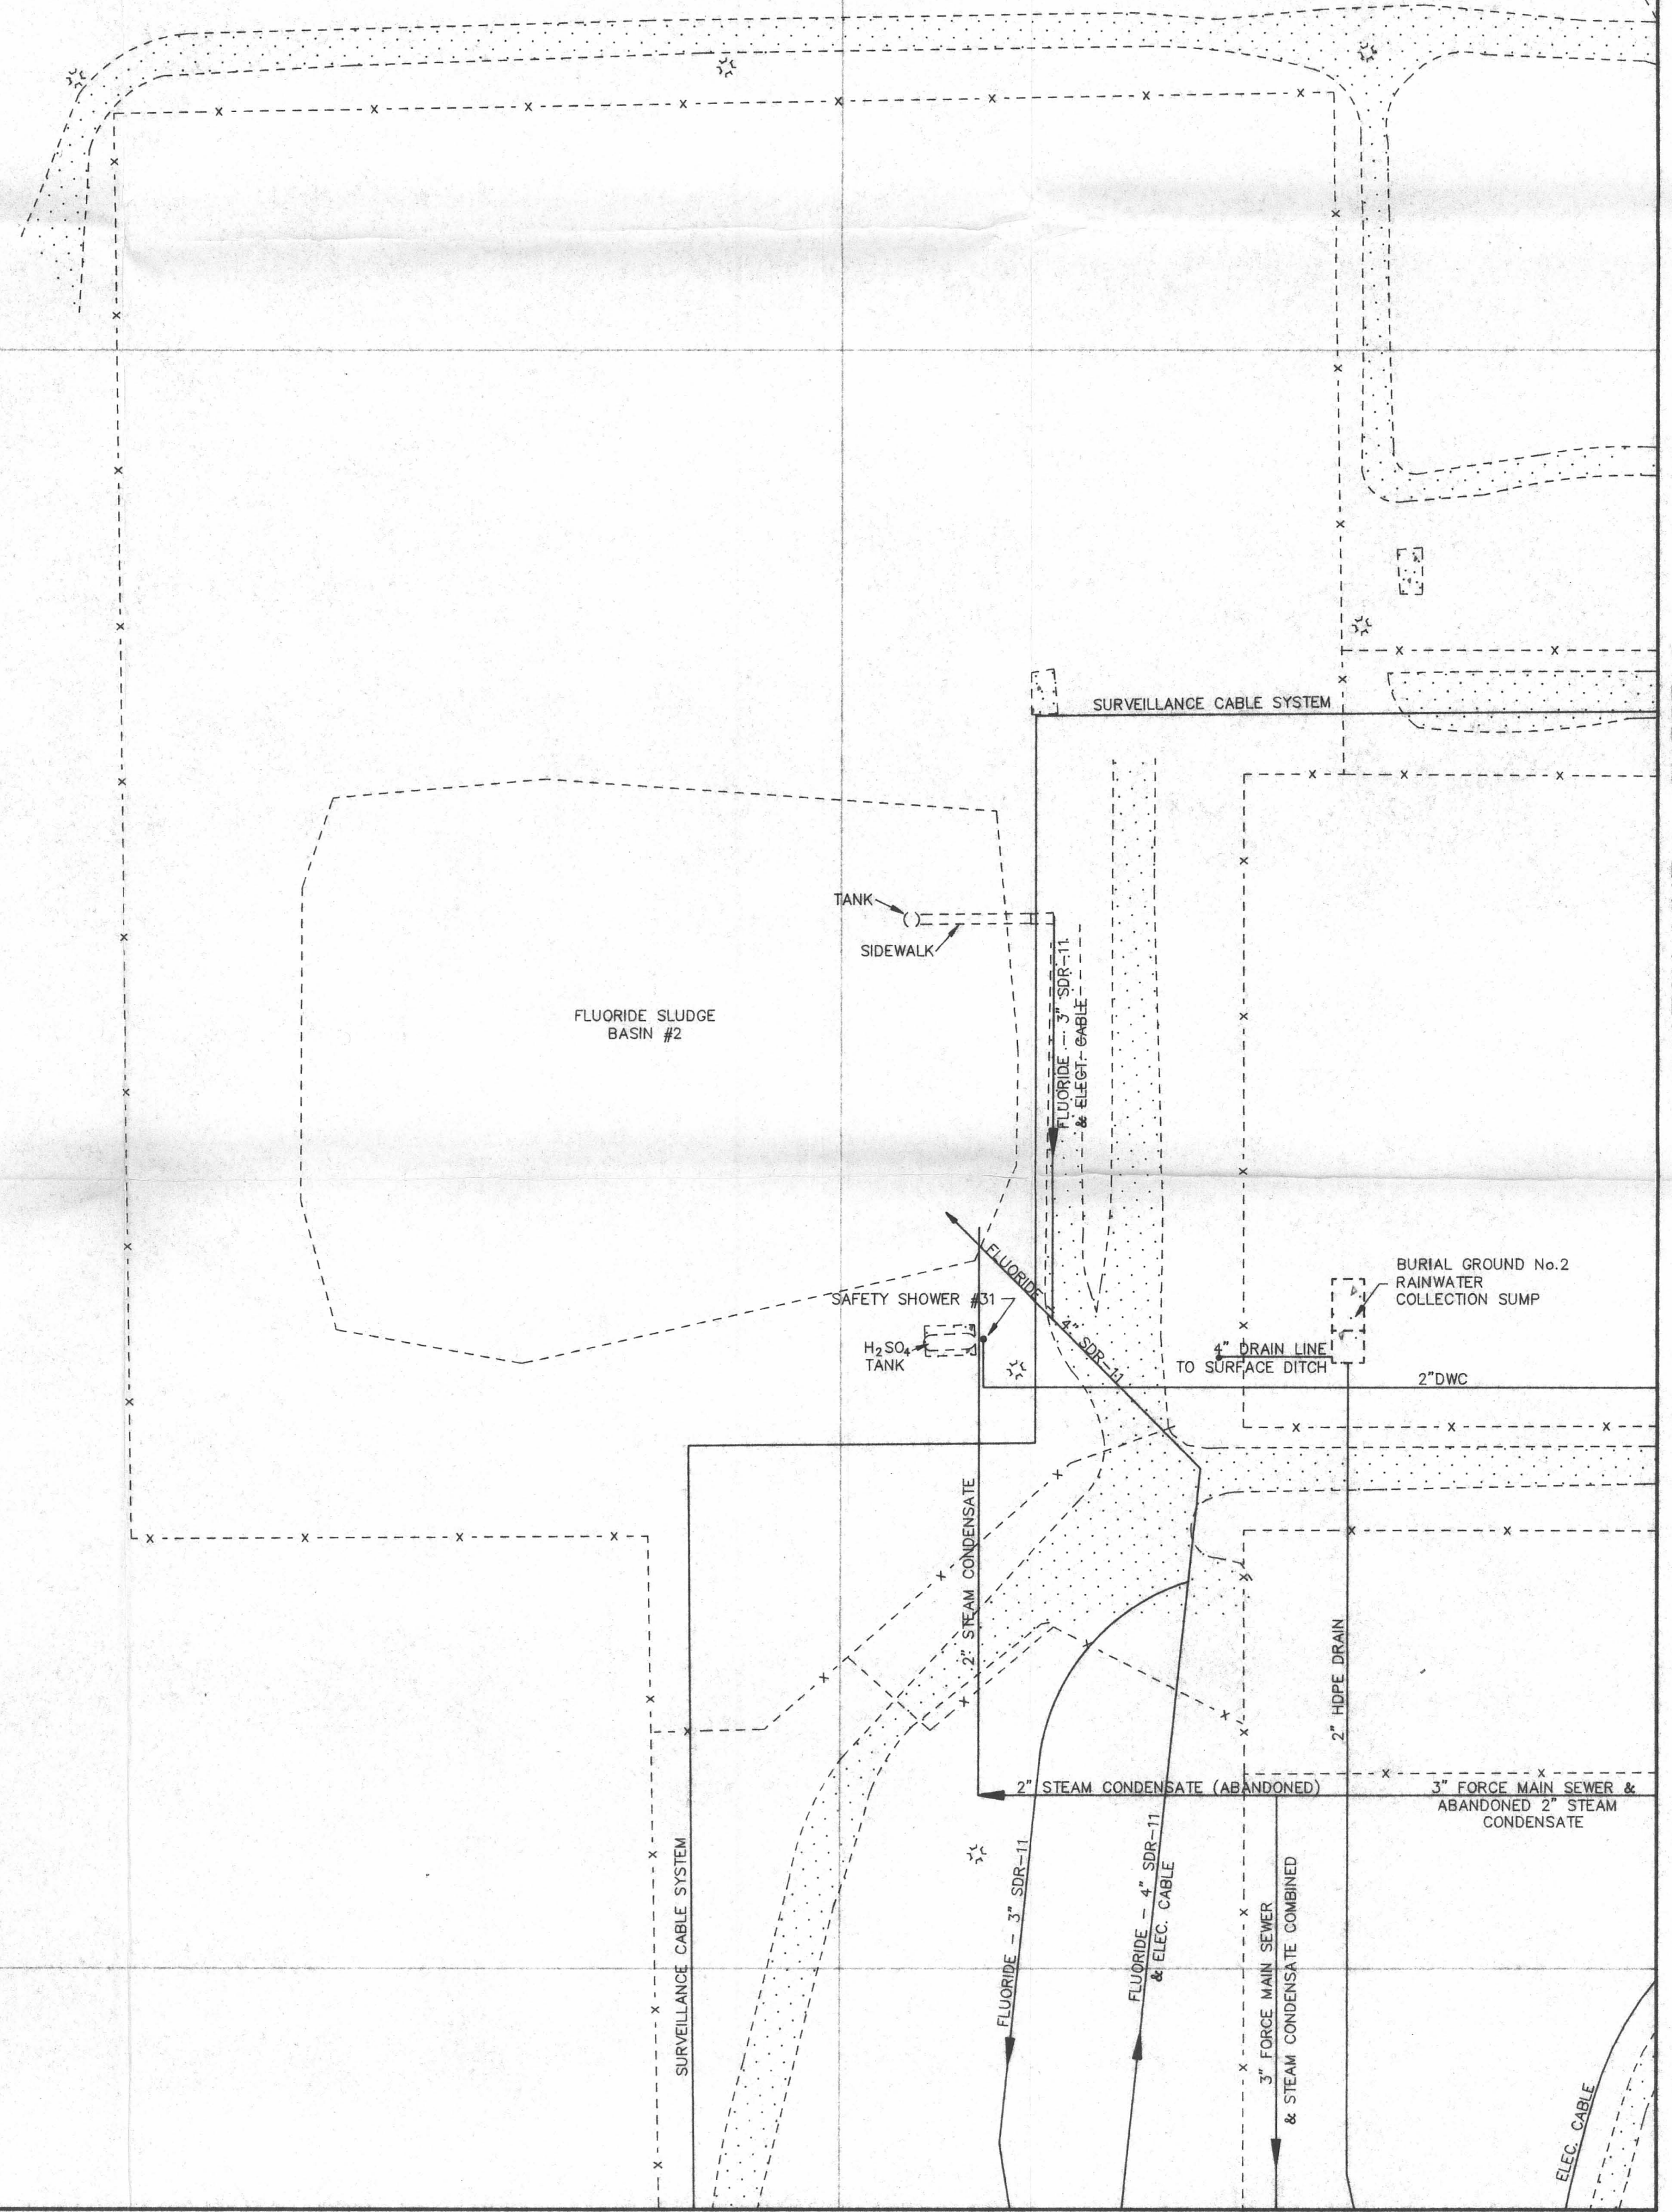

MATCH LINE - SHEET 2

MATCH LINE - SHEET 3

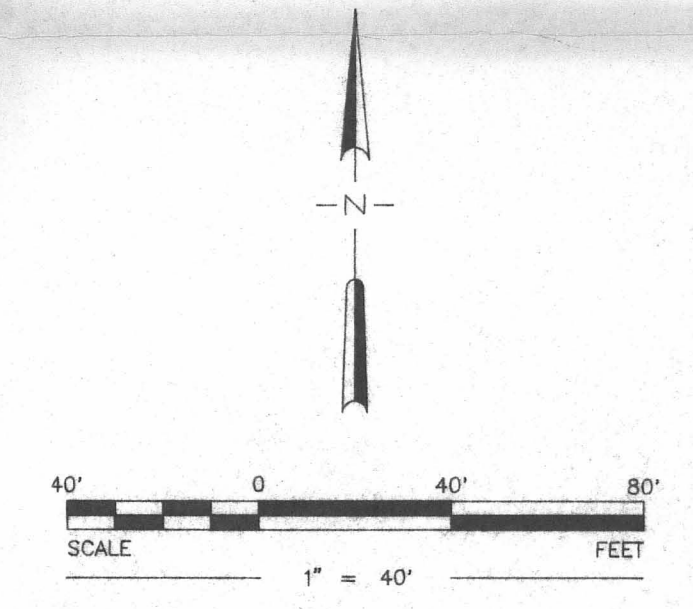

D05

Drawing Title: FACILITY UNDERGROUND UTILITY PLAN - SHEET 1	Client: SEQUOYAH FUELS CORPORATION
Document Title: FEI FINDINGS REPORT	Location: GORE, OKLAHOMA
ROBERTS/SCHORNICK & ASSOCIATES, INC. Environmental Consultants 3700 West Robinson, Suite 200 Norman, Oklahoma 73072 (405) 321-3388	DATE: MAY, 1991 SCALE: 1" = 40' PROJECT NO: 90067M93 PREPARED BY: SFO CHECKED BY: RSA DRAFTED BY: RSA DRAWING No. 5