


MATCH LINE - SHEET 4


MATCH LINE - SHEET 5

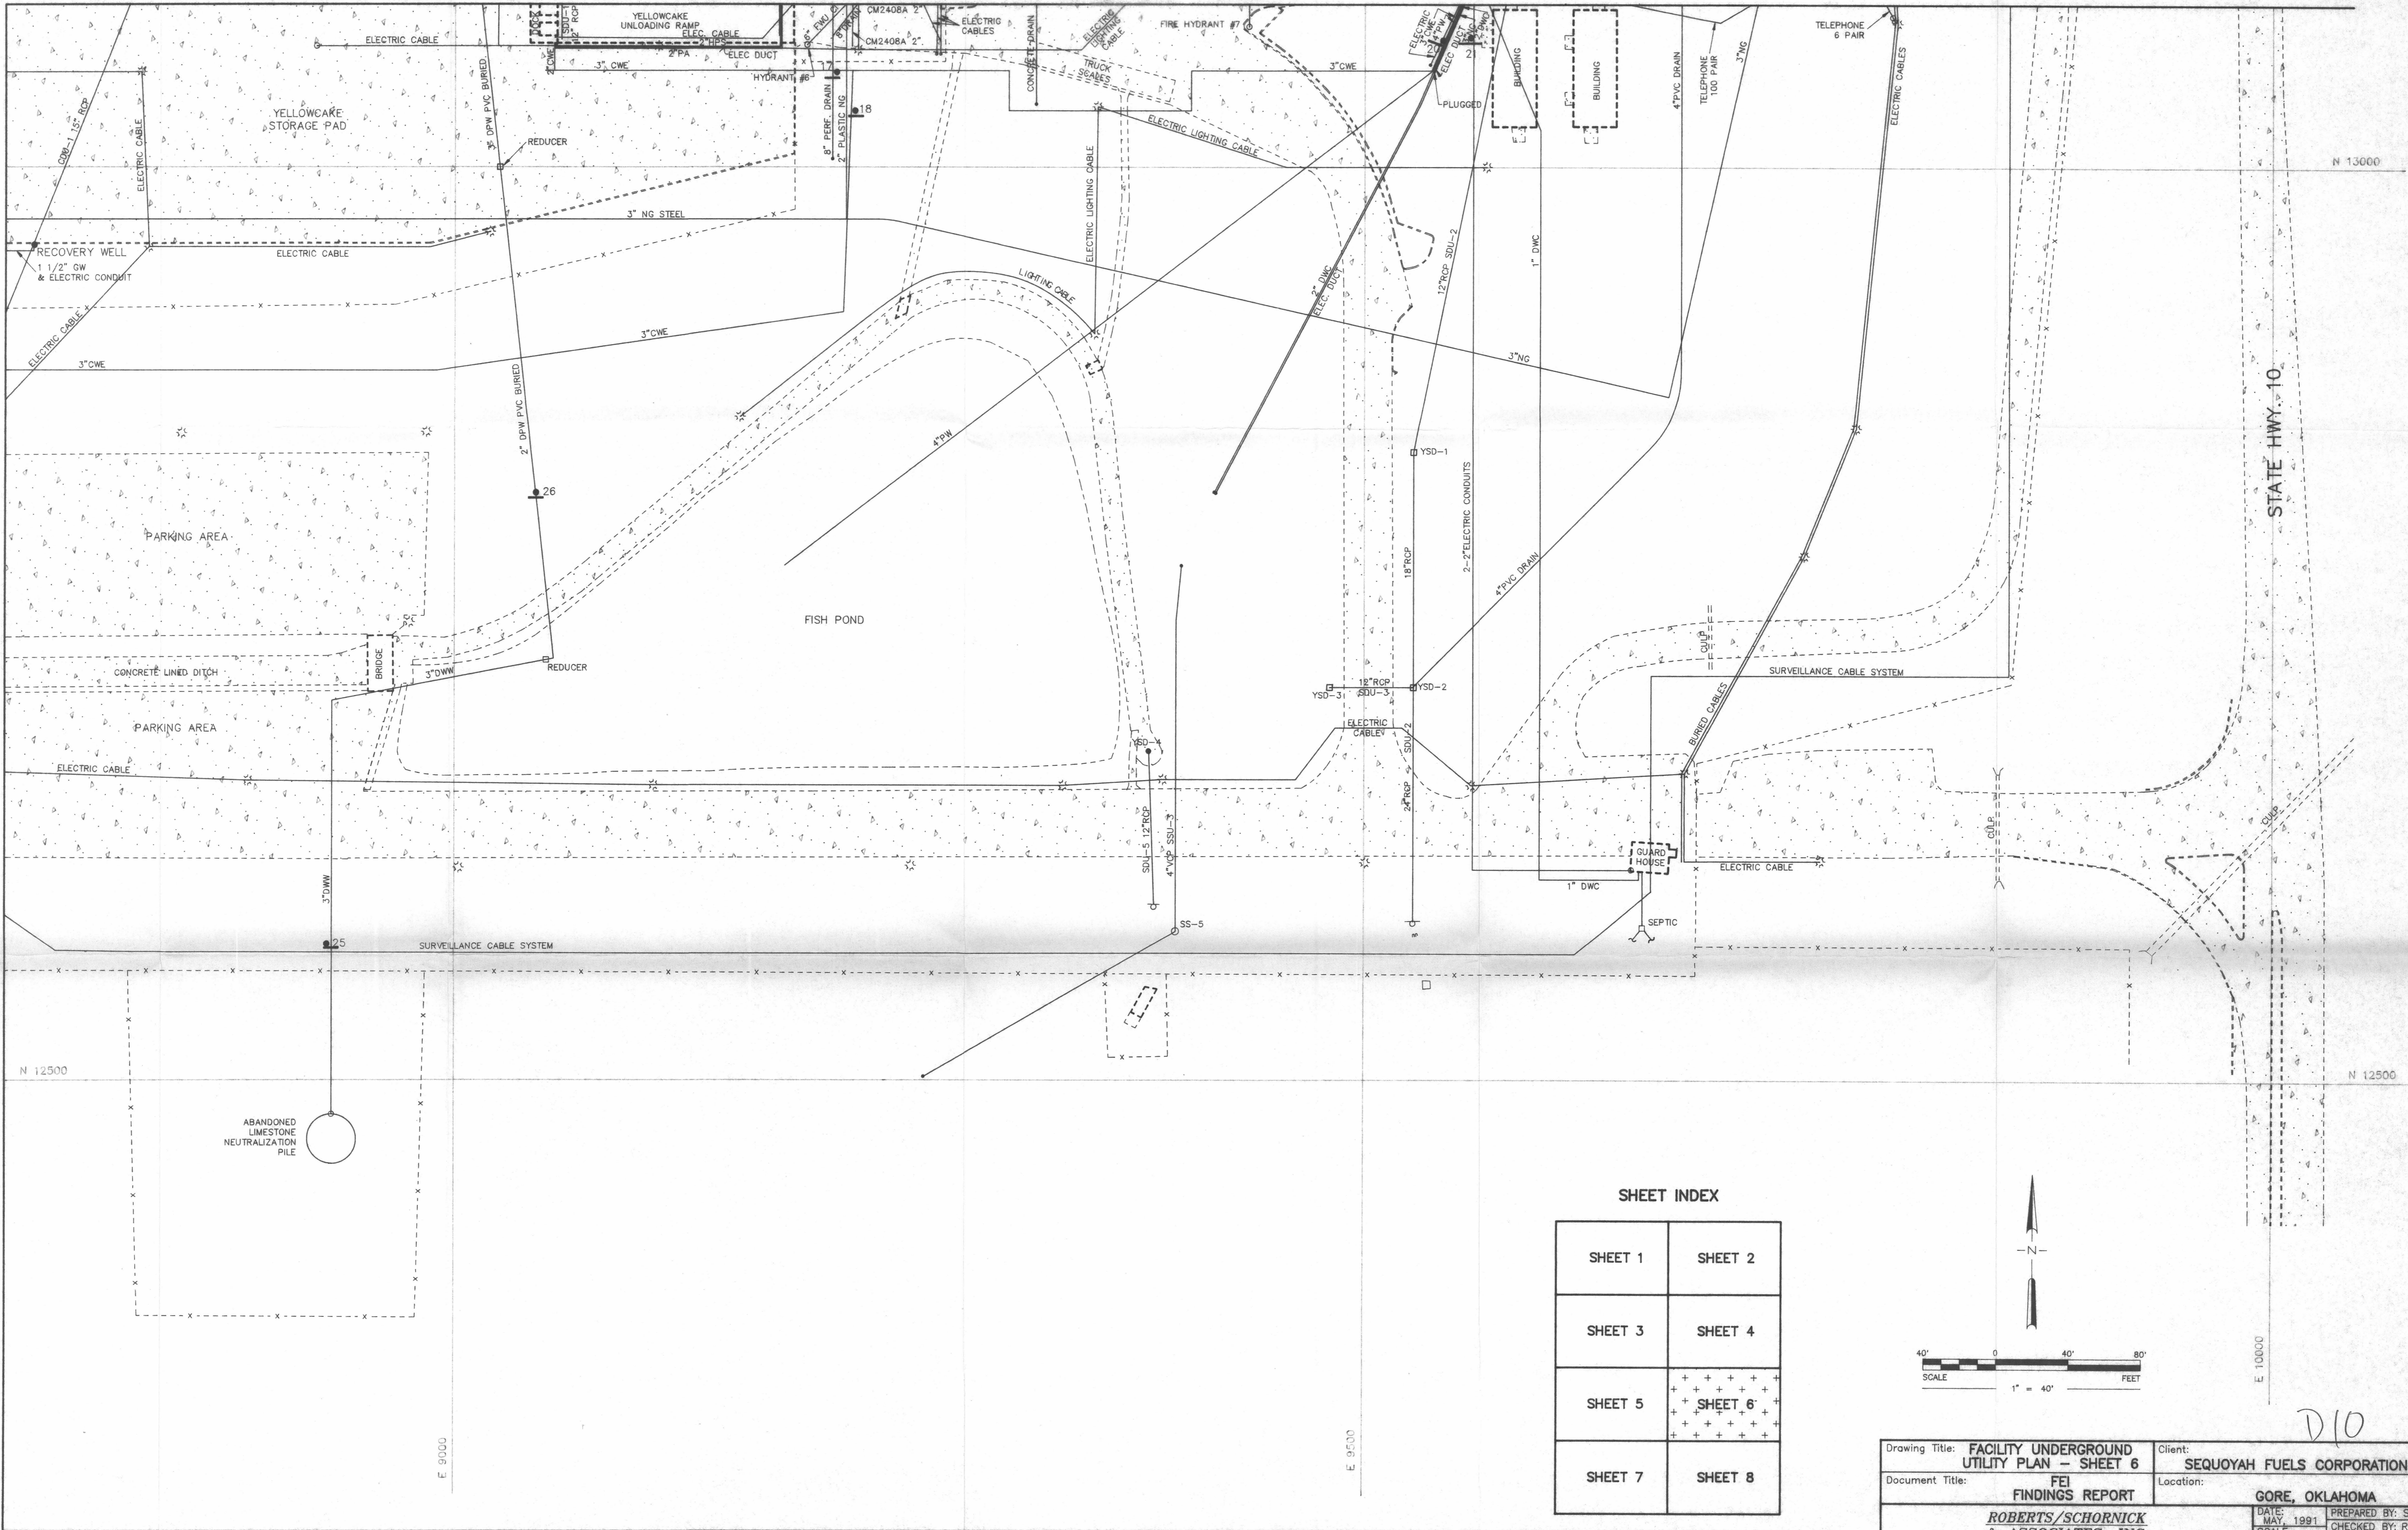

MATCH LINE - SHEET 8

SHEET INDEX

SHEET 1	SHEET 2
SHEET 3	SHEET 4
SHEET 5	++ + SHEET 6 + ++
SHEET 7	SHEET 8

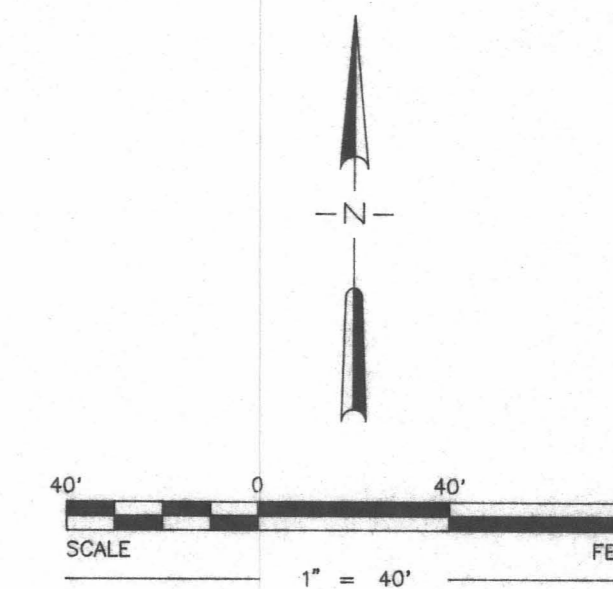

Drawing Title: FACILITY UNDERGROUND UTILITY PLAN - SHEET 6	Client: SEQUOYAH FUELS CORPORATION
Document Title: FEI FINDINGS REPORT	Location: GORE, OKLAHOMA
ROBERTS/SCHORNICK & ASSOCIATES, INC. Environmental Consultants 3700 West Robinson, Suite 200 Norman, Oklahoma 73072 (405) 381-3996	DATE: MAY 1991 SCALE: 1" = 40' PROJECT NO: 90067M92
	PREPARED BY: SFC CHECKED BY: RSA DRAFTED BY: RSA DRAWING No. 10

D10