
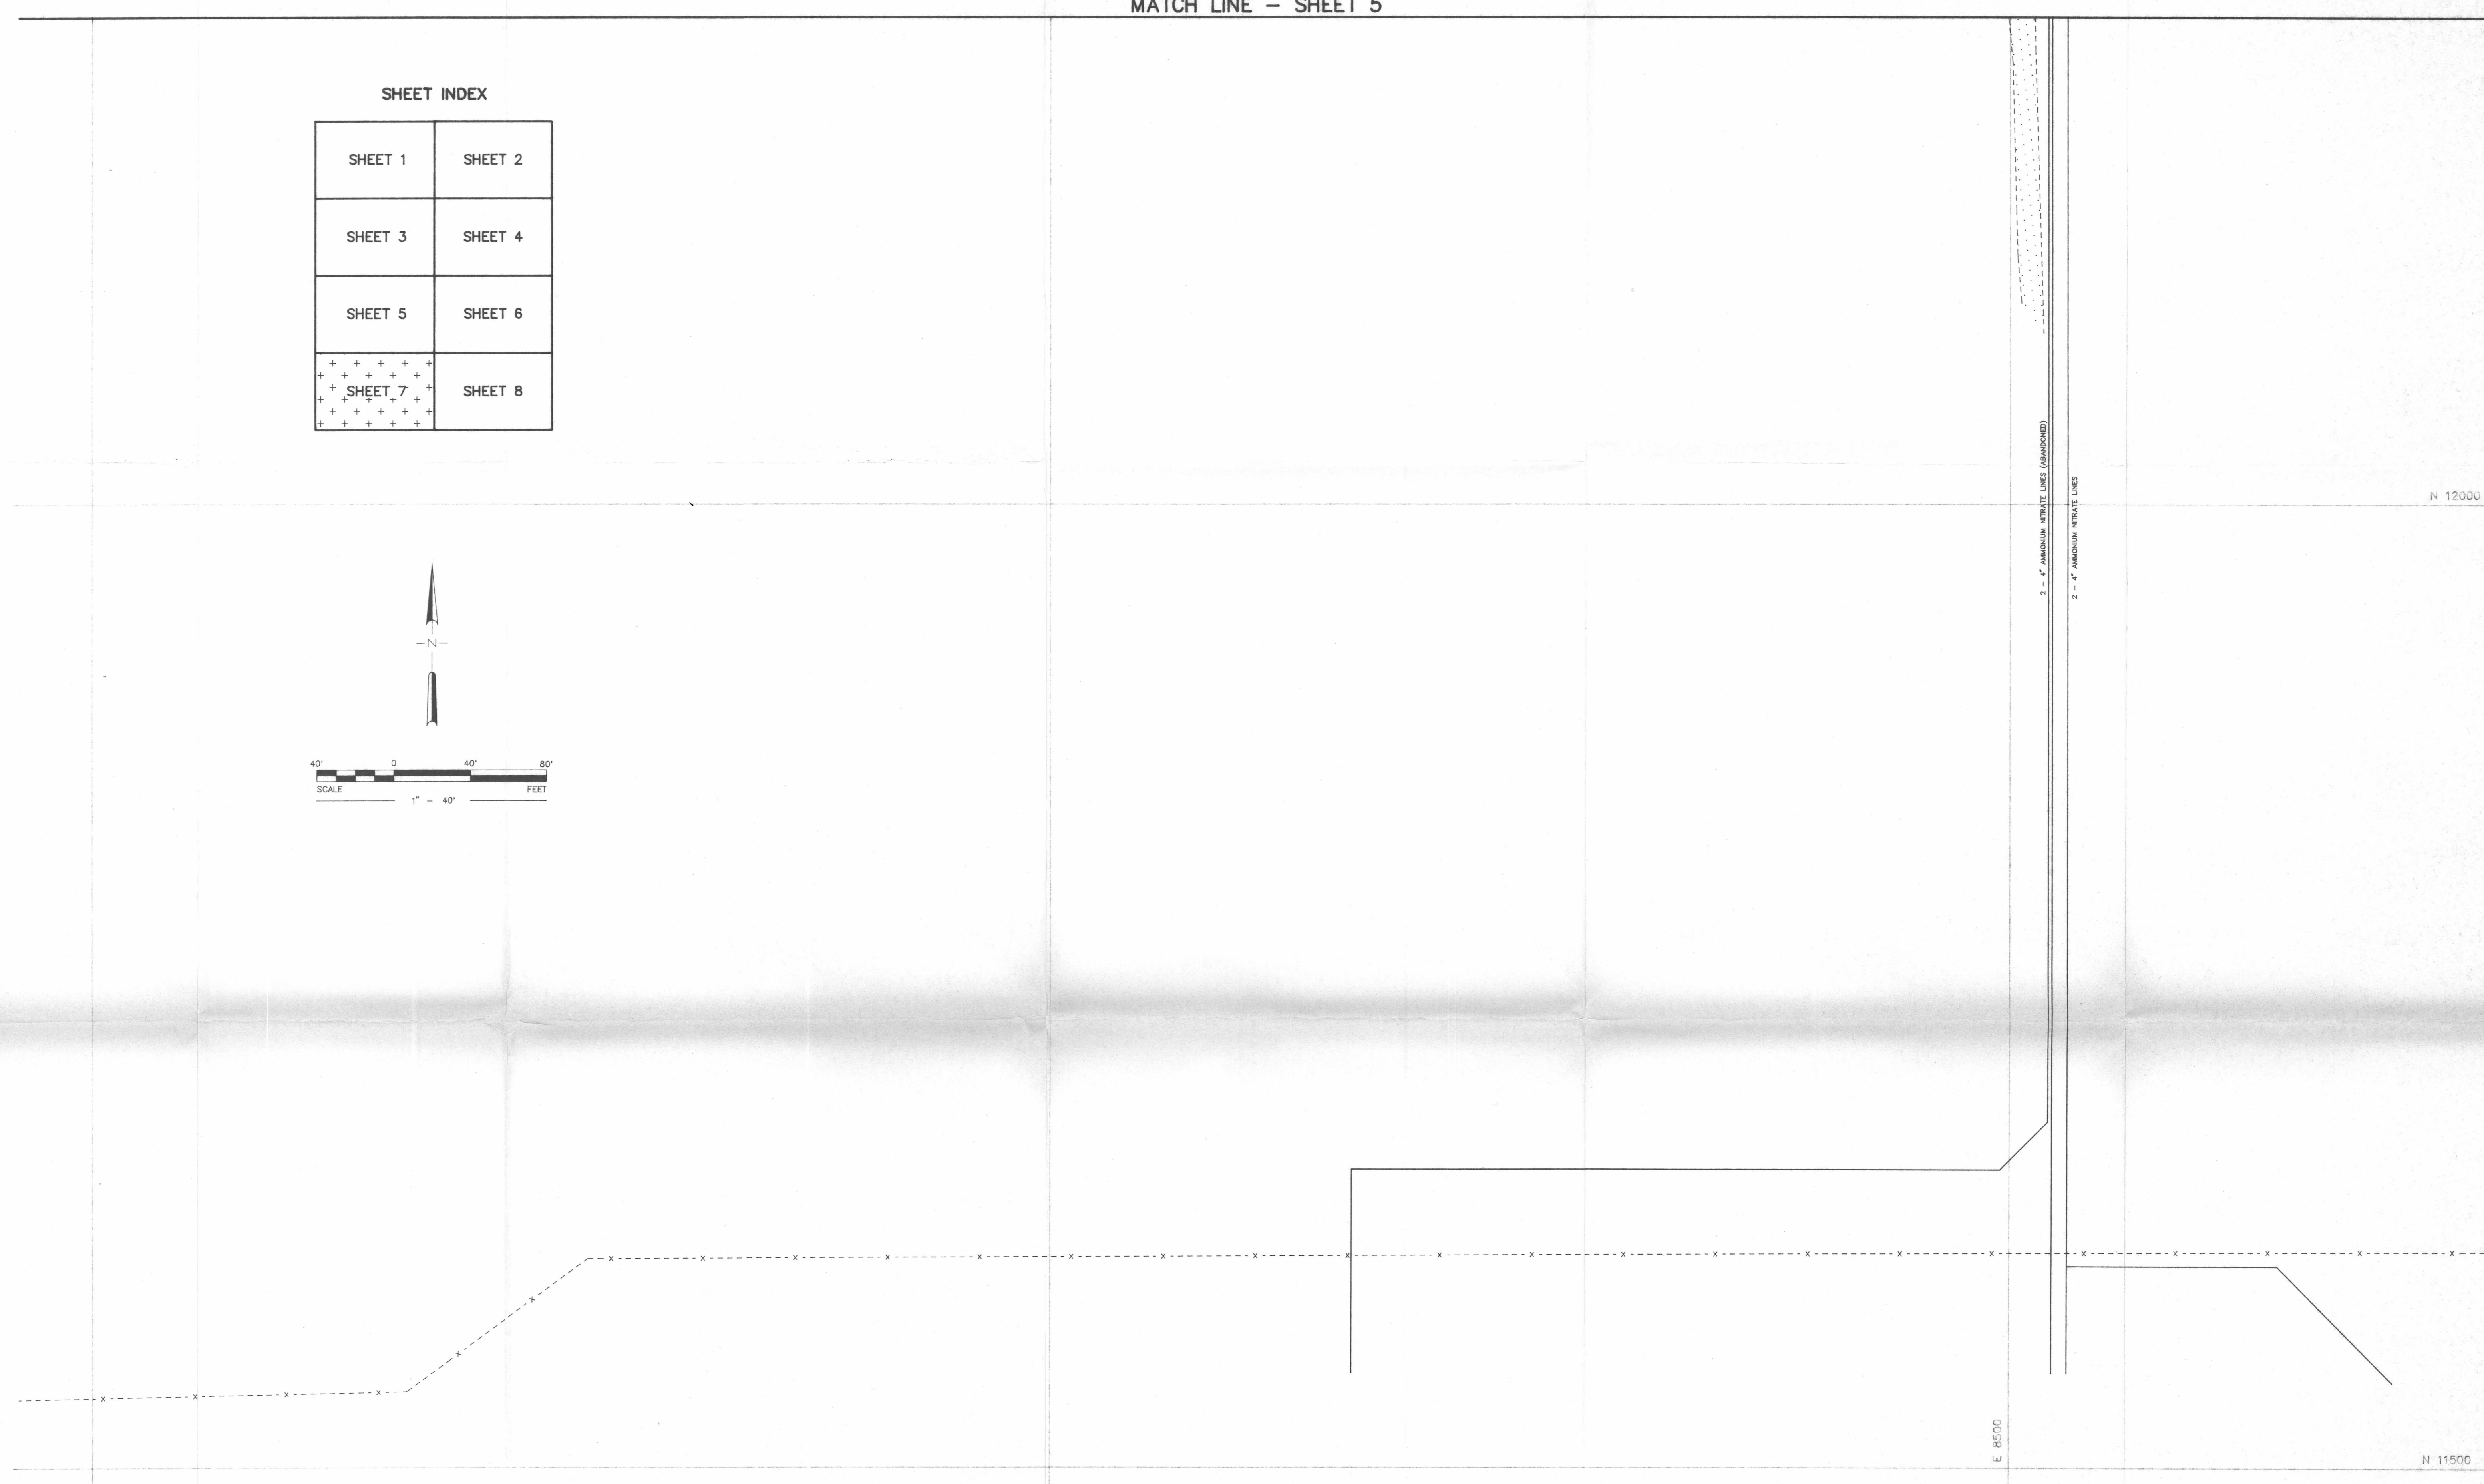


MATCH LINE - SHEET 5

SHEET INDEX

SHEET 1	SHEET 2
SHEET 3	SHEET 4
SHEET 5	SHEET 6
++ ++ SHEET 7 ++ ++	SHEET 8

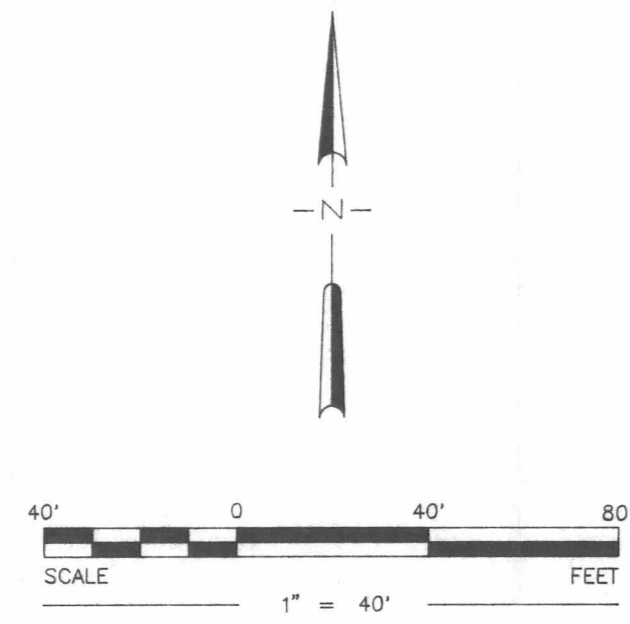

MATCH LINE - SHEET 8

Drawing Title: FACILITY UNDERGROUND UTILITY PLAN - SHEET 7		Client: SEQUOYAH FUELS CORPORATION	
Document Title: FEI FINDINGS REPORT		Location: GORE, OKLAHOMA	
ROBERTS/SCHORNICK & ASSOCIATES, INC. Environmental Consultants <small>3700 West Robinson, Suite 200 Norman, Oklahoma 73072 (405) 521-3850</small>		DATE: MAY, 1991	PREPARED BY: SEC
		SCALE: 1" = 40'	CHECKED BY: RSA
PROJECT NO: 90067N06		DRAWING No. 11	

D11