

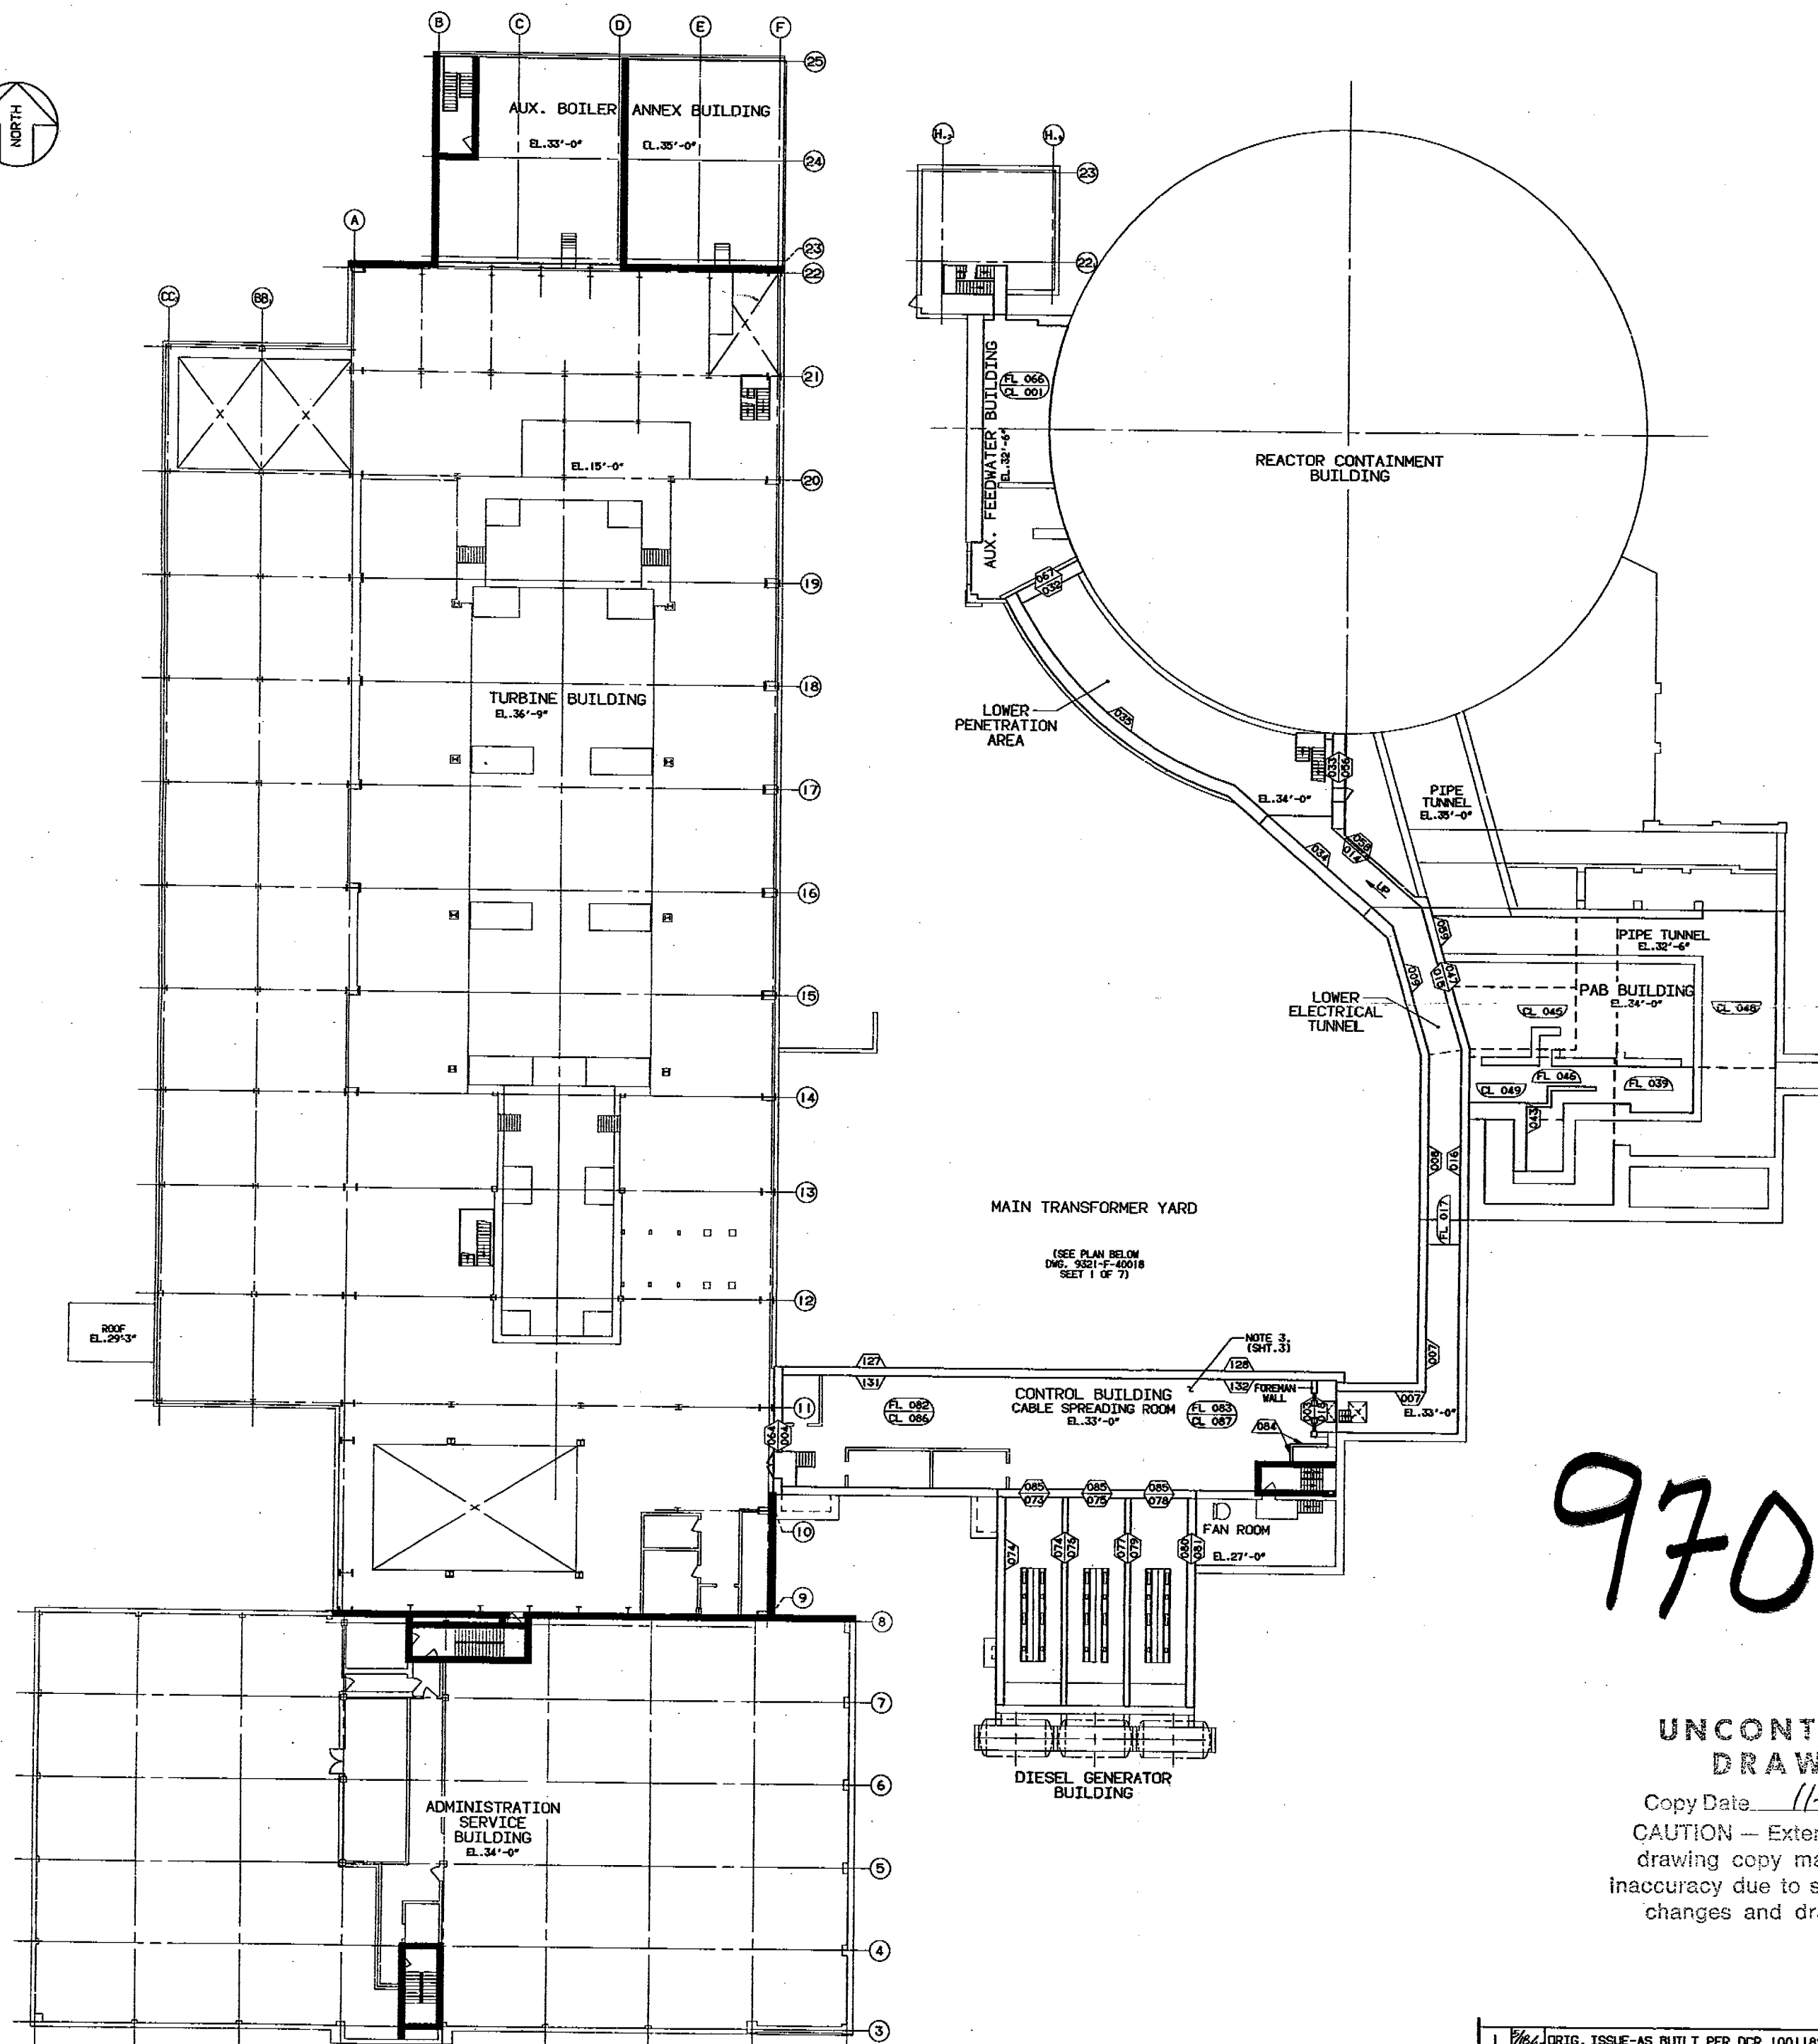


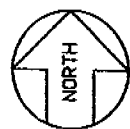

SHT. NO.	FIRE BARRIER CODE NO.
001	AFW-23-CA, AFW-23-CB & AFW-23-CC
002	CTL3-11-2A-TS
003	CTL3-11-MA-TS
004	ETM4-7A-NA & ETM4-7A-MA
005	ETM4-7A-NB
006	ETM4-7A-MC
007	ETM4-7A-EA
008	ETM4-7A-EB
009	ETM4-7A-EC
010	ETM4-7A-FA, ETM4-7A-FB, ETM4-7A-FC & ETM4-7A-FD
011	ETM4-7A-TS
012	ETM4-7A-NA
013	ETM4-7A-SA
014	ETM4-7A-MA
015	ETM4-7A-MB
016	PAB2-4A-FA
017	PAB2-4A-MA
018	PAB2-4A-NB
019	PAB2-4A-MC
020	PAB2-4A-EA
021	PAB2-4A-EB
022	PAB2-4A-EC
023	PAB2-4A-FA
024	PAB2-4A-MA
025	PAB2-4A-NB
026	PAB2-4A-MC
027	PAB2-4A-EA
028	PAB2-4A-EB
029	PAB2-4A-EC
030	PAB2-4A-FA
031	PAB2-4A-MA
032	PAB2-4A-NB
033	PAB2-4A-MC
034	PAB2-4A-EA
035	PAB2-4A-EB
036	PAB2-4A-EC
037	PAB2-4A-FA
038	PAB2-4A-MA
039	PAB2-4A-NB
040	PAB2-4A-MC
041	PAB2-4A-EA
042	PAB2-4A-EB
043	PAB2-4A-EC
044	PAB2-4A-FA
045	PAB2-4A-MA
046	PAB2-4A-NB
047	PAB2-4A-MC
048	PAB2-4A-EA
049	PAB2-4A-EB
050	PAB2-4A-EC
051	PAB2-4A-FA
052	PAB2-4A-MA
053	PAB2-4A-NB
054	PAB2-4A-MC
055	PAB2-4A-EA
056	PAB2-4A-EB
057	PAB2-4A-EC
058	PAB2-4A-FA
059	PAB2-4A-MA
060	PAB2-4A-NB
061	PAB2-4A-MC
062	PAB2-4A-EA
063	PAB2-4A-EB
064	PAB2-4A-EC
065	PAB2-4A-FA
066	PAB2-4A-MA
067	PAB2-4A-NB
068	PAB2-4A-MC
069	PAB2-4A-EA
070	PAB2-4A-EB
071	PAB2-4A-EC
072	PAB2-4A-FA
073	PAB2-4A-MA
074	PAB2-4A-NB
075	PAB2-4A-MC
076	PAB2-4A-EA
077	PAB2-4A-EB
078	PAB2-4A-EC
079	PAB2-4A-FA
080	PAB2-4A-MA
081	PAB2-4A-NB
082	PAB2-4A-MC
083	PAB2-4A-EA
084	PAB2-4A-EB
085	PAB2-4A-EC
086	PAB2-4A-FA
087	PAB2-4A-MA
088	PAB2-4A-NB
089	PAB2-4A-MC
090	PAB2-4A-EA
091	PAB2-4A-EB
092	PAB2-4A-EC
093	PAB2-4A-FA
094	PAB2-4A-MA
095	PAB2-4A-NB
096	PAB2-4A-MC
097	PAB2-4A-EA
098	PAB2-4A-EB
099	PAB2-4A-EC
100	PAB2-4A-FA
101	PAB2-4A-MA
102	PAB2-4A-NB
103	PAB2-4A-MC
104	PAB2-4A-EA
105	PAB2-4A-EB
106	PAB2-4A-EC
107	PAB2-4A-FA
108	PAB2-4A-MA
109	PAB2-4A-NB
110	PAB2-4A-MC
111	PAB2-4A-EA
112	PAB2-4A-EB
113	PAB2-4A-EC
114	PAB2-4A-FA
115	PAB2-4A-MA
116	PAB2-4A-NB
117	PAB2-4A-MC
118	PAB2-4A-EA
119	PAB2-4A-EB
120	PAB2-4A-EC
121	PAB2-4A-FA
122	PAB2-4A-MA
123	PAB2-4A-NB
124	PAB2-4A-MC
125	PAB2-4A-EA
126	PAB2-4A-EB
127	PAB2-4A-EC
128	PAB2-4A-FA
129	PAB2-4A-MA
130	PAB2-4A-NB
131	PAB2-4A-MC
132	PAB2-4A-EA

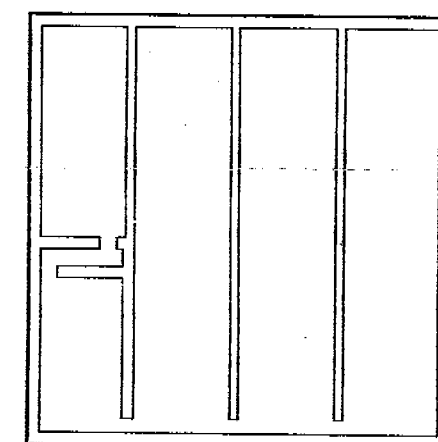

WASTE HOLDUP TANK PIT
EL. 33'-0"

9701070147

ANSTEC
APERTURE
CARD

UNCONTROLLED
DRAWING

Copy Date: 11-6-96

CAUTION — Extended use of this
drawing copy may result in
inaccuracy due to subsequent
changes and drawing updates

NOT NUCLEAR SAFETY RELATED

OWN	CHK'D
DES. SUPV	INDIAN POINT NO. 3 NUCLEAR POWER PLANT
DISCIPLINE ENG	
DISCIPLINE MGR.	FIRE BARRIER PENETRATION WALLS LOCATION SITEMAP PLANS AT EL. 27'-0", 32'-6", 33'-0", 34'-0", 35'-0" & 36'-9"
PROJ. APPROVAL	
DATE	
New York Power Authority	
SCALE: 1/16"=1'-0"	REV
DWG NO. 9321-F-40018	1
SHEET 2 OF 7	

REV	DATE	DESCRIPTION	BY	CHK'D	APP'D
1	11-6-96	ORIG. ISSUE-AS BUILT PER DCR 100118279	DK	US	DK
REVISIONS					

9701070147