
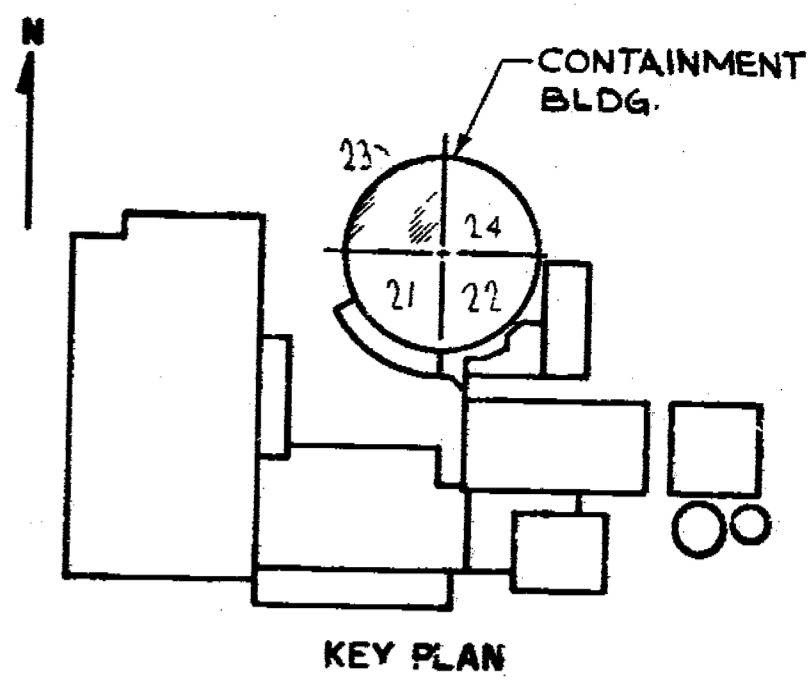


FOR WELD DETAIL
 SEE DWG. P207936

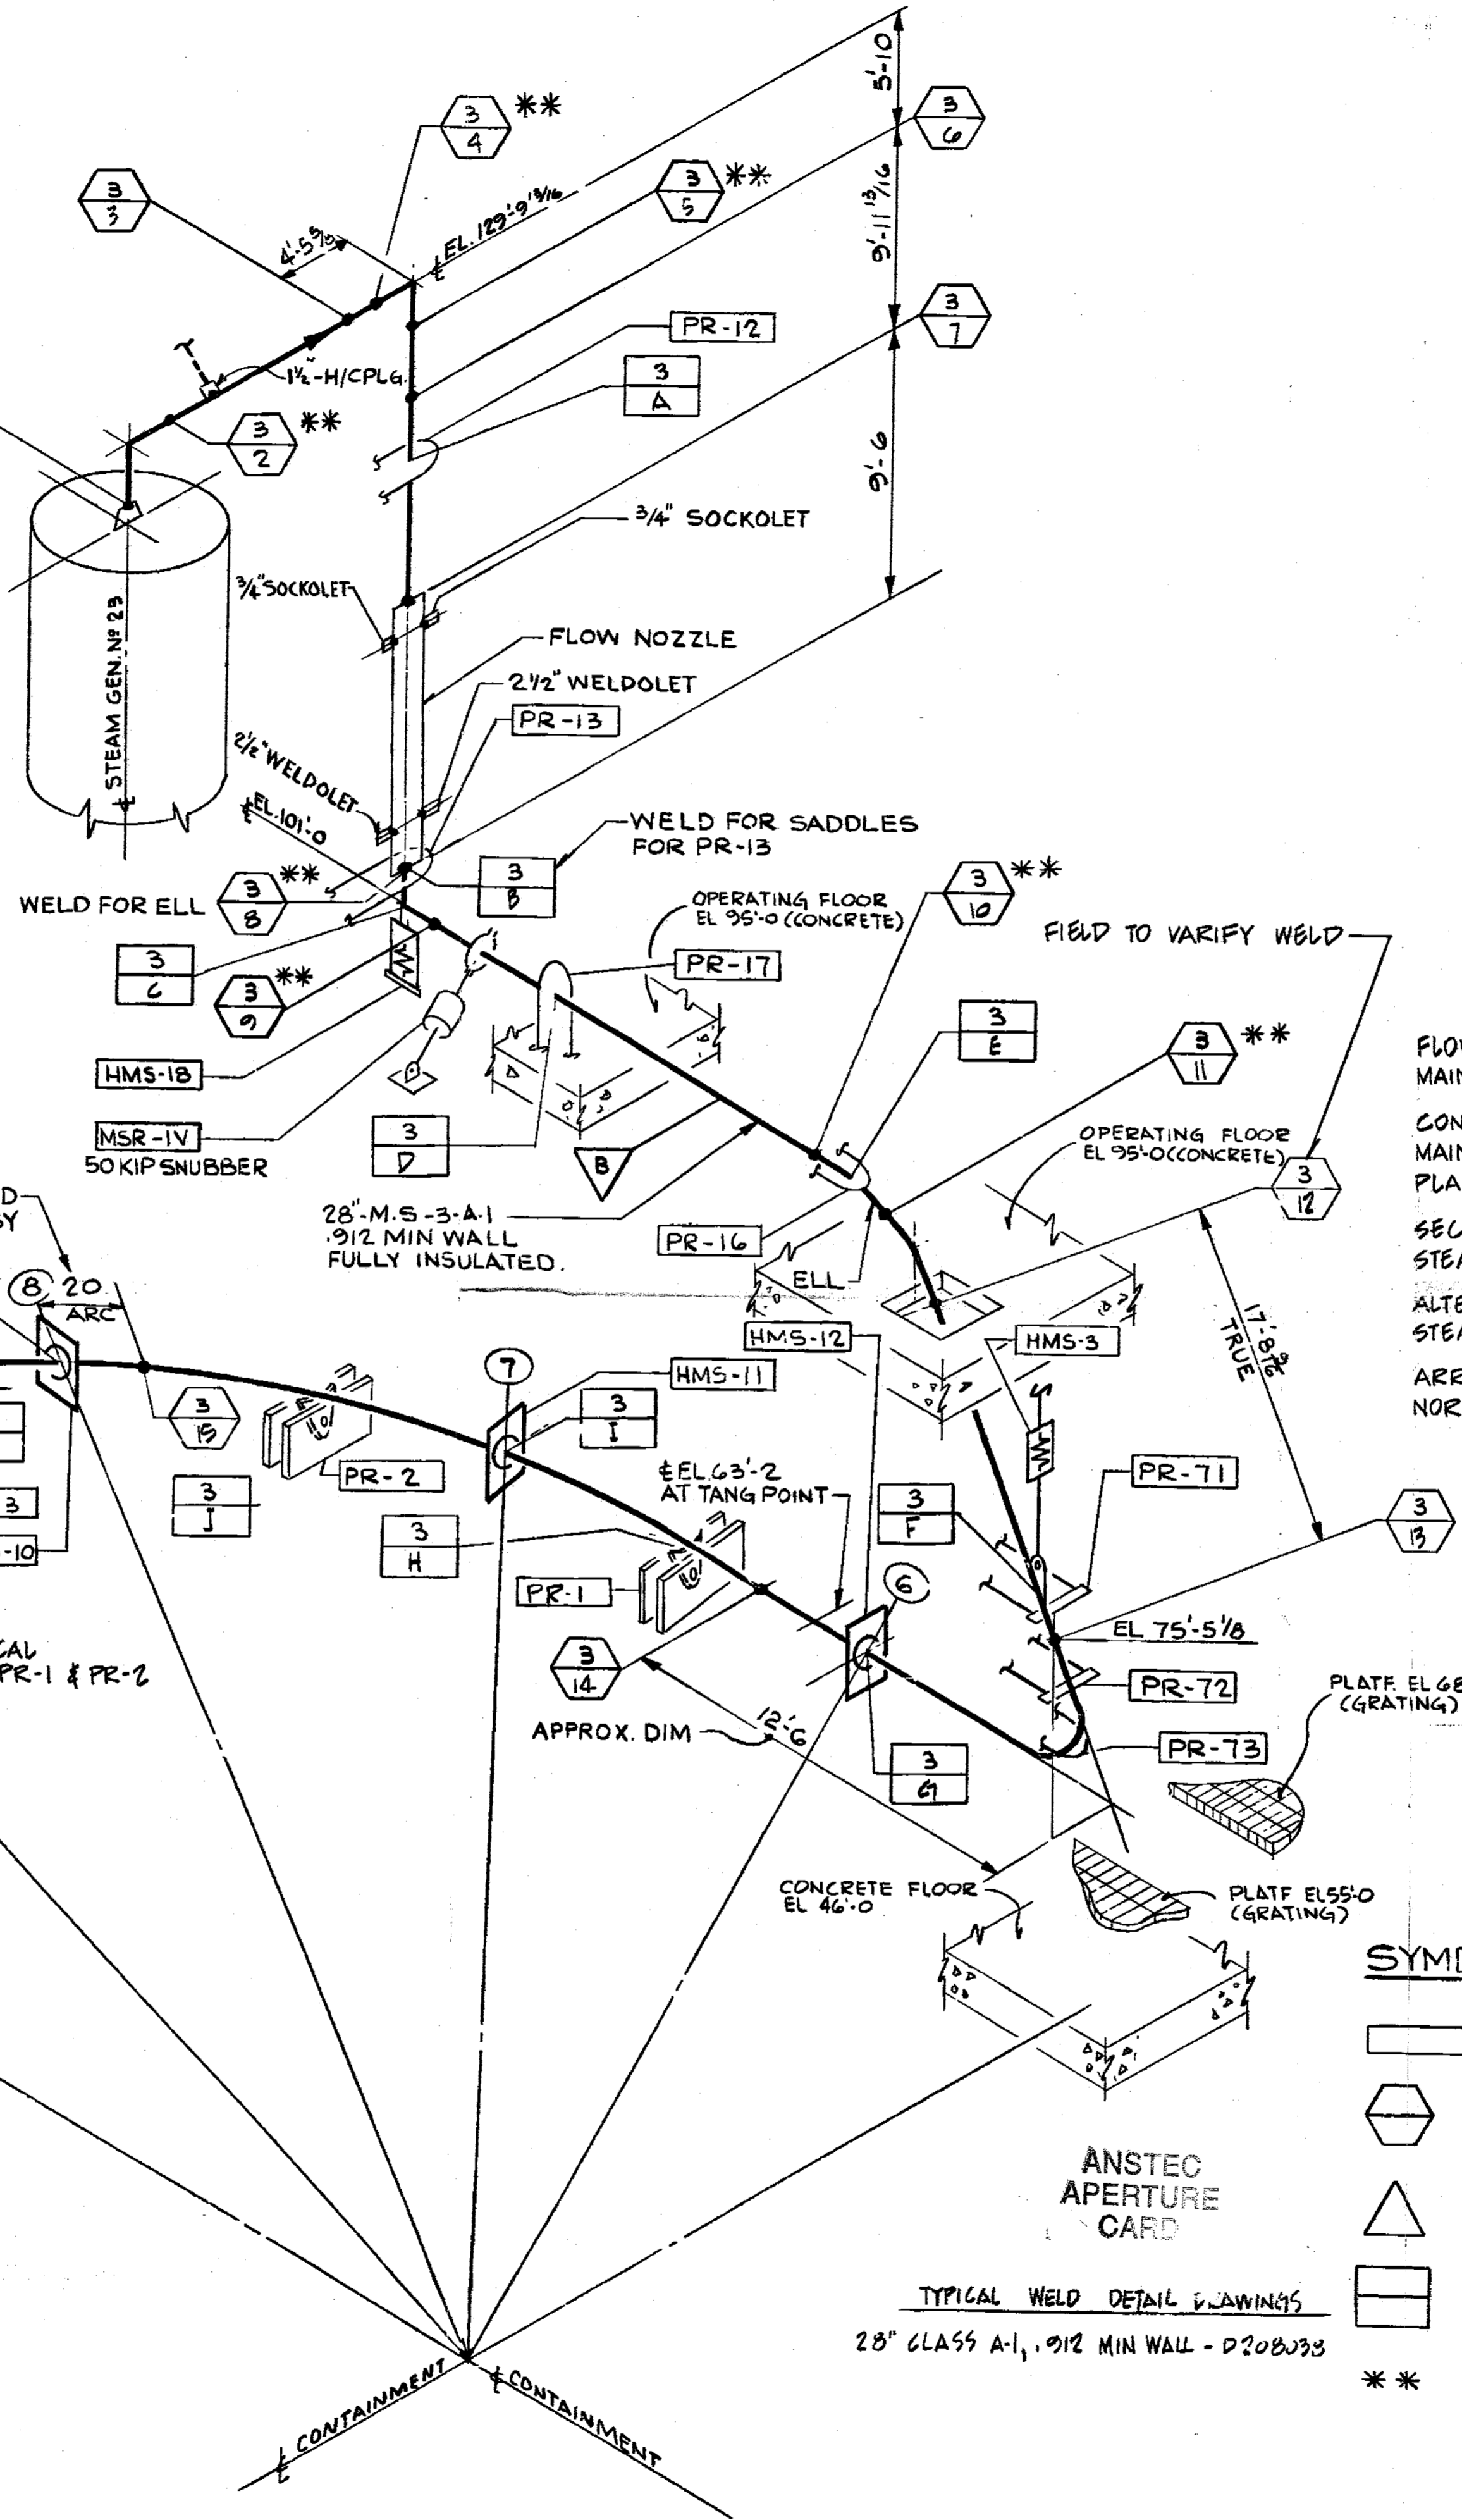

THIS REVISION IS CLASS A PER CI-240-1 UPDATED DWG. PER AS-BUILT INFORMATION AND SERVICE INSPECTION FIELD REVISION INFORMATION.
 RELEASED FOR RECORD P/N 69982-AD-4
 NPS 12/17/93 AAA

Docket # 50-247
 Accession # 9403110117
 Date 2/22/94 of Ltr
 Regulatory Docket File


REFERENCE DRAWINGS

- FLOW DIAGRAM MAIN STEAM SYSTEM 9321-F-2017
- CONTAINMENT BUILDING MAIN STEAM PIPING PLAN-STEAM GEN'S NO. 23 & 24 9321-F-2940
- SECTIONS & DETAILS STEAM GENERATORS NO. 23 & 24 9321-F-2942
- ALTERATIONS TO MAIN STEAM PIPING STEAM GENERATOR NO. 23 9321-F-2944
- ARR'GT OF PIPE RESTRAINTS NORTH HALF - SHEET 1 9321-F-2798

THIS DRAWING CONTAINS ITEMS WHICH MUST BE CONTROLLED WITHIN CON EDISON AS:
"CLASS A" ITEMS
 PER CI-240-1

NOT FOR FABRICATION OR INSTALLATION

NOT FOR FABRICATION OR INSTALLATION

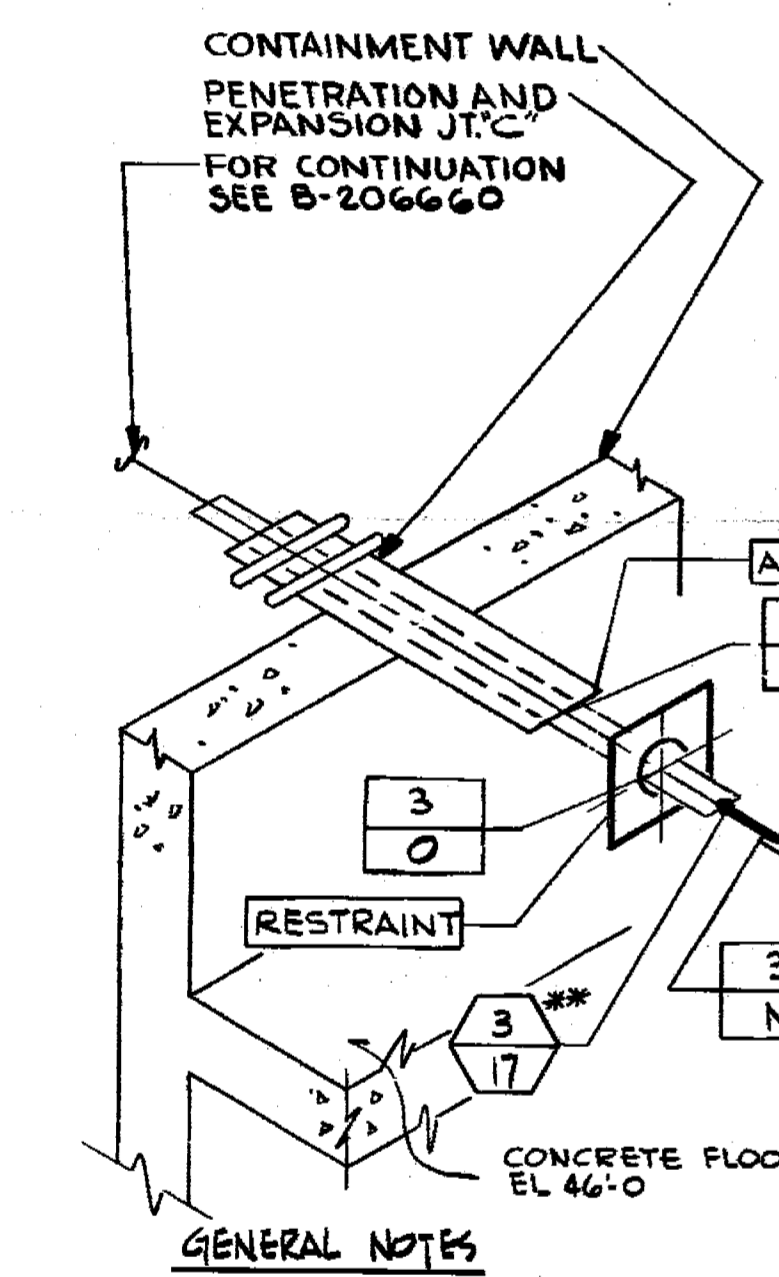

- GENERAL NOTES**
1. WELDS LESS THAN 2 1/2" NOM. PIPE DIA. SOCKET WELDED; 2 1/2" AND LARGER BUTT-WELDED
 2. WELDS IN QUALITY GROUP B PIPING, FOUR INCH NOM PIPE DIA. OR LESS ARE EXEMPT FROM NDT REQUIREMENTS PER IWC-1222 (a) & (b).
 3. (*) INDICATES REMOVABLE INSULATION

SYMBOL IDENTIFICATION

- SUPPORT NUMBER
- WELD NUMBER
- QUALITY GROUP CLASSIFICATION
- INTEGRAL SUPPORT WELD NUMBER
- STRUCTURAL DISCONTINUITY PER TABLE IWC-2520.

B206659-5
 CONSOLIDATED EDISON CO.
 OF NEW YORK, INC.

STATION LOCATION INDIAN POINT NO. 2	
INSERVICE INSPECTION ISOMETRIC OF MAIN STEAM LINE NO. 3	
INSIDE CONTAINMENT	
SCALE NONE DRAWN BY C.ZAPATA RECORDED	
P# 7076 CHECKED BY M. STEINAUER	
CHG	ELECT MECH STRUCT DIST
GENERAL ENGINEERING	CHIEF DESIGNER
MECHANICAL ENGINEERING	MECH. PLAN. ENGINEER
CIVIL ENGINEERING	PLANT STRUCT. ENGINEER
ELECTRICAL ENGINEERING	T & D STRUCT. ENGINEER
PRODUCTION	STATION ELECT. ENGINEER
	T & D ENGINEER
	GAS & STEAM OPERATIONS
	STRUCT. ENGINEER
	CONVENTIONAL POWER
	NUCLEAR POWER

REVISIONS	
1	THIS ISSUE IS NON-CLASS "A" PER CI-240-1. RELEASE FOR RECORD. P.N. 7076 11-3-78
2	THIS REVISION IS NON-CLASS "A" PER CI-240-1. ADDED REF. DRAWINGS. ADDED LATEST REV. NO TO REF. DWG. RELEASE FOR RECORD. P.N. 7076 J.R.JAS EBASCO SERVICES, INC. 1-10-80
3	THIS REVISION IS NON-CLASS "A" PER CI-240-1. ADDED LATEST REV. NO TO REF. DWG'S RELEASE FOR RECORD. P.N. 21369. TREADWELL CORP. 11-12-82.
4	THIS REV. IS NON-CLASS PER CI-240-1. CHANGED DISCIPLINE FROM ME TO ME. REL. FOR RECORD.