
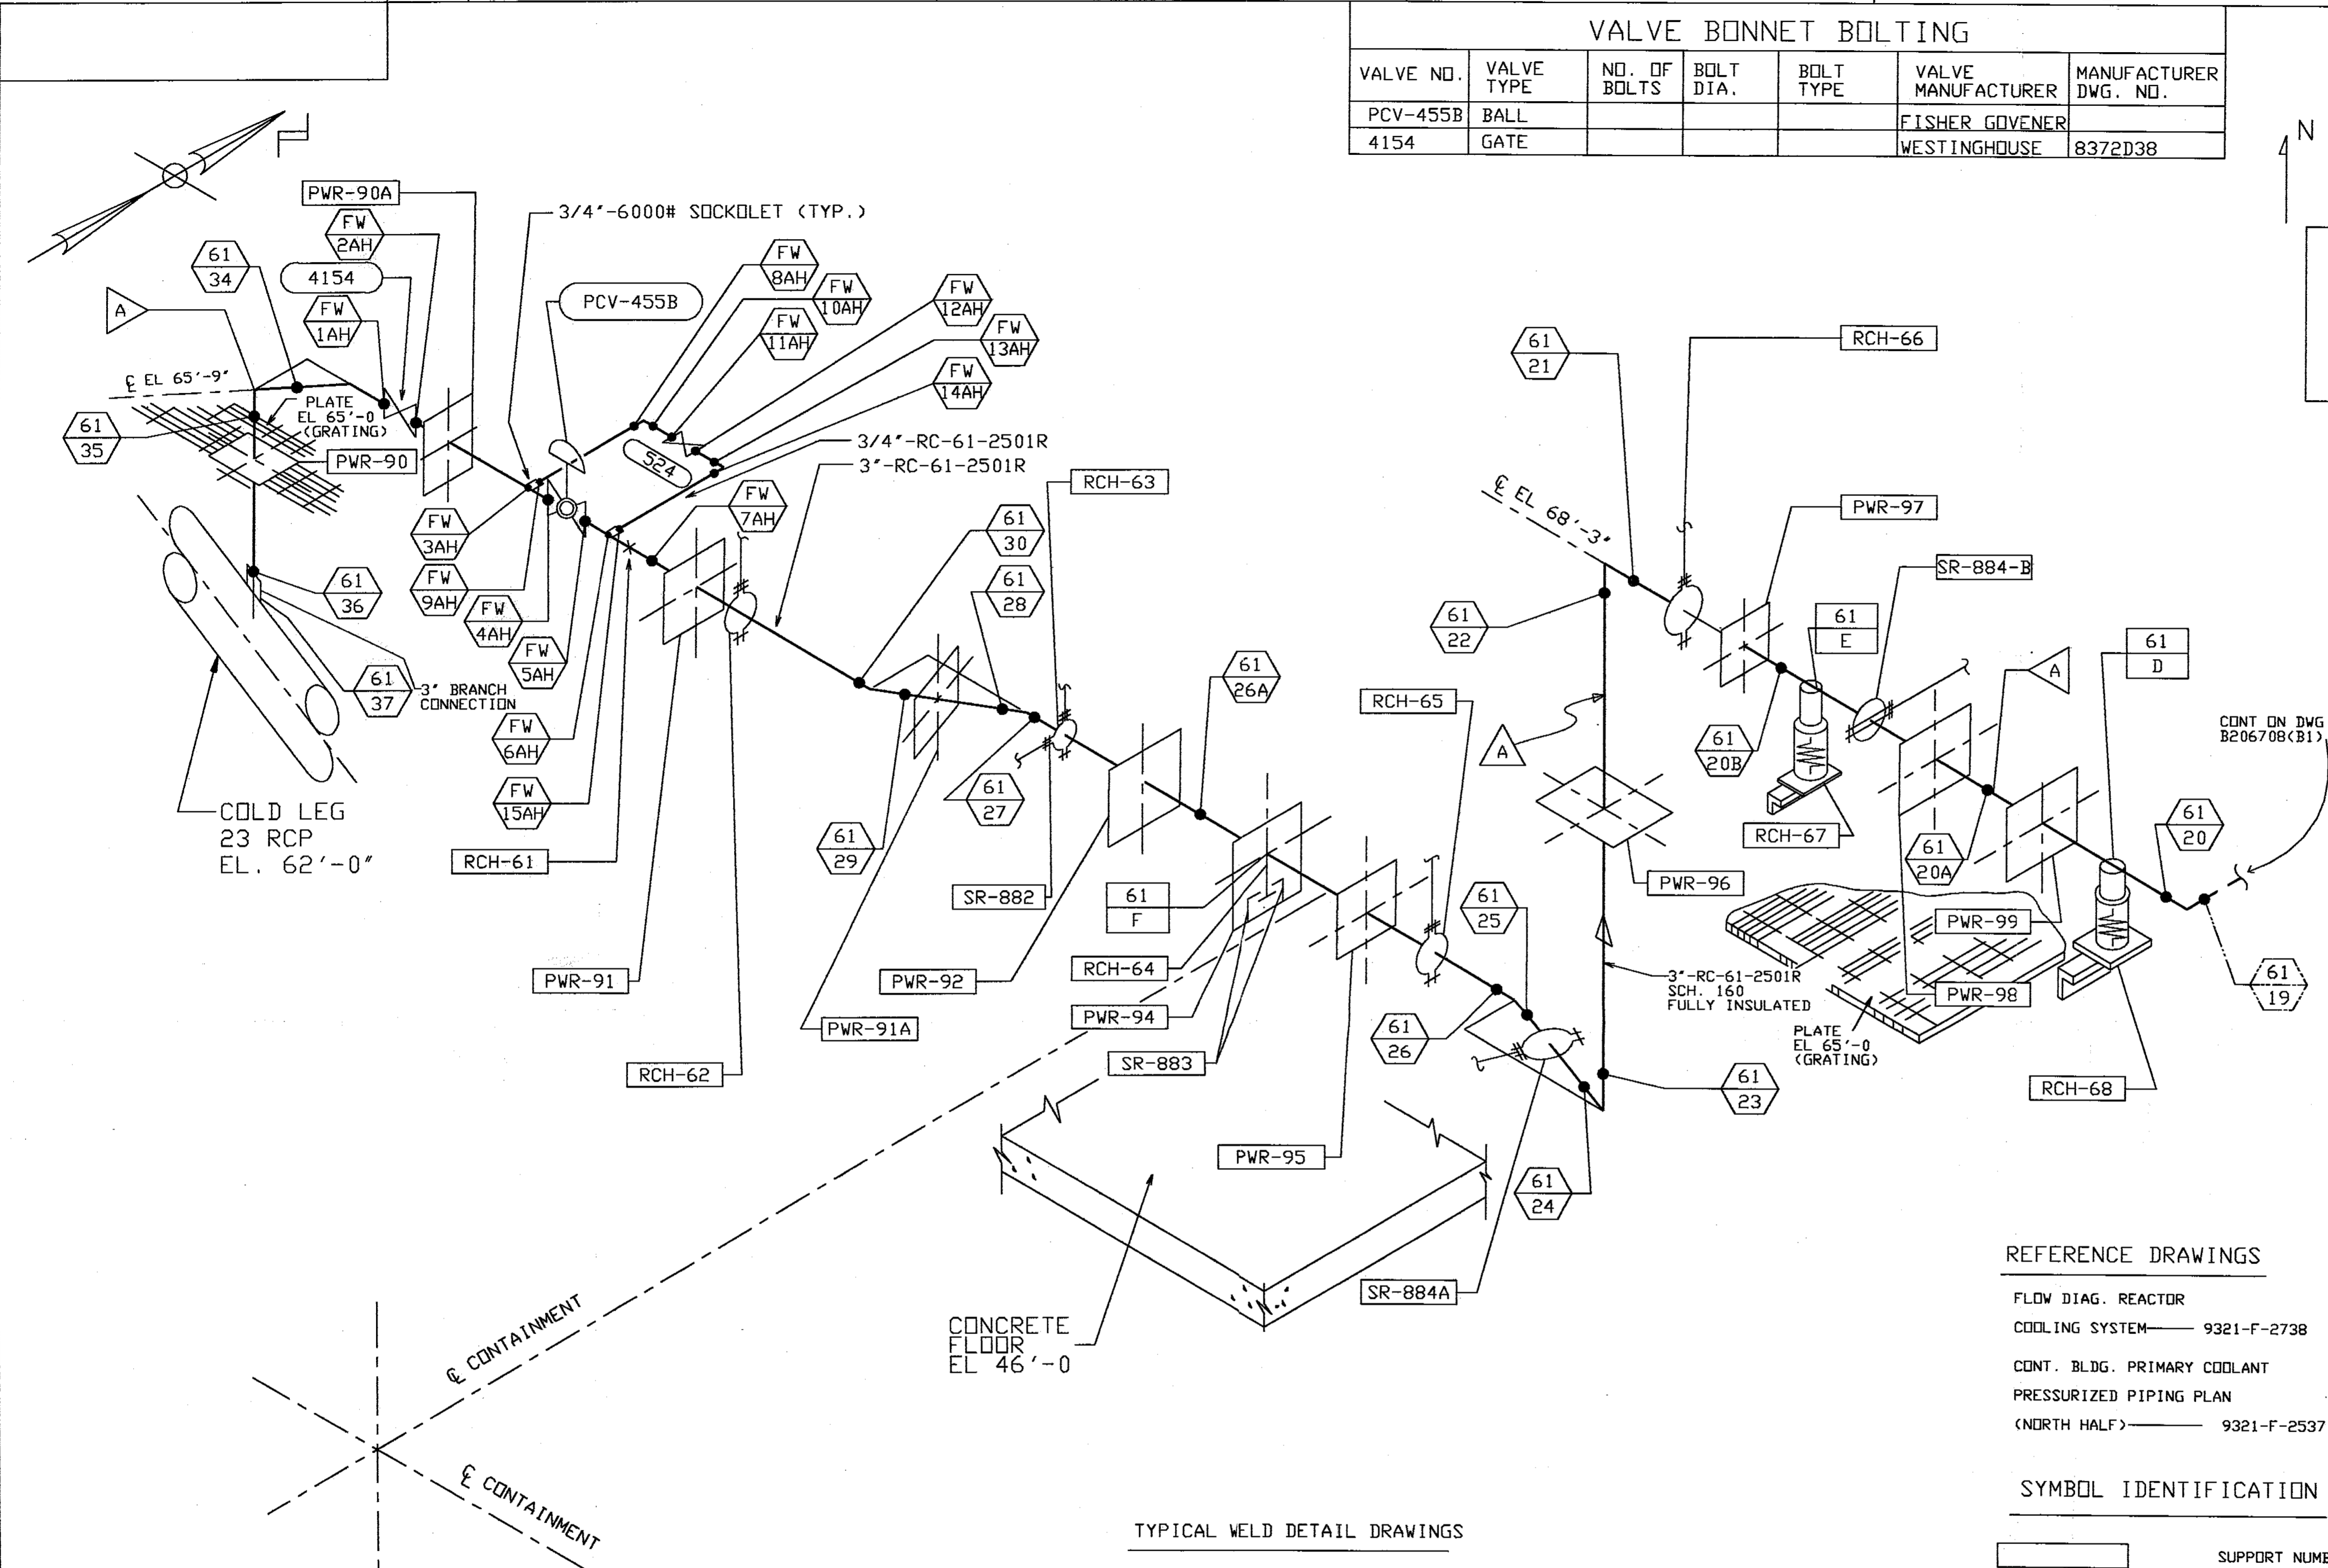


VALVE BONNET BOLTING						
VALVE NO.	VALVE TYPE	NO. OF BOLTS	BOLT DIA.	BOLT TYPE	VALVE MANUFACTURER	MANUFACTURER DWG. NO.
PCV-455B	BALL				FISHER GOVENER	
4154	GATE				WESTINGHOUSE	8372D38

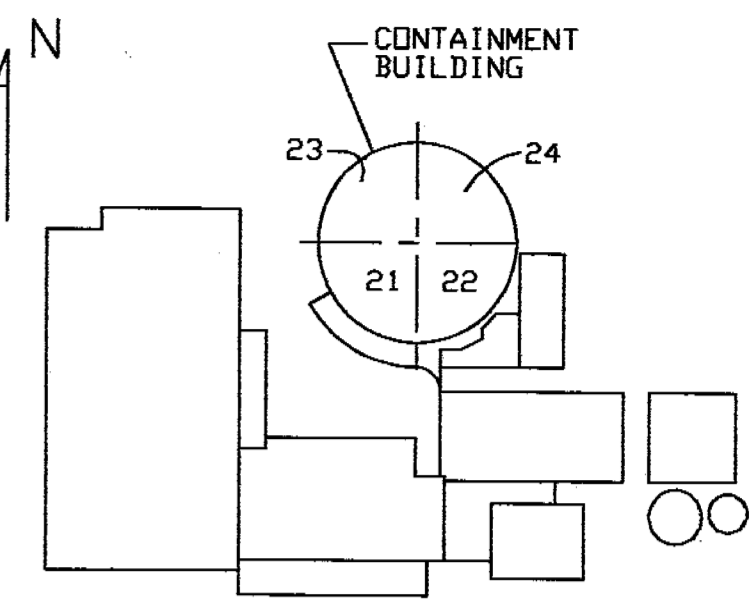

- REFERENCE DRAWINGS**
- FLOW DIAG. REACTOR COOLING SYSTEM — 9321-F-2738
  - CONT. BLDG. PRIMARY COOLANT PRESSURIZED PIPING PLAN (NORTH HALF) — 9321-F-2537

- SYMBOL IDENTIFICATION**
- [Rectangle] SUPPORT NUMBER
  - [Oval] VALVE NUMBER
  - [Hexagon] WELD NUMBER
  - [Triangle] QUALITY GROUP IDENTIFICATION
  - [Square] INTEGRAL SUPPORT WELD NUMBER

**NOT FOR FABRICATION OR INSTALLATION**

THIS DRAWING CONTAINS ITEMS WHICH MUST BE CONTROLLED WITHIN CON EDISON AS:  
**"CLASS A" ITEMS**  
 PER CI-240-1

Docket # 30-247  
 Accession # 24031017  
 Date 2/25/94 of Ltr  
 Regulatory Docket File

**TYPICAL WELD DETAIL DRAWINGS**  
 3" CLASS 2501, SCH 160-D208005

ANSTEC APERTURE CASE

DATE: 12-11-93

COMPUTER GENERATED DRAWING NOT TO BE HAND REVISED

FOR GENERAL NOTES SEE DWG B206708

REVISIONS	REV. 07-THIS REV. IS CLASS "A" PER CI-240-1 UPDATED DWG. AS PER AS-BUILT INFORMATION AND SERVICE INSPECTION FIELD REVISION INFORMATION. RELEASED FOR RECORD P/N 69982-AD-4 NPS 12-15-93 /AAA	DATE	CHK.	SUPV.	DESIGN ENG.	DISC. ENG.	ENG. MGR.	TITLE: INSERVICE INSPECTION ISOMETRIC OF PRESSURIZER SPRAY LINE #61 INSIDE CONTAINMENT	SHE 1-2 STATION INDIAN POINT #2
								SHT. 1 OF 2	
	CONTR. BY	DATE	REVIEW	APPROVALS	DRWN. BY P. DENE	SCALE NONE	REC'D	DWG. NO. B206707-07 MJ	