


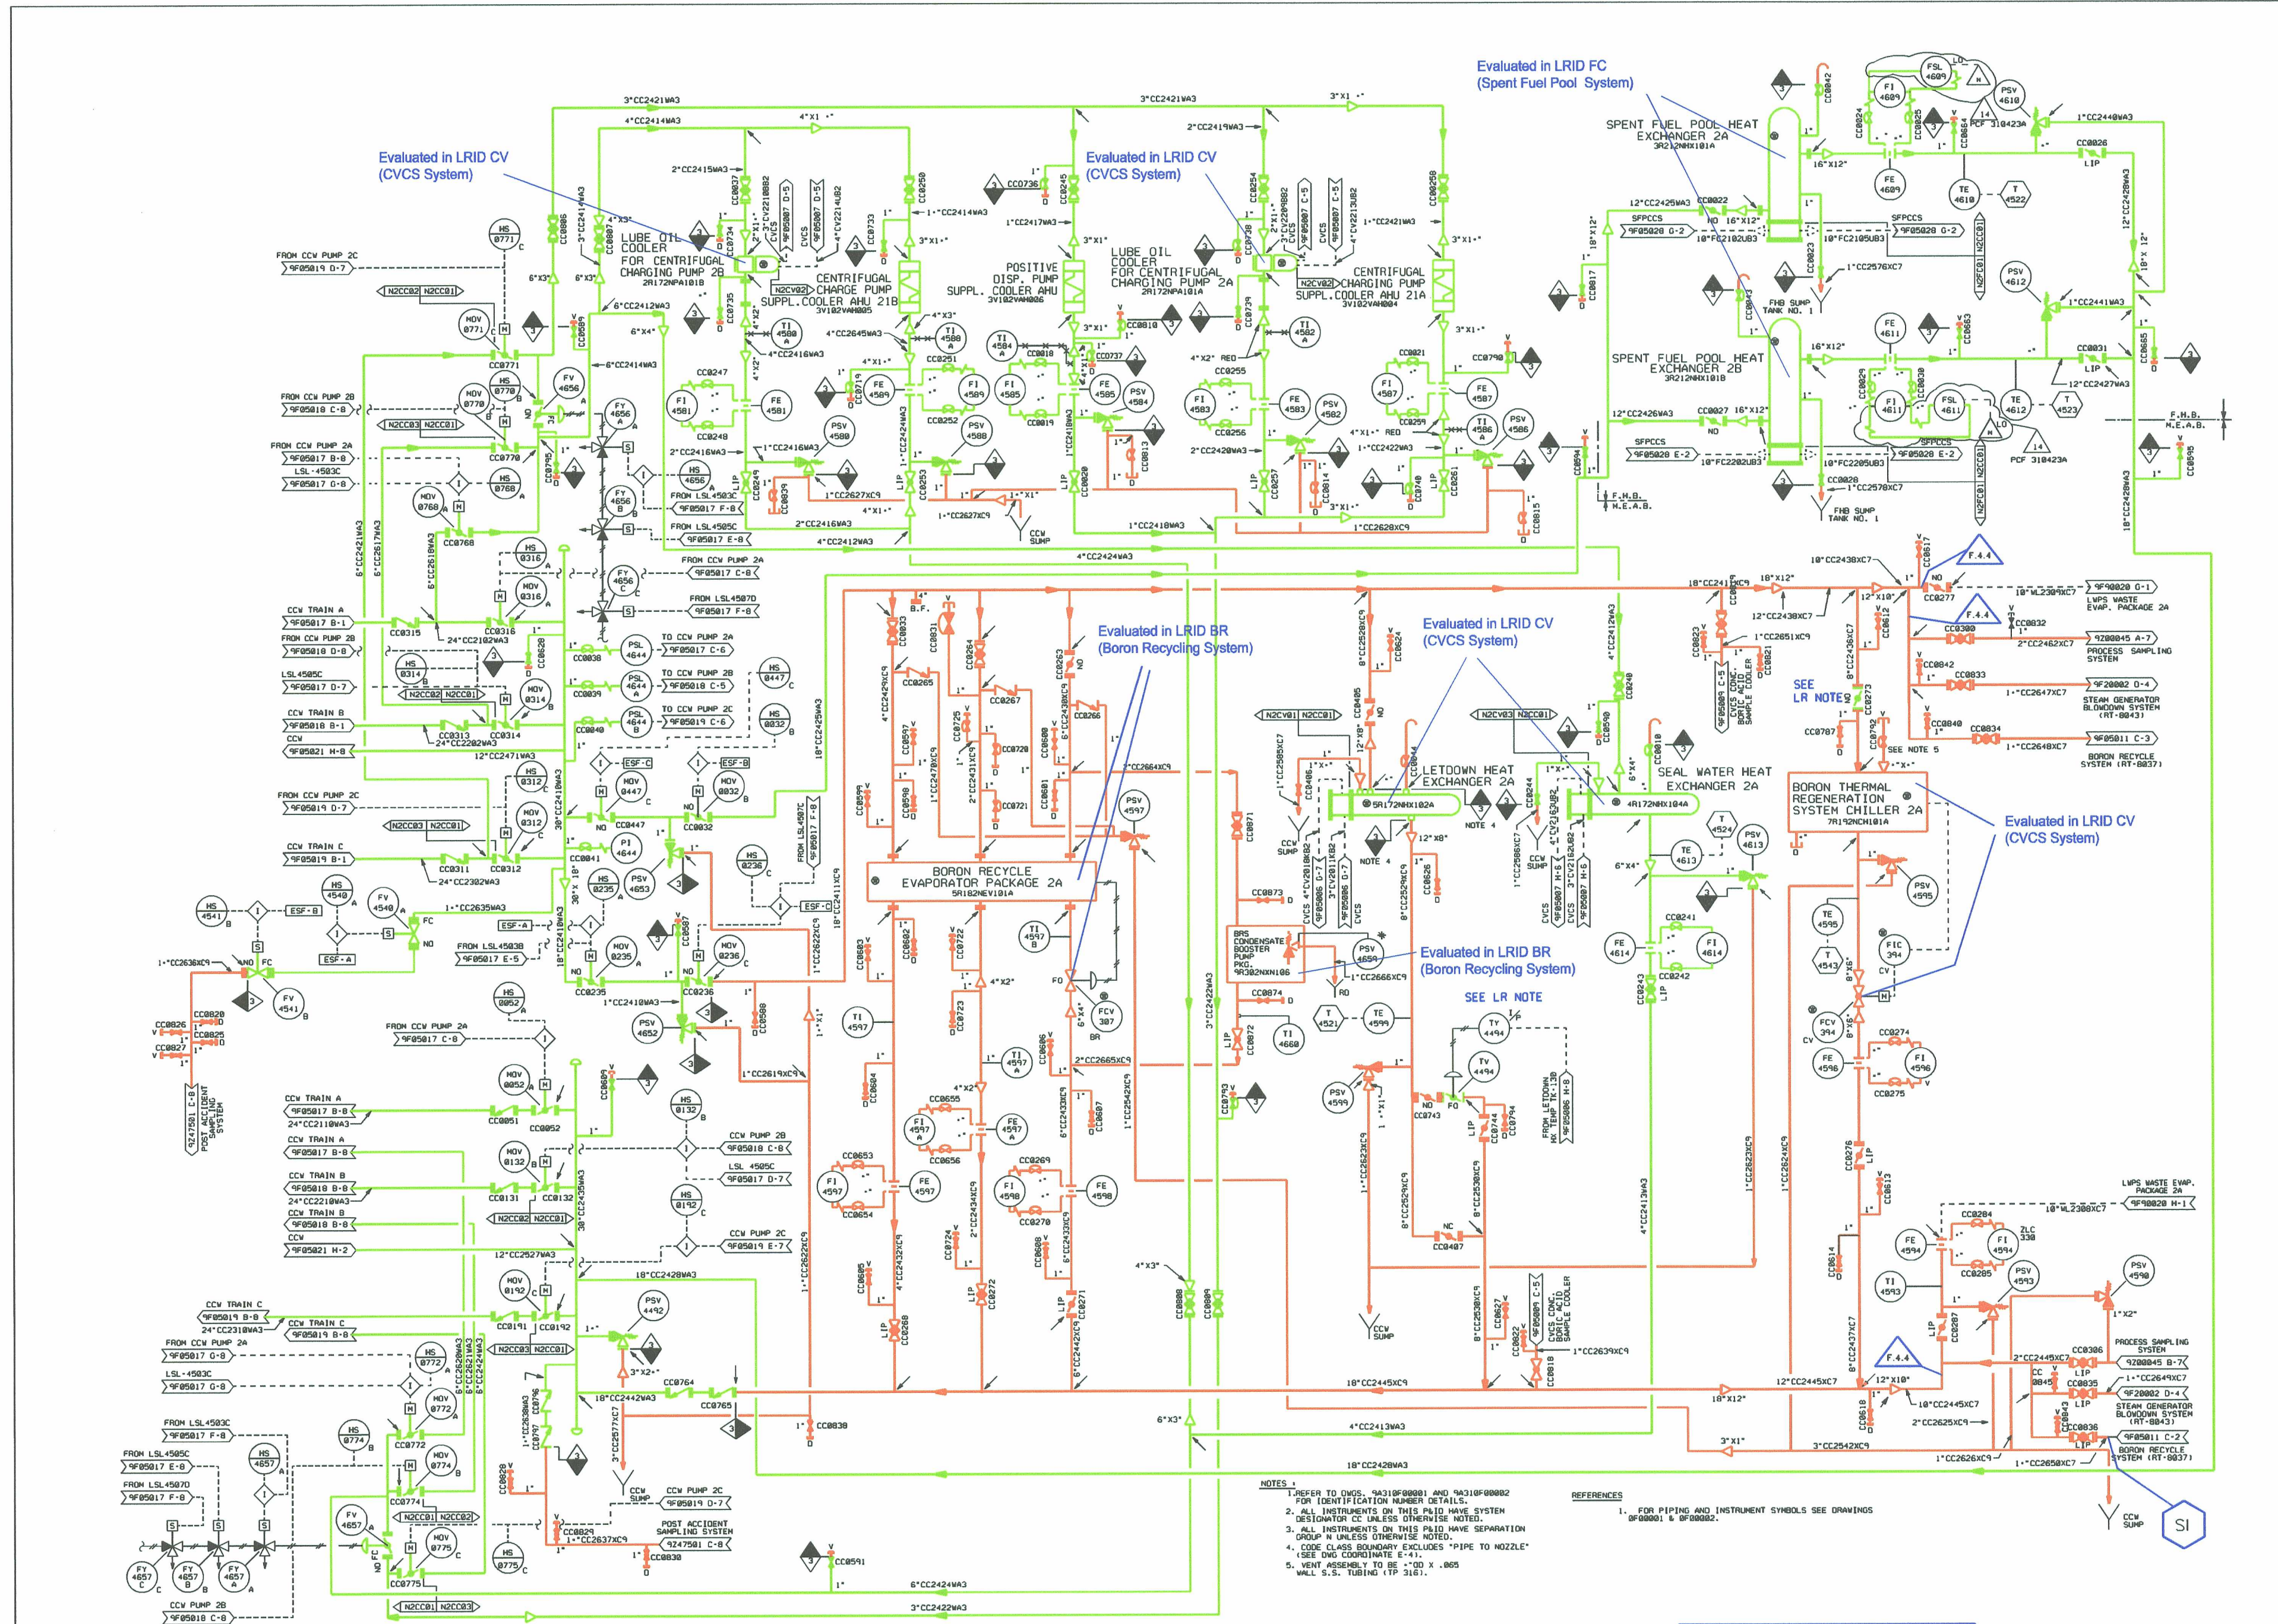

LR NOTE: VALVES -TV4494 AND -CC0273 ARE WITHIN THE SCOPE OF LICENSE RENEWAL FOR (A) (3) CONSIDERATIONS.				LR BOUNDARY DRAWING NO. LR-STP-CC-5R209F05020#2		REV. 0B
14	INCORP. PCF 310423A & EDITORIAL CHANGES FOR UNITIZATION.	VJM				
13	INCORP. DCN MD-02530.	SIGNATURES ON FILE				
12	INCORP. DCN MD-9.	SIGNATURES ON FILE				
11	HL&P ASSUMES DESIGN CHANGE CONTROL AND INCORP. DCN MD-2112.	SIGNATURES ON FILE				
10	REDRAWN / ISSUED FOR CONSTRUCTION.	SIGNATURES ON FILE				
NO.	ISSUE DATE	REVISION	ORIG	CKR	RE	SV
1						
2						
3						
4						
5						
6						
7						
8						

SOUTH TEXAS PROJECT
NUCLEAR OPERATING COMPANY

PIPING AND INSTRUMENTATION DIAGRAM
COMPONENT COOLING WATER SYSTEM

PRIORITY	CADD FILE NO.	FSUG. NO.	STI. NO.	SCALE	DWG. NO.	SHT.	REV.
1	FJA541.141	0070928		NONE	5R209F05020#2		14

2021