


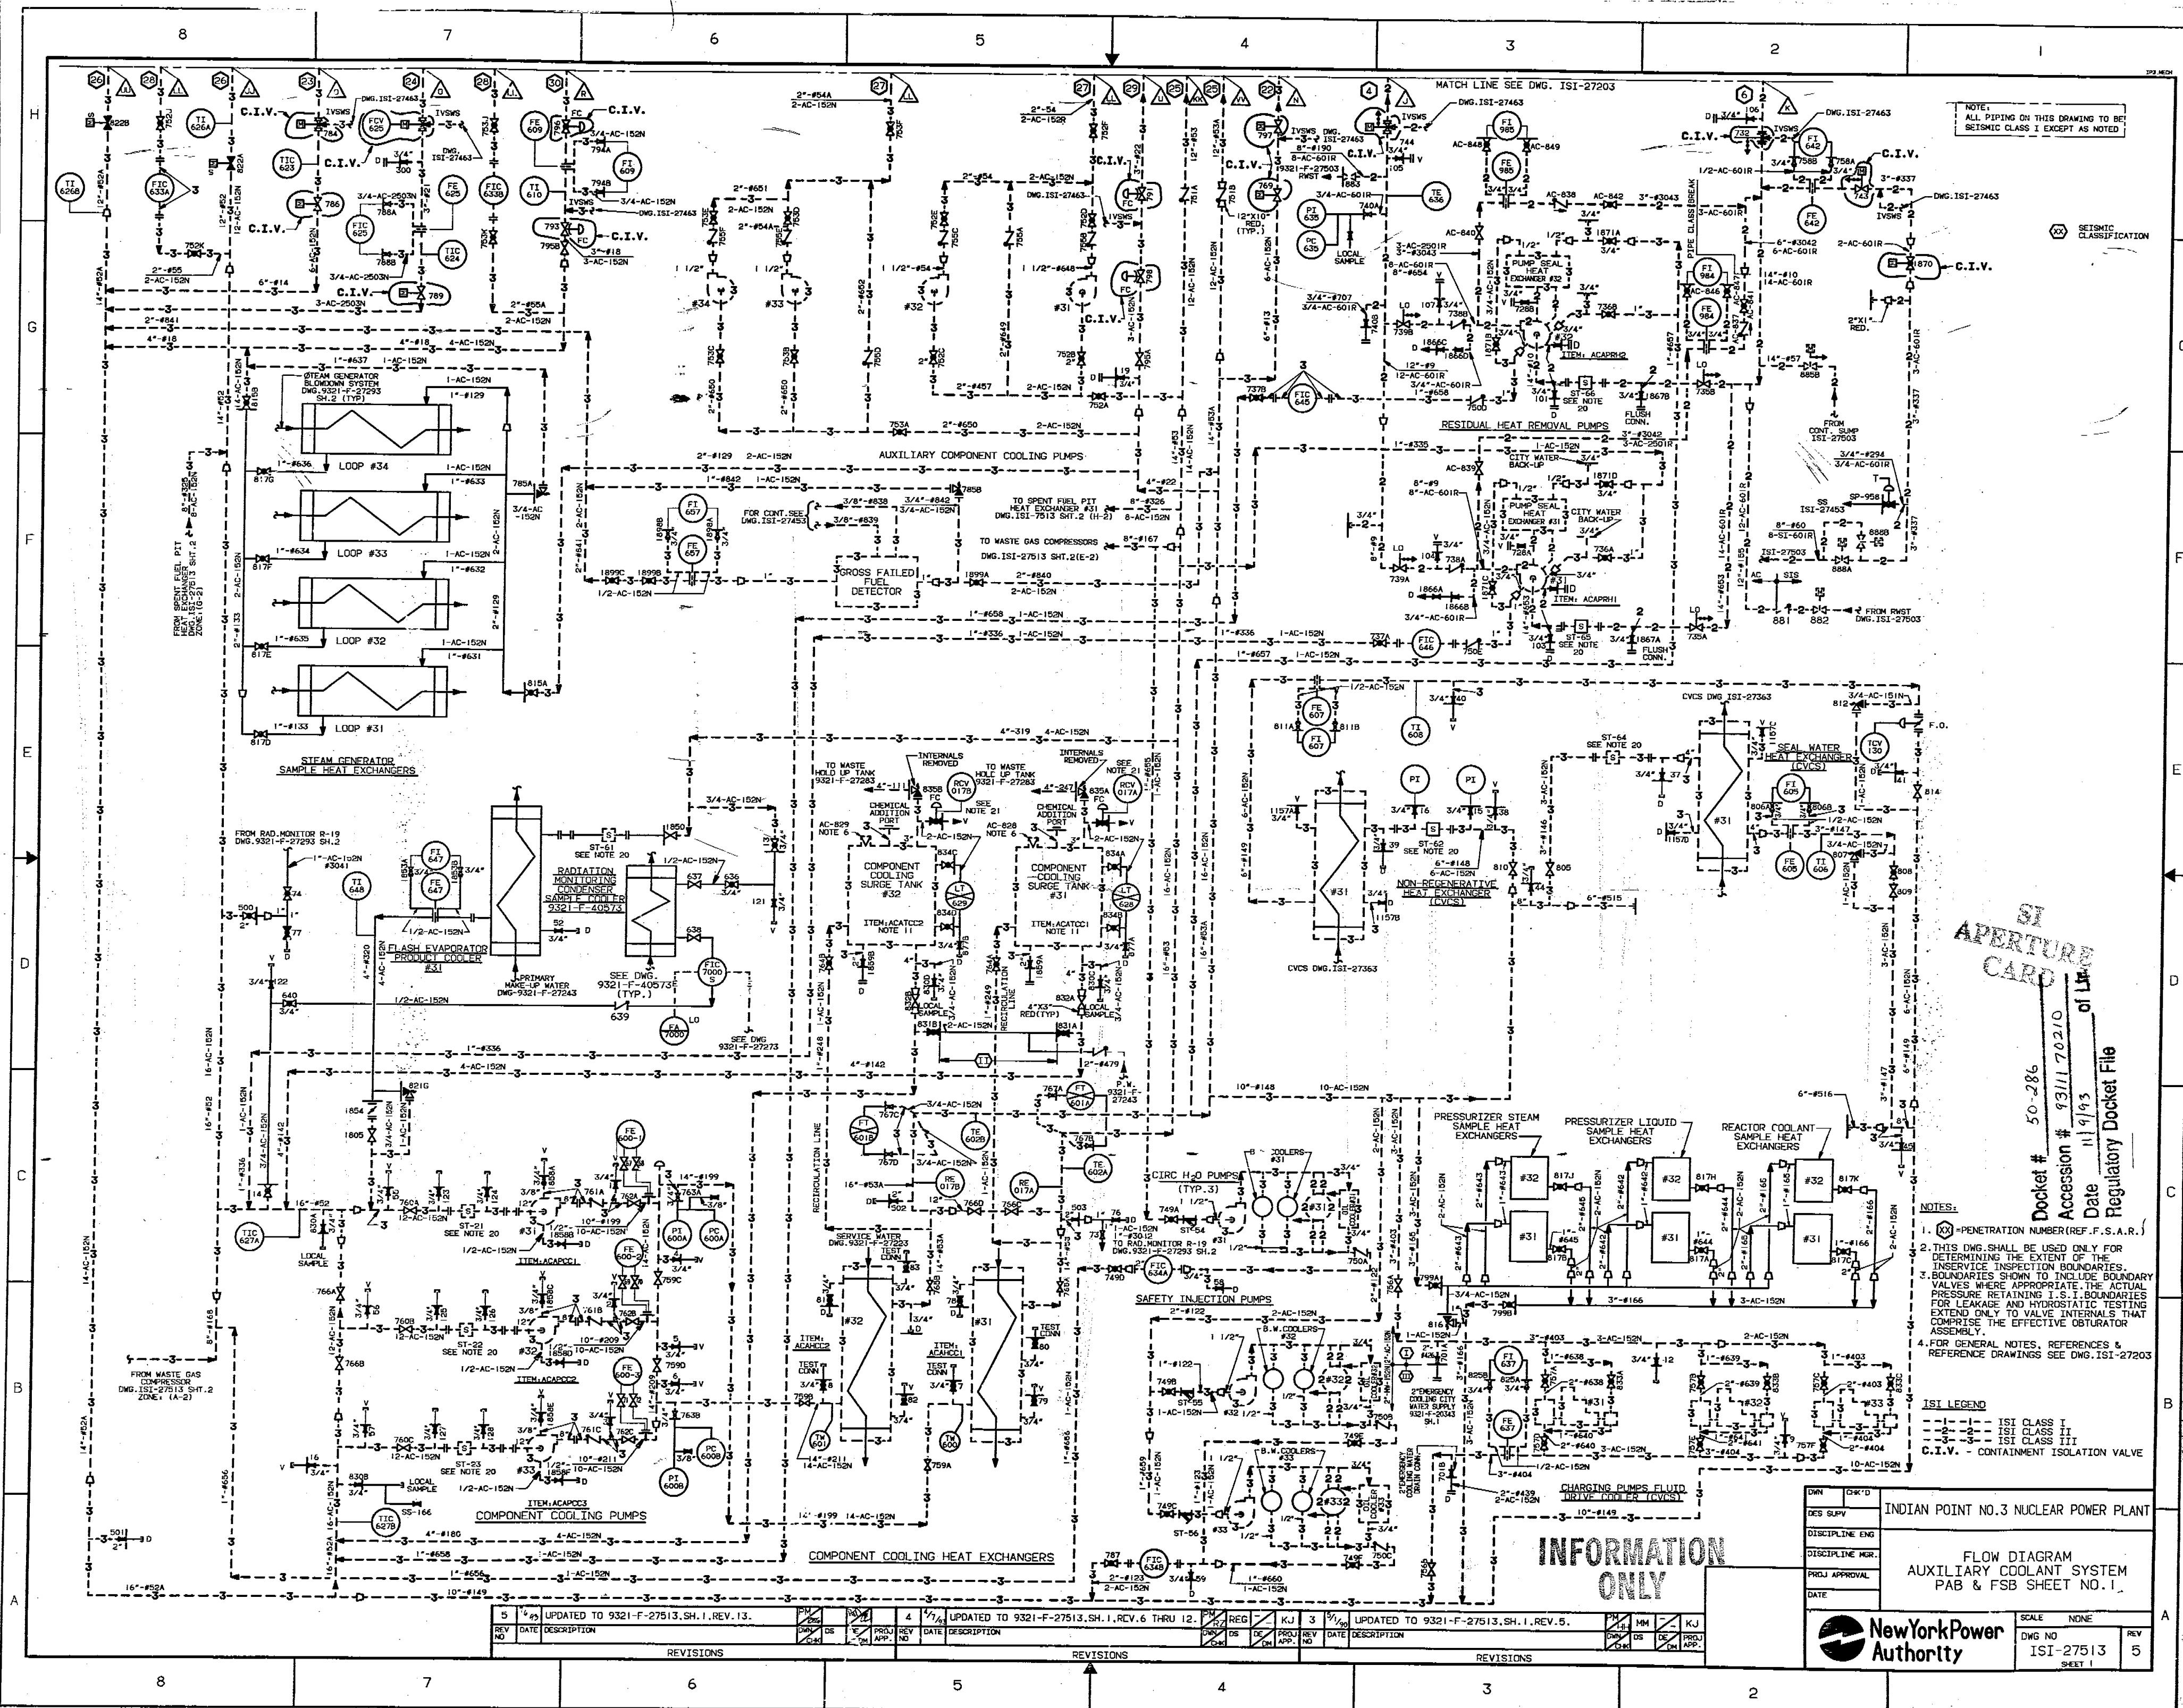

NOTE:  
ALL PIPING ON THIS DRAWING TO BE  
SEISMIC CLASS I EXCEPT AS NOTED

SEISMIC CLASSIFICATION

SI  
APERTURE  
CARD

Docket # 50-286  
Accession # 9311170210  
Date 11/9/93  
Regulatory Docket File

- NOTES:
1. PENETRATION NUMBER (REF. F.S.A.R.)
  2. THIS DWG. SHALL BE USED ONLY FOR DETERMINING THE EXTENT OF THE INSERVICE INSPECTION BOUNDARIES.
  3. BOUNDARIES SHOWN TO INCLUDE BOUNDARY VALVES WHERE APPROPRIATE. THE ACTUAL PRESSURE RETAINING I.S.I. BOUNDARIES FOR LEAKAGE AND HYDROSTATIC TESTING EXTEND ONLY TO VALVE INTERNALS THAT COMPRISE THE EFFECTIVE OBSTURATOR ASSEMBLY.
  4. FOR GENERAL NOTES, REFERENCES & REFERENCE DRAWINGS SEE DWG. ISI-27203

ISI LEGEND

- ISI CLASS I
- - - ISI CLASS II
- - - ISI CLASS III
- C.I.V. - CONTAINMENT ISOLATION VALVE

INFORMATION  
ONLY

| REV. 5 |         |                                        |    | REV. 4 |         |                                               |    | REV. 3 |         |                                       |    | REV. 2 |         |                                       |    | REV. 1 |         |                                       |    |
|--------|---------|----------------------------------------|----|--------|---------|-----------------------------------------------|----|--------|---------|---------------------------------------|----|--------|---------|---------------------------------------|----|--------|---------|---------------------------------------|----|
| NO.    | DATE    | DESCRIPTION                            | BY | NO.    | DATE    | DESCRIPTION                                   | BY | NO.    | DATE    | DESCRIPTION                           | BY | NO.    | DATE    | DESCRIPTION                           | BY | NO.    | DATE    | DESCRIPTION                           | BY |
| 5      | 11/9/93 | UPDATED TO 9321-F-27513, SH.1, REV.13. |    | 4      | 11/9/93 | UPDATED TO 9321-F-27513, SH.1, REV.6 THRU 12. |    | 3      | 11/9/93 | UPDATED TO 9321-F-27513, SH.1, REV.5. |    | 2      | 11/9/93 | UPDATED TO 9321-F-27513, SH.1, REV.4. |    | 1      | 11/9/93 | UPDATED TO 9321-F-27513, SH.1, REV.3. |    |

|                                                                  |          |
|------------------------------------------------------------------|----------|
| INDIAN POINT NO.3 NUCLEAR POWER PLANT                            |          |
| FLOW DIAGRAM<br>AUXILIARY COOLANT SYSTEM<br>PAB & FSB SHEET NO.1 |          |
| New York Power Authority                                         |          |
| DWG NO<br>ISI-27513<br>SHEET 1                                   | REV<br>5 |