



ROOF PLAN EL 689.0


NOTES:  
1. FOR GENERAL NOTES & REFERENCE DRAWINGS SEE 3CW0330-00-1 & 2.

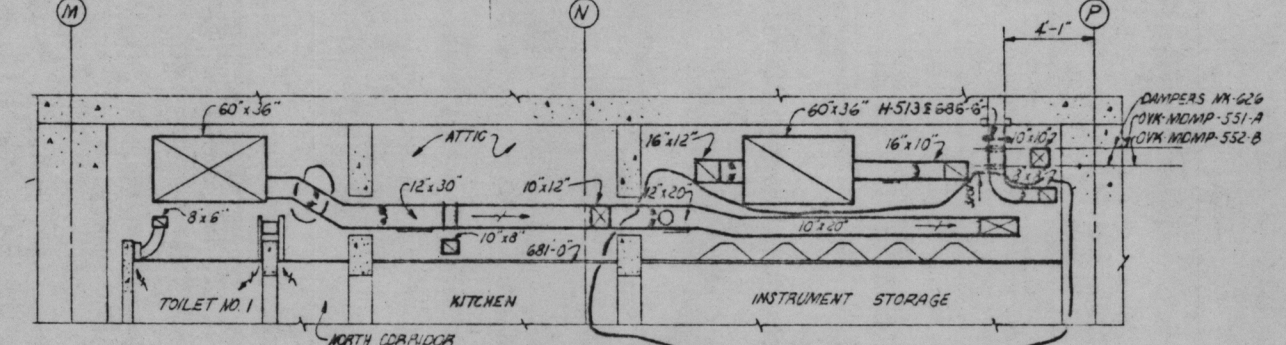


SECTION AB-AB SHEET 6 ECN 546

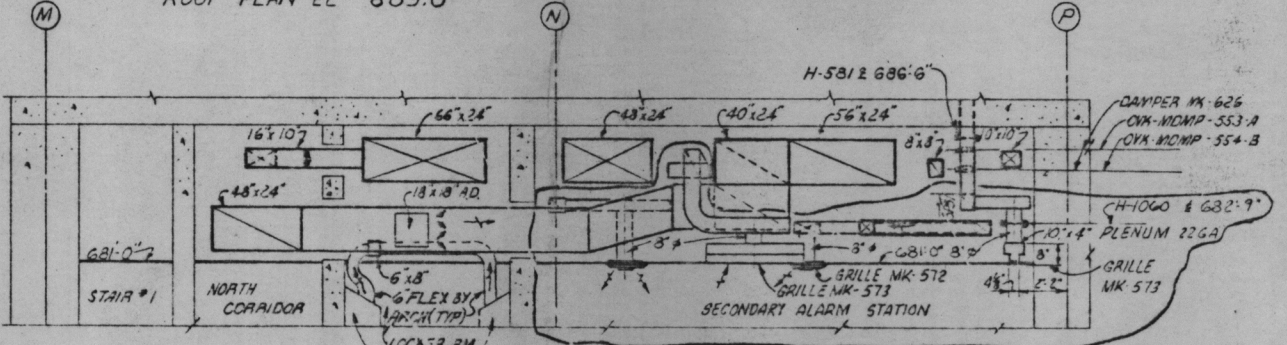

SECTION CB-CB SHEET 6 ECN 546

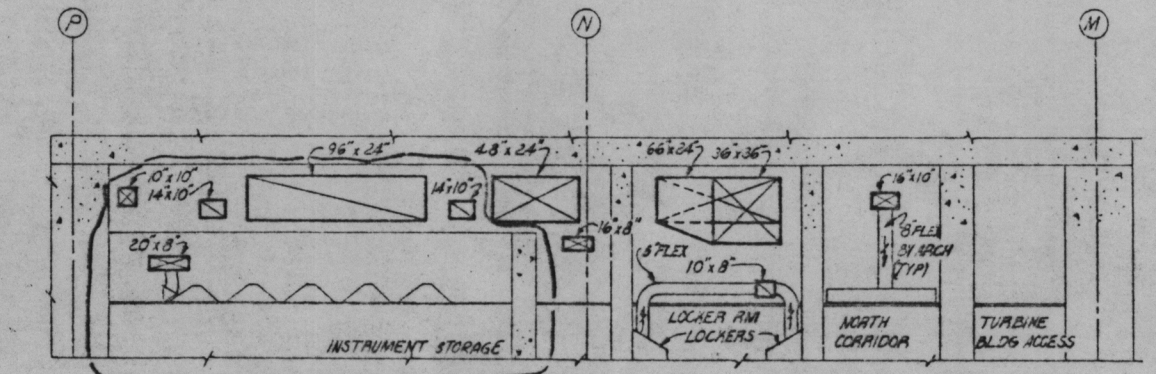

SECTION BB-BB SHEET 6 ECN 546

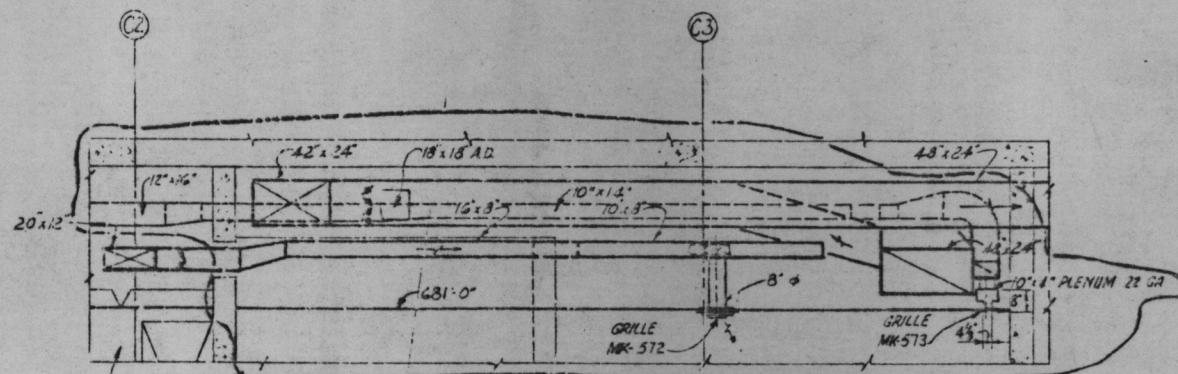

SECTION DB-D8 SHEET 6 ECN 546

PRC  
APERTURE  
CARD

8209080003

Docket # 50-438/439  
Control # 8209080002  
Date 8/23/82 of Document  
REGULATORY DOCKET FILE SCALE 1/4" = 1'-0"

PRINTED RECORD  
BY: [ ]  
PROJ: [ ]  
DWG: [ ]  
SIZE: [ ]

MC	
EE	
CC	
AD	
CD	
ED	
MD	
SD	
LD	

REV	NO.	DATE	DESIGN	DRAWN	CHECK	SUPPLY	ENGR	NSP	SUBMIT	REC'D	APPR
3											
2											
1											
DESIGN: M.E. BRIDGES DRAWN: J. H. HUMAN CHECK: W. G. SHEN SUPPLY: W. G. SHEN											
CONTROL BUILDING UNITS 1 & 2 MECHANICAL HEATING, VENTILATING, AND AIR CONDITIONING											
BELLEFONTE NUCLEAR PLANT TENNESSEE VALLEY AUTHORITY DIVISION OF ENGINEERING DESIGN											
SUBMITTED				RECOMMENDED				APPROVED			
[Signature]				[Signature]				[Signature]			
KNOXVILLE 6-10-76			88 M			3CW0930-00-08R3			RECORD DRAWING AS CONSTRUCTED		

**POOR ORIGINAL**