


This drawing and the design it covers are the property of BECHTEL. They are hereby loaned and on the borrower's express agreement that they will not be reproduced, copied, issued, exhibited, or used except in the limited way and private use permitted by any written consent given by the lender to the borrower.

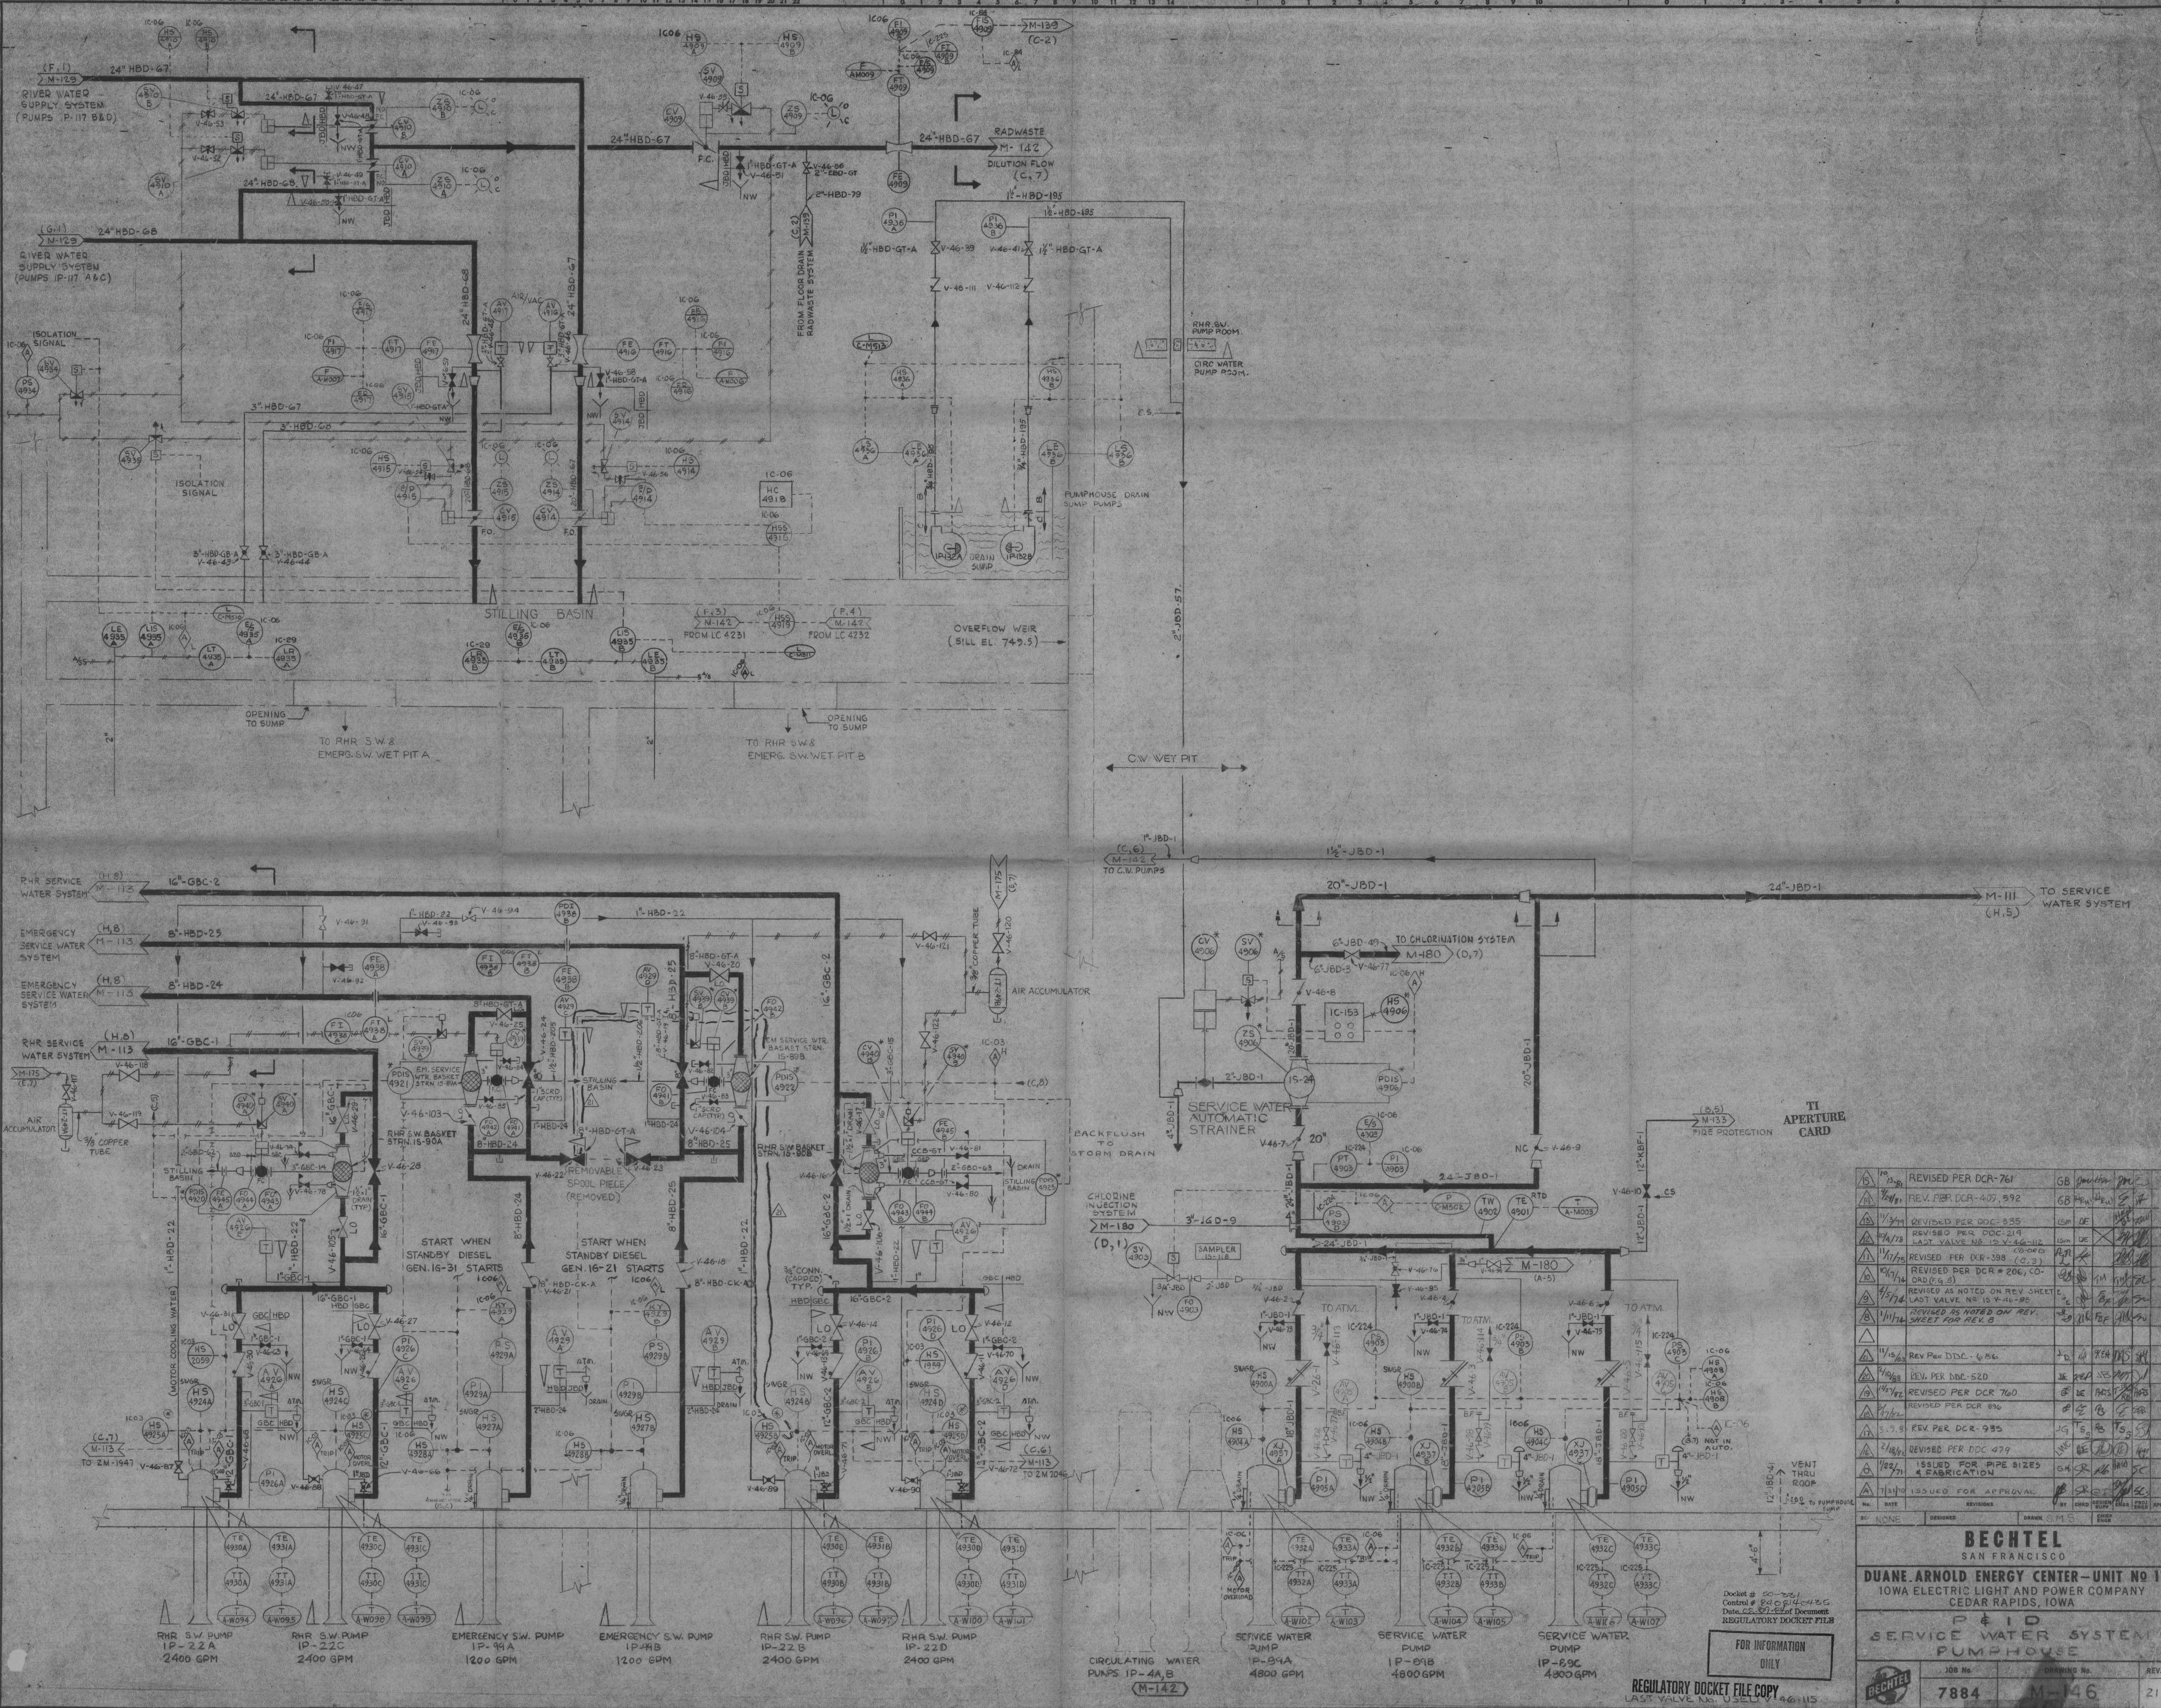

NO.	DATE	REVISIONS	BY	CHKD.	APPV.
1	12/10/78	REVISED PER DCR-761	GB
2	1/24/79	REV. PER DCR-407, 592	GB
3	1/31/79	REVISED PER DDC-935
4	1/24/79	REVISED PER DDC-219
5	1/17/79	REVISED PER DCR-398 (C.3)
6	1/14/79	REVISED PER DCR # 206, (C.2)
7	1/17/79	REVISED AS NOTED ON REV. SHEET
8	1/17/79	REVISED AS NOTED ON REV. SHEET
9	1/17/79	REVISED AS NOTED ON REV. SHEET
10	1/17/79	REV. PER DDC-475
11	1/17/79	REV. PER DDC-520
12	1/17/79	REVISED PER DCR 760
13	1/17/79	REVISED PER DCR 896
14	3/7/79	REV. PER DCR-935
15	2/18/79	REVISED PER DDC-479
16	1/27/79	ISSUED FOR PIPE SIZES FABRICATION
17	1/17/79	ISSUED FOR APPROVAL

BECHTEL
SAN FRANCISCO

DUANE ARNOLD ENERGY CENTER - UNIT NO 1
IOWA ELECTRIC LIGHT AND POWER COMPANY
CEDAR RAPIDS, IOWA

P&ID
SERVICE WATER SYSTEM
PUMPHOUSE

JOB No.	DRAWING No.	REV.
7884	M-46	21

REGULATORY DOCKET FILE COPY
LAST VALVE NO. USED 46-115