


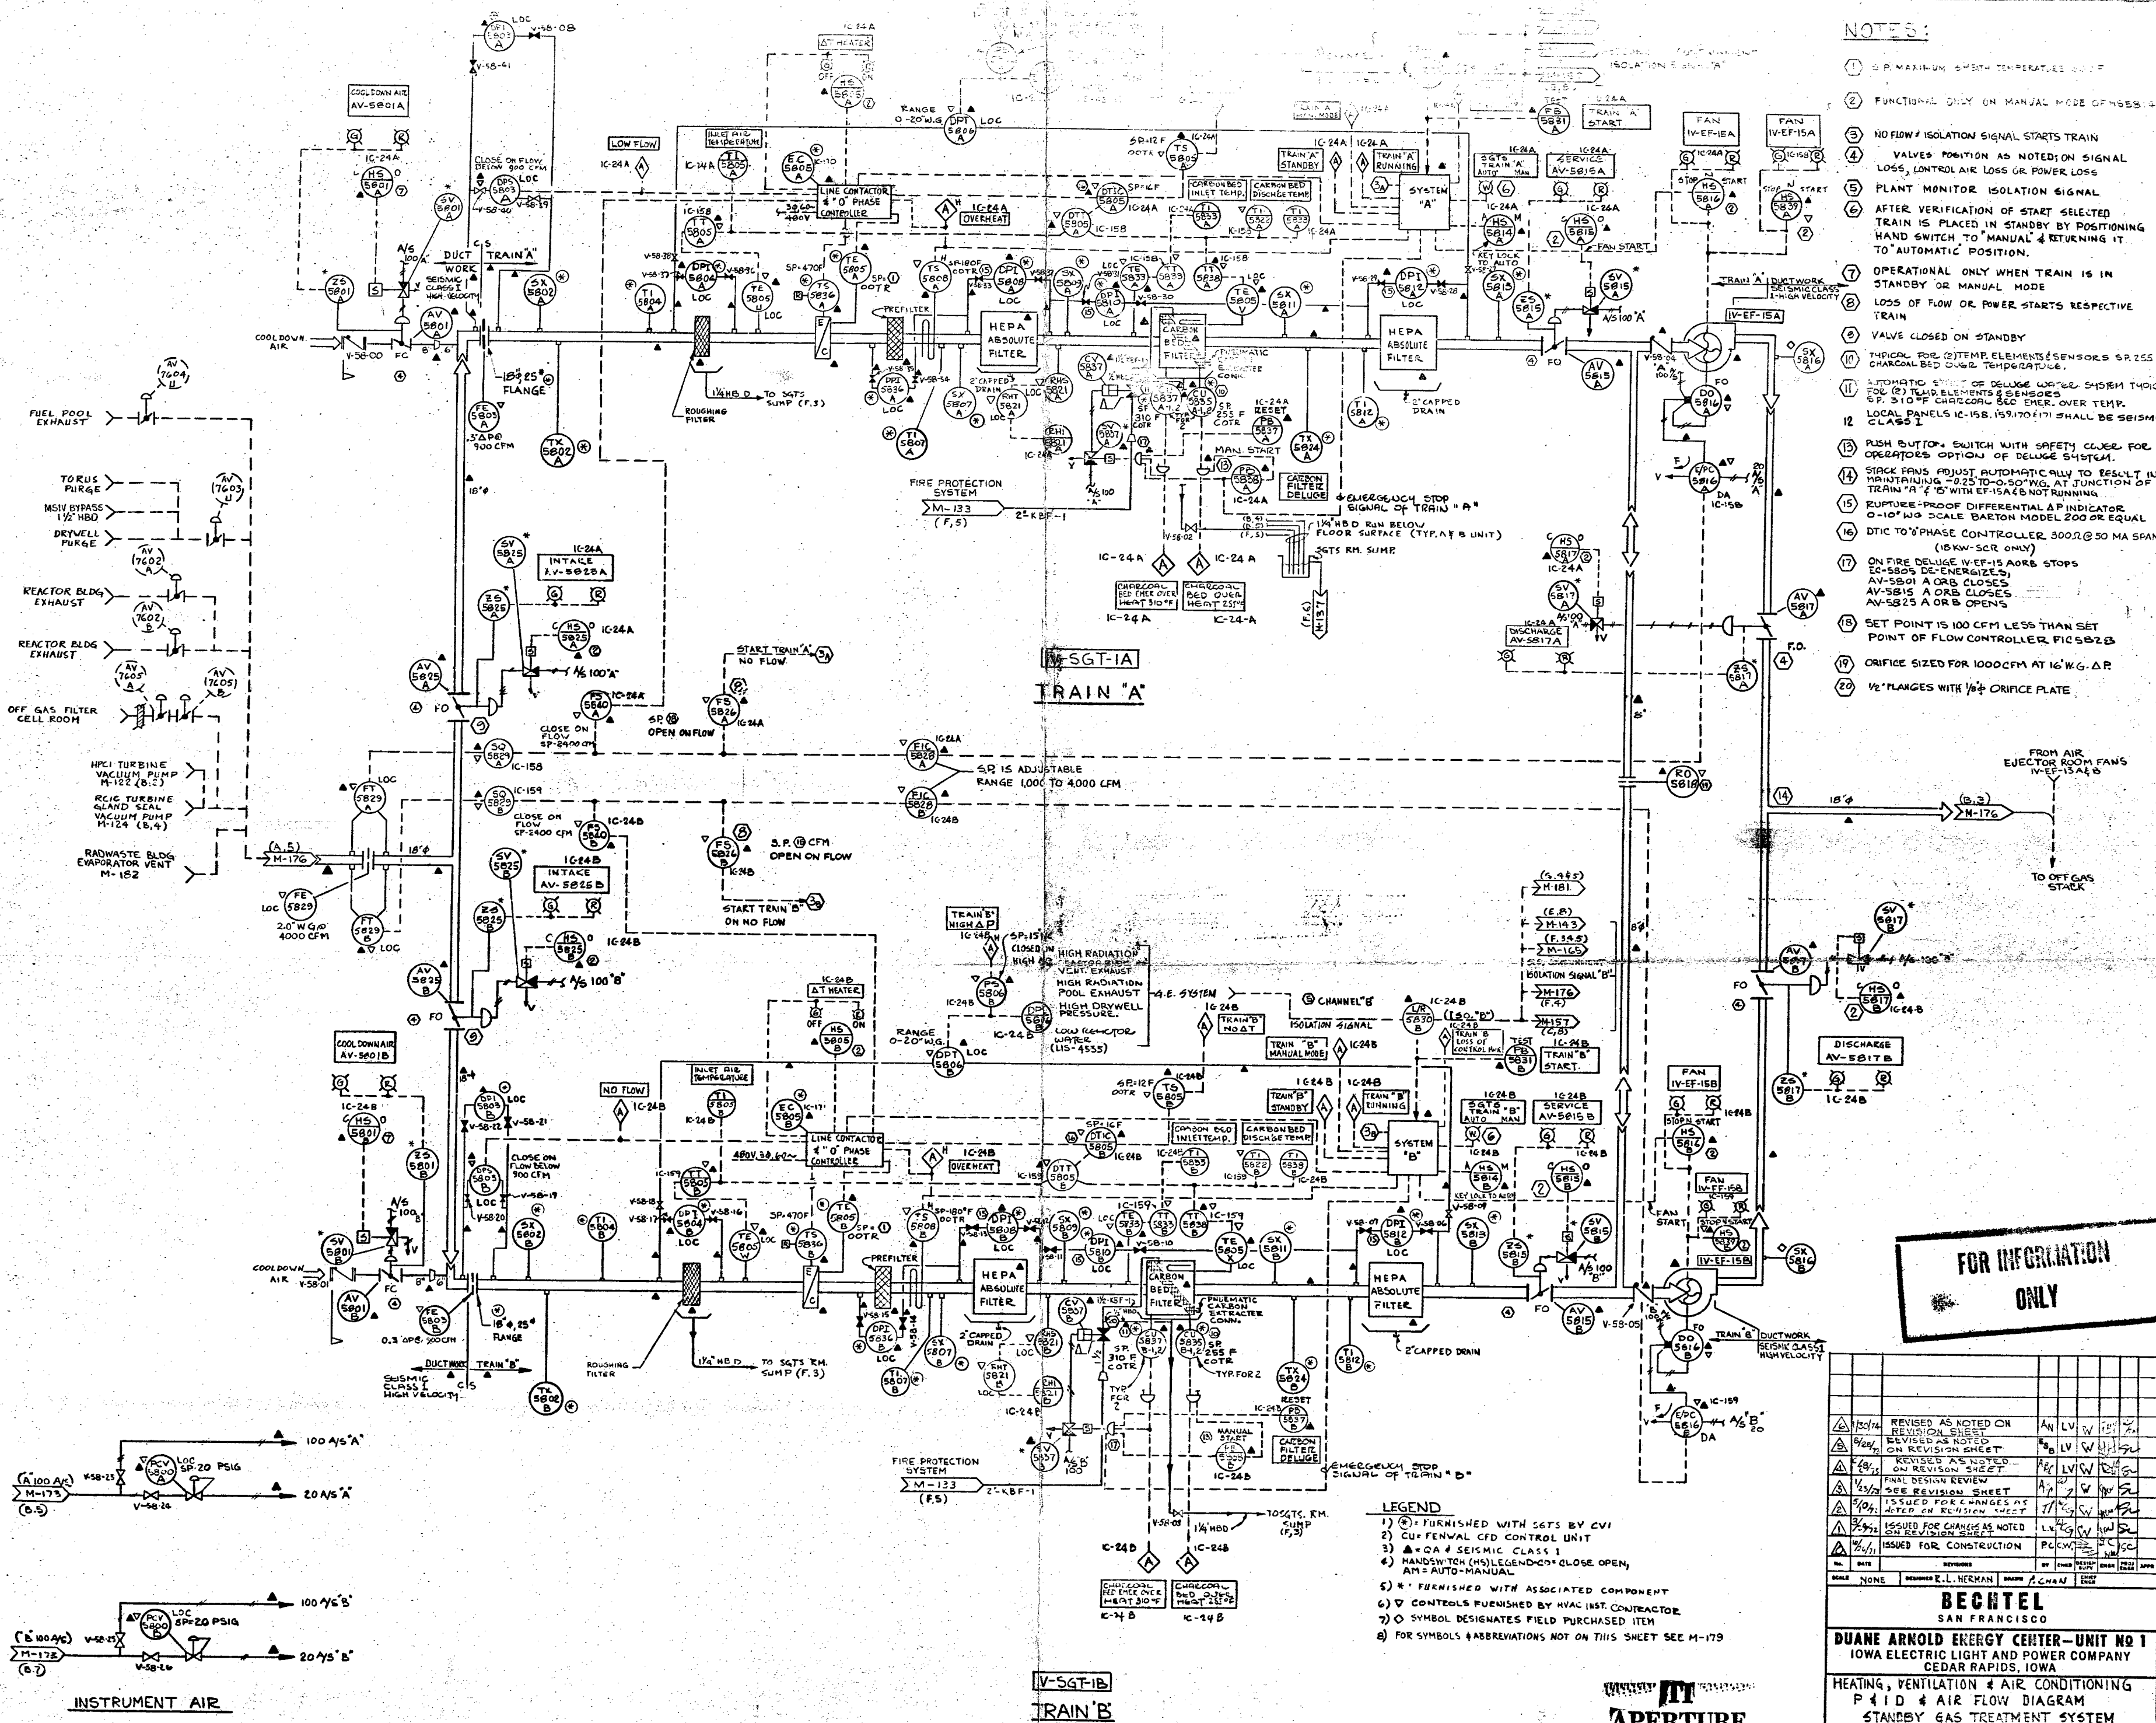

LAST Y-NO USED 58-41 (H-6)
LAST NO. USED 5840 AEB (E, G)

APERTURE CARD

BECHTEL
SAN FRANCISCO

DUANE ARNOLD ENERGY CENTER—UNIT NO.
IOWA ELECTRIC LIGHT AND POWER COMPANY
CEDAR RAPIDS, IOWA

HEATING, VENTILATION & AIR CONDITIONING
P & I D & AIR FLOW DIAGRAM
STANDBY GAS TREATMENT SYSTEM

HEATING, VENTILATION & AIR CONDITIONING
P & ID & AIR FLOW DIAGRAM
STANDBY GAS TREATMENT SYSTEM

	JGC No.	DRAWING No.
	7884	M-152

800 429 0777_{XA}