


I:\PROJECTS\PLANS\18002-Bell Bend Land Development\DESIGN\CD\404\MAP\_POST-DRN-6.dwg  
8/27/2011 1:28 PM  
PENNONI, INC.

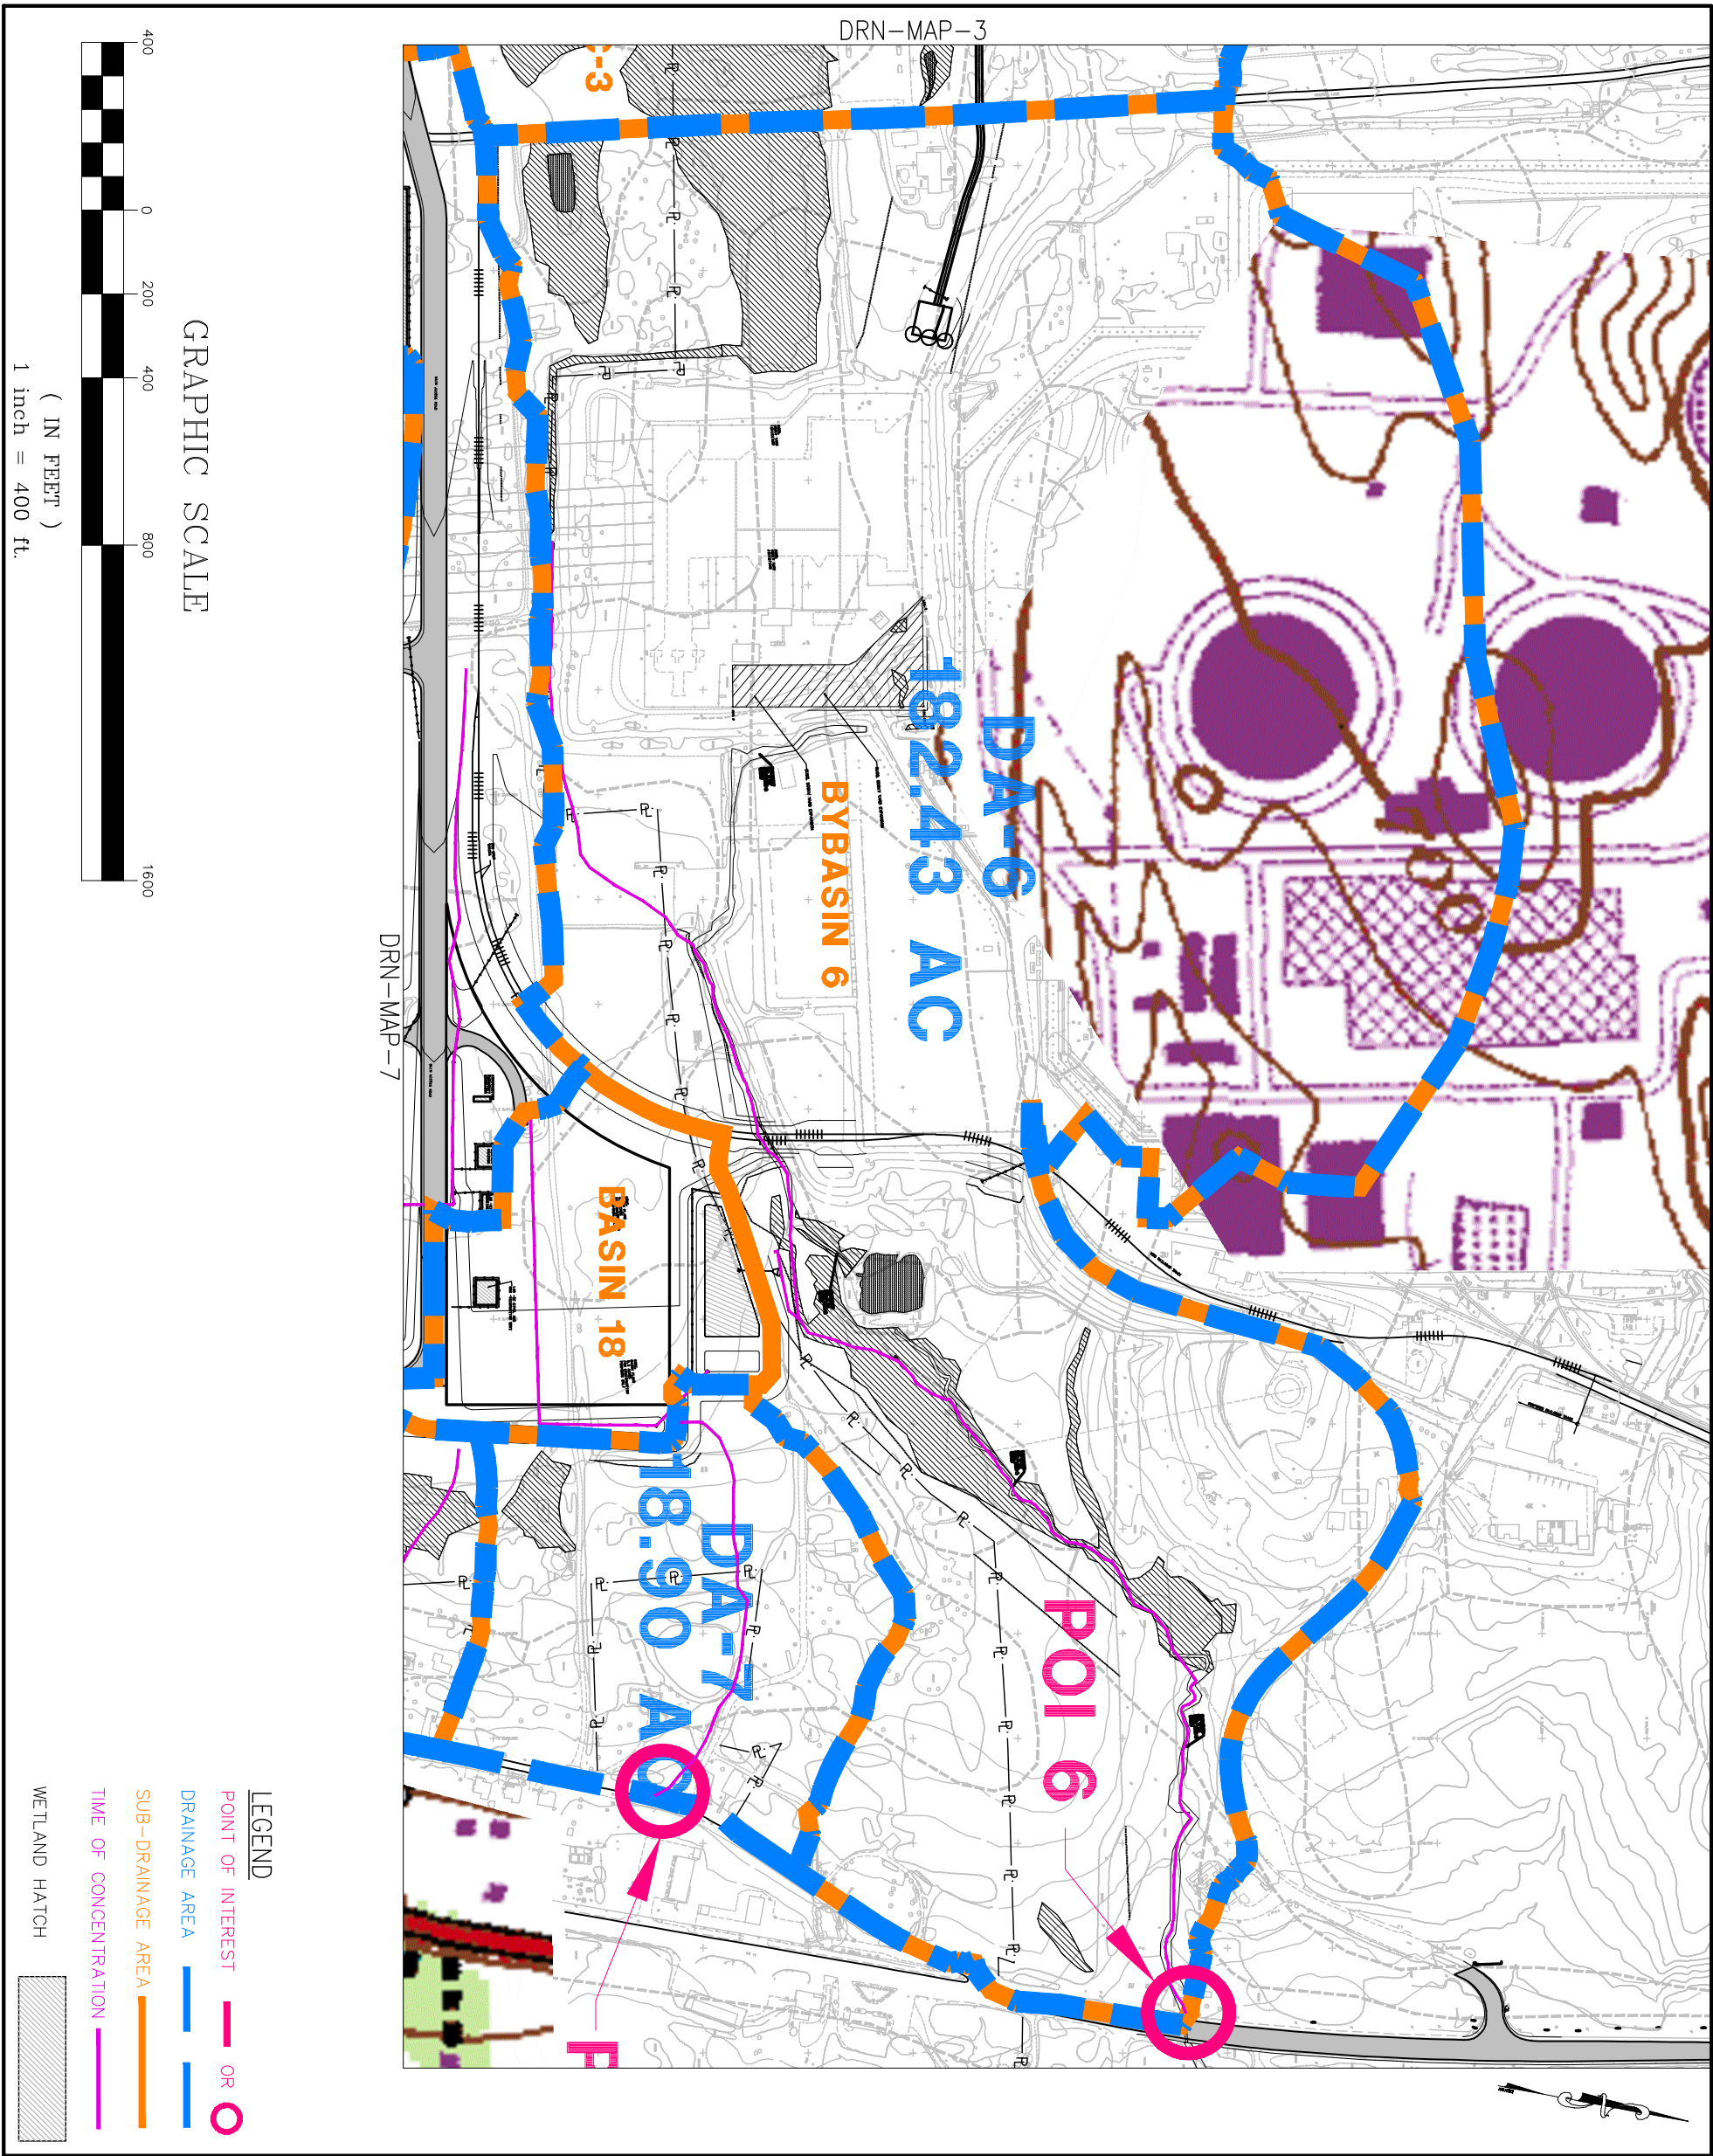

Pennoni Associates Inc.

100 N. Wilkes-Barre Boulevard  
Wilkes-Barre, PA 18702 (870) 824-2200

Engineers • Surveyors • Planners • Landscape Architects

|                                                                               |                         |  |
|-------------------------------------------------------------------------------|-------------------------|--|
| SHEET<br>1" = 400'<br>DRAWN BY<br>JAO<br>DATE<br>09/15/2011<br>PROJECT<br>LBS | PROJECT NO.<br>18002    |  |
|                                                                               | JOB NO.<br>SHEET 6 OF 9 |  |
|                                                                               | DRN<br>MAP<br>6         |  |

|                                |  |
|--------------------------------|--|
| BELL BEND NUCLEAR POWER PLANT  |  |
| SALEM TOWNSHIP, PENNSYLVANIA   |  |
| POST-DEVELOPMENT DRAINAGE AREA |  |
| MAP 6                          |  |
| PPL BELL BEND, LLC             |  |
| 38 BOWBOY LANE, SUITE 2        |  |
| BERWICK, PA 18603              |  |

|                                                                                                                                     |  |
|-------------------------------------------------------------------------------------------------------------------------------------|--|
| ALL DIMENSIONS MUST BE VERIFIED BY CONTRACTOR<br>AND OWNER MUST BE NOTIFIED OF ANY<br>DISCREPANCIES BEFORE PROCEEDING WITH THE WORK |  |
|                                                                                                                                     |  |

|         |     |           |                                                |     |
|---------|-----|-----------|------------------------------------------------|-----|
| 9/15/11 |     | 1         | EXCESS EARTHWORK REDUCTION<br>AND LCO COMMENTS | LGB |
| DATE    | NO. | REVISIONS | BY                                             |     |

