














\\PENNONI\WORK\201002-2011 Land Development\VERNON\CA\CA06\SF Map 6.dwg  
Created: 9/15/2011

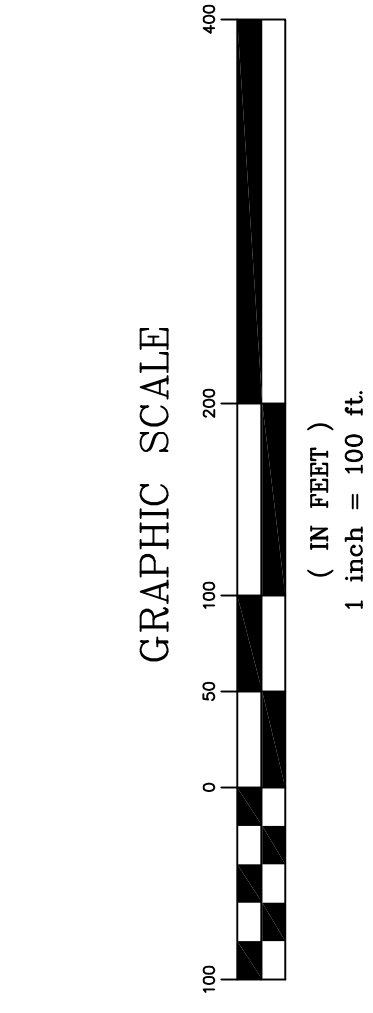

- LEGEND**
- EXISTING MAJOR CONTOUR LINE (10')
  - EXISTING MINOR CONTOUR LINE (2')
  - TEMPORARY PROPOSED CONTOUR LINE (10')
  - TEMPORARY PROPOSED CONTOUR LINE (2')
  - MAJOR CONTOUR LINE (10')
  - MINOR CONTOUR LINE (2')
  - 18" SILT FENCE
  - 30" SILT FENCE
  - SUPER SILT FENCE
  - FLOW PATH USED TO DETERMINE LENGTH AND SLOPE TO SILT FENCE

- NOTES:**
- LENGTHS AND SLOPES HAVE NOT BEEN CALCULATED FOR ALL SILT FENCE SECTIONS.
  - BARRIERS THAT HAVE NOT BEEN CALCULATED ARE SIMILAR IN SLOPE/LENGTH TO ONES THAT HAVE BEEN CALCULATED AND HAVE BEEN PLACED ACCORDINGLY.

LENGTHS AND SLOPES FOR TYPICAL BARRIER 11, 20, 21, 24 AND 25

Pennoni Associates Inc.

100 N. Wilkes-Barre Boulevard  
Wilkes-Barre, PA 18702 (570) 824-2200

Engineers • Surveyors • Planners • Landscape Architects

SCALE 1"=100'	DRAWING NO. SF MAP06
DRAWN BY WCK	
DATE 9/15/2011	
APPROVED JFM	


JOB NO. PPLS0902	
SHEET 6 OF 9	

ALL DOCUMENTS PREPARED BY PENNONI ASSOCIATES ARE INSTRUMENTS OF SERVICE IN RESPECT OF THE PROJECT. THEY ARE NOT INTENDED OR REPRESENTED TO BE SUITABLE FOR REUSE BY OTHERS OR EXTENSIONS OF THE PROJECT OR ON ANY OTHER PROJECT. ANY REUSE WITHOUT WRITTEN PERMISSION OR ADAPTATION BY PENNONI ASSOCIATES FOR THE SPECIFIC PURPOSE INTENDED WILL BE AT OWNERS SOLE RISK AND WITHOUT LIABILITY OR LEGAL EXPOSURE TO PENNONI ASSOCIATES; AND OWNER SHALL INDEMNIFY AND HOLD HARMLESS PENNONI ASSOCIATES FROM ALL CLAIMS, DAMAGES, LOSSES AND EXPENSES ARISING OUT OF OR RESULTING THEREFROM.

**BELL BEND NUCLEAR POWER PLANT**  
SALEM TOWNSHIP, PENNSYLVANIA  
**SILT FENCE MAP**  
**PPL BELL BEND, LLC**  
36 BOMBAY LANE, SUITE 2  
BERWICK, PA 18603

ALL DIMENSIONS MUST BE VERIFIED BY CONTRACTOR AND OWNER. ANY DISCREPANCIES MUST BE REPORTED TO THE ENGINEER BEFORE PROCEEDING WITH THE WORK.

DATE	NO.	REVISIONS	BY

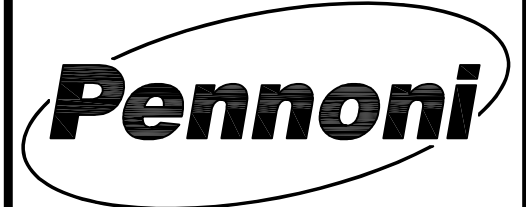




\\PENNONI\PROJECTS\2010\02-Shell Island Land Development\DESIGN\CA\Map05.dwg Map 5.dwg  
Created: 9/15/2011 10:00 AM  
User: jfm



- LEGEND**
- EXISTING MAJOR CONTOUR LINE (10')
  - EXISTING MINOR CONTOUR LINE (2')
  - TEMPORARY PROPOSED CONTOUR LINE (10')
  - TEMPORARY PROPOSED CONTOUR LINE (2')
  - MAJOR CONTOUR LINE (10')
  - MINOR CONTOUR LINE (2')
  - 18" SILT FENCE
  - 30" SILT FENCE
  - SUPER SILT FENCE
  - FLOW PATH USED TO DETERMINE LENGTH AND SLOPE TO SILT FENCE

- NOTES:**
- LENGTHS AND SLOPES HAVE NOT BEEN CALCULATED FOR ALL SILT FENCE SECTIONS.
  - BARRIERS THAT HAVE NOT BEEN CALCULATED ARE SIMILAR IN SLOPE/LENGTH TO ONES THAT HAVE BEEN CALCULATED AND HAVE BEEN PLACED ACCORDINGLY.

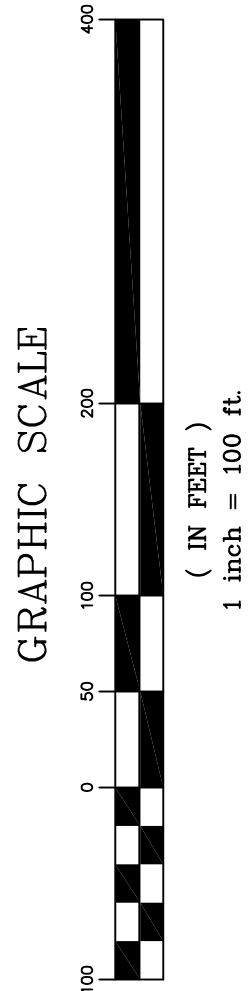

LENGTHS AND SLOPES FOR TYPICAL BARRIER 7, 18 AND 19



Pennoni Associates Inc.

100 N. Wilkes-Barre Boulevard  
Wilkes-Barre, PA 18702 (570) 824-2200

Engineers • Surveyors • Planners • Landscape Architects

SCALE 1"=100'	DRAWING NO. <b>SF MAP05</b>
DRAWN BY WCK	
DATE 9/15/2011	
APPROVED JFM	

JOB NO. PPLS0902	BY
SHEET 5 OF 9	REVISIONS


**BELL BEND NUCLEAR POWER PLANT**  
SILT FENCE MAP  
PPL BELL BEND, LLC  
38 BOMBAY LANE, SUITE 2  
BERWICK, PA 18603  
SALEM TOWNSHIP, PENNSYLVANIA

ALL DIMENSIONS MUST BE VERIFIED BY CONTRACTOR  
AND OWNER. NO DIMENSIONS SHALL BE  
CONSIDERED FINAL UNTIL THEY HAVE BEEN  
APPROVED BY THE ENGINEER. DISCREPANCIES  
MUST BE CORRECTED BEFORE PROCEEDING WITH THE WORK.






\\PENNONI\PROJECTS\2010\2010-0002-001 Land Development\DESIGN\DWG\SF Map 4.dwg  
9/15/2011 10:00 AM  
JFM

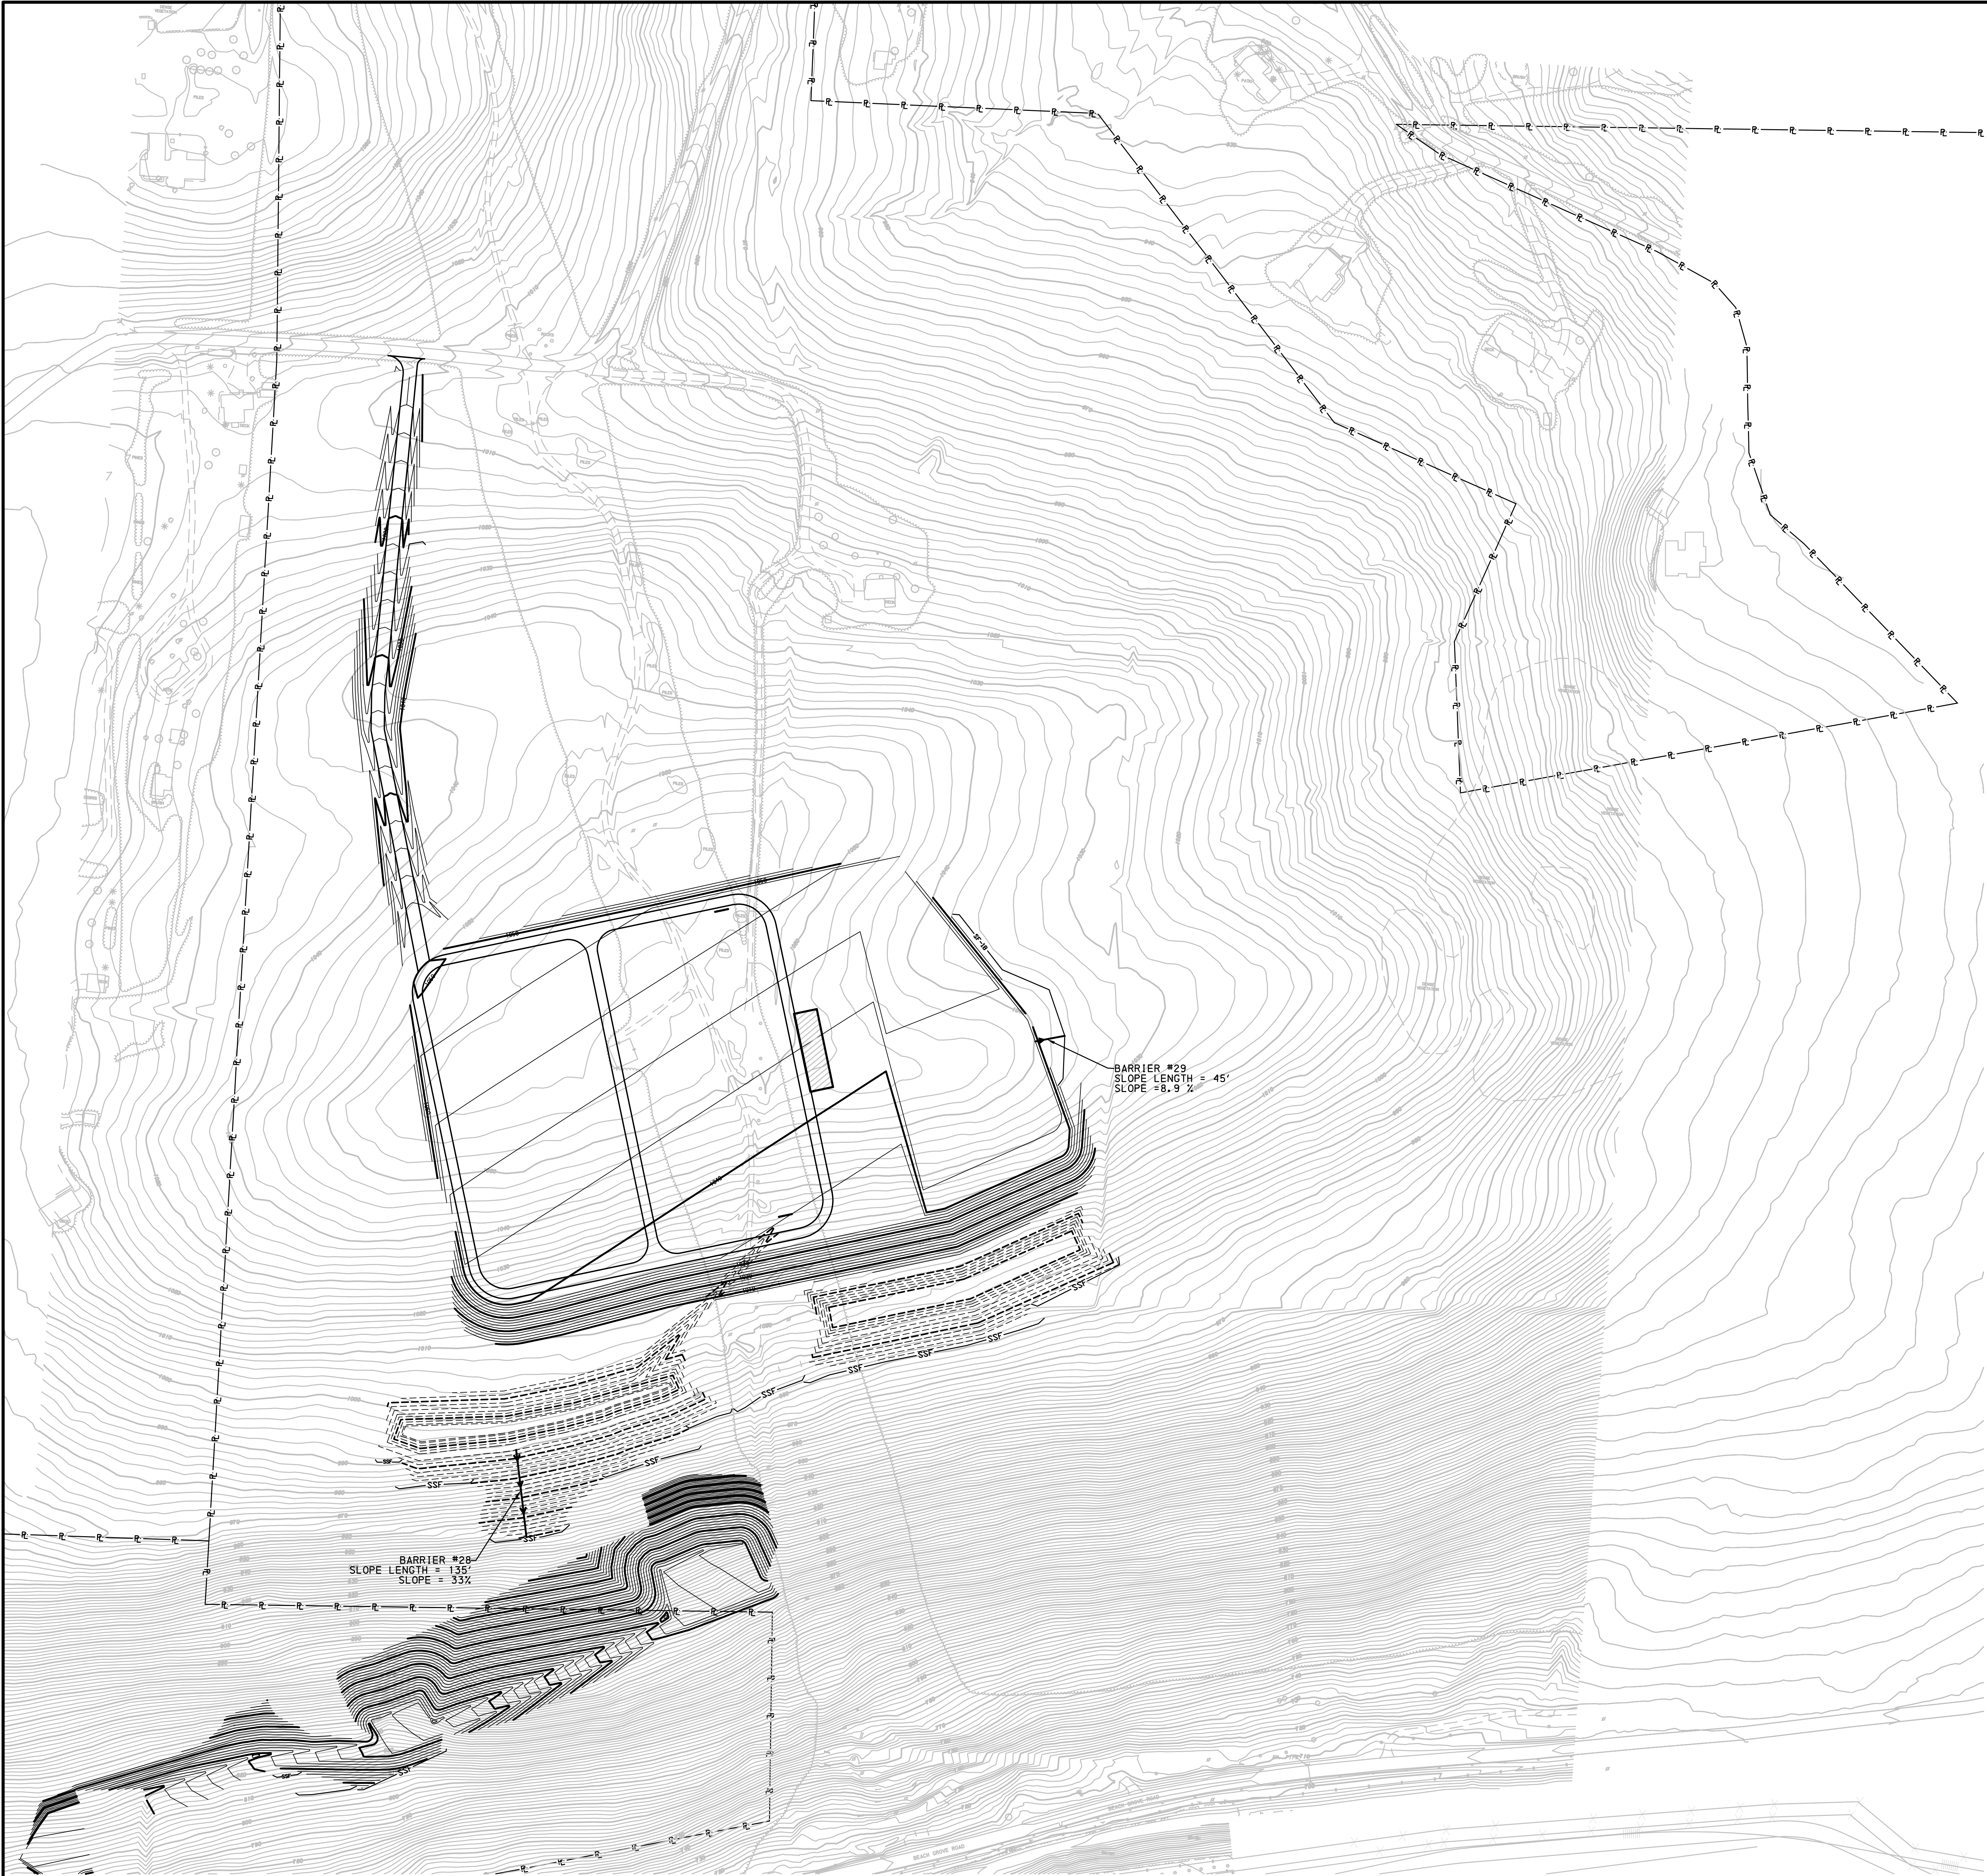

LENGTHS AND SLOPES FOR TYPICAL BARRIER 28 AND 29

- LEGEND**
- 700— EXISTING MAJOR CONTOUR LINE (10')
  - - -700- - - EXISTING MINOR CONTOUR LINE (2')
  - - -700- - - TEMPORARY PROPOSED CONTOUR LINE (10')
  - - -700- - - TEMPORARY PROPOSED CONTOUR LINE (2')
  - 700— MAJOR CONTOUR LINE (10')
  - - - MINOR CONTOUR LINE (2')
  - SF-18— 18" SILT FENCE
  - SF-30— 30" SILT FENCE
  - SSF— SUPER SILT FENCE
  - FLOW PATH USED TO DETERMINE LENGTH AND SLOPE TO SILT FENCE
- NOTES:**
1. LENGTHS AND SLOPES HAVE NOT BEEN CALCULATED FOR ALL SILT FENCE SECTIONS.
  2. BARRIERS THAT HAVE NOT BEEN CALCULATED ARE SIMILAR IN SLOPE/LENGTH TO ONES THAT HAVE BEEN CALCULATED AND HAVE BEEN PLACED ACCORDINGLY.

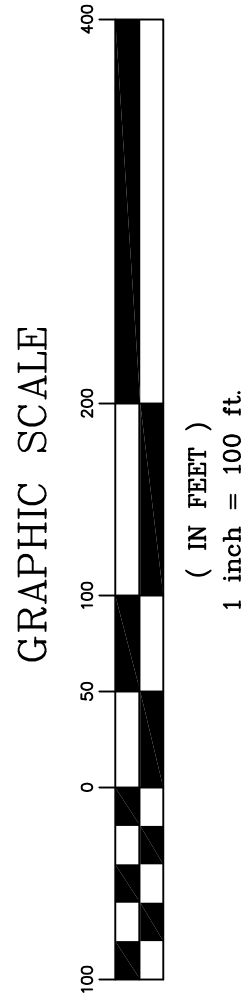

Pennoni Associates Inc.

100 N. Wilkes-Barre Boulevard  
Wilkes-Barre, PA 18702 (570) 824-2200

Engineers • Surveyors • Planners • Landscape Architects

SCALE 1"=100'	DRAWING NO. SF MAP04
DRAWN BY WCK	
DATE 9/15/2011	
APPROVED JFM	


JOB NO. PPLS0902	
SHEET 4 OF 9	

ALL DOCUMENTS PREPARED BY PENNONI ASSOCIATES ARE INSTRUMENTS OF SERVICE IN RESPECT OF THE PROJECT. THEY ARE NOT INTENDED OR REPRESENTED TO BE SUITABLE FOR REUSE BY OTHERS OR FOR EXTENSIONS OF THE PROJECT OR ON ANY OTHER PROJECT. ANY REUSE WITHOUT WRITTEN PERMISSION OR ADAPTATION BY PENNONI ASSOCIATES FOR THE SPECIFIC PURPOSE INTENDED WILL BE AT OWNERS RISK AND WITHOUT LIABILITY OR LEGAL EXPOSURE TO PENNONI ASSOCIATES. AND OWNER SHALL INDEMNIFY AND HOLD HARMLESS PENNONI ASSOCIATES FROM ALL CLAIMS, DAMAGES, LOSSES AND EXPENSES ARISING OUT OF OR RESULTING THEREFROM.

BELL BEND NUCLEAR POWER PLANT  
SILT FENCE MAP  
PPL BELL BEND, LLC  
38 BOMBAY LANE, SUITE 2  
BERWICK, PA 18603  
SALEM TOWNSHIP, PENNSYLVANIA

ALL DIMENSIONS MUST BE VERIFIED BY CONTRACTOR AND OWNER. ANY DISCREPANCIES MUST BE RESOLVED BEFORE PROCEEDING WITH THE WORK.

DATE	NO.	REVISIONS	BY

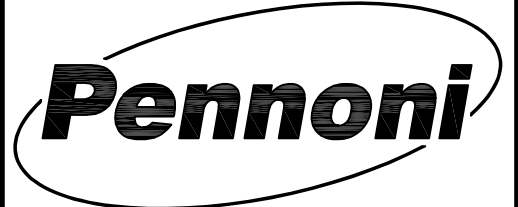








\\PENNONI\PROJECTS\2015\20150902-Bell Bend Land Development\DESIGN\SF MAP02.dwg Map 2.dwg  
9/15/2011  
WCK  
JFM

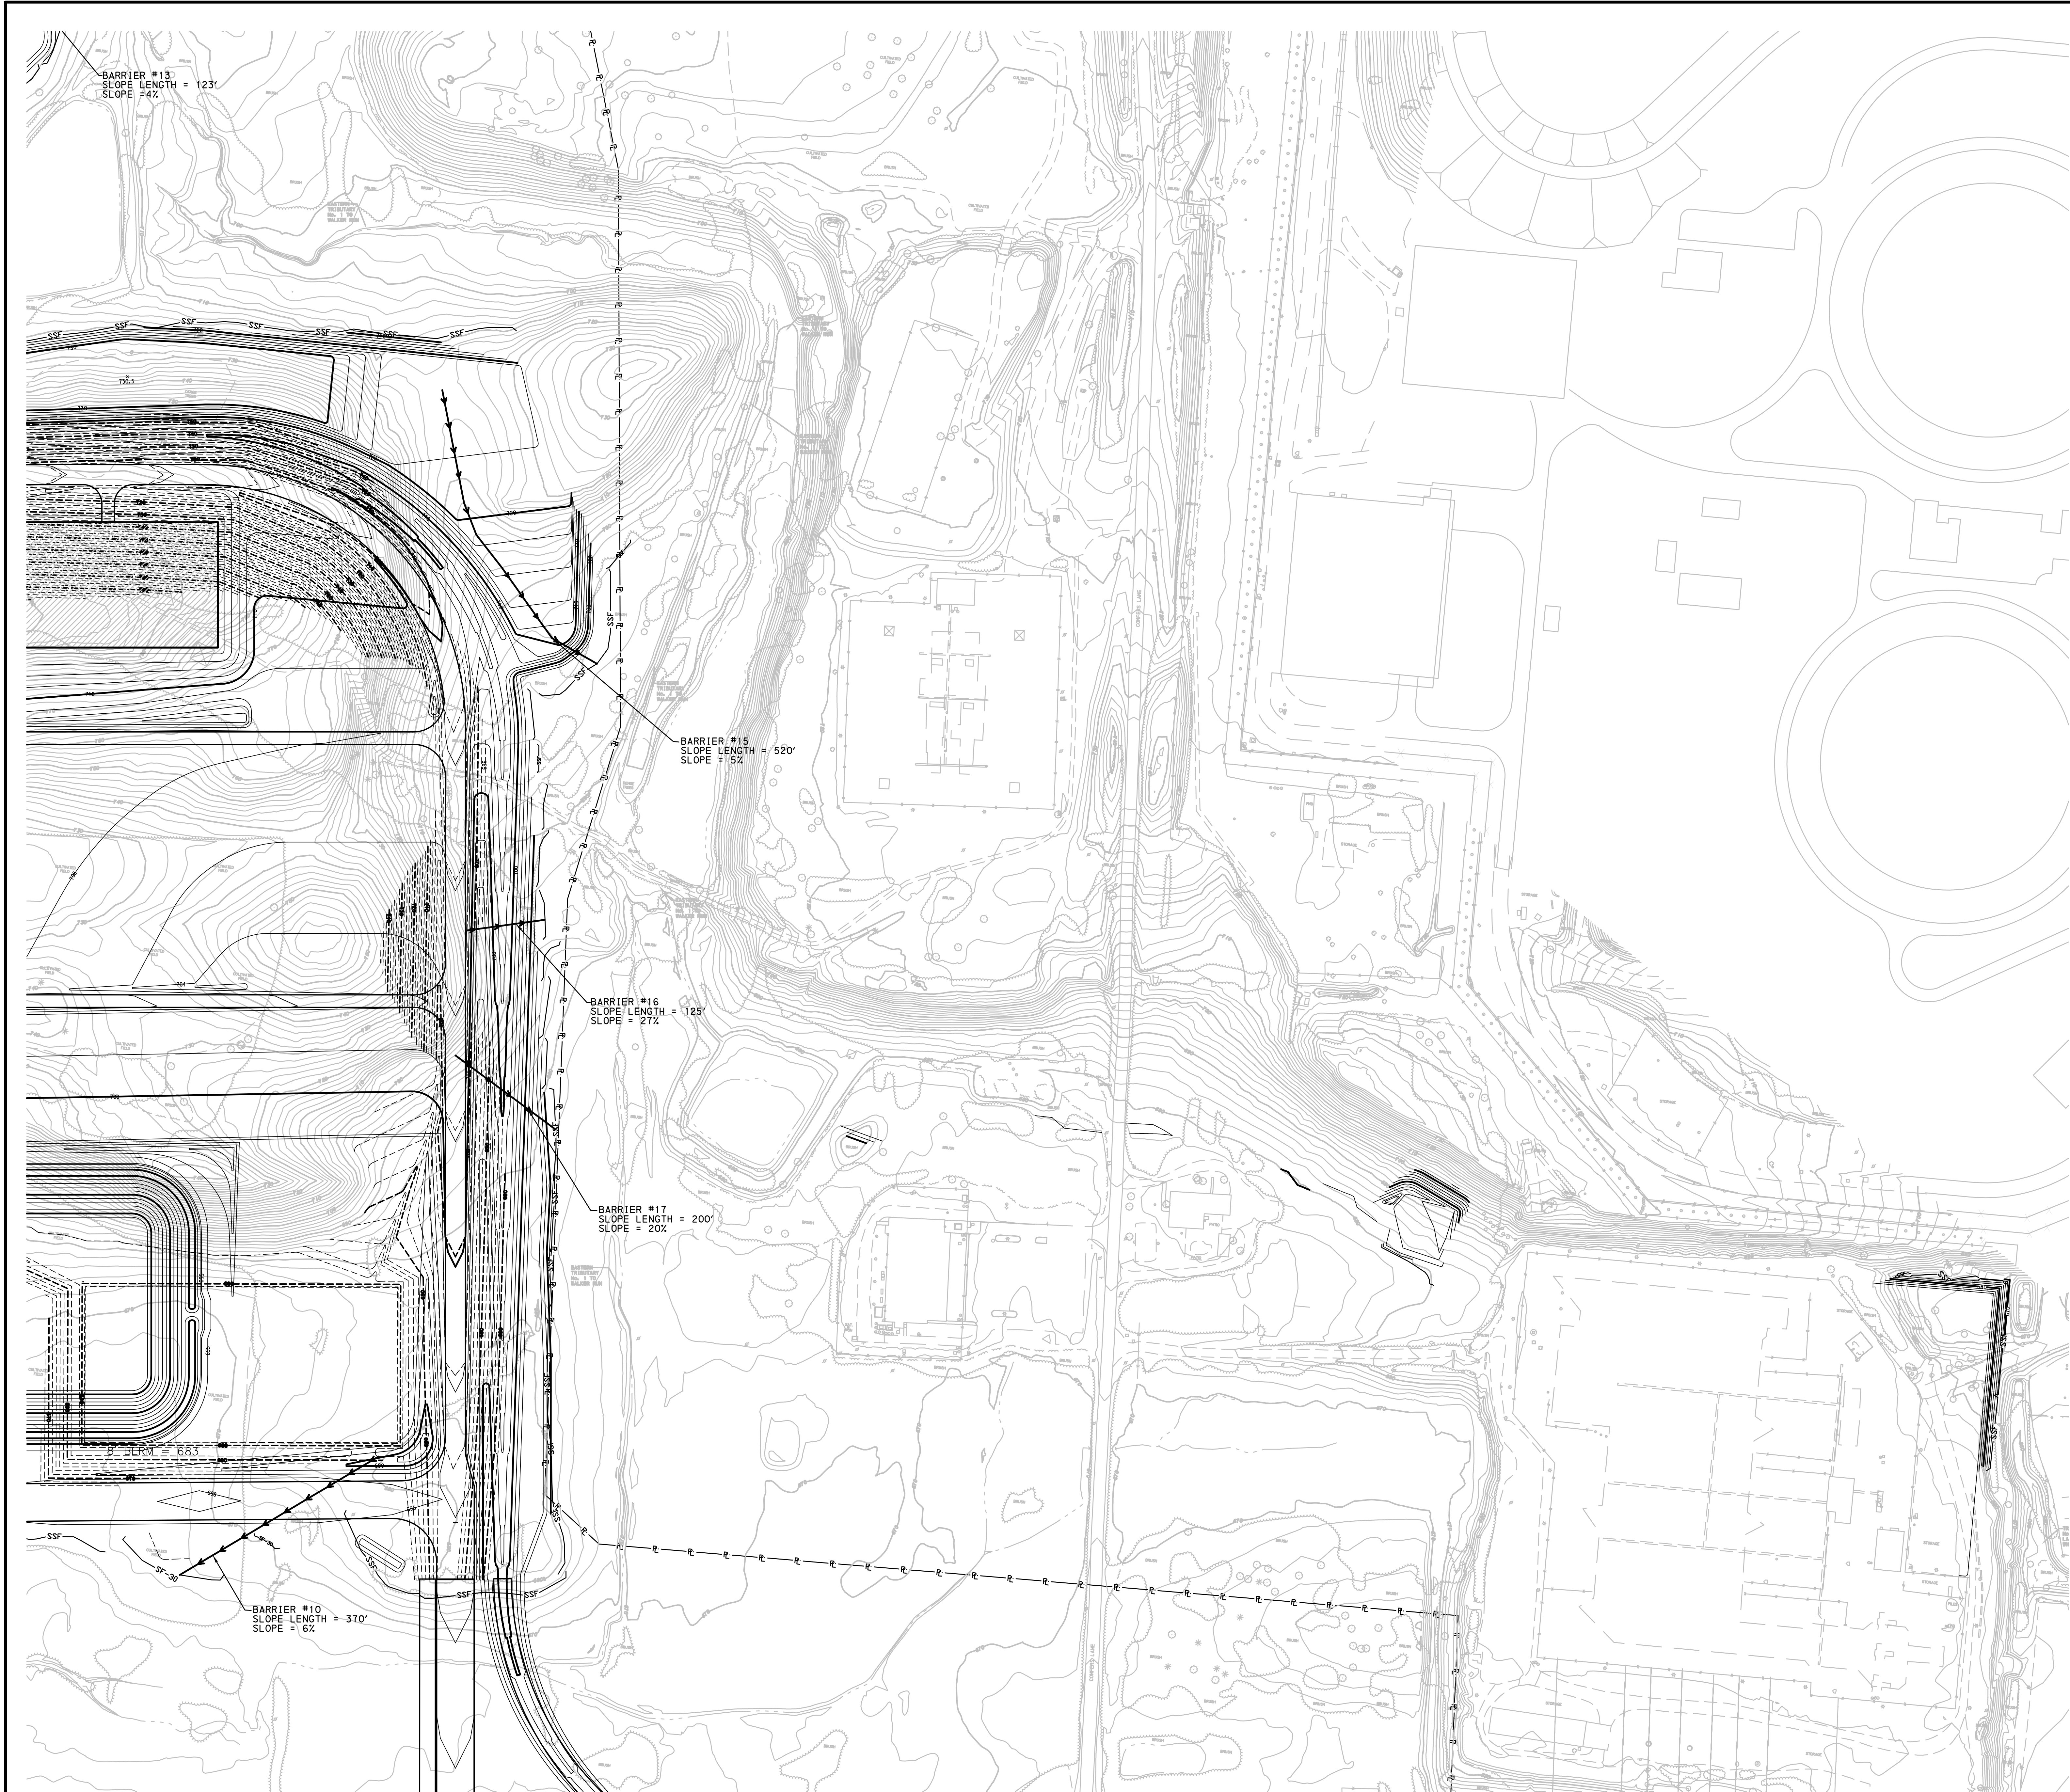

LENGTHS AND SLOPES FOR TYPICAL BARRIER 10, 15, 16, AND 17

**LEGEND**

—700— EXISTING MAJOR CONTOUR LINE (10')  
- - -700- - - EXISTING MINOR CONTOUR LINE (2')  
- - -700- - - TEMPORARY PROPOSED CONTOUR LINE (10')  
- - -700- - - TEMPORARY PROPOSED CONTOUR LINE (2')  
—700— MAJOR CONTOUR LINE (10')  
- - -700- - - MINOR CONTOUR LINE (2')


—SF-18— 18" SILT FENCE  
—SF-30— 30" SILT FENCE  
—SSF— SUPER SILT FENCE

→ FLOW PATH USED TO DETERMINE LENGTH AND SLOPE TO SILT FENCE

**NOTES:**

1. LENGTHS AND SLOPES HAVE NOT BEEN CALCULATED FOR ALL SILT FENCE SECTIONS.

2. BARRIERS THAT HAVE NOT BEEN CALCULATED ARE SIMILAR IN SLOPE/LENGTH TO ONES THAT HAVE BEEN CALCULATED AND HAVE BEEN PLACED ACCORDINGLY.

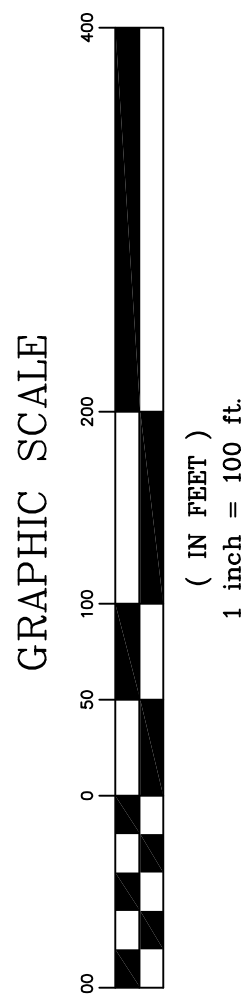

Pennoni Associates Inc.

100 N. Wilkes-Barre Boulevard  
Wilkes-Barre, PA 18702 (570) 824-2200

Engineers • Surveyors • Planners • Landscape Architects

SCALE 1"=100'	DRAWING NO. SF MAP02
DRAWN BY WCK	
DATE 9/15/2011	
APPROVED JFM	

JOB NO. PPLS0902
SHEET 2 OF 9

BELL BEND NUCLEAR POWER PLANT SILT FENCE MAP PPL BELL BEND, LLC 38 BOMBAY LANE, SUITE 2 BERWICK, PA 18603
-----------------------------------------------------------------------------------------------------------------------


ALL DIMENSIONS MUST BE VERIFIED BY CONTRACTOR ASSUMING NO DISCREPANCIES DISCREPANCIES MUST BE NOTED & CORRECTED BEFORE PROCEEDING WITH THE WORK
----------------------------------------------------------------------------------------------------------------------------------------------------------

DATE	NO.	REVISIONS	BY
------	-----	-----------	----






\\PENNONI\WORK\2010\2010 Bell Bend Nuclear Power Plant\GIS\Map01 Map 1.dwg  
Created: 9/15/2011

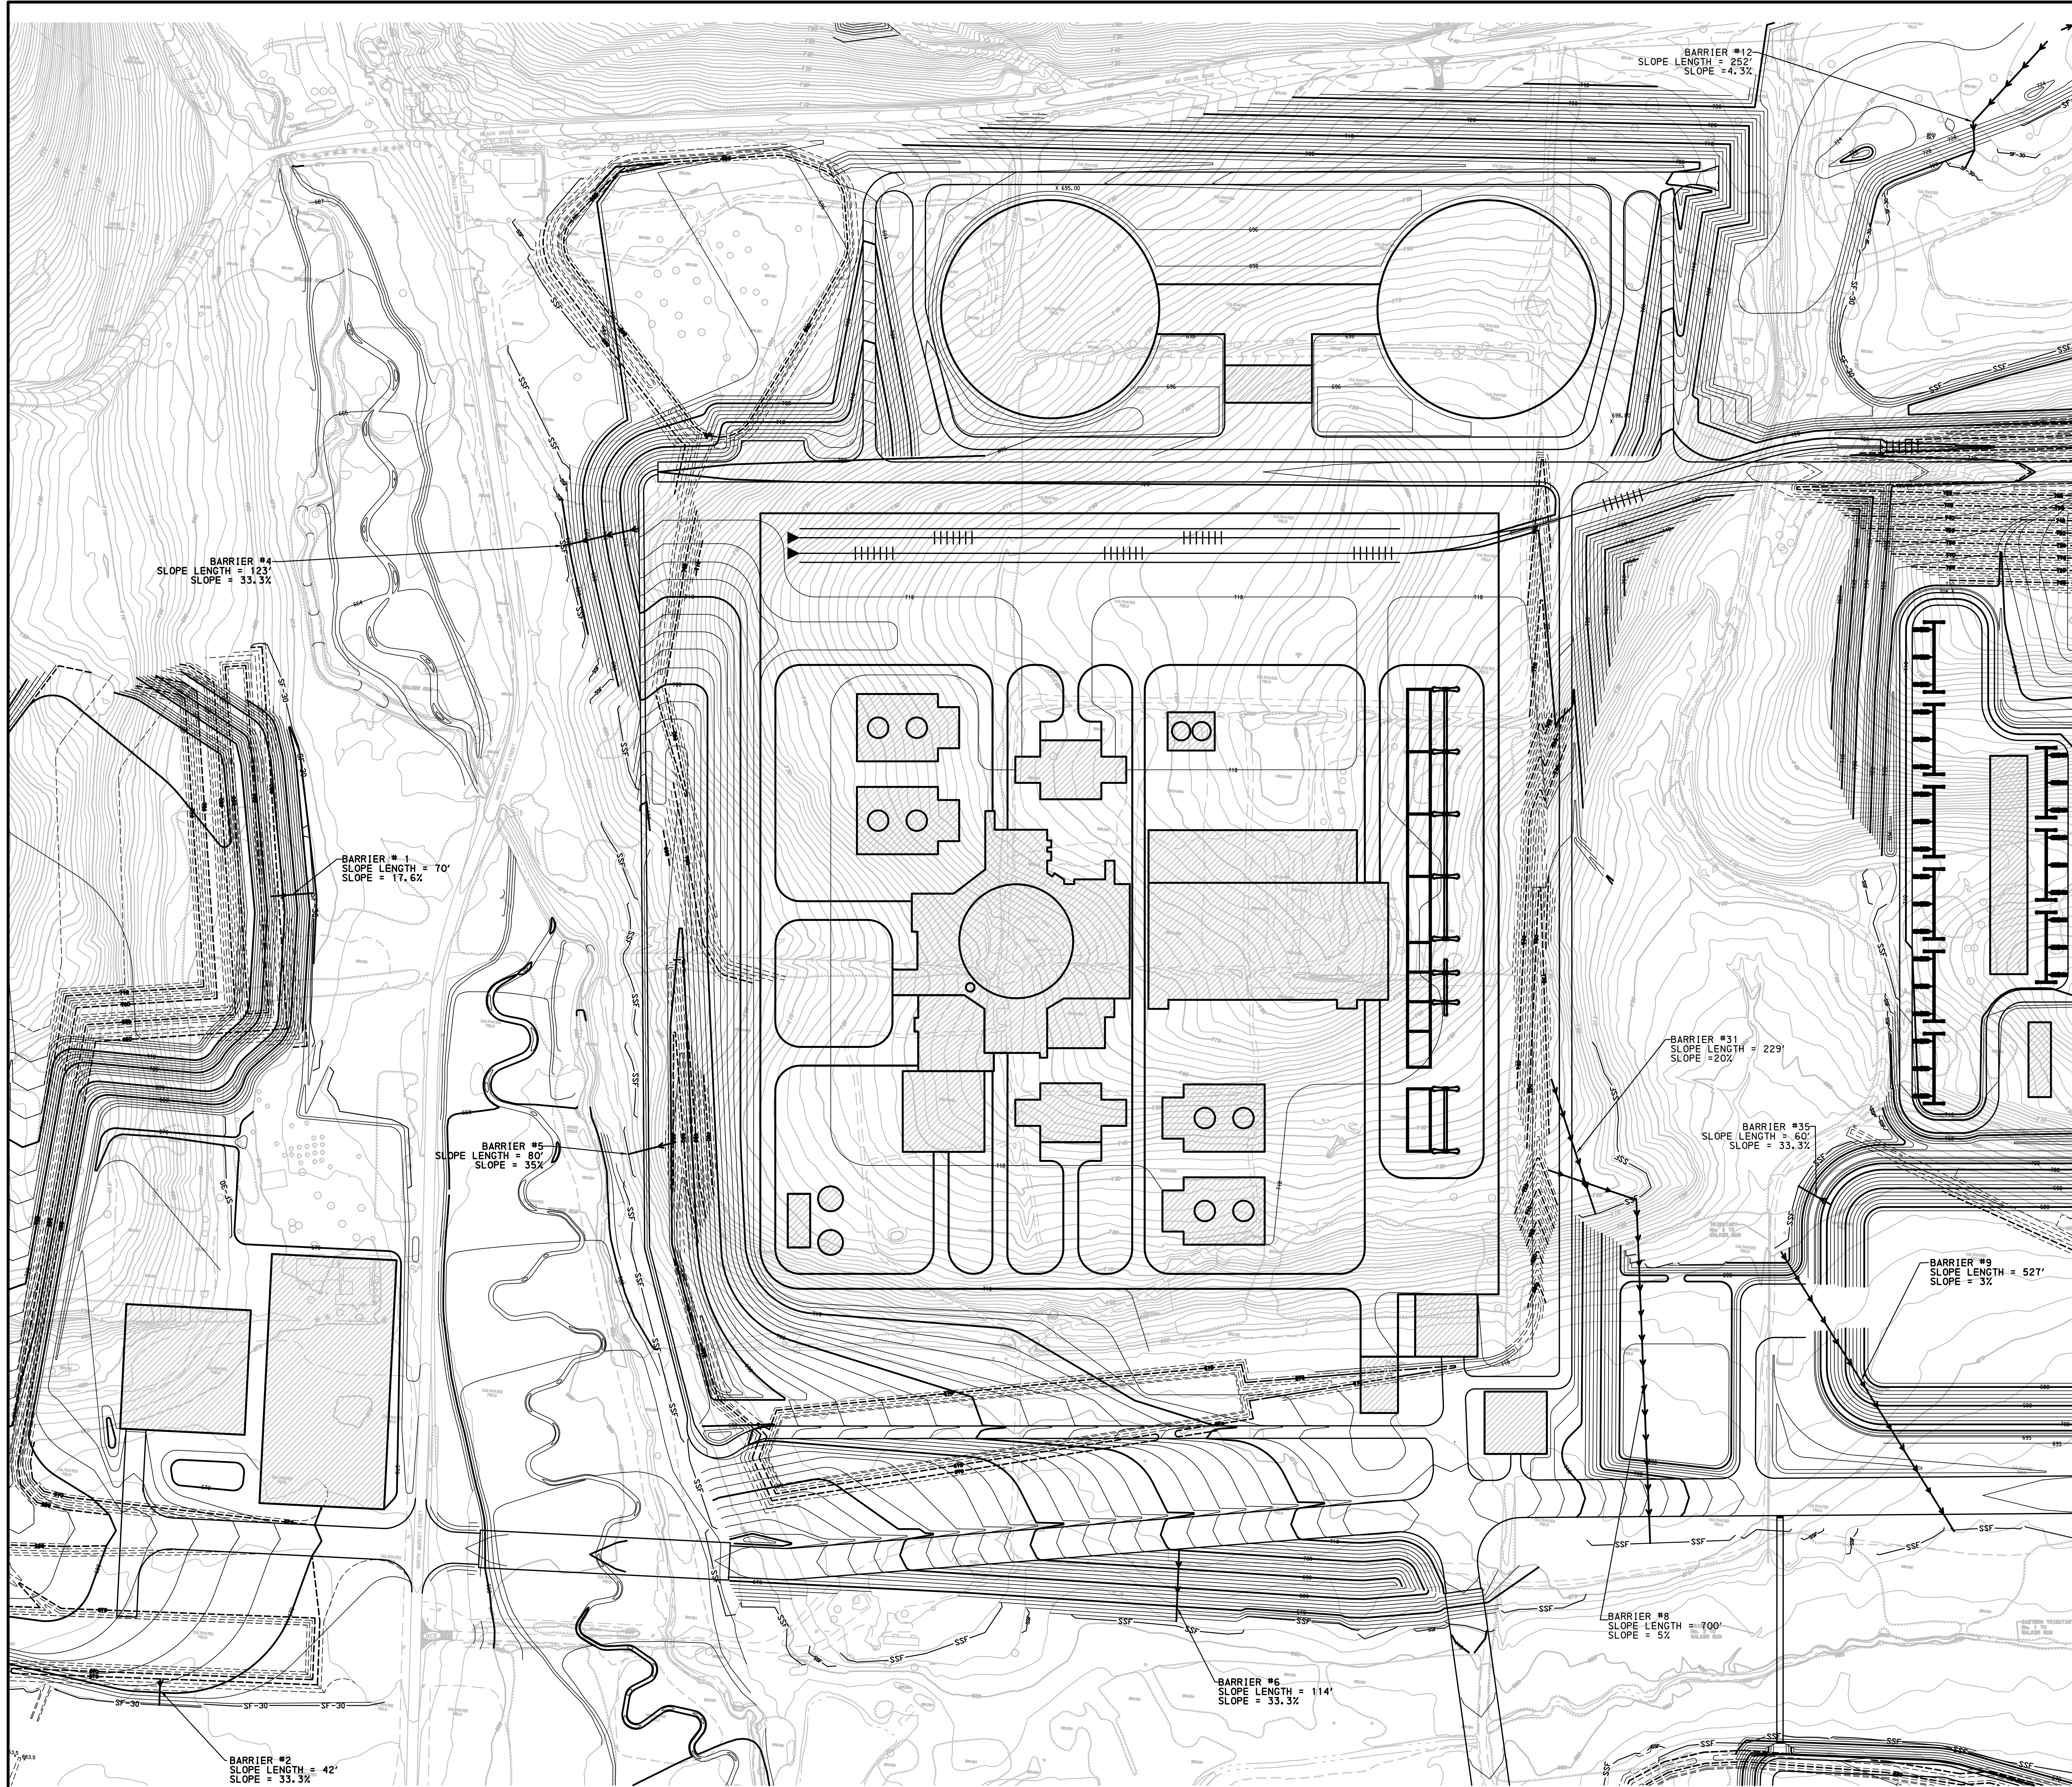

LENGTHS AND SLOPES FOR TYPICAL BARRIER 1, 2, 4, 5, 6, 8, 9, 12, 31, AND 35

- LEGEND**
- EXISTING MAJOR CONTOUR LINE (10')
  - EXISTING MINOR CONTOUR LINE (2')
  - TEMPORARY PROPOSED CONTOUR LINE (10')
  - TEMPORARY PROPOSED CONTOUR LINE (2')
  - MAJOR CONTOUR LINE (10')
  - MINOR CONTOUR LINE (2')
  - 18" SILT FENCE
  - 30" SILT FENCE
  - SUPER SILT FENCE
  - FLOW PATH USED TO DETERMINE LENGTH AND SLOPE TO SILT FENCE

- NOTES:**
- LENGTHS AND SLOPES HAVE NOT BEEN CALCULATED FOR ALL SILT FENCE SECTIONS.
  - BARRIERS THAT HAVE NOT BEEN CALCULATED ARE SIMILAR IN SLOPE LENGTH TO ONES THAT HAVE BEEN CALCULATED AND HAVE BEEN PLACED ACCORDINGLY.

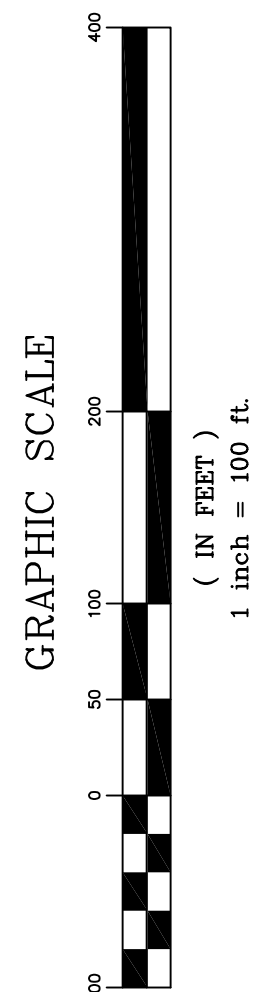

**Pennoni Associates Inc.**

100 N. Wilkes-Barre Boulevard  
Wilkes-Barre, PA 18702 (570) 824-2200

**Engineers • Surveyors • Planners • Landscape Architects**

SCALE 1"=100'	DRAWING NO. <b>SF MAP01</b>
DRAWN BY WCK	
DATE 9/15/2011	
APPROVED JFM	

**BELL BEND NUCLEAR POWER PLANT**

SILT FENCE MAP

**PPL BELL BEND, LLC**  
36 BOMBAY AVE, SUITE 2  
BERWICK, PA 18603

ALL DIMENSIONS MUST BE VERIFIED BY CONTRACTOR  
AND OWNER MUST BE NOTIFIED OF ANY  
DISCREPANCIES BEFORE PROCEEDING WITH THE WORK

DATE	NO.	REVISIONS	BY

