


\\PENNONI\PROJECTS\PA\090902-001 Bell Bend Land Development\VERSION\CS\ACAD\DWG\01.dwg
09/15/2011 11:11 AM
NKG
NKG

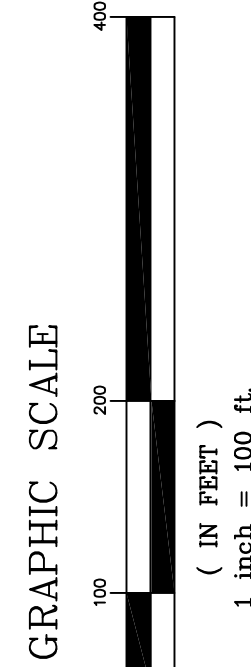

NORTH

Pennoni Associates Inc.

100 N. Wilkes-Barre Boulevard
Wilkes-Barre, PA 18702 (570) 824-2200


Engineers • Surveyors • Planners • Landscape Architects

SCALE 1"=100'	DRAWING NO. PERM SWL01
DRAWN BY NKG	
DATE 09/15/2011	
APPROVED LGB	

SHEET 1 OF 6	JOB NO. PPLS0902
-----------------	---------------------


ALL DOCUMENTS PREPARED BY PENNONI ASSOCIATES ARE INSTRUMENTED BY ORDINANCE IN RESPECT OF THE PROJECT. THEY ARE NOT INTENDED OR REPRESENTED TO BE SUITABLE FOR REUSE BY OTHERS OR FOR EXTENSIONS OF THE PROJECT OR ON ANY OTHER PROJECT. ANY REUSE WITHOUT WRITTEN PERMISSION OR ADJUSTMENT BY PENNONI ASSOCIATES FOR THE SPECIFIC PURPOSE INTENDED WILL BE AT OWNERS SOLE RISK AND WITHOUT LIABILITY OR LEGAL EXPOSURE TO PENNONI ASSOCIATES; AND OWNER SHALL INDEMNIFY AND HOLD HARMLESS PENNONI ASSOCIATES FROM ALL CLAIMS, DAMAGES, LOSSES AND EXPENSES ARISING OUT OF OR RESULTING THEREFROM.

BELL BEND NUCLEAR POWER PLANT
PERMANENT SWALE DRAINAGE AREA MAP
PPL BELL BEND, LLC
36 BOMBAY AVE, SUITE 2
BERWICK, PA 18603


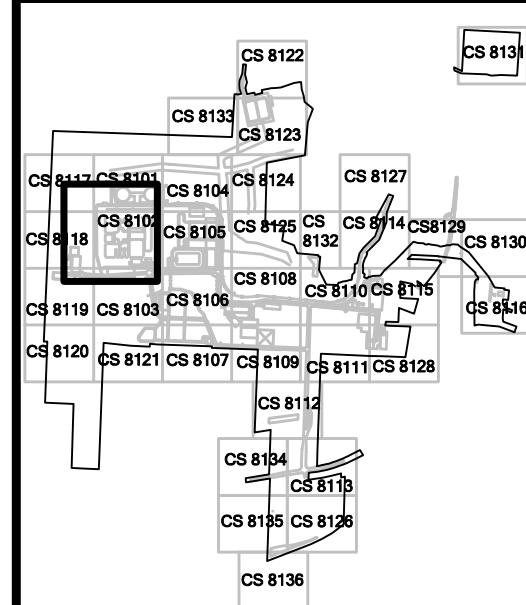


ALL DIMENSIONS MUST BE VERIFIED BY CONTRACTOR. ANY DISCREPANCIES MUST BE REPORTED TO THE ENGINEER BEFORE PROCEEDING WITH THE WORK.	

DATE	NO.	REVISIONS	BY
09/15/11	1	EXCESS EARTHWORK REDUCTION AND LOT COMMENTS	NKG
11/12/10	0	INITIAL SUBMISSION	NKG

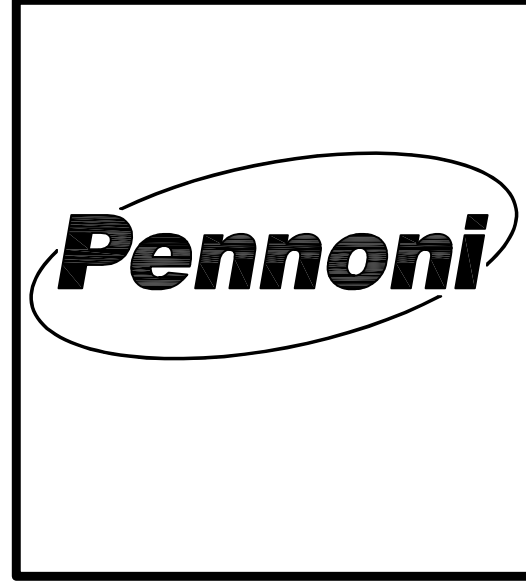

\\PENNONI\US\Projects\2010\02-2011\Bell Bend Land Development\DWG\CS\SWA02\SWA02.dwg
09/15/2011 10:00 AM
NKG

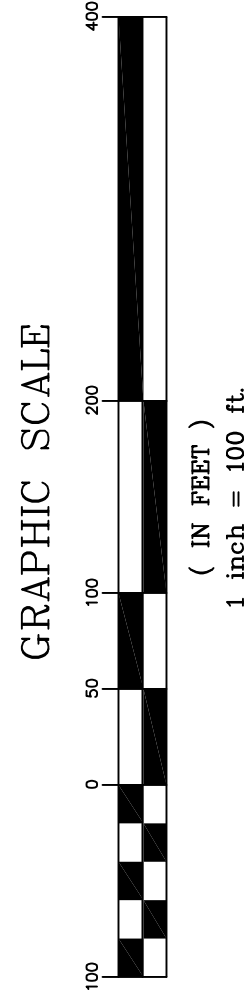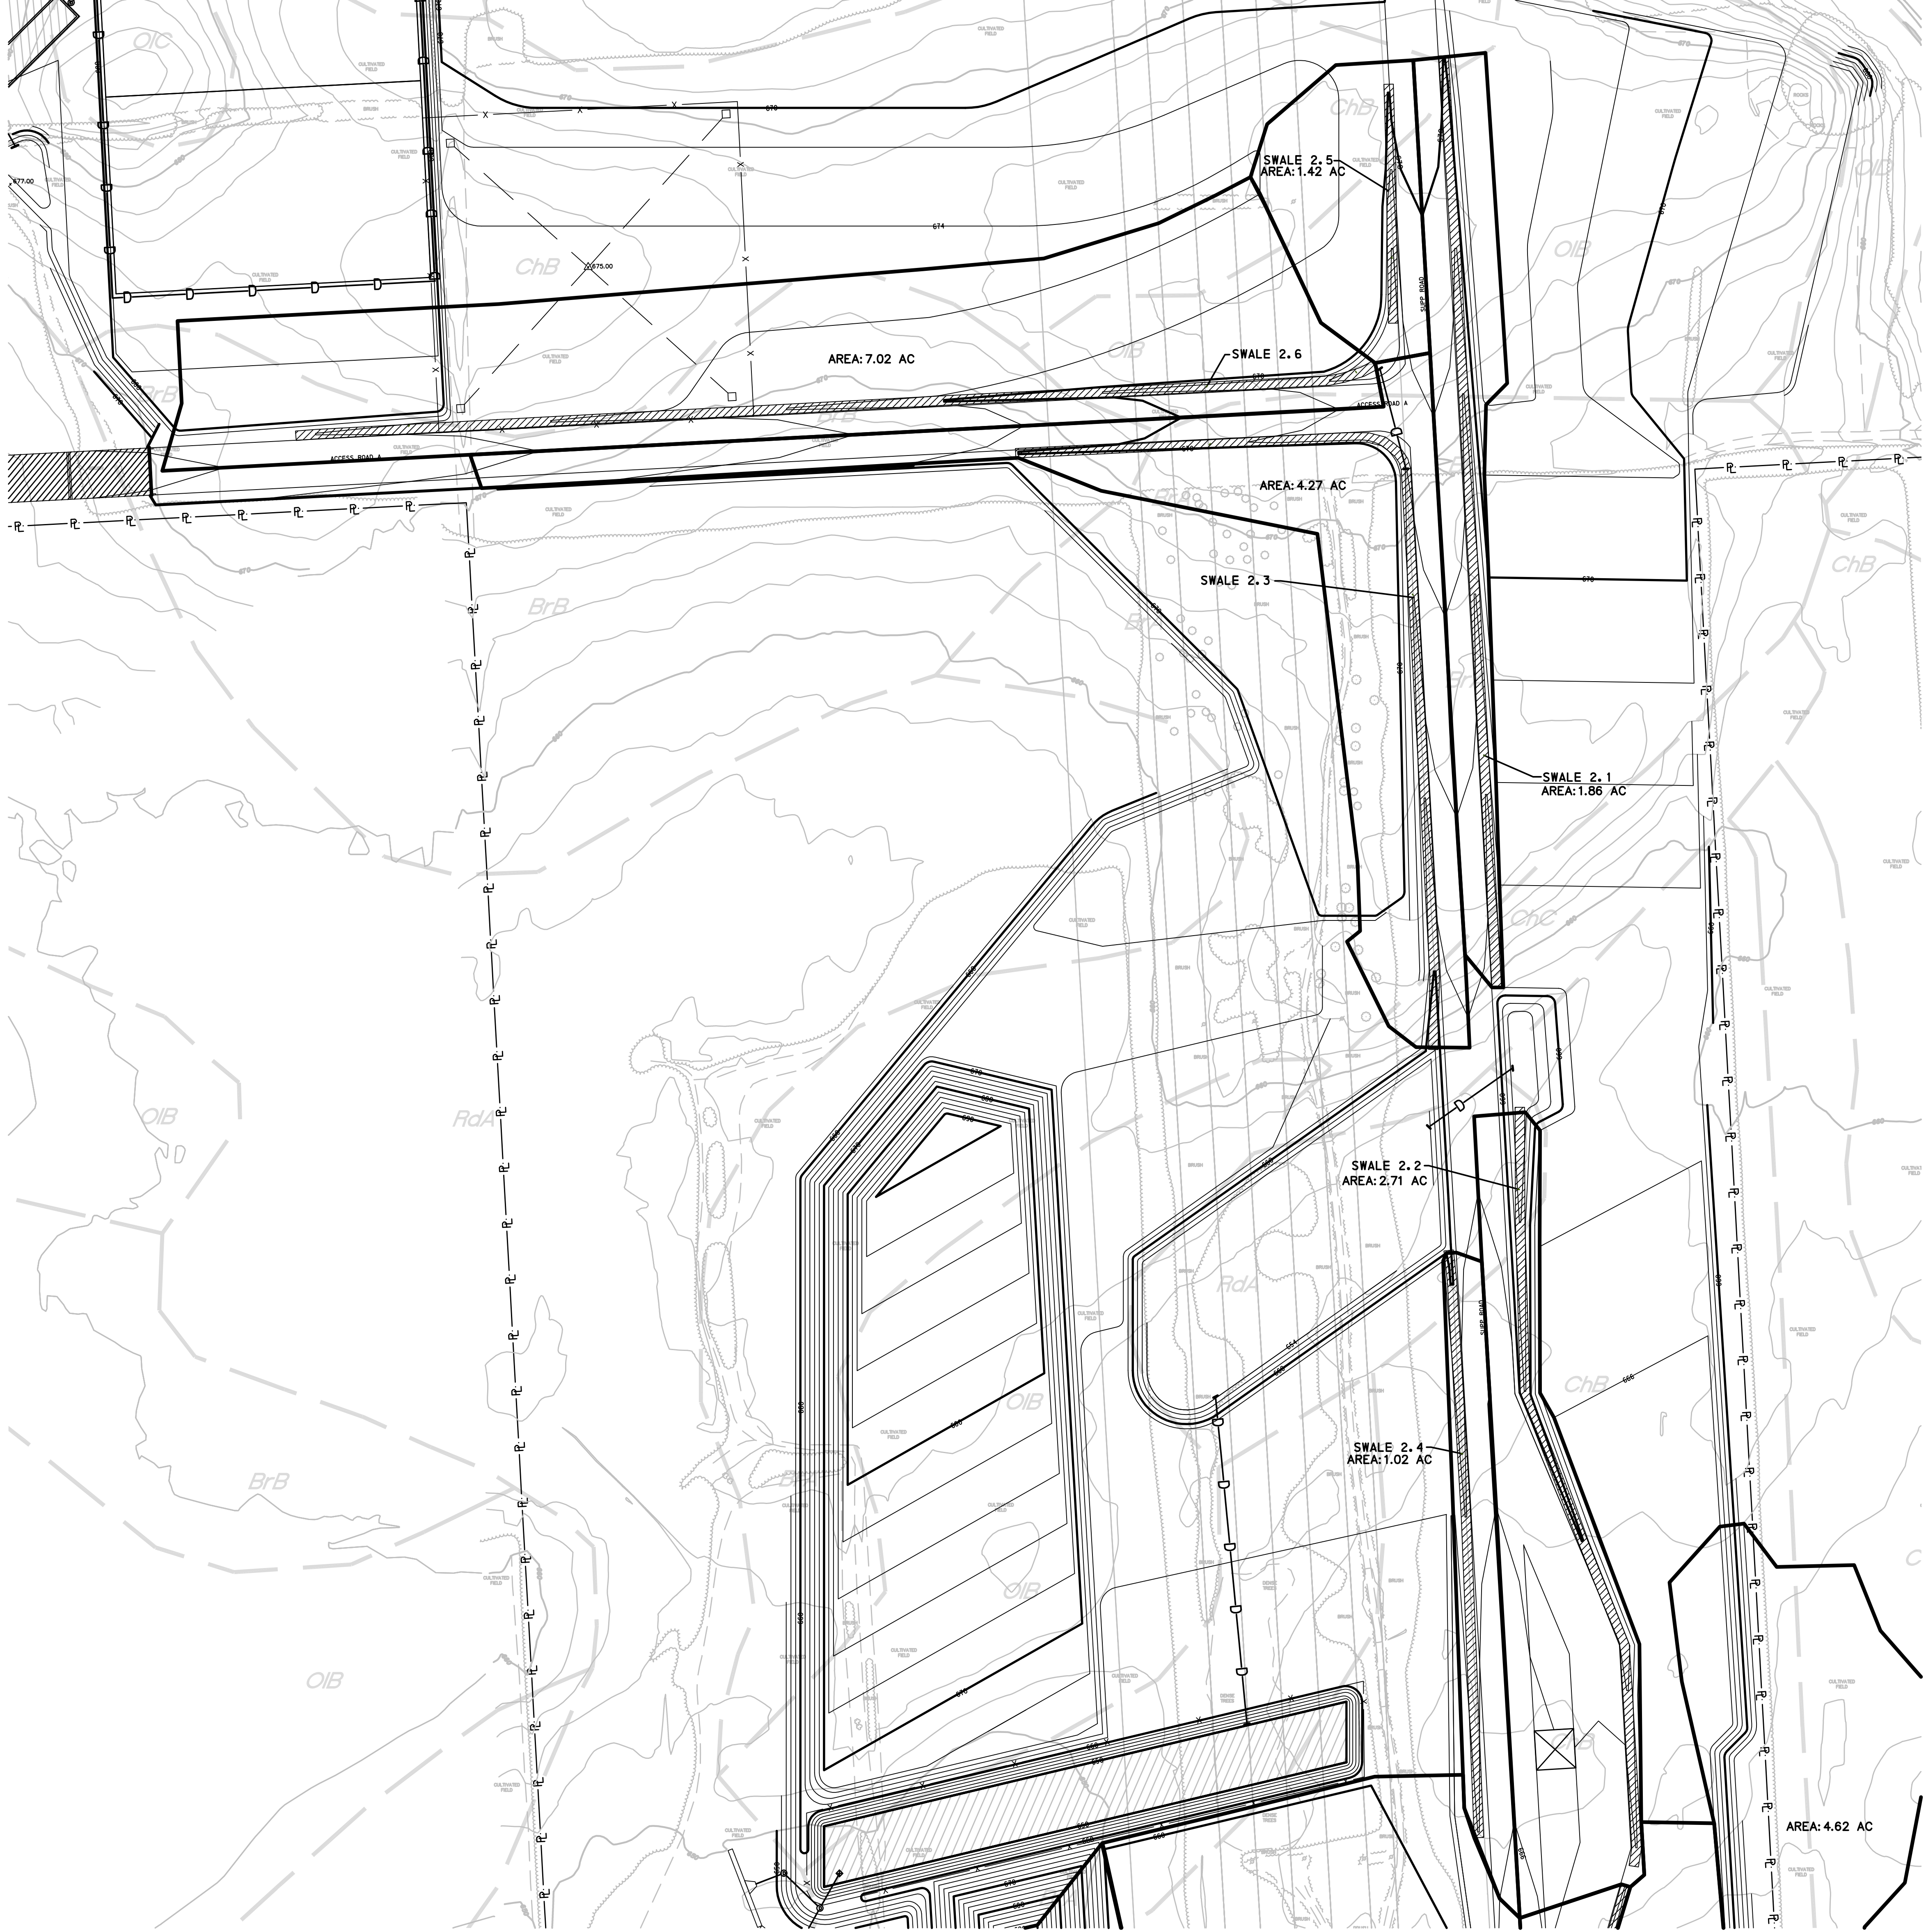

Pennoni Associates Inc.

100 N. Wilkes-Barre Boulevard
Wilkes-Barre, PA 18702 (570) 824-2200


Engineers • Surveyors • Planners • Landscape Architects

SCALE 1"=100'	DRAWING NO. PERM SWL04
DRAWN BY NKG	
DATE 09/15/2011	
APPROVED LGB	

JOB NO. PPLS0902	
SHEET 4 OF 6	

ALL DOCUMENTS PREPARED BY PENNONI ASSOCIATES ARE INSTRUMENTED OR OTHERWISE IN RECORD OF THE PROJECT. THEY ARE NOT INTENDED OR REPRESENTED TO BE SUITABLE FOR REUSE BY OTHERS OR FOR OTHER PROJECTS. ANY REUSE WITHOUT WRITTEN PERMISSION OR ADAPTATION BY PENNONI ASSOCIATES FOR THE SPECIFIC PURPOSE INTENDED WILL BE AT OWNERS SOLE RISK AND WITHOUT LIABILITY OR LEGAL EXPOSURE TO PENNONI ASSOCIATES. AND OWNER SHALL INDEMNIFY AND HOLD HARMLESS PENNONI ASSOCIATES FROM ALL CLAIMS, DAMAGES, LOSSES AND EXPENSES ARISING OUT OF OR RESULTING THEREFROM.



BELL BEND NUCLEAR POWER PLANT
PERMANENT SWALE DRAINAGE AREA MAP
PPL BELL BEND, LLC
38 BOMBAY LANE, SUITE 2
BERWICK, PA 18603

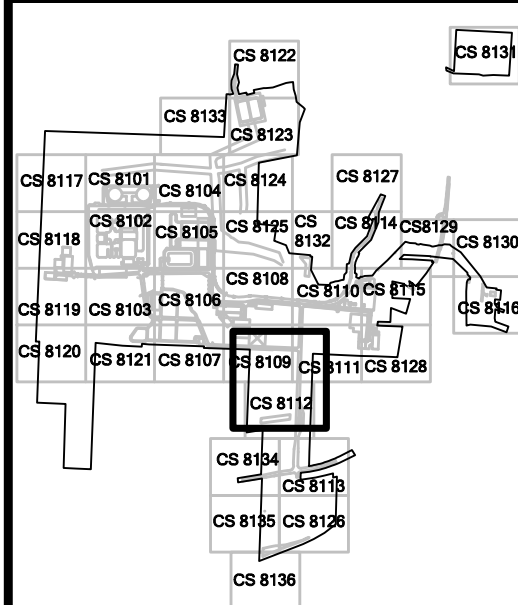

ALL DIMENSIONS MUST BE VERIFIED BY CONTRACTOR. ASSUMES SWALES ARE CONSTRUCTED TO MEET DISSEMINATED BEFORE PROCEEDING WITH THE WORK.

DATE	NO.	REVISIONS	BY
09/15/11	1	EXCESS EARTHWORK REDUCTION AND LOT COMMENTS	NKG
11/12/10	0	INITIAL SUBMISSION	NKG



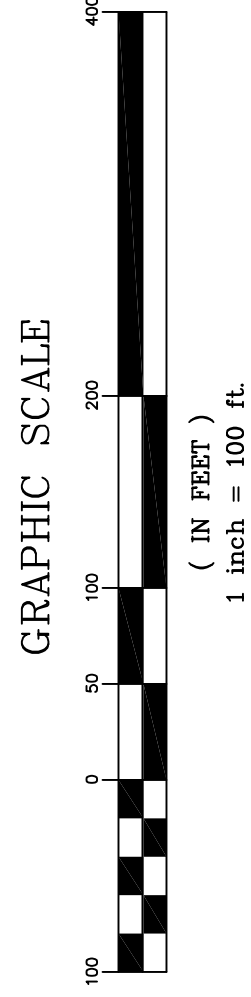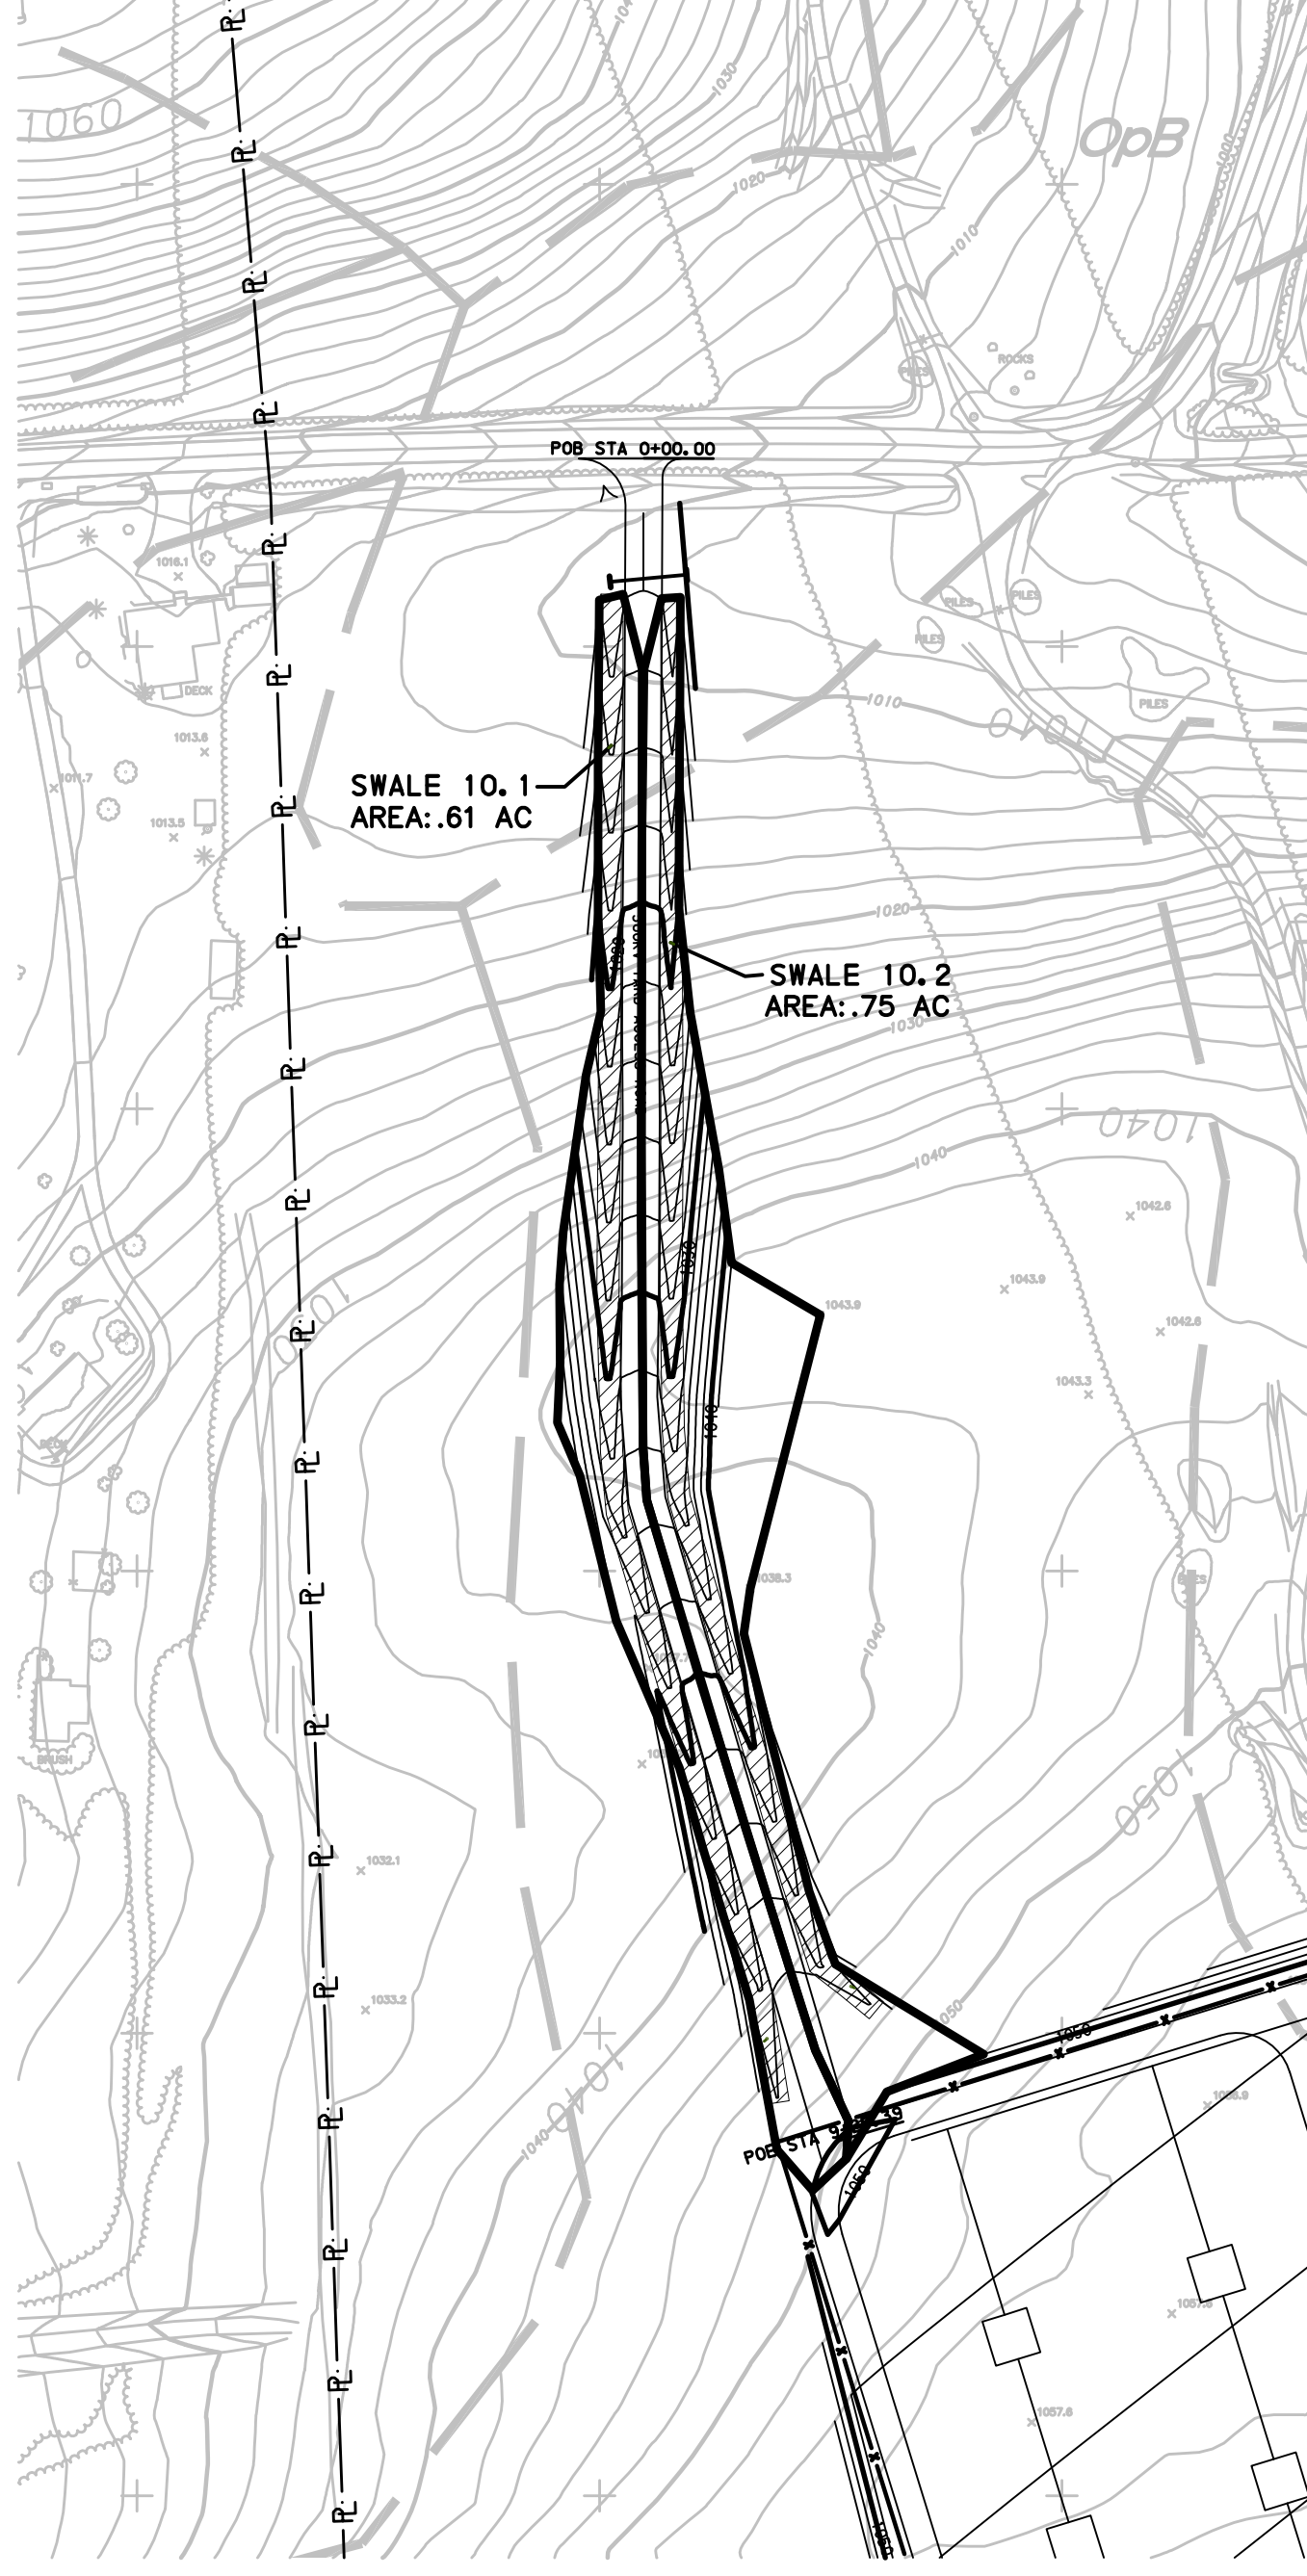

BELL BEND NUCLEAR POWER PLANT

PERMANENT SWALE DRAINAGE AREA MAP

PPL BELL BEND, LLC

ALL DIMENSIONS MUST BE VERIFIED BY CONTRACTOR AND OWNER MUST BE NOTIFIED OF ANY DISCREPANCIES BEFORE PROCEEDING WITH THE WORK.


09/15/11	1	EXCESS EARTHWORK REDUCTION AND LCD COMMENTS	NKG
11/12/10	0	INITIAL SUBMISSION	NKG
DATE	NO.	REVISIONS	BY


SCALE
1"=100'
DRAWN BY
NKG
DATE
09/15/20
APPROVED
LGB

PE
SWL

	JOB NO. PPLS0902
	SHEET 5 OF 6

ALL DOCUMENTS PREPARED BY PENNOMI ASSOCIATES ARE INSTRUMENTS OF SERVICE IN RESPECT OF THE PROJECT. THEY ARE NOT INTENDED OR REPRESENTED TO BE SUITABLE FOR REUSE BY OWNER OR OTHERS ON EXTENSIONS OF THE PROJECT OR ON ANY OTHER PROJECT. ANY REUSE WITHOUT WRITTEN VERIFICATION OR ADAPTATION BY PENNOMI ASSOCIATES FOR THE SPECIFIC PURPOSE INTENDED WILL BE AT OWNERS SOLE RISK AND WITHOUT LIABILITY OR LEGAL EXPOSURE TO PENNOMI ASSOCIATES, AND OWNER SHALL INDEMNIFY AND HOLD HARMLESS PENNOMI ASSOCIATES FROM ALL CLAIMS, DAMAGES, LOSSES AND EXPENSES ARISING OUT OF OR RESULTING THEREFROM.

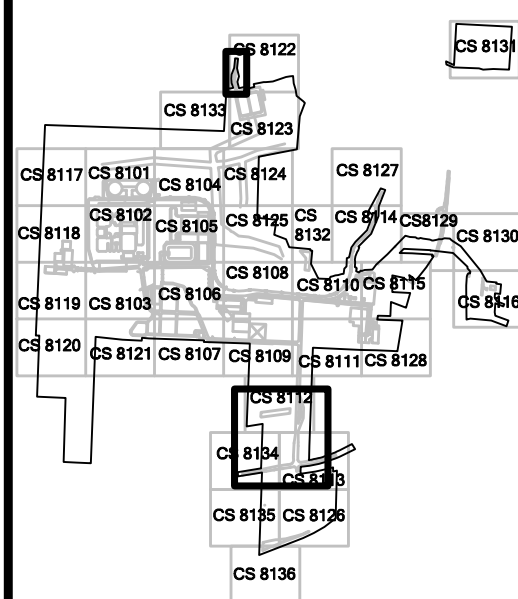

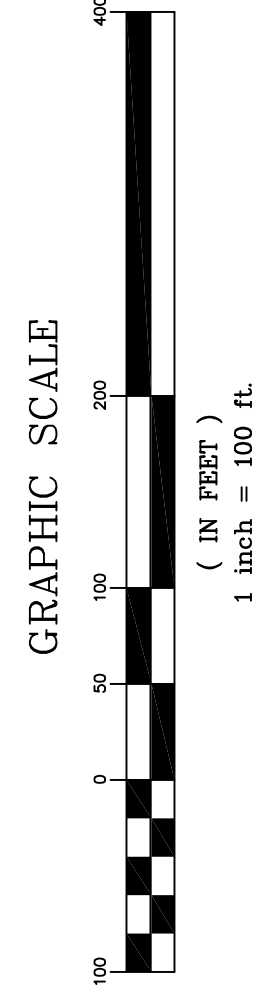

Pennoni Associates Inc.

100 N. Wilkes-Barre Boulevard
Wilkes-Barre, PA 18702 (570) 824-2200

Engineers • Surveyors • Planners • Landscape Architects


BELL BEND NUCLEAR POWER PLANT

PERMANENT SWALE DRAINAGE AREA MAP

PPL BELL BEND, LLC

ALL DIMENSIONS MUST BE VERIFIED BY CONTRACTOR AND OWNER MUST BE NOTIFIED OF ANY DISCREPANCIES BEFORE PROCEEDING WITH THE WORK

09/15/11	1	EXCESS EARTHWORK REDUCTION AND LCD COMMENTS	NKG
11/12/10	0	INITIAL SUBMISSION	NKG
DATE	NO.	REVISIONS	BY

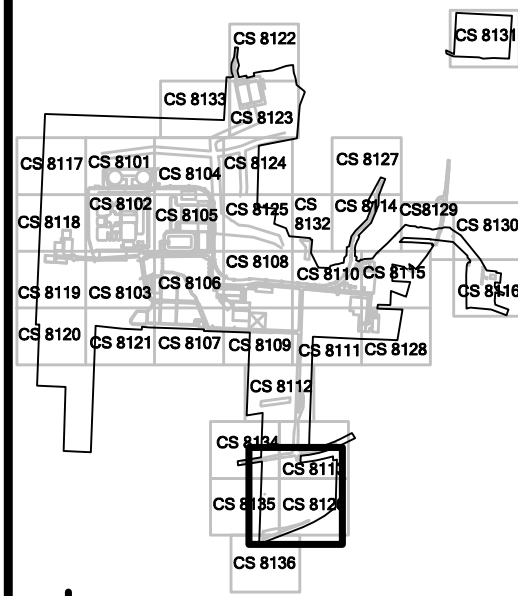

ALL DOCUMENTS PREPARED BY PENNONI ASSOCIATES ARE UNCLASSIFIED AND UNCONTROLLED. INFORMATION CONTAINED HEREIN IS FOR INFORMATION PURPOSES ONLY. IT IS NOT INTENDED OR REPRESENTED TO BE SUITABLE FOR REUSE BY OWNER OR OTHERS ON EXTENSIONS OF THE PROJECT OR ON ANY OTHER PROJECT. ANY REUSE WITHOUT WRITTEN VERIFICATION OR ADAPTATION BY PENNONI ASSOCIATES FOR THE SPECIFIC PURPOSE INTENDED WILL BE AT OWNERS SOLE RISK AND WITHOUT LIABILITY OR LEGAL EXPOSURE TO PENNONI ASSOCIATES, AND OWNER SHALL HOLD PENNONI AND HOLD HARMLESS. PENNONI ASSOCIATES SHALL NOT BE RESPONSIBLE FOR ANY DAMAGES, LOSSES, OR EXPENSES ARISING OUT OF OR RESULTING THEREFROM.

	JOB NO. PPLS0902
	SHEET 6 OF 6

SCALE 1"=100'	DRAWING NO. PERM SWL06
DRAWN BY NKG	
DATE 09/15/2011	
APPROVED LGB	

