


SEE SHEET CS8117

SEE SHEET CS8104

SEE SHEET CS8102

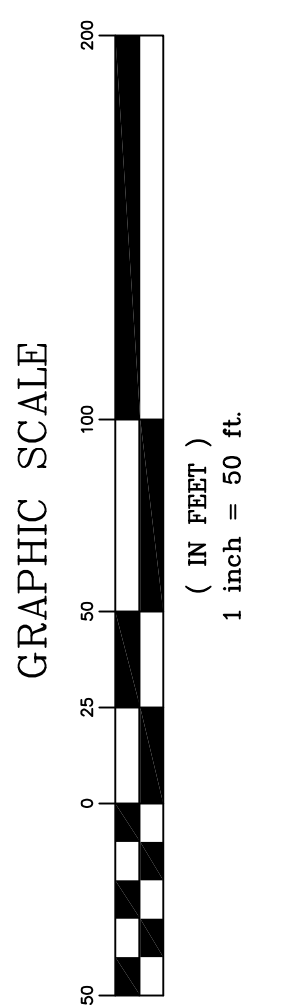


Pennoni Associates Inc. 100 N. Wilkes-Barre Boulevard
 Wilkes-Barre, PA 18702 (570) 824-2200
 Engineers • Surveyors • Planners • Landscape Architects



DATE	NO.	REVISIONS	DFC	BY
9/15/11	1	EXCESS EARTHWORK REDUCTION AND L&D COMMENTS	DFC	
11/12/10	0	INITIAL SUBMISSION	DFC	

ALL DIMENSIONS MUST BE VERIFIED BY CONTRACTOR AND OWNER BEFORE PROCEEDING WITH THE WORK. ANY DISCREPANCIES MUST BE REPORTED IMMEDIATELY TO THE DESIGNER.

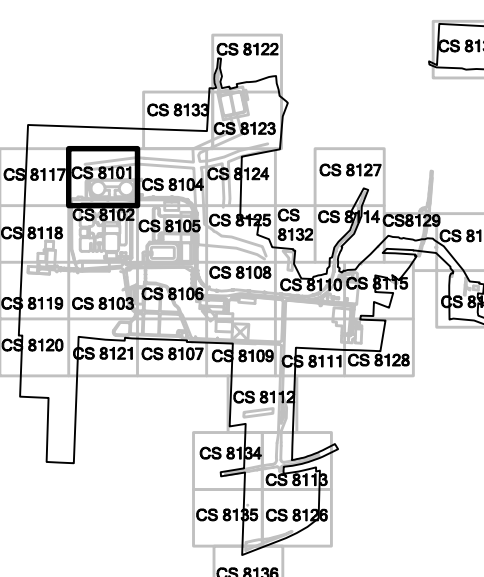

BELL BEND NUCLEAR POWER PLANT
 EROSION AND SEDIMENTATION CONTROL PLANS
 PERMANENT FEATURES
PPL BELL BEND, LLC
 38 BOMBAY LANE, SUITE 2
 BETHLEHEM, PA 18020

SALEM TOWNSHIP, PENNSYLVANIA

ALL DOCUMENTS PREPARED BY PENNONI ASSOCIATES ARE INSTRUMENTED BY RECORD IN RESPECT OF THE PROJECT. THEY ARE NOT INTENDED OR REPRESENTED TO BE SUITABLE FOR USE BY ANY OTHER PARTY OR FOR EXTENSIONS OF THE PROJECT OR ON ANY OTHER PROJECT. ANY REUSE OF THIS DOCUMENT WITHOUT THE WRITTEN PERMISSION OF PENNONI ASSOCIATES FOR THE SPECIFIC PURPOSE INTENDED WILL BE AT OWNERS RISK AND WITHOUT LIABILITY TO PENNONI ASSOCIATES. PENNONI ASSOCIATES AND OWNER SHALL BE RESPONSIBLE FOR ALL CLAIMS, DAMAGES, LOSSES AND EXPENSES ARISING OUT OF OR RESULTING THEREFROM.

JOB NO.	PPLS0902
SHEET	5 OF 75

SCALE	1"=50'
DRAWN BY	MLF
DATE	9/15/2011
APPROVED	JFM
DRAWING NO.	CS 8101A