


SEE SHEET CS8133


SEE SHEET CS8101

SEE SHEET CS8124

SEE SHEET CS8105

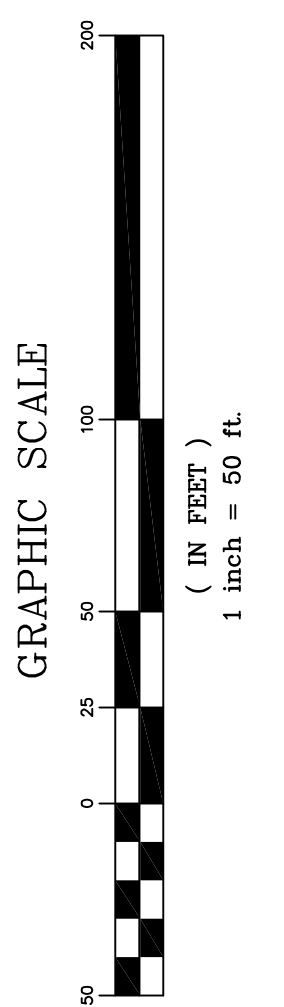


Pennoni Associates Inc.
 100 N. Wilkes-Barre Boulevard
 Wilkes-Barre, PA 18702 (570) 824-2200
 Engineers • Surveyors • Planners • Landscape Architects

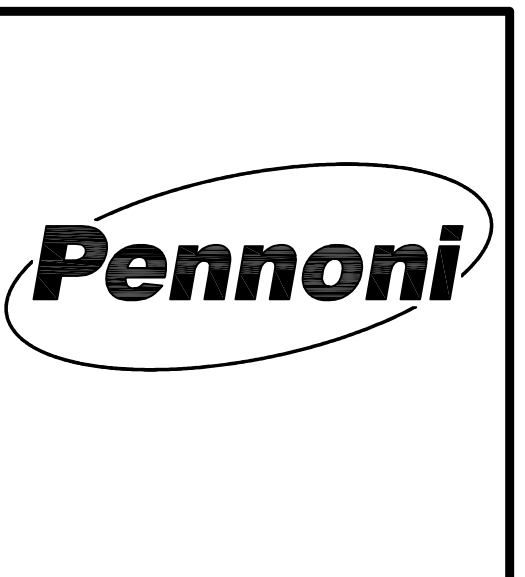

DATE	NO.	REVISIONS	BY
9/15/11	1	EXCESS EARTHWORK REDUCTION AND L2D COMMENTS	DFC
11/12/10	0	INITIAL SUBMISSION	DFC

ALL DIMENSIONS MUST BE VERIFIED BY CONTRACTOR AND OWNER. ANY DISCREPANCIES MUST BE REPORTED IMMEDIATELY. ALL DIMENSIONS MUST BE PRECEDED WITH THE WORD "AS SHOWN".

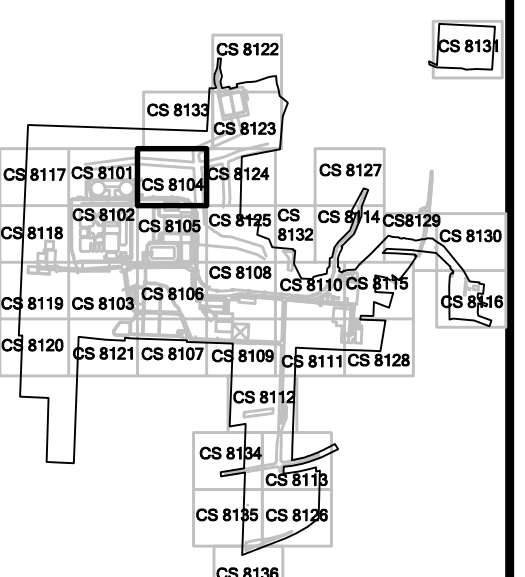

BELL BEND NUCLEAR POWER PLANT
 EROSION AND SEDIMENTATION CONTROL PLANS
 PERMANENT FEATURES
PPL BELL BEND, LLC
SALEM TOWNSHIP, PENNSYLVANIA
 38 BOMBAY LANE, SUITE 2
 BETHLEHEM, PA 18023

ALL DOCUMENTS PREPARED BY PENNONI ASSOCIATES ARE INTENDED TO BE USED IN CONNECTION WITH THE PROJECT. THEY ARE NOT INTENDED OR REPRESENTED TO BE SUITABLE FOR REUSE BY OTHERS OR FOR EXTENSIONS OF THE PROJECT OR ON ANY OTHER PROJECT. ANY REUSE WITHOUT WRITTEN PERMISSION OR AGREEMENT BY PENNONI ASSOCIATES FOR THE SPECIFIC PURPOSE INTENDED WILL BE AT USER'S SOLE RISK AND WITHOUT LIABILITY OR LEGAL EXPOSURE TO PENNONI ASSOCIATES; AND OWNER SHALL INDEMNIFY AND HOLD HARMLESS PENNONI ASSOCIATES FROM ALL CLAIMS, DAMAGES, LOSSES AND EXPENSES ARISING OUT OF OR RESULTING THEREFROM.

JOB NO.	PPLS0902
SHEET	11 OF 75

SCALE	1"=50'	DRAWING NO.	CS 8104A
DRAWN BY	MLF		
DATE	9/15/2011		
APPROVED	JFM		

PROJECT: PPL BELL BEND NUCLEAR POWER PLANT EROSION AND SEDIMENTATION CONTROL PLANS PERMANENT FEATURES
 DRAWN: MLF
 DATE: 9/15/2011
 CHECKED: JFM
 DATE: 9/15/2011