


SEE SHEET CS8133


SEE SHEET CS8101

SEE SHEET CS8124

SEE SHEET CS8105

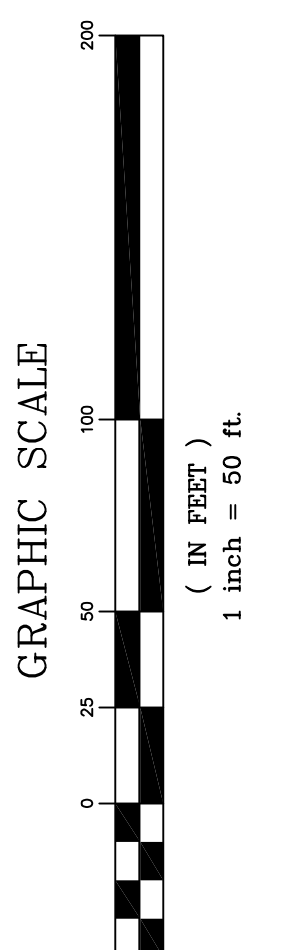


**Pennoni Associates Inc.**  
 Engineers • Surveyors • Planners • Landscape Architects  
 100 N. Wilkes-Barre Boulevard  
 Wilkes-Barre, PA 18702 (570) 824-2200

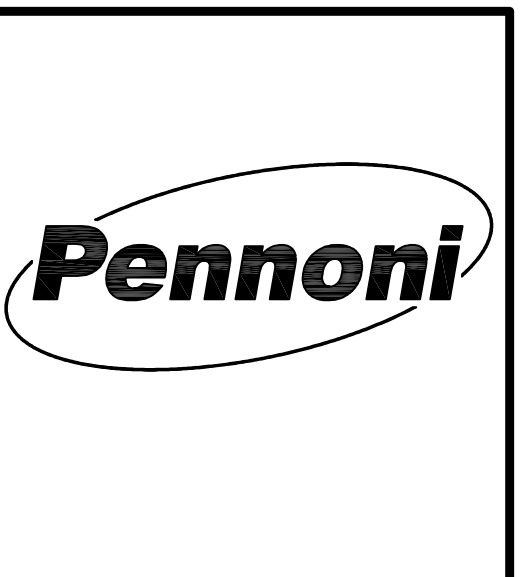

DATE	NO.	REVISIONS	BY
9/15/11	1	EXCESS EARTHWORK REDUCTION AND L2D COMMENTS	DFC
11/12/10	0	INITIAL SUBMISSION	DFC

ALL DIMENSIONS MUST BE VERIFIED BY CONTRACTOR AND OWNER. ANY DISCREPANCIES MUST BE CORRECTED BEFORE PROCEEDING WITH THE WORK.

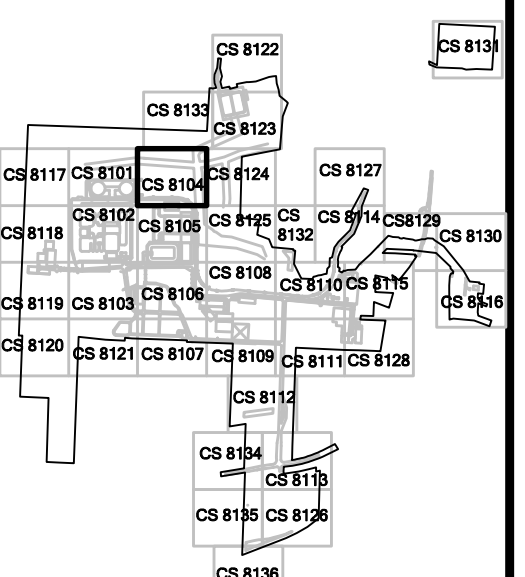

**BELL BEND NUCLEAR POWER PLANT**  
 EROSION AND SEDIMENTATION CONTROL PLANS  
 TEMPORARY CONDITIONS  
**PPL BELL BEND, LLC**  
SALEM TOWNSHIP, PENNSYLVANIA  
 38 BOMBAY LANE, SUITE 2  
 BETHLEHEM, PA 18023

ALL DOCUMENTS PREPARED BY PENNONI ASSOCIATES ARE INSTRUMENTED BY RECORD IN RECORD OF THE PROJECT. THEY ARE NOT INTENDED OR REPRESENTED TO BE SUITABLE FOR REUSE BY OTHERS OR EXTENSIONS OF THE PROJECT OR ON ANY OTHER PROJECT. ANY REUSE WITHOUT WRITTEN PERMISSION OR AGREEMENT BY PENNONI ASSOCIATES FOR THE SPECIFIC PURPOSE INTENDED WILL BE AT USER'S SOLE RISK AND WITHOUT LIABILITY OR LEGAL EXPOSURE TO PENNONI ASSOCIATES. USER SHALL INDEMNIFY AND HOLD HARMLESS PENNONI ASSOCIATES FROM ALL CLAIMS, DAMAGES, LOSSES AND EXPENSES ARISING OUT OF OR RESULTING THEREFROM.

JOB NO.	PPLS0902
SHEET	12 OF 75

SCALE	1"=50'	DRAWING NO.	CS 8104B
DRAWN BY	MLF	DATE	9/15/2011
APPROVED	JFM		

PROJECT: PPLS0902-001 - Bell Bend Nuclear Power Plant Erosion and Sedimentation Control Plans  
 DRAWN: MLF  
 DATE: 9/15/2011