

\\PENNONI\Projects\2010\2010-09-15\BELL BEND\Drawings\CS8114.dwg  
Date: 9/15/2011 10:00:00 AM  
User: jfm


SEE SHEET CS8132

SEE SHEET CS8127

SEE SHEET CS8129

SEE SHEET CS8110

SEE SHEET CS8129

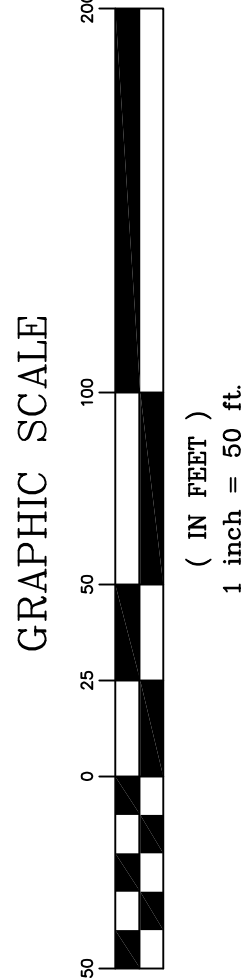


Pennoni Associates Inc.

Engineers • Surveyors • Planners • Landscape Architects

SCALE	1"=50'
DRAWN BY	MLF
DATE	9/15/2011
APPROVED	JFM
JOB NO.	PPLS0902
SHEET	26 OF 75
DRAWING NO.	CS8114

**BELL BEND NUCLEAR POWER PLANT**  
**EROSION AND SEDIMENTATION CONTROL PLANS**  
 SALEM TOWNSHIP, PENNSYLVANIA  
**PPL BELL BEND, LLC**  
 38 BOMBAY LANE, SUITE 2  
 BERWICK, PA 18603

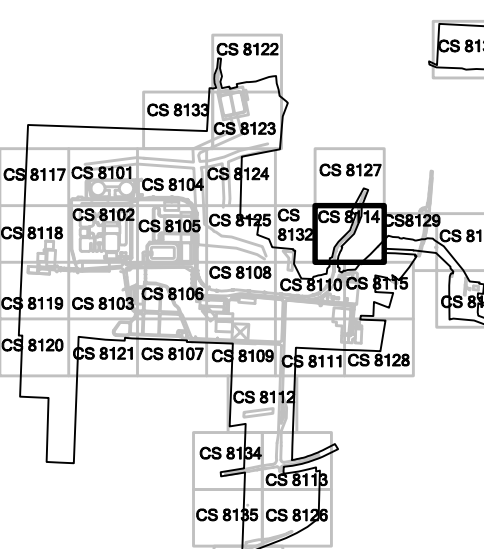

ALL DIMENSIONS MUST BE VERIFIED BY CONTRACTOR  
 ASSUMES ALL DIMENSIONS ARE AS SHOWN UNLESS  
 OTHERWISE NOTED. ALL DIMENSIONS MUST BE  
 OBTAINED BEFORE PROCEEDING WITH THE WORK.

DATE	NO.	REVISIONS	BY
9/15/11	1	EXCESS EARTHWORK REDUCTION AND L&D COMMENTS	DFC
11/12/10	0	INITIAL SUBMISSION	DFC

