


SEE SHEET CS8114

SEE SHEET CS8129

SEE SHEET CS8110

SEE SHEET CS8128

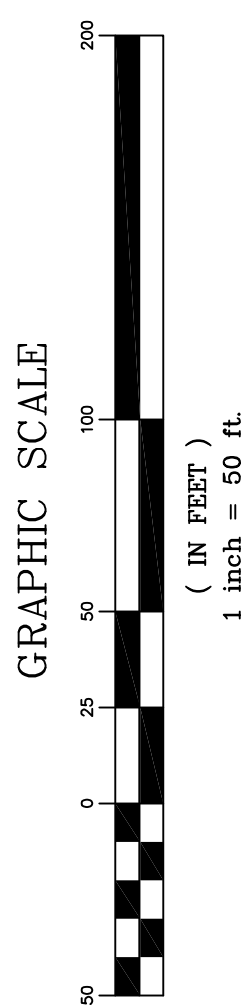

**Pennoni Associates Inc.**


100 N. Wilkes-Barre Boulevard  
Wilkes-Barre, PA 18702 (570) 824-2200

Engineers • Surveyors • Planners • Landscape Architects



DATE	NO.	REVISIONS	DFC	BY
9/15/11	1	EXCESS EARTHWORK REDUCTION AND L2D COMMENTS	DFC	
11/12/10	0	INITIAL SUBMISSION	DFC	

ALL DIMENSIONS MUST BE VERIFIED BY CONTRACTOR ASSUMES RESPONSIBILITY FOR ANY DISCREPANCIES BEFORE PROCEEDING WITH THE WORK.

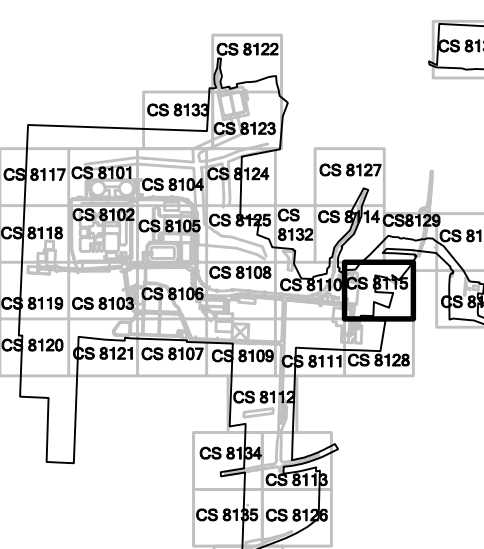

**BELL BEND NUCLEAR POWER PLANT**  
EROSION AND SEDIMENTATION CONTROL PLANS  
PERMANENT FEATURES  
PPL BELL BEND, LLC  
38 BOMBAY LANE, SUITE 2  
BERWICK, PA 18803

SALEM TOWNSHIP, PENNSYLVANIA

ALL DOCUMENTS PREPARED BY PENNONI ASSOCIATES ARE INSTRUMENTED BY ENGINEER IN RECORD OF THE PROJECT. THEY ARE NOT INTENDED OR REPRESENTED TO BE SUITABLE FOR REUSE BY OTHERS OR FOR EXTENSIONS OF THE PROJECT OR ON ANY OTHER PROJECT. ANY REUSE WITHOUT WRITTEN APPROVAL OR PERMISSION BY PENNONI ASSOCIATES FOR THE SPECIFIC PURPOSE INTENDED WILL BE AT USER'S SOLE RISK AND WITHOUT LIABILITY OR LEGAL EXPOSURE TO PENNONI ASSOCIATES; AND OWNER SHALL INDEMNIFY AND HOLD HARMLESS PENNONI ASSOCIATES FROM ALL CLAIMS, DAMAGES, LOSSES AND EXPENSES ARISING OUT OF OR RESULTING THEREFROM.

JOB NO.	PPLS0902
SHEET	27 OF 75

SCALE	1"=50'	DRAWING NO.	CS 8115A
DRAWN BY	MLF		
DATE	9/15/2011		
APPROVED	JFM		

\PROJECTS\09\0902\0902-001\0902-001.dwg User: jfm Date: 9/15/2011 10:54:41 AM  
 Pennoni Associates Inc.