


\\PENNONI\WORK\2010\2010 Bell Bend Land Development\DESIGN\CS\8119.dwg
09/15/2011 10:00 AM
JPM

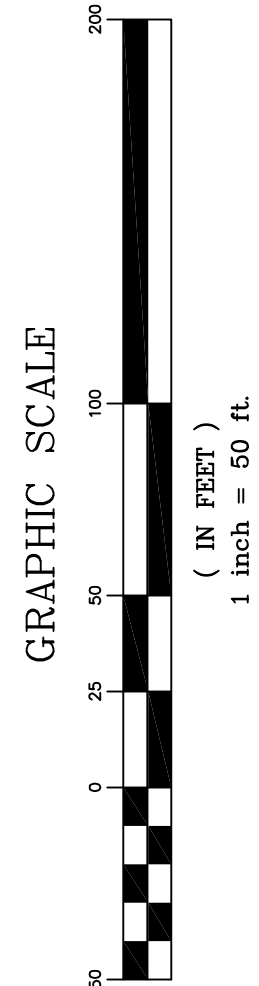

SEE SHEET CS8102

SEE SHEET CS8117

SEE SHEET CS8119

Pennoni Associates Inc.


Engineers • Surveyors • Planners • Landscape Architects

SCALE	1"=50'
DRAWN BY	MLF
DATE	9/15/2011
APPROVED	JPM

JOB NO.	PPLS0902
SHEET	31 OF 75

ALL DOCUMENTS PREPARED BY PENNONI ASSOCIATES ARE INSTRUMENTED BY RECORD IN RECORD OF THE PROJECT. THEY ARE NOT INTENDED OR REPRESENTED TO BE SUITABLE FOR REUSE BY OTHERS OR FOR EXTENSIONS OF THE PROJECT OR ON ANY OTHER PROJECT. ANY REUSE WITHOUT WRITTEN PERMISSION OR ADAPTATION BY PENNONI ASSOCIATES FOR THE SPECIFIC PURPOSE INTENDED WILL BE AT OWNERS SOLE RISK AND WITHOUT LIABILITY OR LEGAL EXPOSURE TO PENNONI ASSOCIATES. AND OWNER SHALL INDEMNIFY AND HOLD HARMLESS PENNONI ASSOCIATES FROM ALL CLAIMS, DAMAGES, LOSSES AND EXPENSES ARISING OUT OF OR RESULTING THEREFROM.

BELL BEND NUCLEAR POWER PLANT
EROSION AND SEDIMENTATION CONTROL PLANS
PERMANENT FEATURES
PPL BELL BEND, LLC
38 BOMBAY AVE, SUITE 2
BERWICK, PA 19603

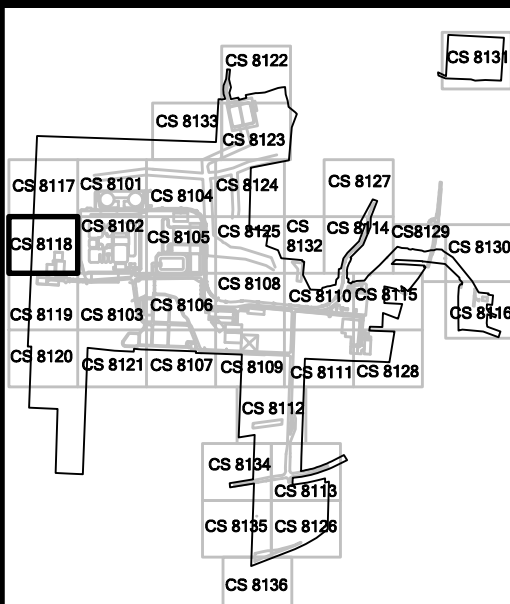

ALL DIMENSIONS MUST BE VERIFIED BY CONTRACTOR. ALL DIMENSIONS MUST BE VERIFIED BY CONTRACTOR. ALL DIMENSIONS MUST BE VERIFIED BY CONTRACTOR. ALL DIMENSIONS MUST BE VERIFIED BY CONTRACTOR. ALL DIMENSIONS MUST BE VERIFIED BY CONTRACTOR.	DATE	NO.	REVISIONS	BY
11/12/10	0	INITIAL SUBMISSION	DFC	DFC
9/15/11	1	EXCESS EARTHWORK REDUCTION AND LDC COMMENTS	DFC	DFC

