


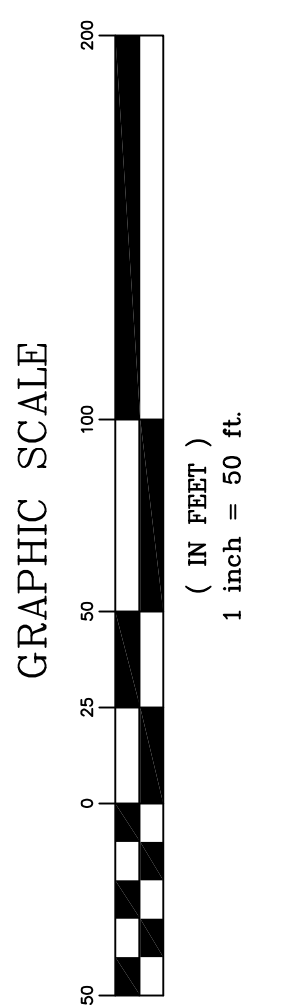


SEE SHEET CS8118

SEE SHEET CS8103

SEE SHEET CS8120




**Pennoni Associates Inc.** 100 N. Wilkes-Barre Boulevard  
 Wilkes-Barre, PA 18702 (570) 824-2200

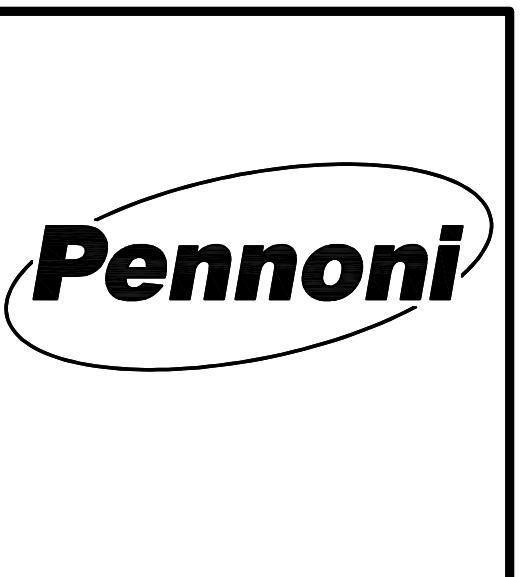

DATE	NO.	REVISIONS	BY
9/15/11	1	EXCESS EARTHWORK REDUCTION AND L&D COMMENTS	DFC
11/12/10	0	INITIAL SUBMISSION	DFC

ALL DIMENSIONS MUST BE VERIFIED BY CONTRACTOR AND OWNER. ANY DIMENSIONS NOT SHOWN MUST BE VERIFIED BY THE WORKING DRAWINGS BEFORE PROCEEDING WITH THE WORK.

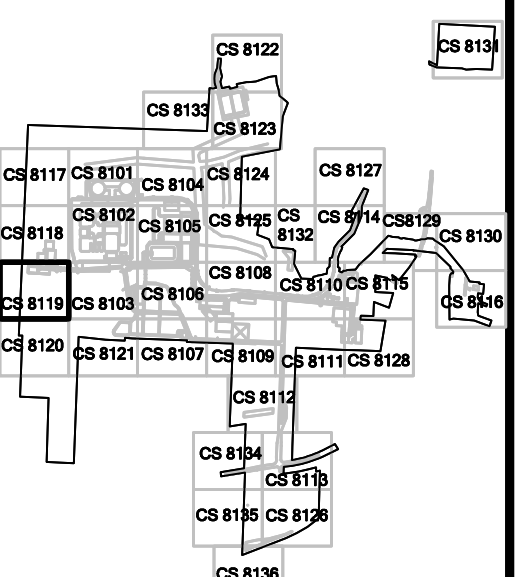

**BELL BEND NUCLEAR POWER PLANT**  
 EROSION AND SEDIMENTATION CONTROL PLANS  
 PERMANENT FEATURES  
**PPL BELL BEND, LLC**  
 38 BOMBAY LANE, SUITE 2  
 BETHLEHEM, PA 18023

SALEM TOWNSHIP, PENNSYLVANIA

ALL DOCUMENTS PREPARED BY PENNONI ASSOCIATES ARE INTENDED TO BE USED IN CONNECTION WITH THE PROJECT. THEY ARE NOT INTENDED OR REPRESENTED TO BE SUITABLE FOR REUSE OR FOR ANY OTHER PROJECT. ANY REUSE OF THIS DOCUMENT OR ANY PART THEREOF WITHOUT THE WRITTEN APPROVAL OF PENNONI ASSOCIATES FOR THE SPECIFIC PURPOSE INTENDED WILL BE AT OWNERS RISK AND WITHOUT LIABILITY OR LEGAL EXPOSURE TO PENNONI ASSOCIATES; AND OWNER SHALL INDEMNIFY AND HOLD HARMLESS PENNONI ASSOCIATES FROM ALL CLAIMS, DAMAGES, LOSSES AND EXPENSES ARISING OUT OF OR RESULTING THEREFROM.

JOB NO.	PPLS0902
SHEET	33 OF 75

SCALE	1"=50'	DRAWING NO.	CS 8119A
DRAWN BY	MLF		
DATE	9/15/2011		
APPROVED	JFM		

PROJECT: PPL BELL BEND NUCLEAR POWER PLANT EROSION AND SEDIMENTATION CONTROL PLANS PERMANENT FEATURES  
 DRAWN: MLF  
 DATE: 9/15/2011  
 CHECKED: JFM  
 DATE: 9/15/2011