


\\PENNONI\PROJECTS\2010\0902- Bell Bend Land Development\VERSION\CS8122.dwg  
 9/15/2011 10:00:00 AM  
 JFM

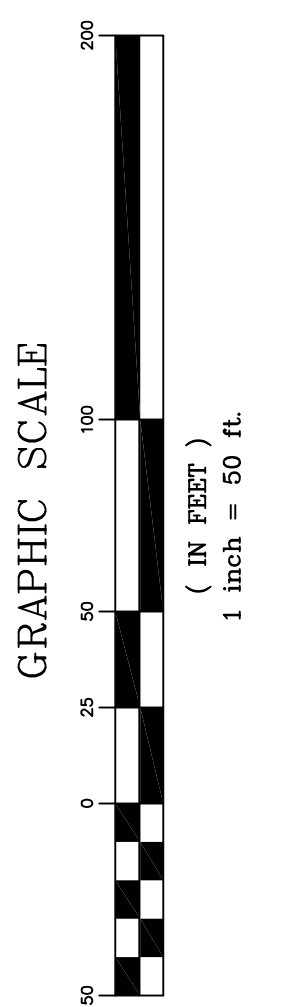

SEE SHEET CS8123


**Pennoni Associates Inc.**

**Engineers • Surveyors • Planners • Landscape Architects**

SCALE	1"=50'	DRAWING NO.	CS8122
DRAWN BY	MLF	JOB NO.	PPLS0902
DATE	9/15/2011	SHEET	38 OF 75
APPROVED	JFM		

**BELL BEND NUCLEAR POWER PLANT**  
**EROSION AND SEDIMENTATION CONTROL PLANS**  
 SALEM TOWNSHIP, PENNSYLVANIA  
**PPL BELL BEND, LLC**  
 38 BOMBAY AVE, SUITE 2  
 BETHLEHEM, PA 18023

100 N. Wilkes-Barre Boulevard  
 Wilkes-Barre, PA 18702 (570) 824-2200

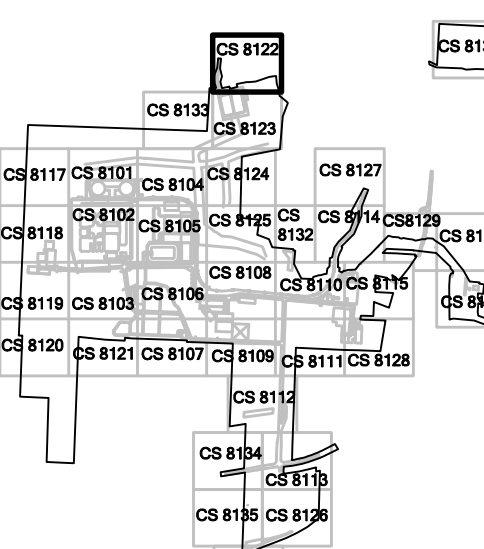

ALL DIMENSIONS MUST BE VERIFIED BY CONTRACTOR  
 ASSUMES ALL DIMENSIONS ARE AS SHOWN  
 DISCREPANCIES BEFORE PROCEEDING WITH THE WORK

DATE	NO.	REVISIONS	BY
9/15/11	1	EXCESS EARTHWORK REDUCTION AND L2D COMMENTS	DFC
11/12/10	0	INITIAL SUBMISSION	DFC



ALL DOCUMENTS PREPARED BY PENNONI ASSOCIATES ARE INSTRUMENTED BY ENGINEER IN RECORD OF THE PROJECT. THEY ARE NOT INTENDED OR REPRESENTED TO BE SUITABLE FOR REUSE BY OTHERS OR EXTENSIONS OF THE PROJECT OR ON ANY OTHER PROJECT. ANY REUSE WITHOUT WRITTEN PERMISSION OR ASSURANCE BY PENNONI ASSOCIATES FOR THE SPECIFIC PURPOSE INTENDED WILL BE AT USER'S SOLE RISK AND WITHOUT LIABILITY OR LEGAL EXPOSURE TO PENNONI ASSOCIATES. AND OWNER SHALL INDEMNIFY AND HOLD HARMLESS PENNONI ASSOCIATES FROM ALL CLAIMS, DAMAGES, LOSSES AND EXPENSES ARISING OUT OF OR RESULTING THEREFROM.