


SEE SHEET CS8115



SEE SHEET CS8111

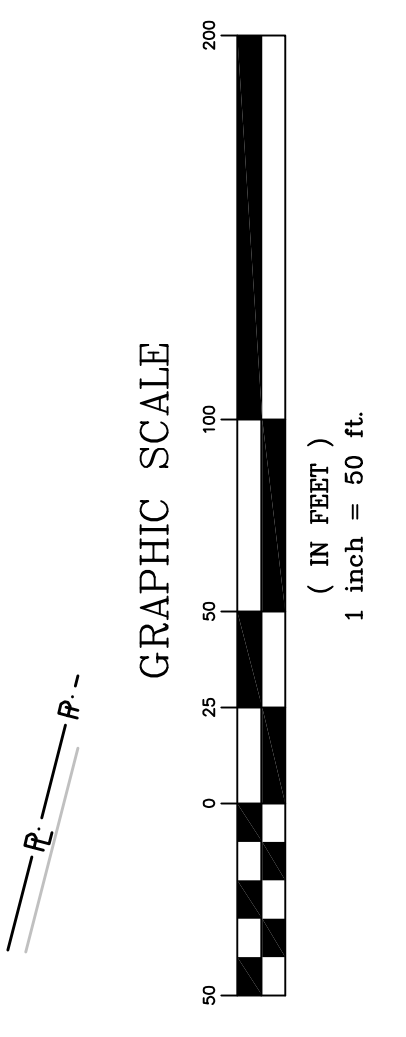


Pennoni Associates Inc.

Engineers • Surveyors • Planners • Landscape Architects

SCALE	1"=50'
DRAWN BY	MLF
DATE	9/15/2011
APPROVED	JFM
JOB NO.	PPLS0902
SHEET	45 OF 75
DRAWING NO.	CS 8128A

BELL BEND NUCLEAR POWER PLANT
EROSION AND SEDIMENTATION CONTROL PLANS
PERMANENT FEATURES
PPL BELL BEND, LLC
 38 BOMBAY LANE, SUITE 2
 BERWICK, PA 19803

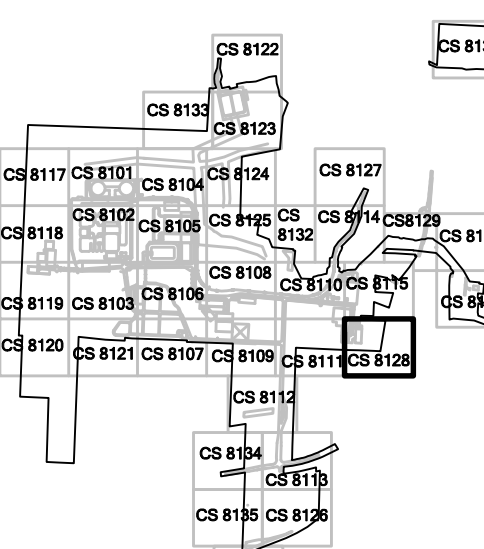

ALL DIMENSIONS MUST BE VERIFIED BY CONTRACTOR. ASSUMES ALL DIMENSIONS ARE CORRECT UNLESS OTHERWISE NOTED. DISCREPANCIES BEFORE PROCEEDING WITH THE WORK.

DATE	NO.	REVISIONS	BY
9/15/11	1	EXCESS EARTHWORK REDUCTION AND LOD COMMENTS	DFC
11/12/10	0	INITIAL SUBMISSION	DFC



\\PENNONI\PROJECTS\WY\CS812802 - Bell Bend Land Development\DESIGN\CS8128A\8128A.dwg
 9/15/2011 10:00 AM
 JFM