


\\PENNONI\WORK\150902-Bell Bend Land Development\DESIGN\CS8134.dwg
9/15/2011 10:00 AM
MLF

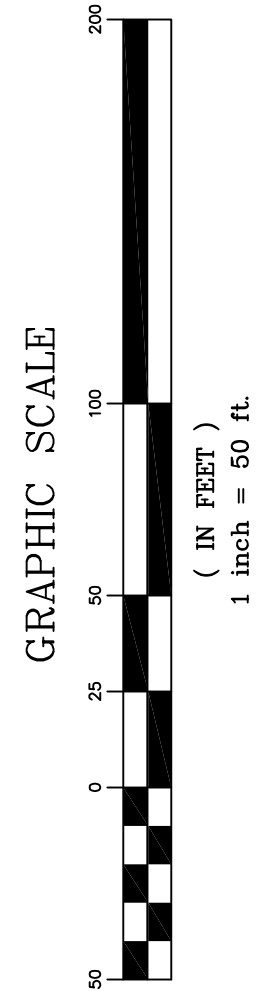

SEE SHEET CS8113

SEE SHEET CS8135

SEE SHEET CS8112



Pennoni Associates Inc.

100 N. Wilkes-Barre Boulevard
Wilkes-Barre, PA 18702 (570) 824-2200

Engineers • Surveyors • Planners • Landscape Architects

SCALE 1"=50'	DRAWING NO. CS8134
DRAWN BY MLF	
DATE 9/15/2011	
APPROVED JFM	


JOB NO. PPLS0902	
SHEET 52 OF 75	

ALL DOCUMENTS PREPARED BY PENNONI ASSOCIATES ARE
INSTRUMENTS OF SERVICE IN RESPECT OF THE PROJECT.
THEY ARE NOT INTENDED OR REPRESENTED TO BE SUITABLE
FOR REUSE BY OTHERS OR FOR OTHERS ON EXTENSIONS OF
THE PROJECT OR ON ANY OTHER PROJECT. ANY REUSE
WITHOUT WRITTEN PERMISSION OR ADAPTATION BY PENNONI
ASSOCIATES FOR THE SPECIFIC PURPOSE INTENDED WILL BE
AT OWNERS SOLE RISK AND WITHOUT LIABILITY OR LEGAL
EXPOSURE TO PENNONI ASSOCIATES; AND OWNER SHALL
INDEMNIFY AND HOLD HARMLESS PENNONI ASSOCIATES
FROM ALL CLAIMS, DAMAGES, LOSSES AND EXPENSES
ARISING OUT OF OR RESULTING THEREFROM.

BELL BEND NUCLEAR POWER PLANT

PPL BELL BEND, LLC
38 BOMBAY LANE, SUITE 2
BERWICK, PA 19803

EROSION AND SEDIMENTATION CONTROL PLANS

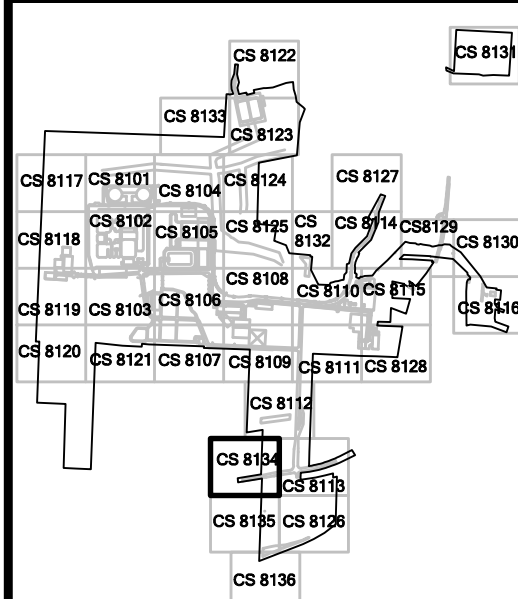

ALL DIMENSIONS MUST BE VERIFIED BY CONTRACTOR
AND CORRECTED BEFORE PROCEEDING WITH THE WORK.

DATE	NO.	REVISIONS	BY
9/15/11	1	EXCESS EARTHWORK REDUCTION AND L&D COMMENTS	DFC
11/12/10	0	INITIAL SUBMISSION	DFC

DATE	NO.	REVISIONS	BY
9/15/11	1	EXCESS EARTHWORK REDUCTION AND L&D COMMENTS	DFC
11/12/10	0	INITIAL SUBMISSION	DFC

