


\\PENNONI\PROJECTS\150802-Bell Bend Land Development\AECOM\CS1508\1508PSM.dwg
9/15/2011 10:40 AM
JFM

SEE SHEET CS1506

SEE SHEET CS1525

SEE SHEET CS1509

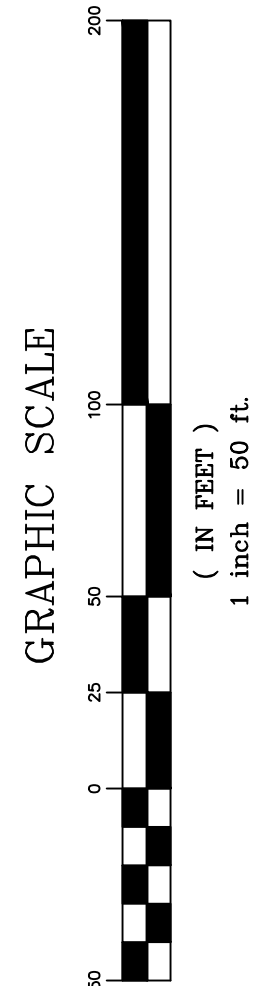

SEE SHEET CS1510



Pennoni Associates Inc.

Engineers • Surveyors • Planners • Landscape Architects

SCALE 1"=50'	DRAWING NO. CS 1508 PCSM
DRAWN BY LGB	
DATE 9/15/2011	
APPROVED JFM	

JOB NO. PPLS0902	
SHEET 10 OF 43	

ALL DOCUMENTS PREPARED BY PENNONI ASSOCIATES ARE THE PROPERTY OF PENNONI ASSOCIATES. THEY ARE NOT TO BE REPRODUCED OR TRANSMITTED IN ANY FORM OR BY ANY MEANS, ELECTRONIC OR MECHANICAL, INCLUDING PHOTOCOPYING, RECORDING, OR BY ANY INFORMATION STORAGE AND RETRIEVAL SYSTEM, WITHOUT THE WRITTEN PERMISSION OF PENNONI ASSOCIATES. PENNONI ASSOCIATES SHALL NOT BE LIABLE FOR ANY DAMAGES, LOSSES, OR EXPENSES ARISING OUT OF OR RESULTING THEREFROM.


BELL BEND NUCLEAR POWER PLANT

PCSM PLANS

PPL BELL BEND, LLC

38 BOMBAY LANE, SUITE 2
BERWICK, PA 18603

100 N. Wilkes-Barre Boulevard
Wilkes-Barre, PA 18702 (570) 824-2200

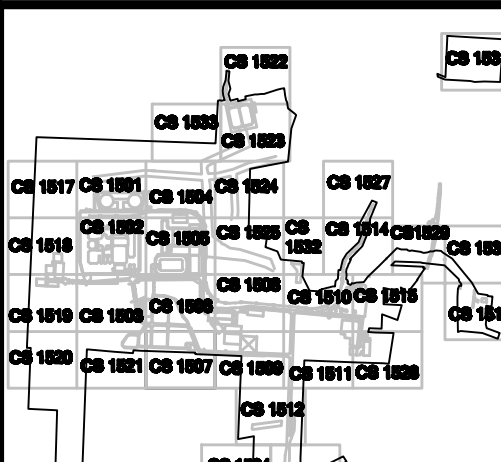

ALL DIMENSIONS MUST BE VERIFIED BY CONTRACTOR AND FIELD REPRESENTATIVE PRIOR TO CONSTRUCTION. DISCREPANCIES BETWEEN FIELD AND OFFICE DIMENSIONS SHALL BE THE RESPONSIBILITY OF THE CONTRACTOR.

DATE	NO.	REVISIONS	BY
9/15/11	1	EXCESS SURVEYOR REVISIONS AND LOG COMMENTS	LGB

