




DIESEL GENERATOR BLDG - AREA 12 (OWC)

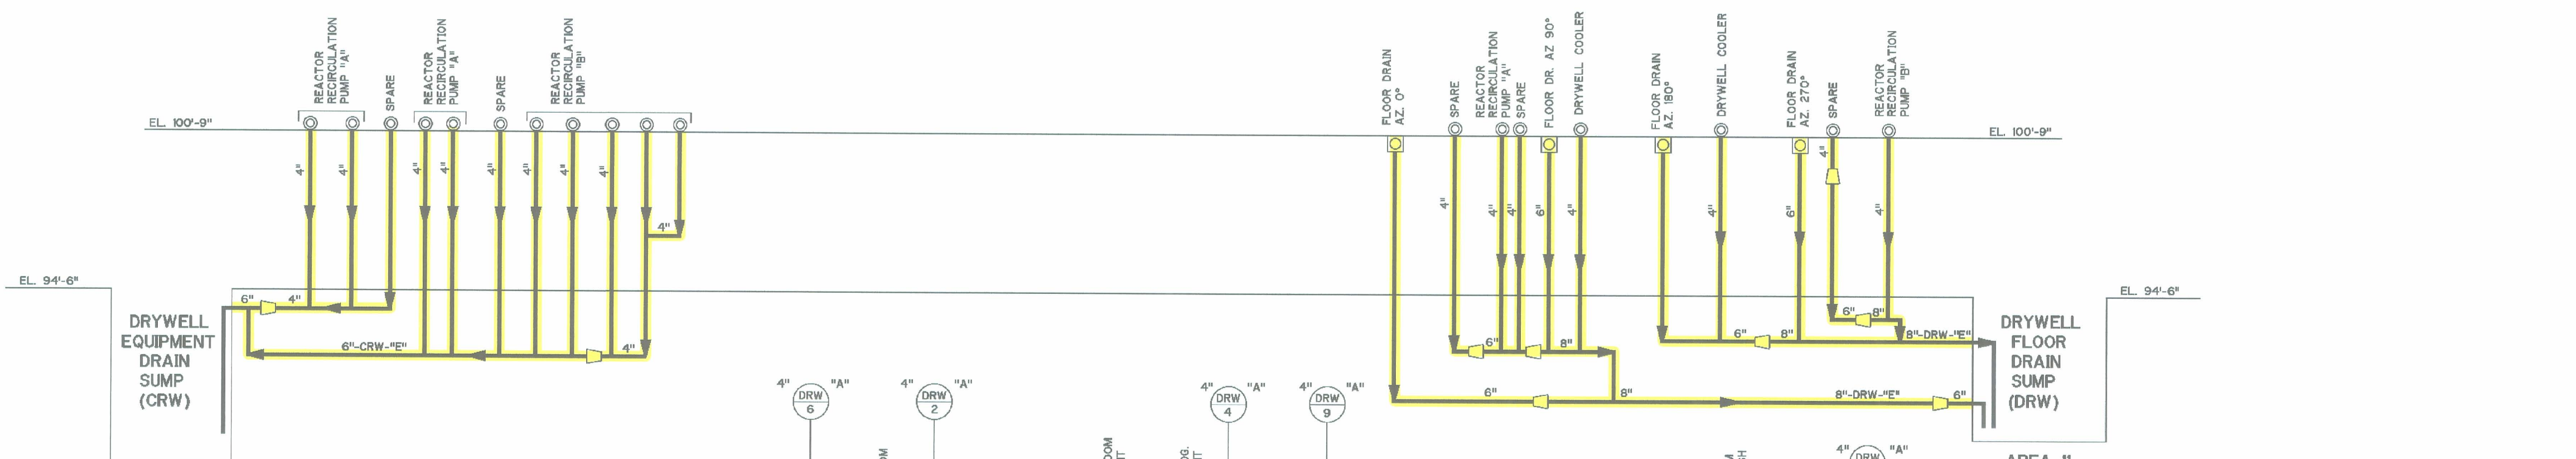

AREA II

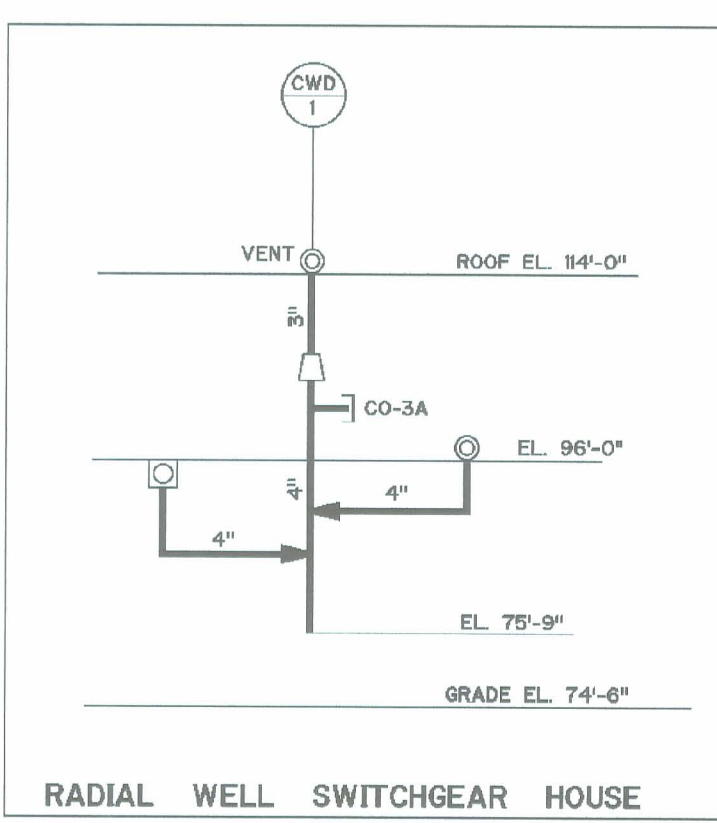

RADIAL WELL SWITCHGEAR HOUSE

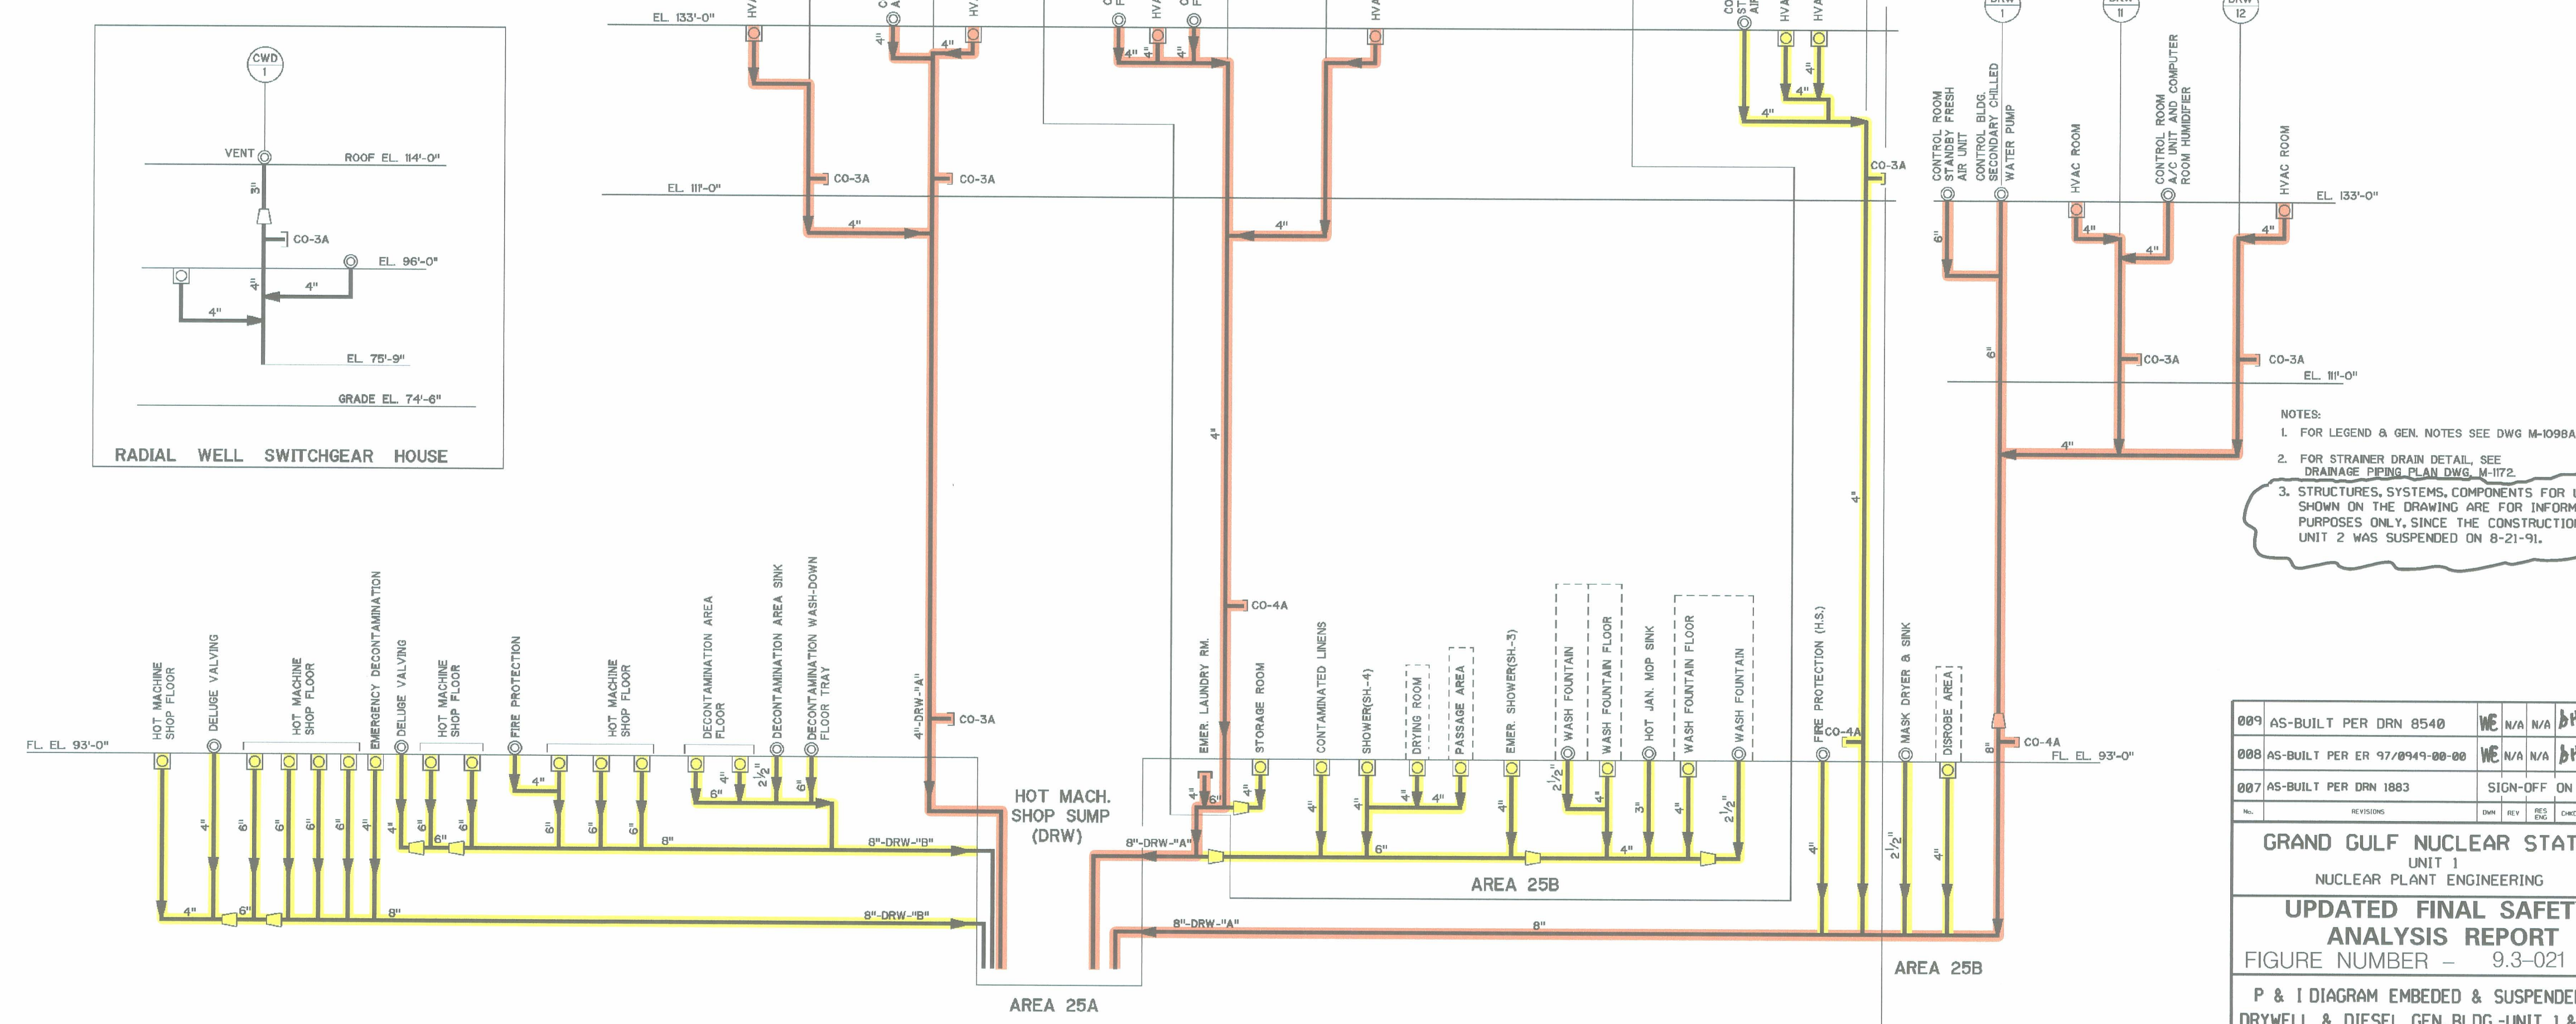

AREA 25A

AREA 25B

AREA 25B

NOTES:  
 1. FOR LEGEND & GEN. NOTES SEE DWG M-1098A  
 2. FOR STRAINER DRAIN DETAIL, SEE DRAINAGE PIPING PLAN DWG. M-1172  
 3. STRUCTURES, SYSTEMS, COMPONENTS FOR UNIT 2 SHOWN ON THE DRAWING ARE FOR INFORMATION PURPOSES ONLY, SINCE THE CONSTRUCTION OF UNIT 2 WAS SUSPENDED ON 8-21-91.

009	AS-BUILT PER DRN 8540	WE	N/A	N/A	BH	10-24
008	AS-BUILT PER ER 97/0949-00-00	WE	N/A	N/A	BH	5-16-02
007	AS-BUILT PER DRN 1883				SIGN-OFF ON RECORD	
GRAND GULF NUCLEAR STATION UNIT 1 NUCLEAR PLANT ENGINEERING UPDATED FINAL SAFETY ANALYSIS REPORT FIGURE NUMBER - 9.3-021						
P & I DIAGRAM EMBEDDED & SUSPENDED DR. DRYWELL & DIESEL GEN. BLDG.-UNIT 1 & CONT. BLDG. & RAD. WELL SWGR. HOUSE-UNIT 1						
SCALE:	NONE	DRAWING No.	M-1098G	REV.	009	

COMPONENTS SUBJECT TO AMR  
 NON-SAFETY RELATED SYSTEMS & COMPONENTS AFFECTING SAFETY RELATED SYSTEMS AM20  
 FLOOR AND EQUIPMENT DRAIN SYSTEM AM30

NO.	DATE	DESCRIPTION	BY	ENG	CHK	APP
REVISIONS						
LRA-M-1098G						
001	10-13-2011					

DOSS