


C-A9-P-0063

- ① STAIRWELL TO ROOF
- ② NON-OPERATIONAL ELEVATORS
- ③ SPRINKLER RISER
- ④ BOILER ROOM FUEL: NAT. GAS
- ⑤ SHADED AREAS - RESTRICTED
- ⑥ HOT CELL - HIGH RADIATION & CONTAMINATION AREA
- ⑦ ISOTOPE SHOP - RADIATION AREA & CONTAMINATION PRESENT
- ⑧ WASTE STORAGE - HIGH RADIATION AREA STORAGE OF RADIOACTIVE WASTE PRIOR TO SHIPMENT.
- ⑨ DEPLETED URANIUM STORAGE AREA
- ⑩ WAREHOUSE - RADIATION AREA. STORAGE & STAGING AREA FOR SEALED SOURCES IN SHIPPING PACKAGES.
- ⑪ STAIRWELLS TO BASEMENT - RESTRICTED AREAS DUE TO RADIATION & CONTAMINATION. RADIOACTIVE WASTE - WASTE STORAGE AREA. NO FLAMMABLE MATERIALS.

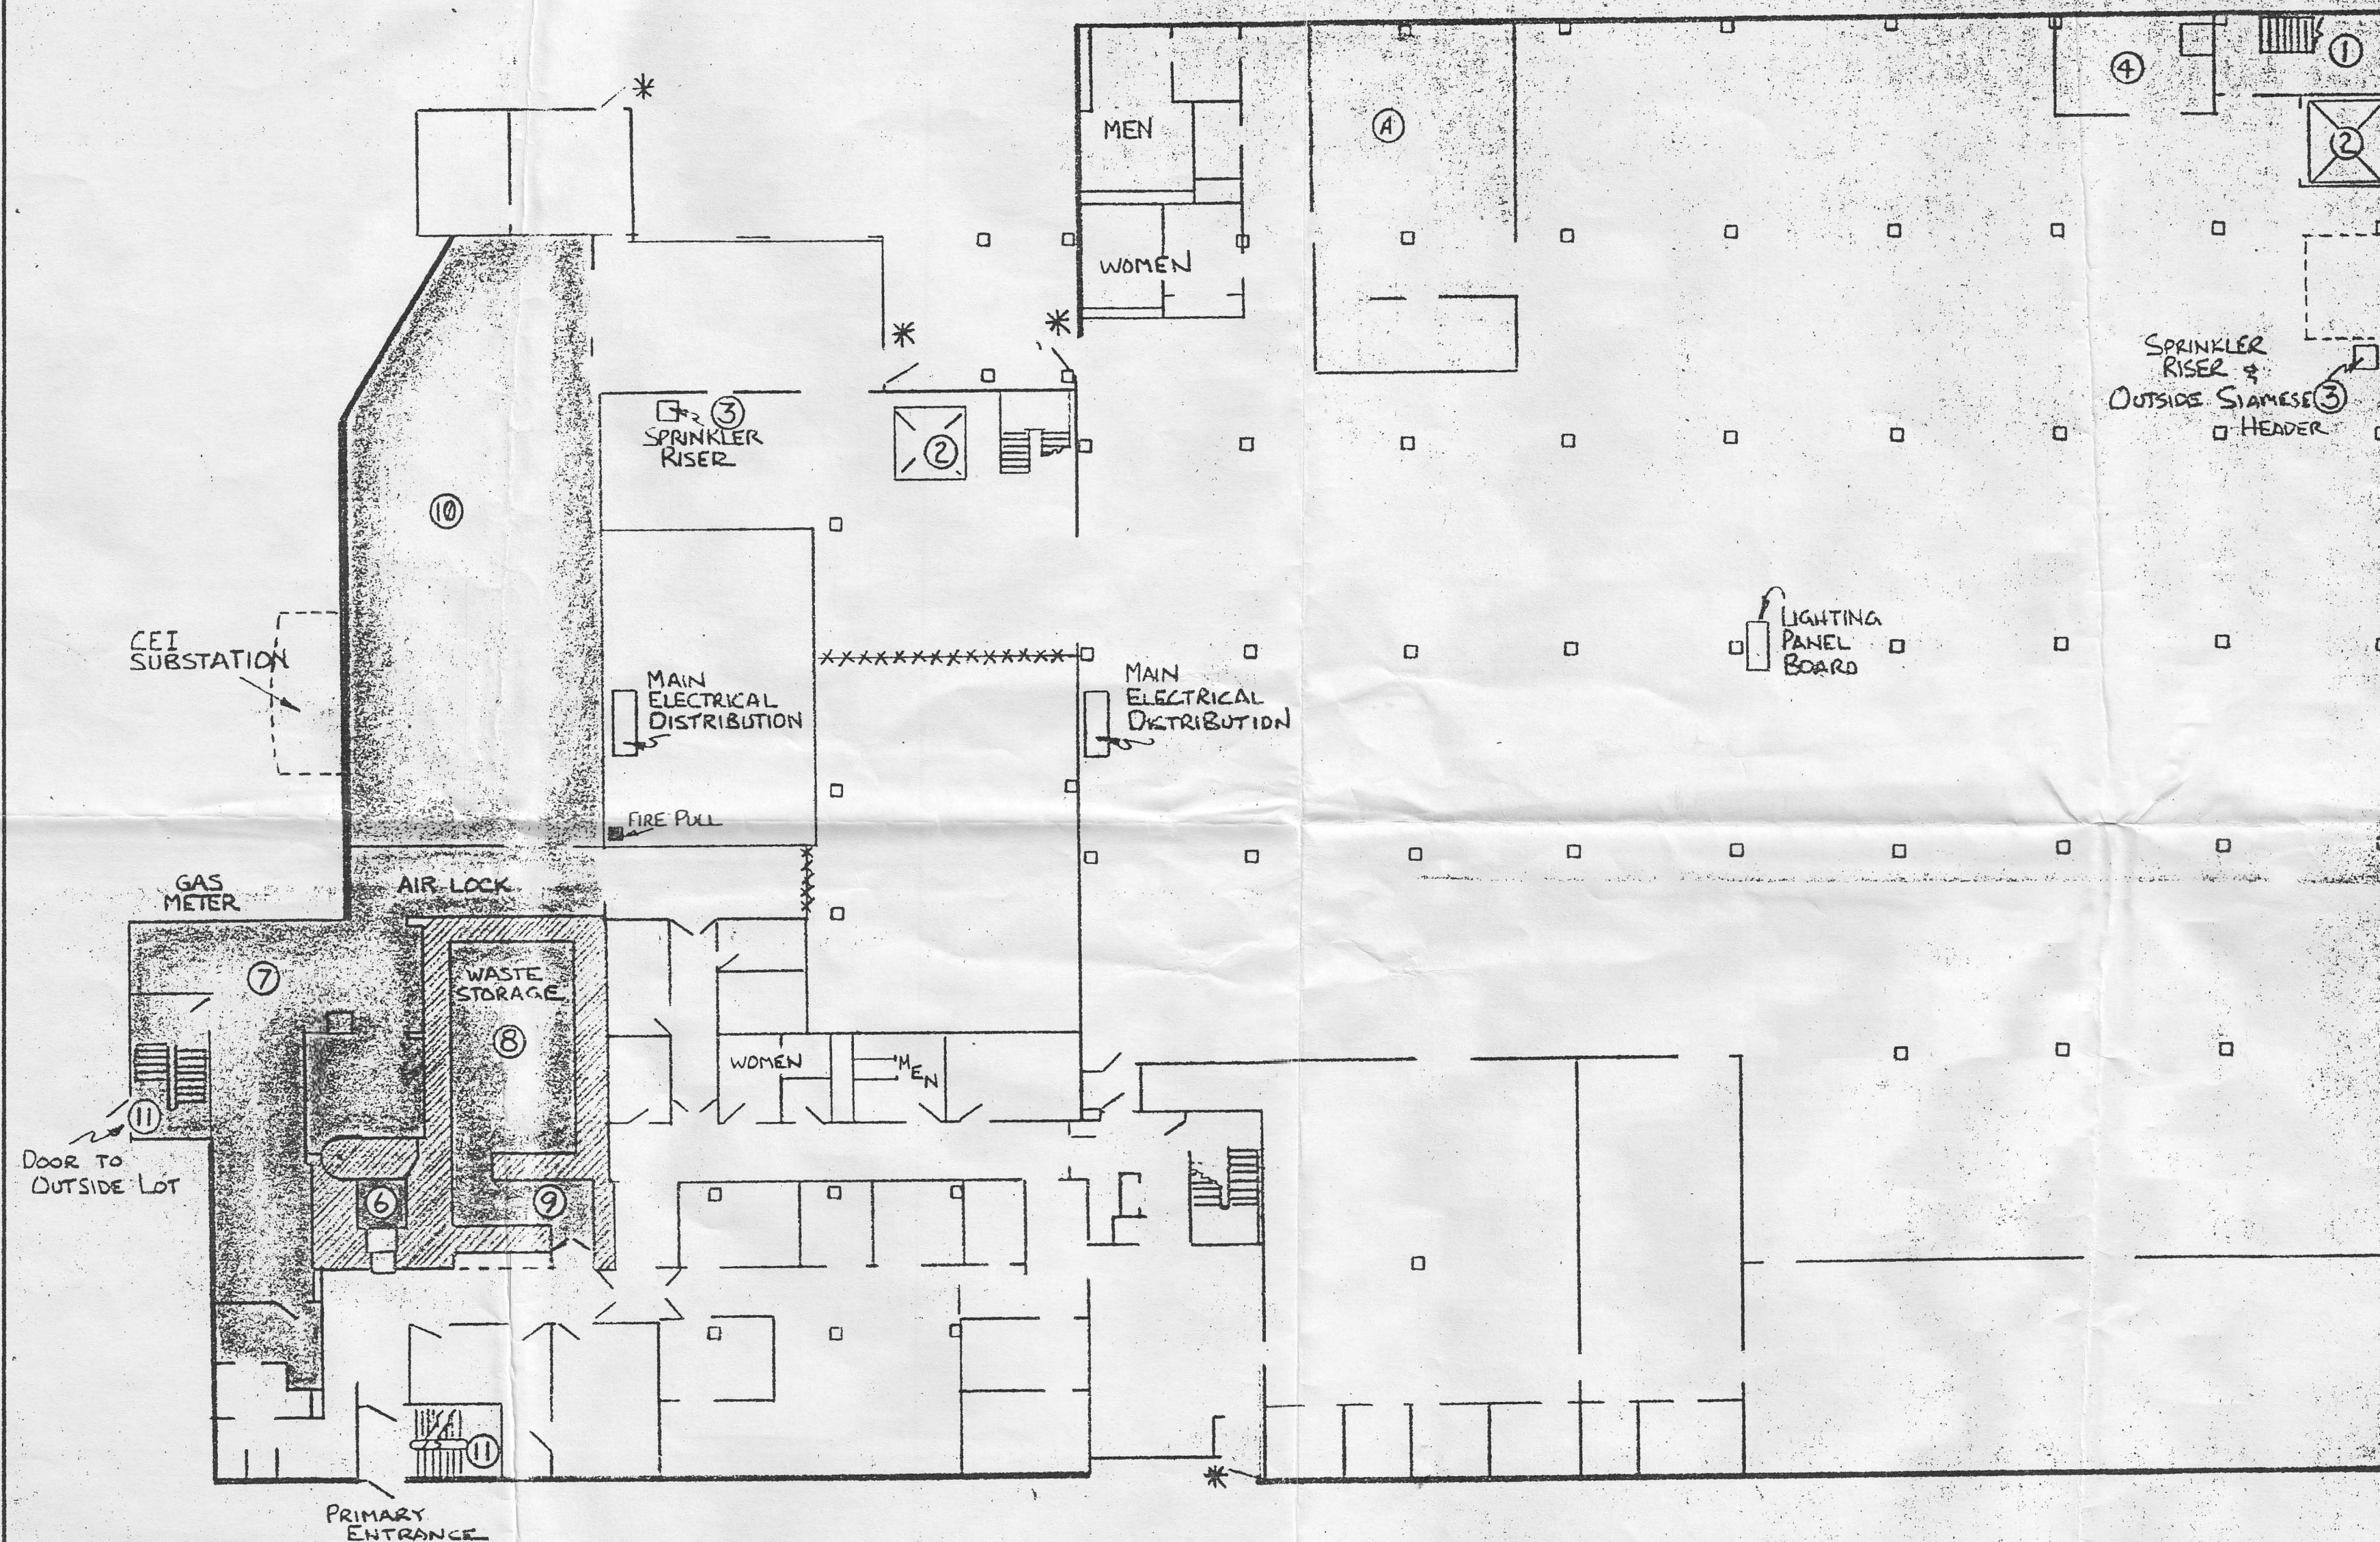

← LONDON ROAD →

* = SECONDARY EXIT/ENTRANCES FOR EMERGENCY USE

01092X

UNLESS NOTED • TOLERANCES ON ANGLES ±		□ BREAK ALL SHARP EDGES	
DECIMALS ±		DIMENSIONS ARE BEFORE APPLYING FINISH	
NEXT ASSY		NAME: LONDON ROAD 1ST FLOOR PRE-EMERGENCY	
		PLAN	
		MATERIAL	
		FINISH	
DRN: [signature]		DATE: 1/24/95	CHKD: HET
APPRVD: [signature]		ESV: 1/20/95	
A - REMOVED AREA 12'		1/24/95	
TR		REVISION	
		DATE	
		ADVANCED MEDICAL SYSTEMS, INC.	
		GE 1A OHIO 44041	
		SCALE 1/8" = 1'-0"	
		C-A9-P 7063	